
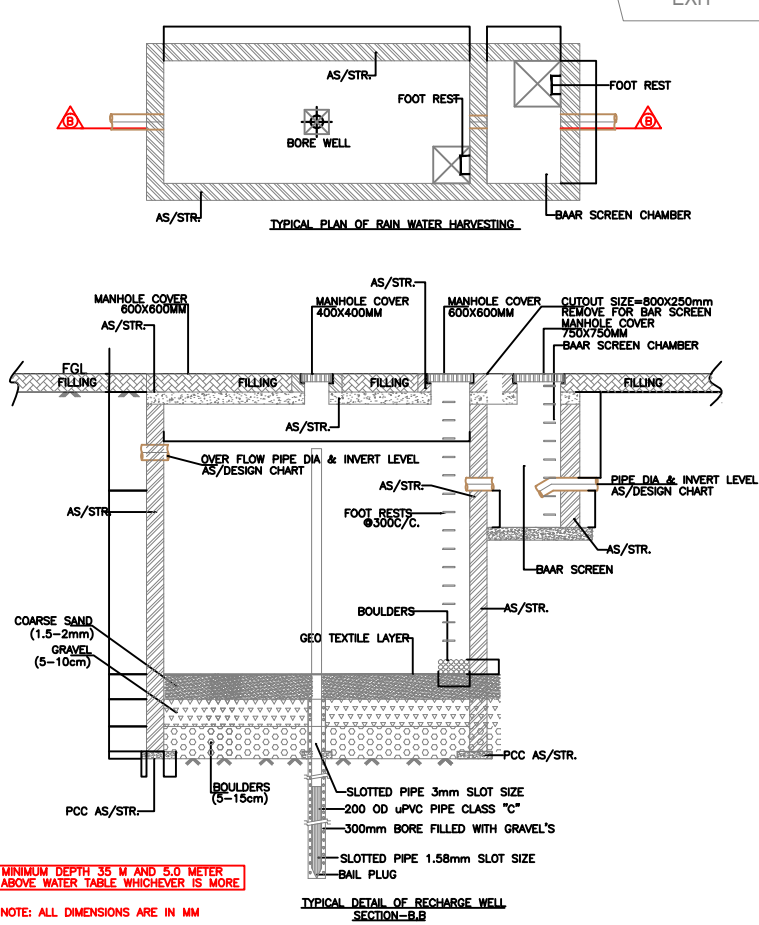


THIS PART OF RAMP
WILL BE IN FILLING

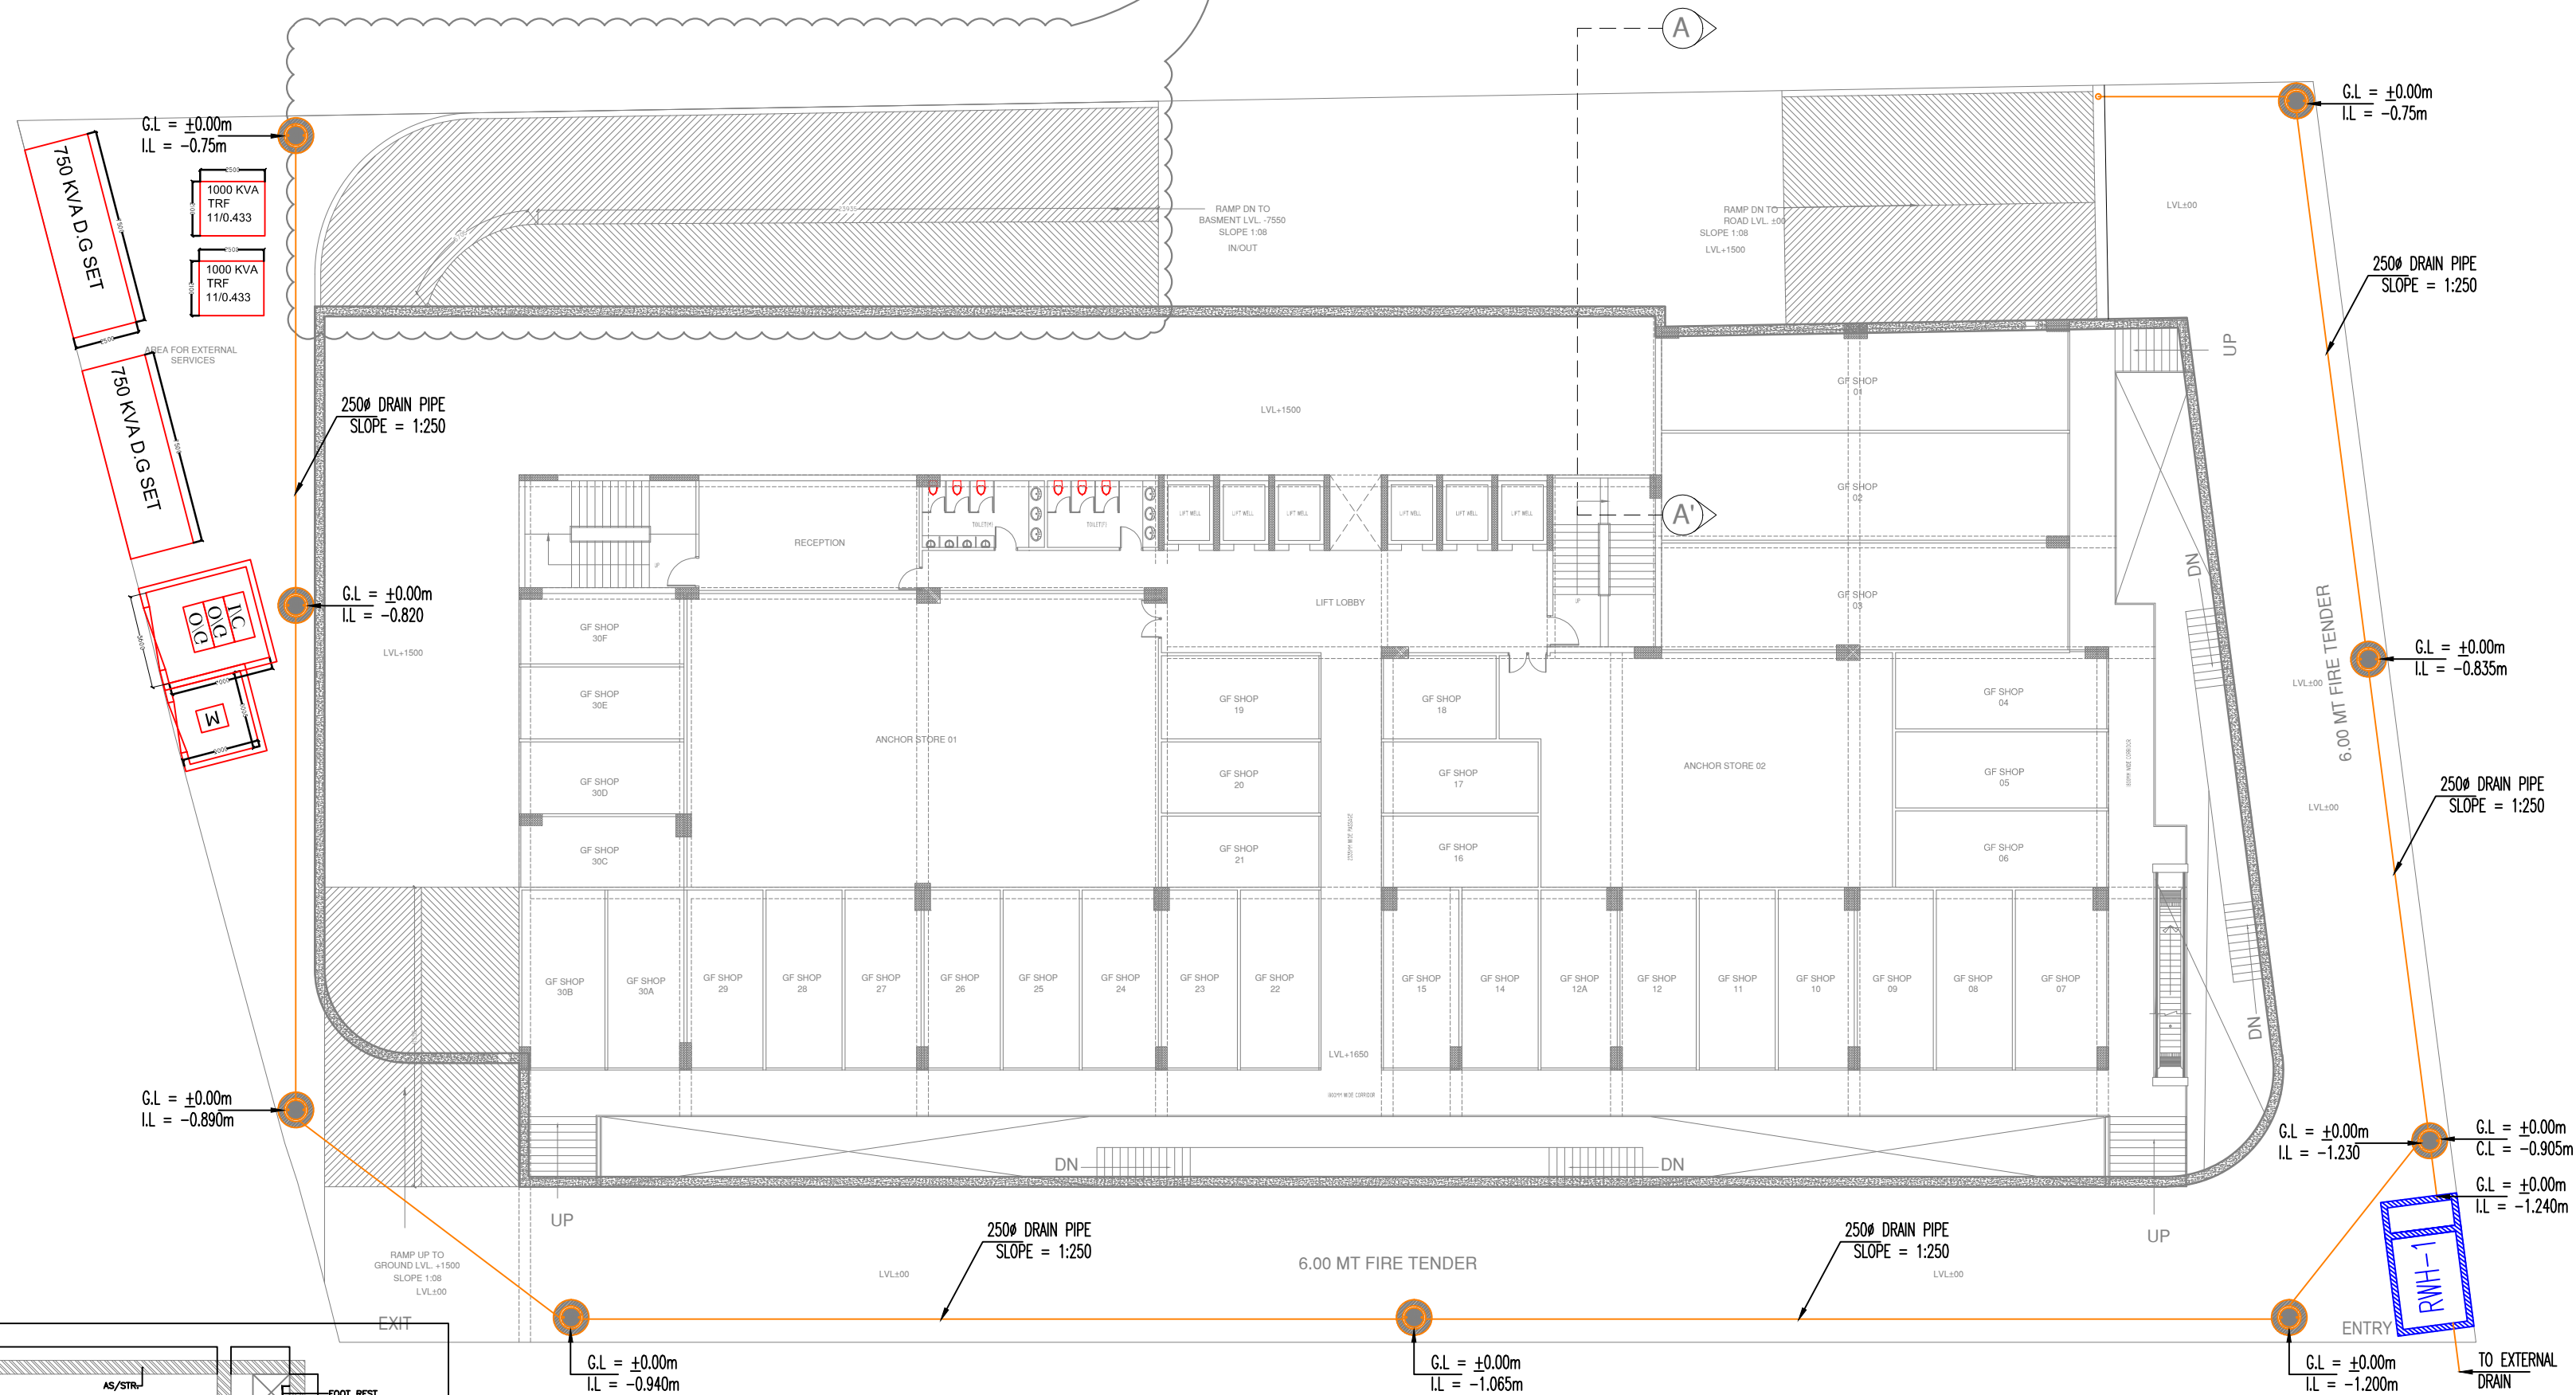

LEGENDS FOR DRAINAGE SYSTEM:-	
	DOMESTIC WATER SUPPLY PIPE
	DOMESTIC WATER SUPPLY PIPE
	DRAINAGE MANHOLE
	RAIN WATER HARVESTING PIT

PROJECT -
PROPOSED HOTEL AT ,KHASRA NO.:
1069(M) VILLAGE - NOORNAGAR
GHAZIABAD (U.P)

OWNER -
FOR M/s.RAJVANSH INFRACON PVT. LTD.

DRAWING TITLE :-
EXTERNAL SERVICES SETTING OUT
PLAN

OWNER SIGN **ARCHITECT SIGN**

ARCHITECTS & PLANNERS:
SINGLA ARCHITECTS & ASSOCIATES
EROS MARKET PLACE, PLOT NO-02, SHOP - 87, 1ST. FLOOR
SHAKTI KHAND - 2, INDIRAPURAM, GHAZIABAD (U.P.)
Mob: 9971998445
e-mail : gsingla32@gmail.com,

MEP Consultant:
WeDESIGN Associates
"Engineered to perfection"
Email : wesignassociates@gmail.com
Mob. - 9999288416, 9999288407, 9882244495

DEALT BY:- VIBHOR	CHECKED BY:- DK	SCALE:- NTS.	DATE:- 14.06.2023	DRG. No.- PL-EXT-01
----------------------	--------------------	-----------------	----------------------	------------------------

GROUND FLOOR PLAN