


PLOT NO. 18

PLOT NO. 20

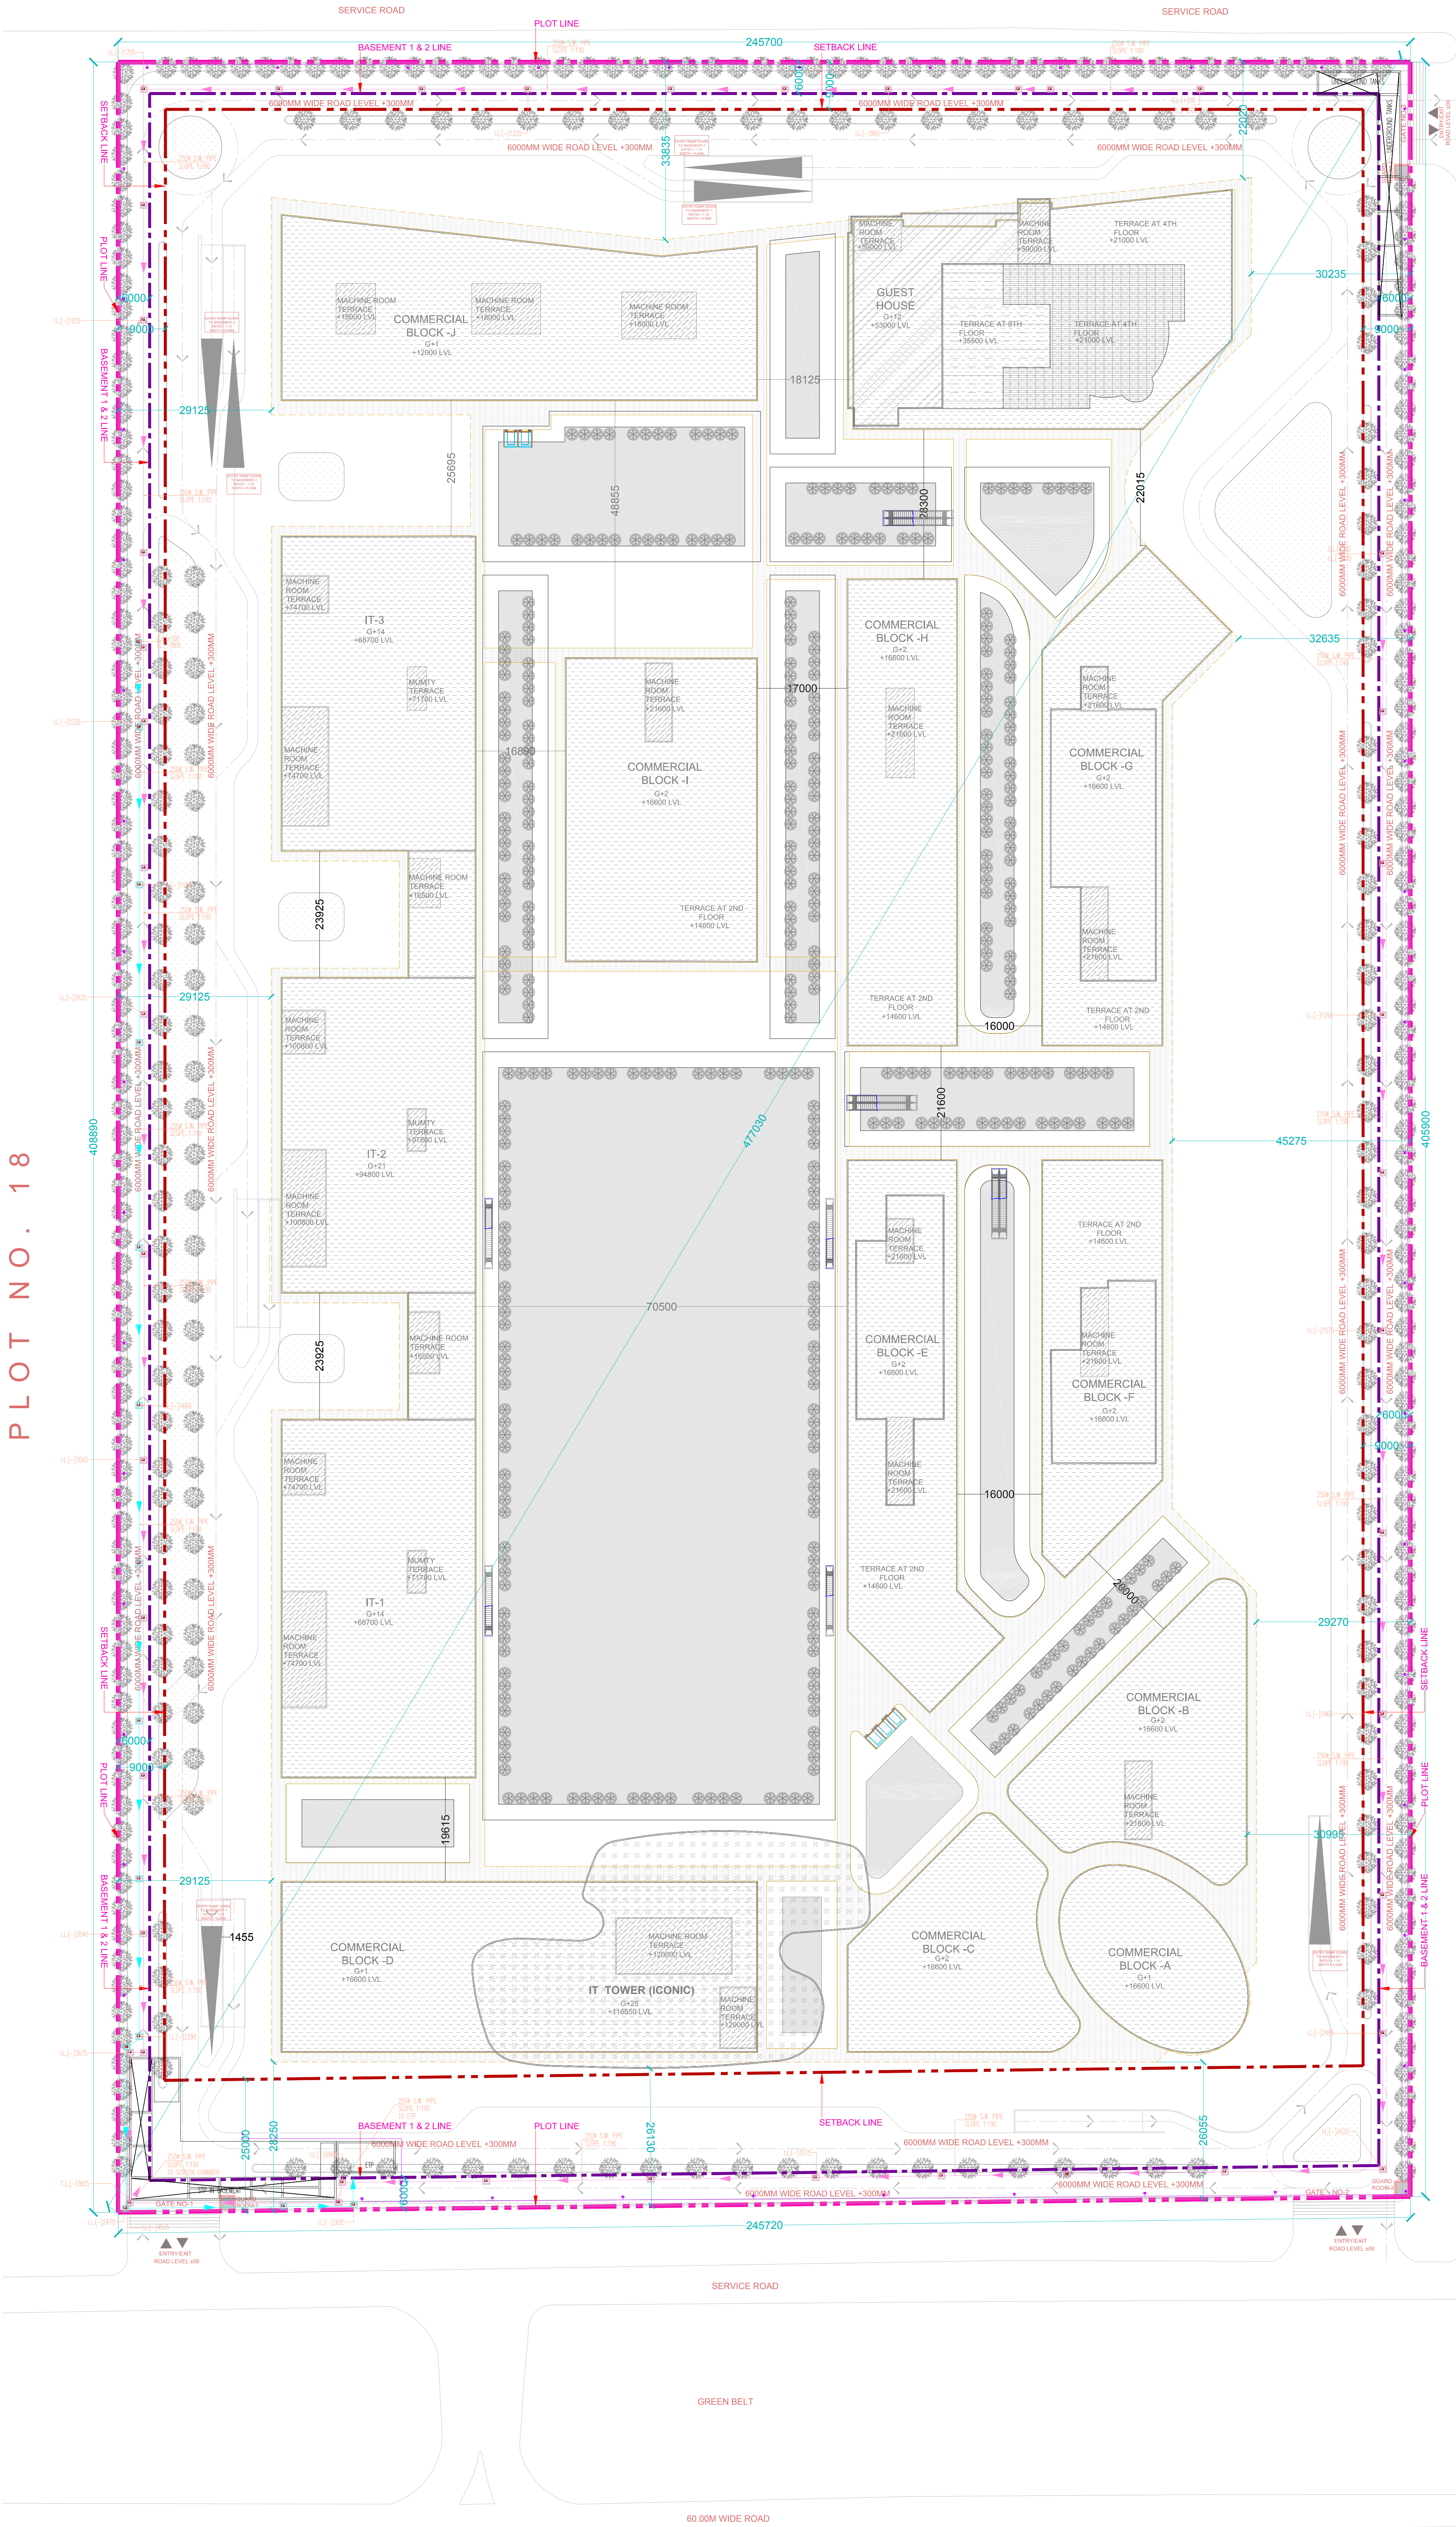

LEGEND:-
SEWERAGE MANHOLE

SUBMISSION DRAWING

PROJECT:
M/s Advance Compusoft Pvt. Ltd.
Plot no. -19, Sector-Techzone - IV,
Greater Noida

DRAWING TITLE:
**SITE PLAN
SEWERAGE LAYOUT**

OWNER'S SIGN

ARCHITECT'S SIGN.

ACPL
ACPL Design Ltd
www.acplnoida.com

ISO 9001:2015
Architecture
Management
Planning

ACPL Design Ltd
E-24, South Extension-II
New Delhi-110048, India
A: +91 11 24627195
R: +91 11 24627195
F: +91 11 24627195

SCALE
1:500

DESIGN BY

DEALT BY

CHECKED BY

DATE - 31.08.21

DRG. No.

PL-01