



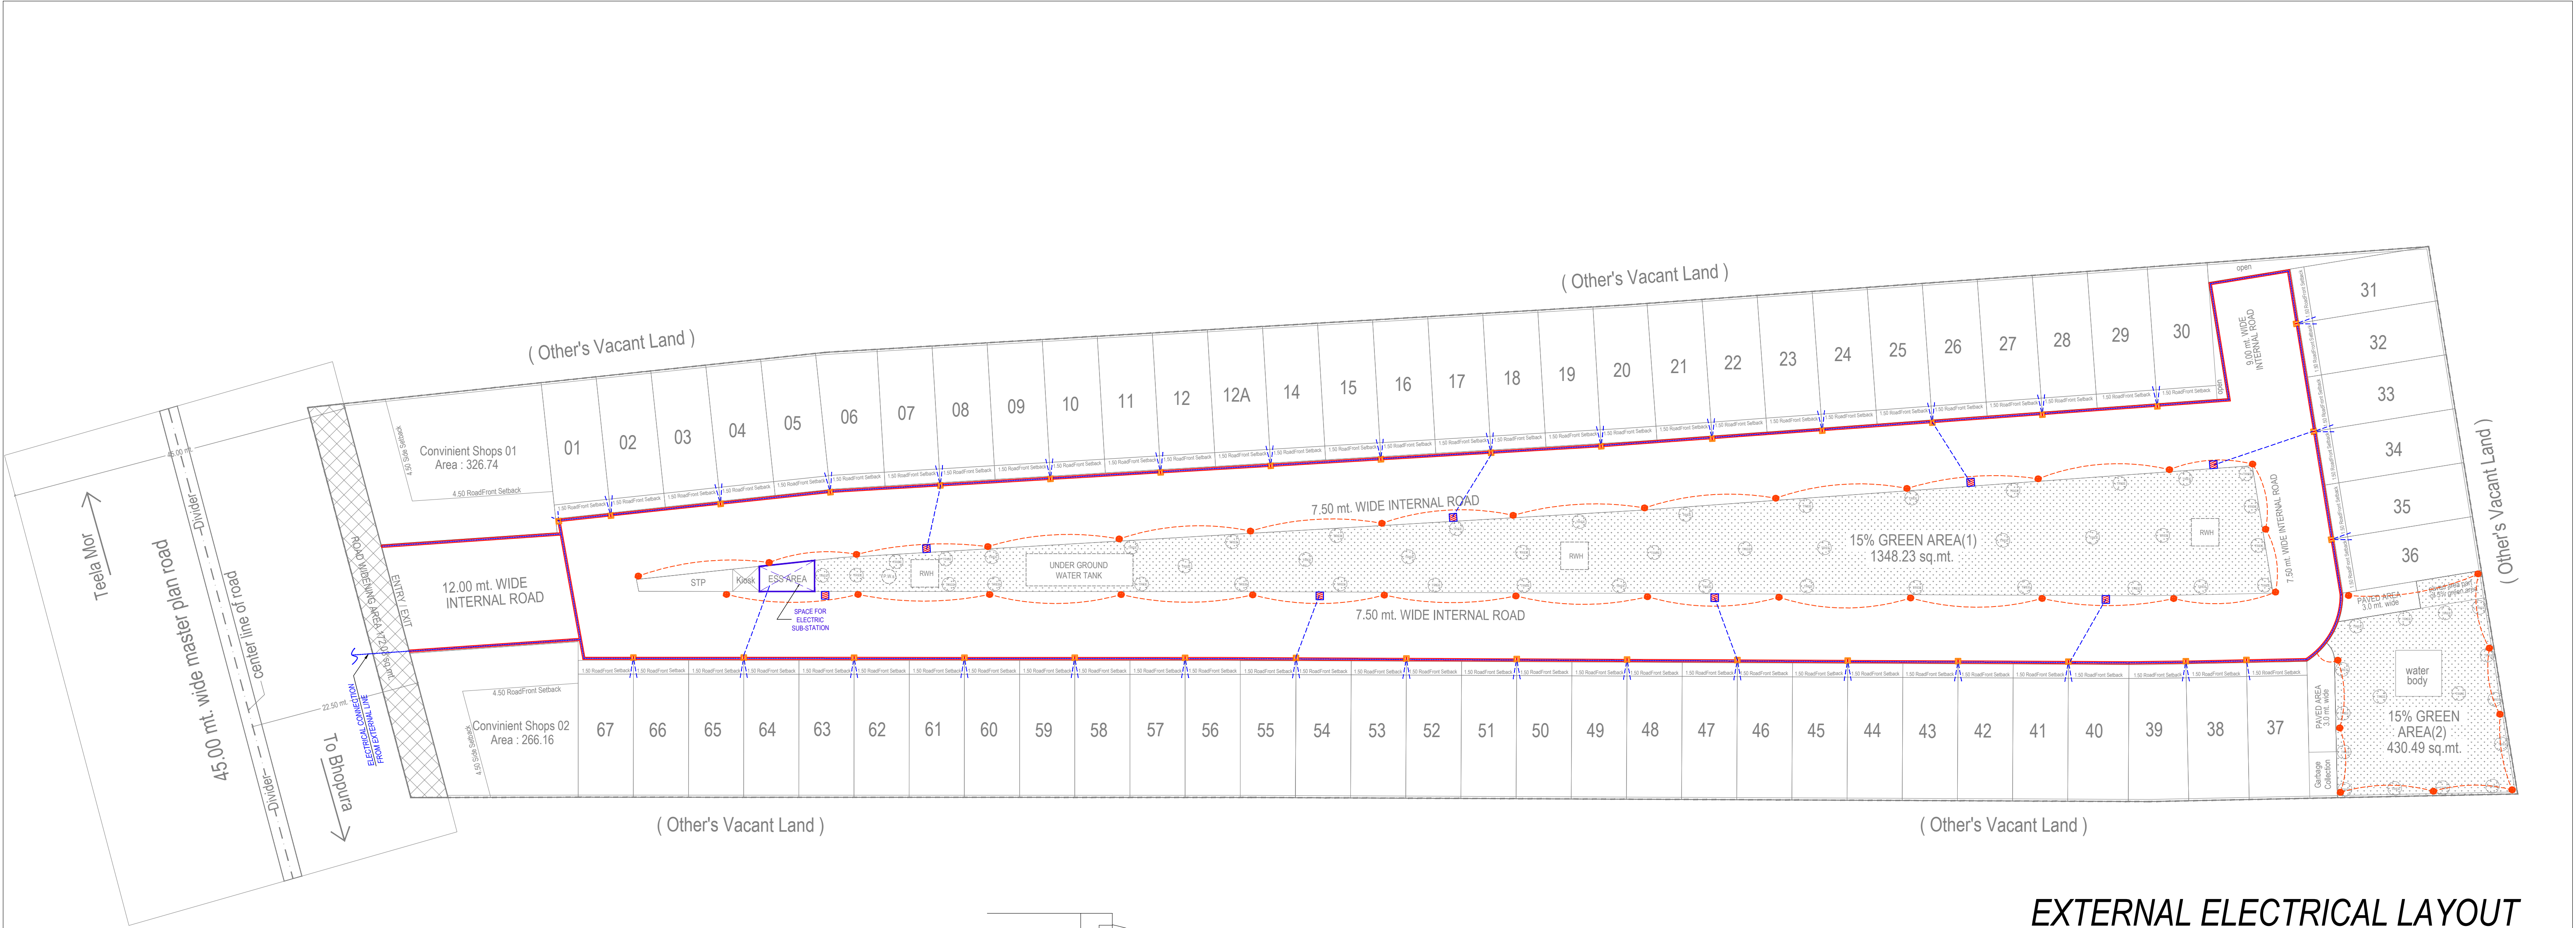

EXTERNAL ELECTRICAL LAYOUT

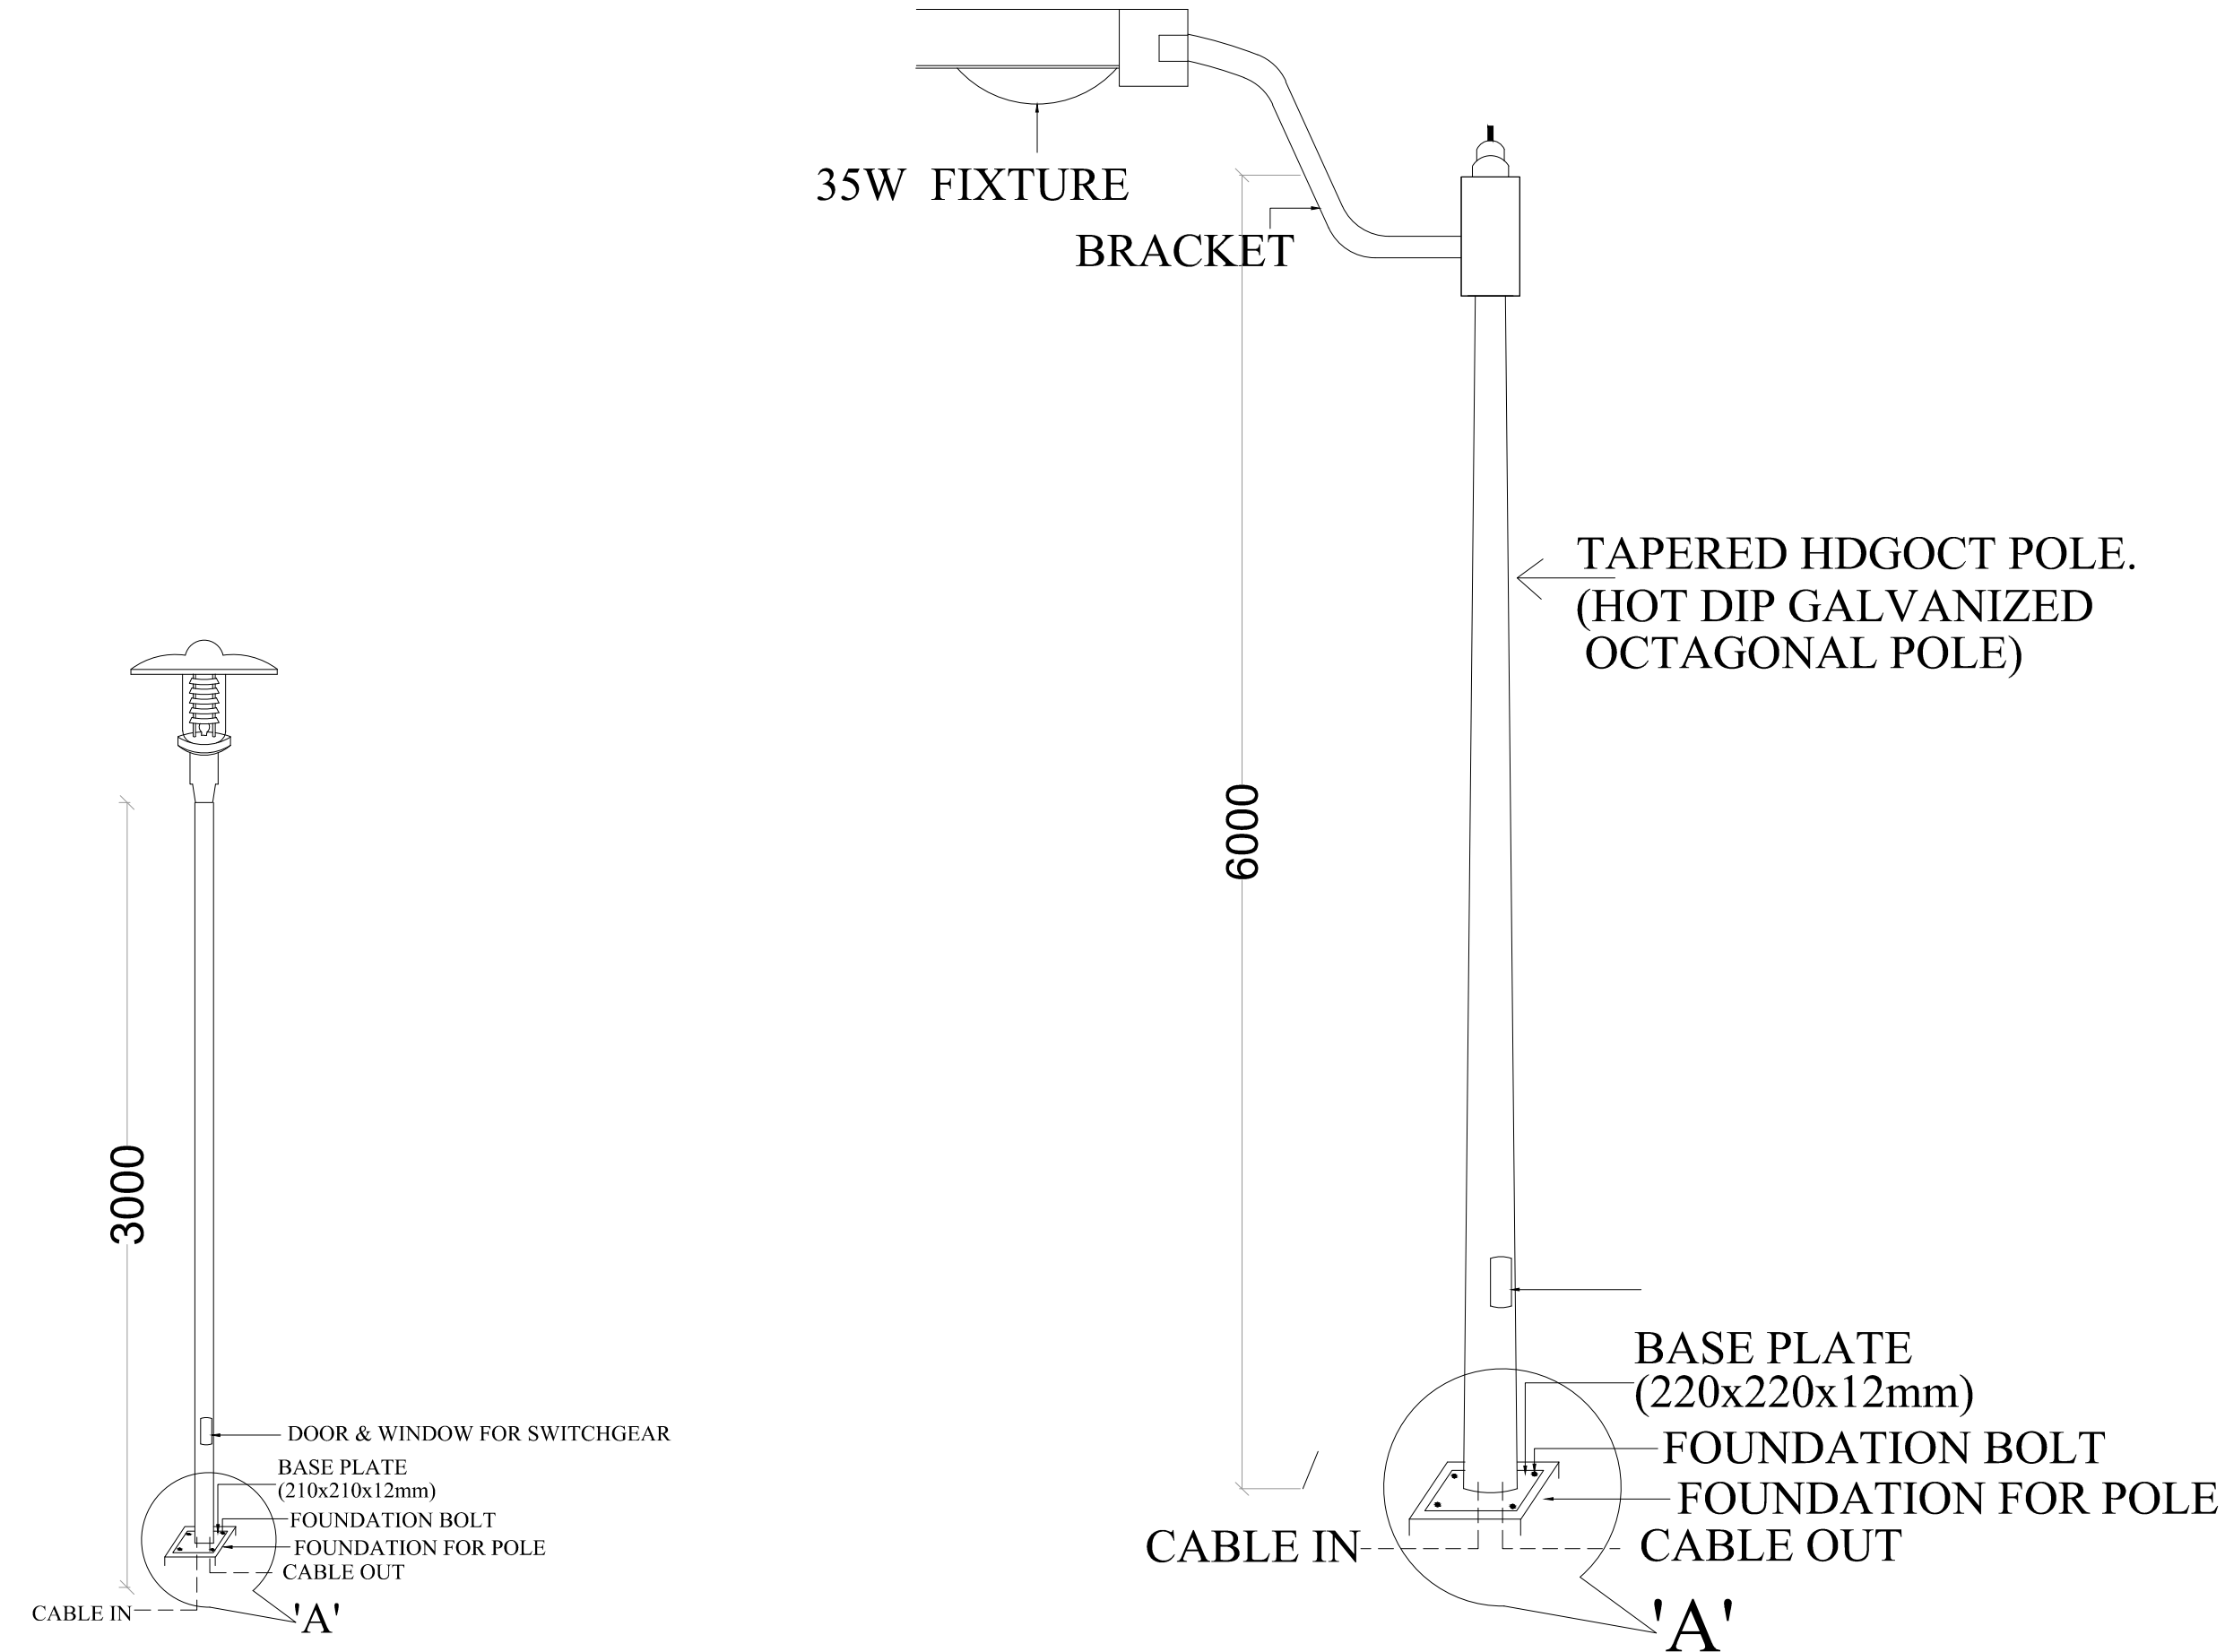

LEGEND:-	
	FEEDER PILLAR
	CABLE TRENCH
	UNDER GROUND CABLE
	ELECTRICAL MAN HOLE
	PEDESTRIAN LIGHT

PROJECT

PROPOSED AFFORDABLE HOUSING LAYOUT PLAN
KHASRA NO :- 606m VILLAGE TILA SAHBAJPUR ,
PARGANA LONI, GHAZIABAD (U.P.)

OWNER

M/s. - PRITHVILINK DEVELOPER'S PRIVATE LIMITED
Through :- Mr. - AMARDEEP DALAL

DRAWING TITLE

EXTERNAL ELECTRICAL LAYOUT

ARCHITECT

ANUJ AGARWAL ARCHITECTS
OFFICE:- A-244 KAUSHAMBI GHAZIABAD (U.P.)
Ph:-0120 - 4165716 , 4563716 , 6454182
e-mail : arch.anujagarwal@gmail.com

DEALT BY:-

Ar.Talib

CHECKED BY:-

Ar.Anuj Agarwal

DATE:-

30-08-2023

DRG. No.:-

DW-05

