



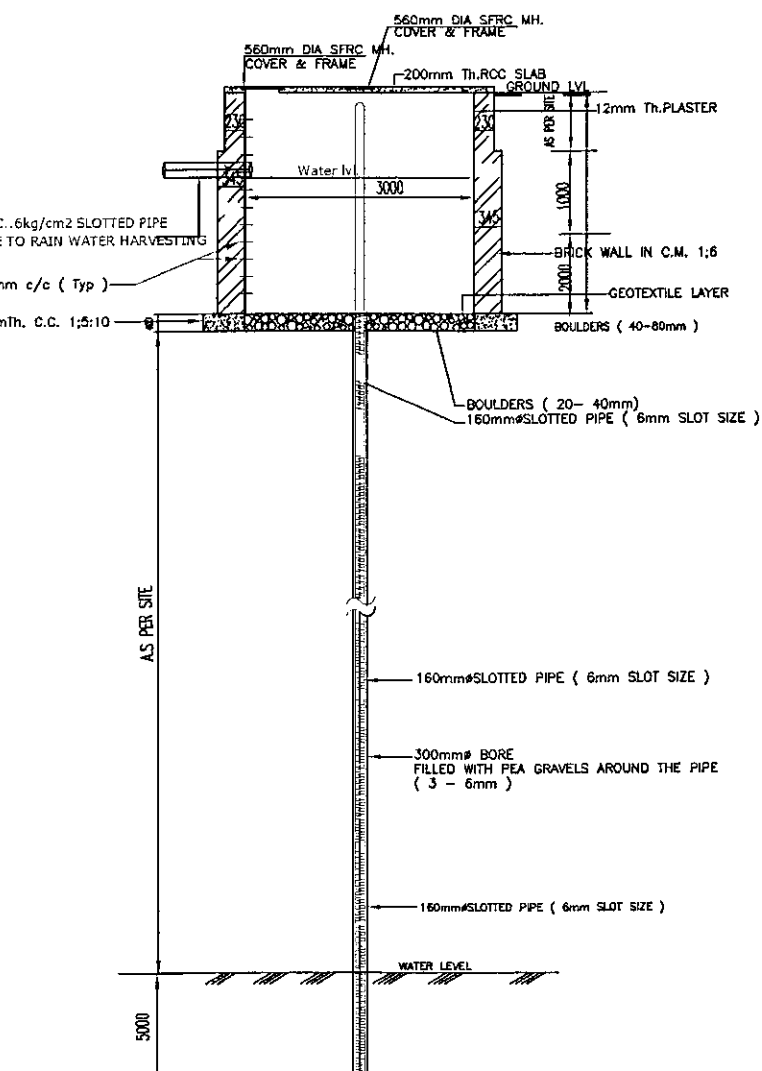


SECTION-R.R.
160mm dia. P.V.C. SLOTTED PIPE (6mm SLOT SIZE)

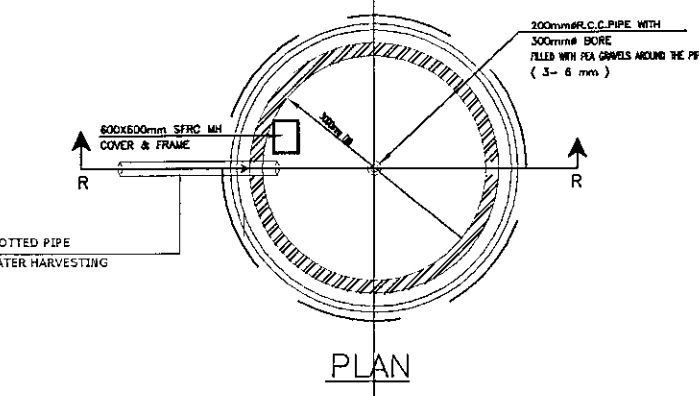

PLAN

RAIN WATER HARVESTING (RECHARGE SHAFT)
3000mm dia & 3000mm DEEP (EFFECTIVE DEPTH)

- INSTITUTIONAL FACILITIES**
1. waiting and transit areas
 2. area designated for public utilities
 3. travel services
 4. telephone exchange
 5. electric sub station
 6. water works
 7. export related facilities
 8. canteen / restaurant
 9. creche & day care centre
 10. operation and maintenance by specialized agencies
 11. training centre and library
 12. health club and gym for users / residents for i.t. industries and i.t. enabled services
 13. games / entertainment room for users / residents for i.t. industries and i.t. enabled services
 14. banking and financial services
 15. business and financial services
 16. business centre/ conference facilities
 17. shops
 18. open eating kiosks
- commercial use**
1. shops
 2. areas for storage, display and sale of merchandise
 3. cinemas halls
 4. hotels
 5. restaurants
 6. Open eating kiosks
- residential use**
1. residential uses
 2. hostels
 3. guest houses
 4. staff Quarter

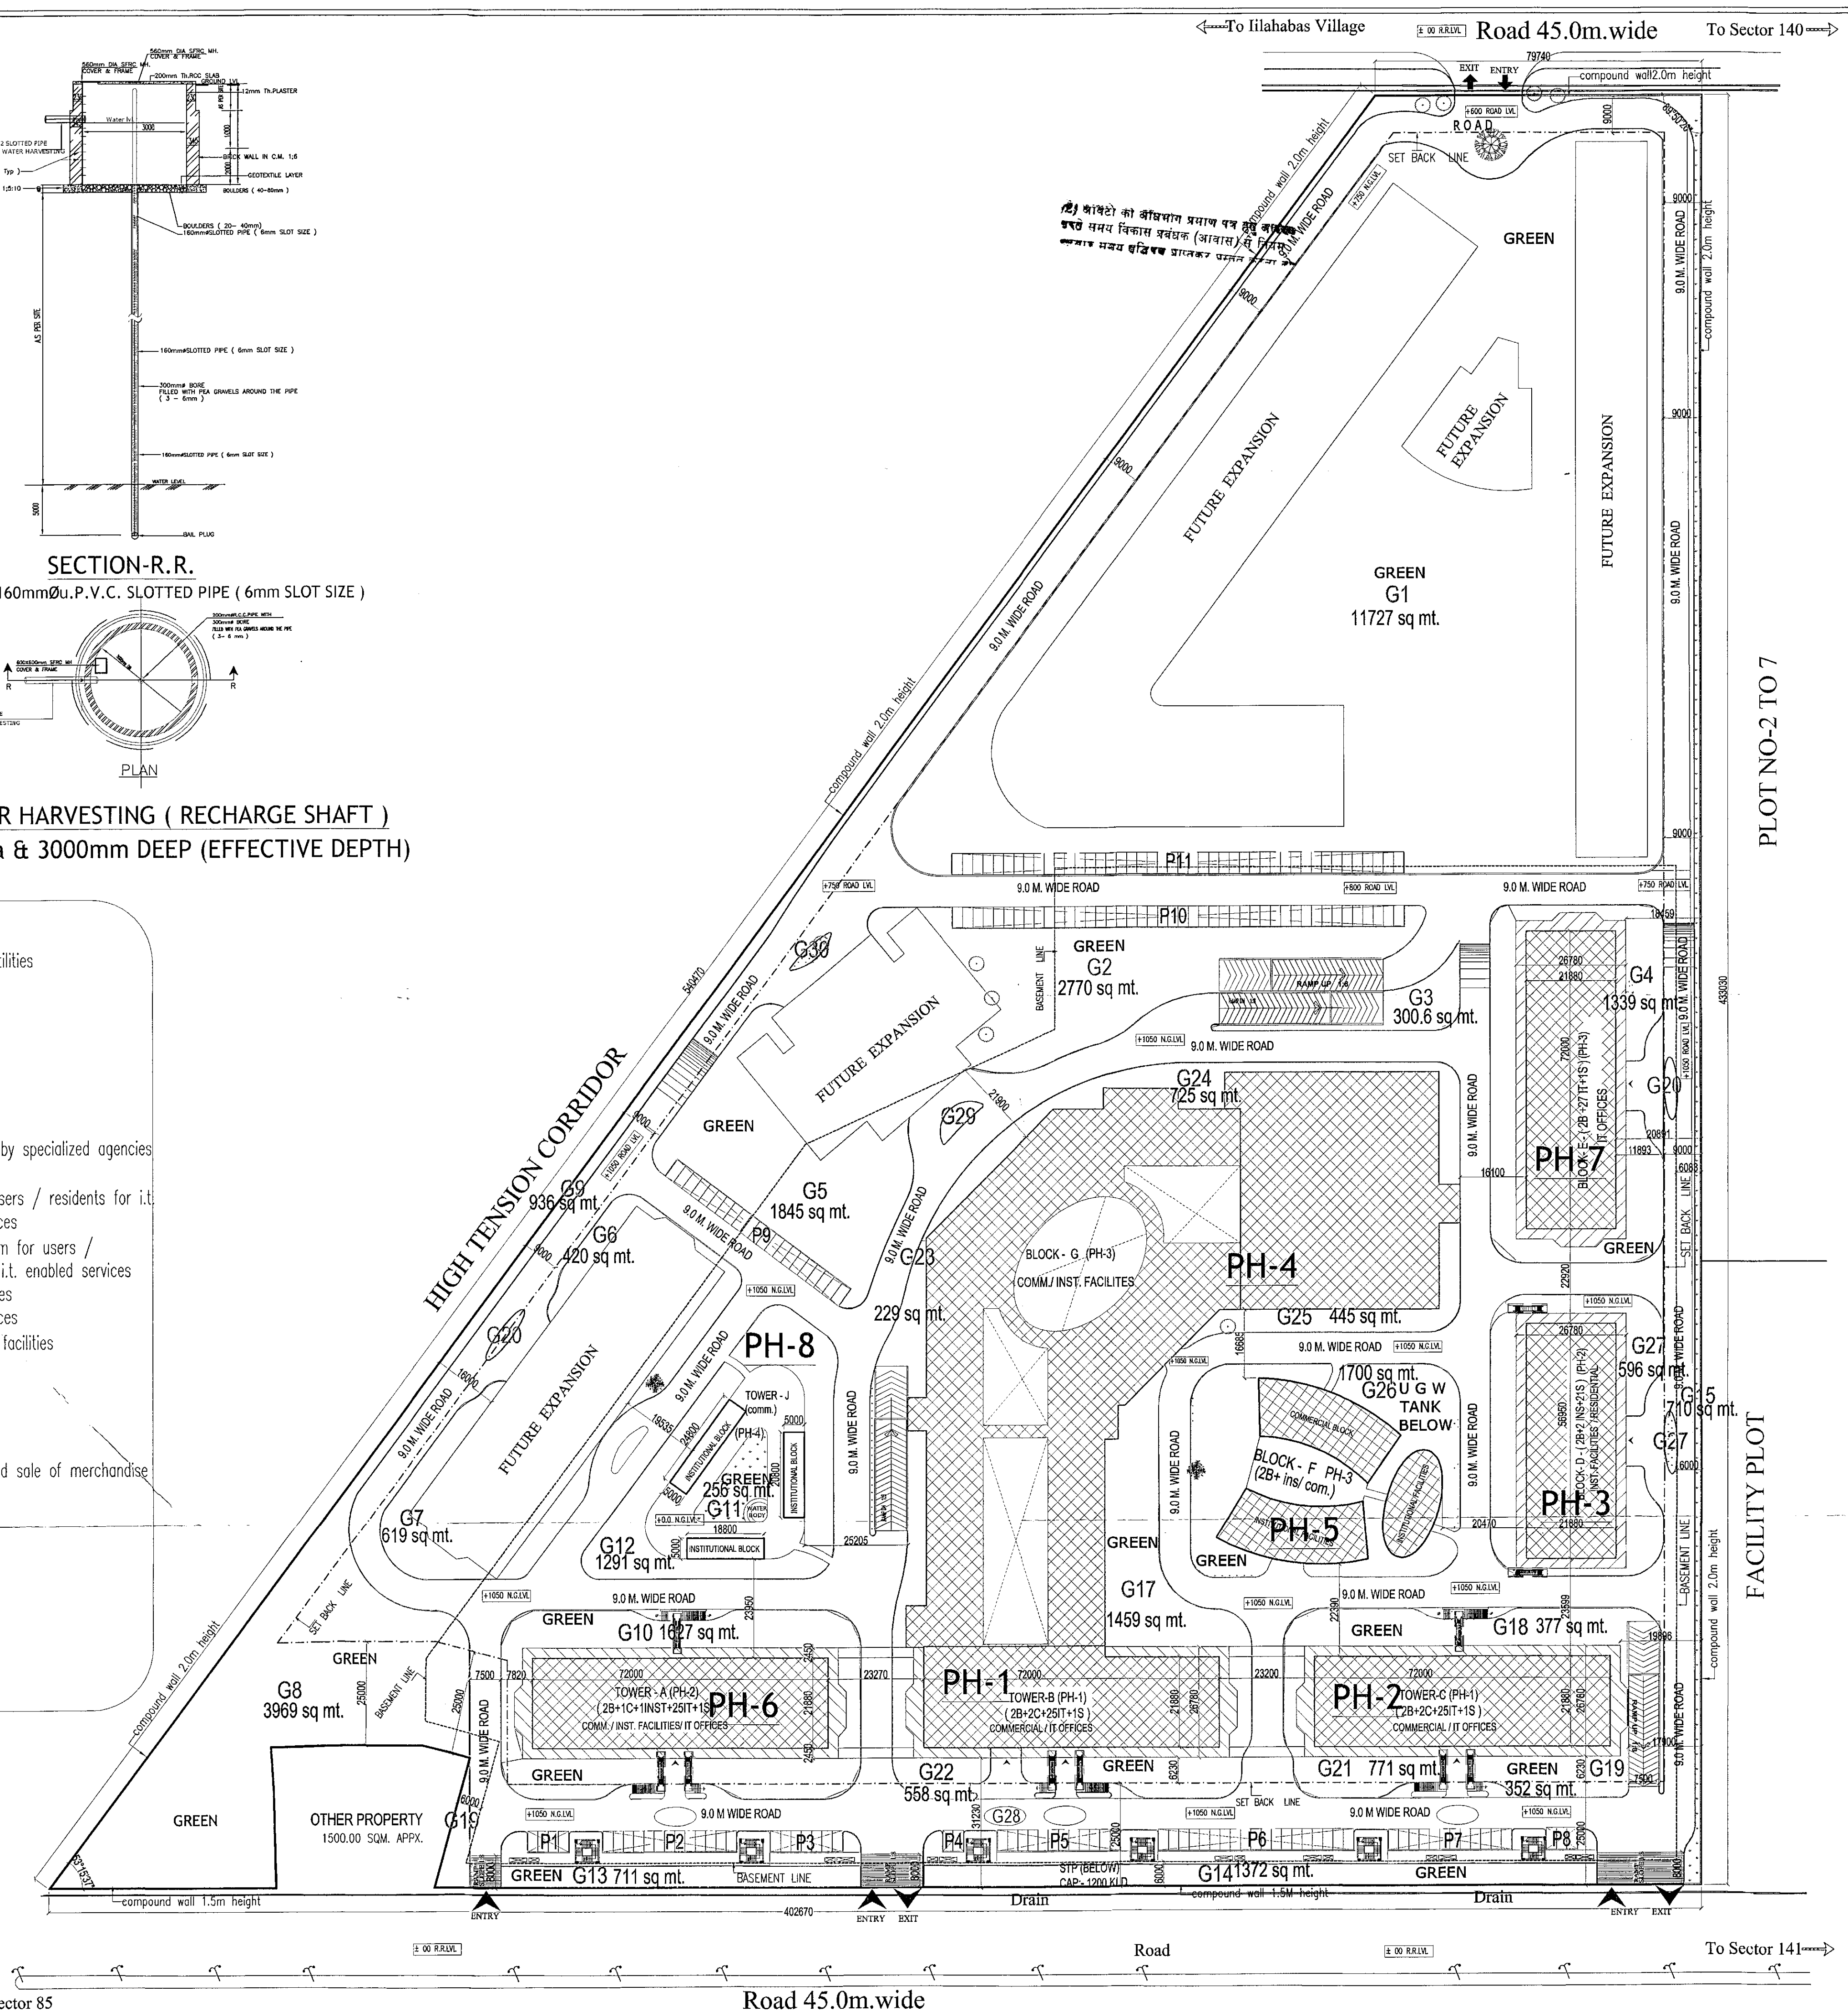

SCHEDULE OF DEVELOPMENT

PHASE 1 - TOWER B	PHASE 2 - TOWER C
PHASE 3 - TOWER D	PHASE 4 - TOWER G
PHASE 5 - TOWER F	PHASE 6 - TOWER A
PHASE 7 - TOWER E	PHASE 8 - TOWER J

भवन प्रकल्प
नियम-अनुश्रुति, 2014
प्रकल्प की शर्तों के अनुसार
करने हेतु प्रस्तावित है।
यह प्रकल्प नियमित रूप से
चलाया जाएगा।
दिनांक: 10/03/2017

भवन प्रकल्प
नियम-अनुश्रुति, 2014
प्रकल्प की शर्तों के अनुसार
करने हेतु प्रस्तावित है।
यह प्रकल्प नियमित रूप से
चलाया जाएगा।
दिनांक: 10/03/2017

CBS International Projects Pvt. Ltd.

Owner Sign

ARCHITECT
02/03/13250

Architect Sign

SUBMISSION DRAWING

Title:-
SITE PLAN

Project:-
NOIDA WORLD ONE
Plot No. 1, Sector- 90,
Expressway, Noida.

Client:-
CBS INTERNATIONAL PROJECTS Pvt. Ltd.
Plot No. - 1, Sector-90, Noida Expressway, Noida. Tel:- 882909090
Email: info@cbshinternational.net - Website: www.noidaworldone.com

Architects:-
SPACE COMBINE
(An ISO 9001:2000 Certified)
Architects, Engineers, Planners
project management consult.
A1/112 SAFDARJUNG ENCLAVE,
NEW DELHI -110029
PH : 011-46150000
E-mail: spacecombine
@rediffmail.com

Drawing released for:-
☐ APPROVAL ☒ SUBMISSION
☐ ADVANCE COPY ☐ CONSTRUCTION

drg. no.:

scale: 1:500 date: MAY 2017

drawn by: ckd by: