




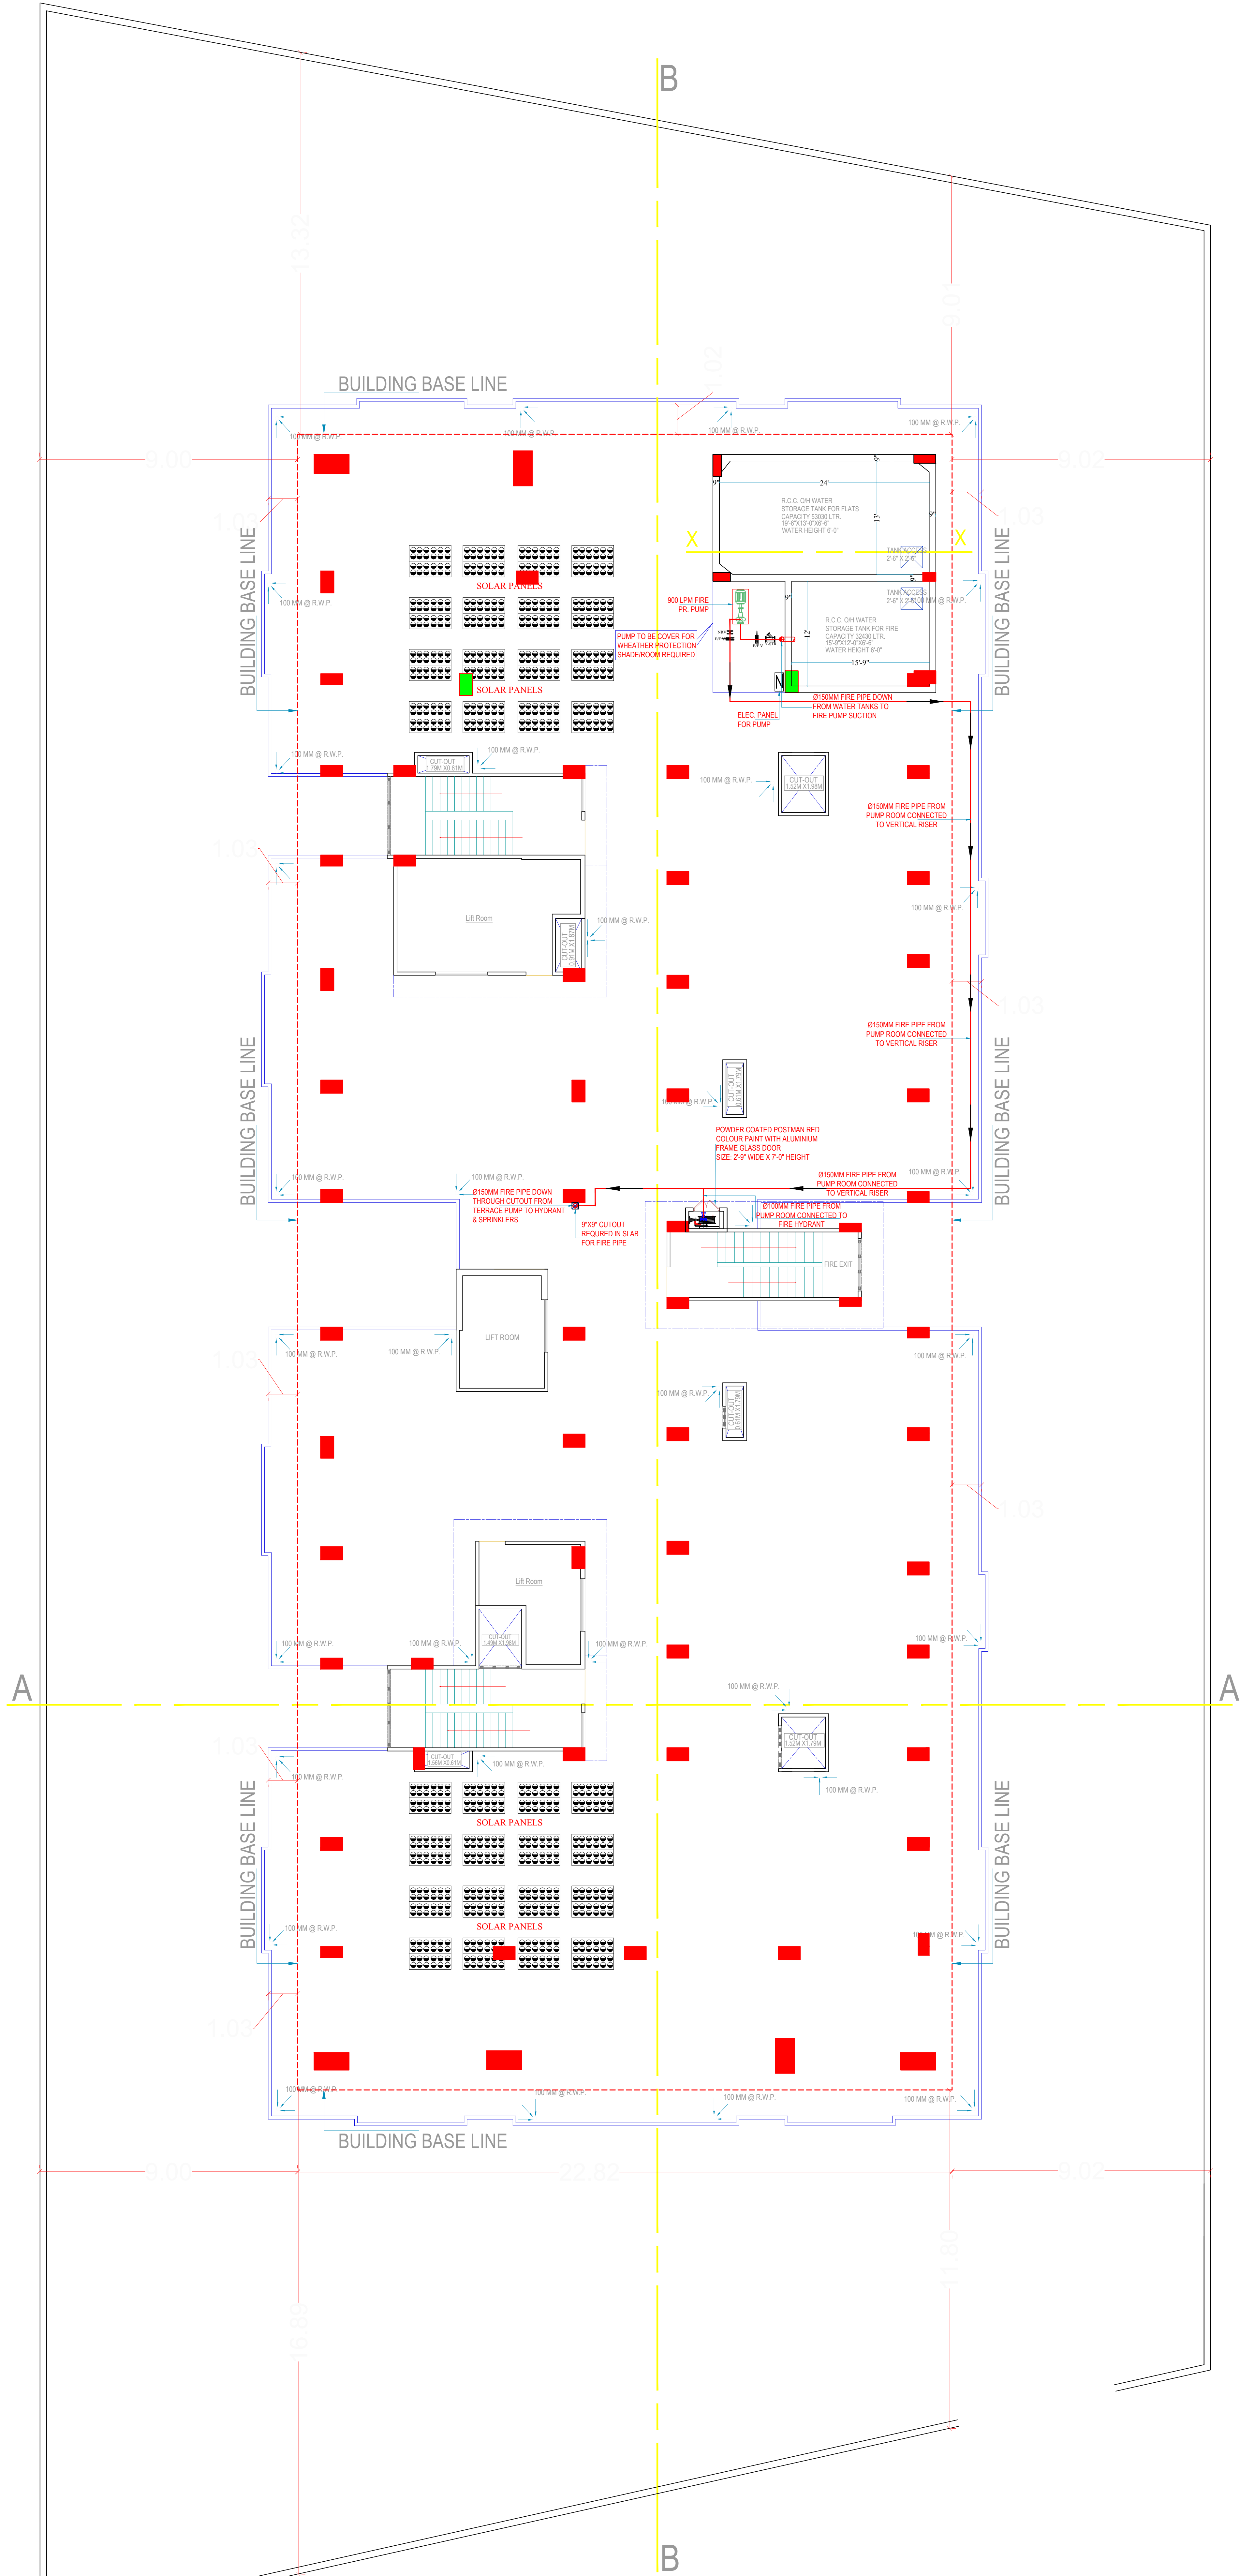

TITLE :-
TERRACE FLOOR PLANS

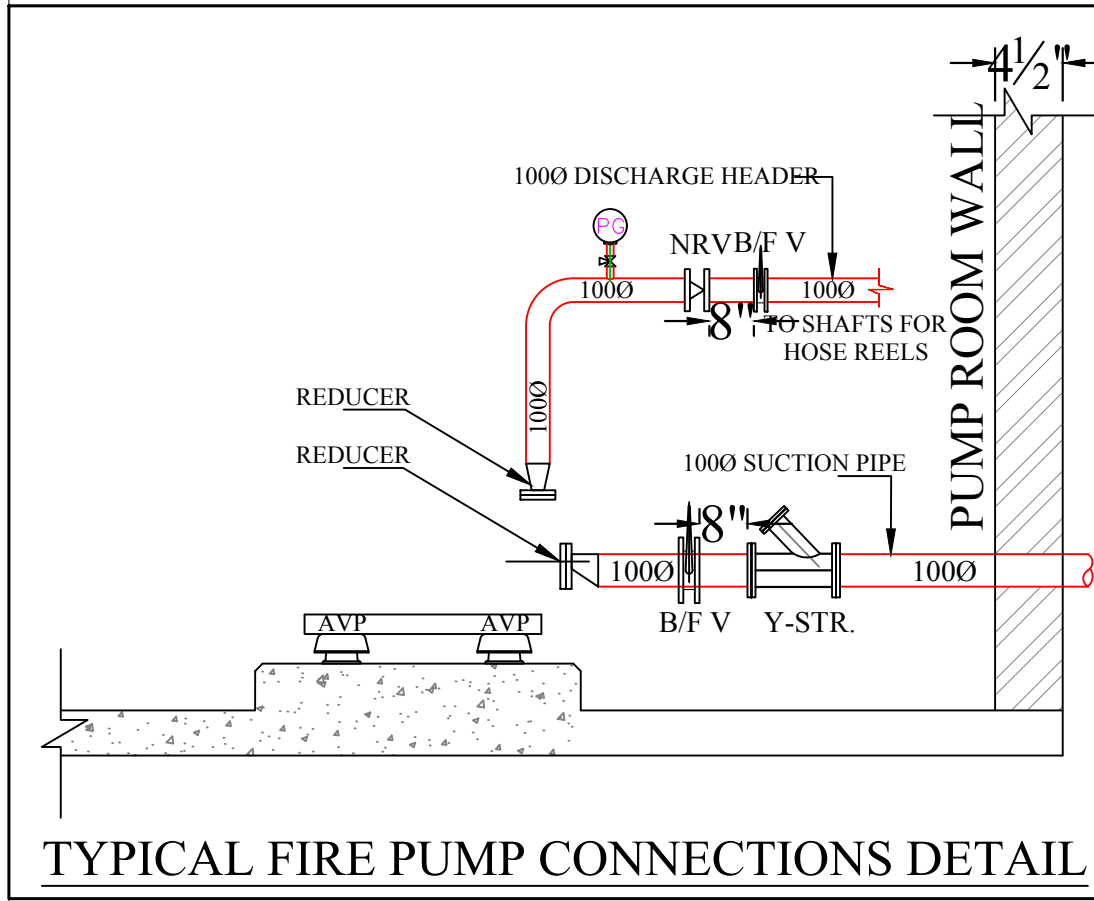

LEGEND - FIRE		
S.NO.	SYMBOL	DESCRIPTION OF ITEM
1		FIRE PIPE
2		FIRE HOSE CABINET

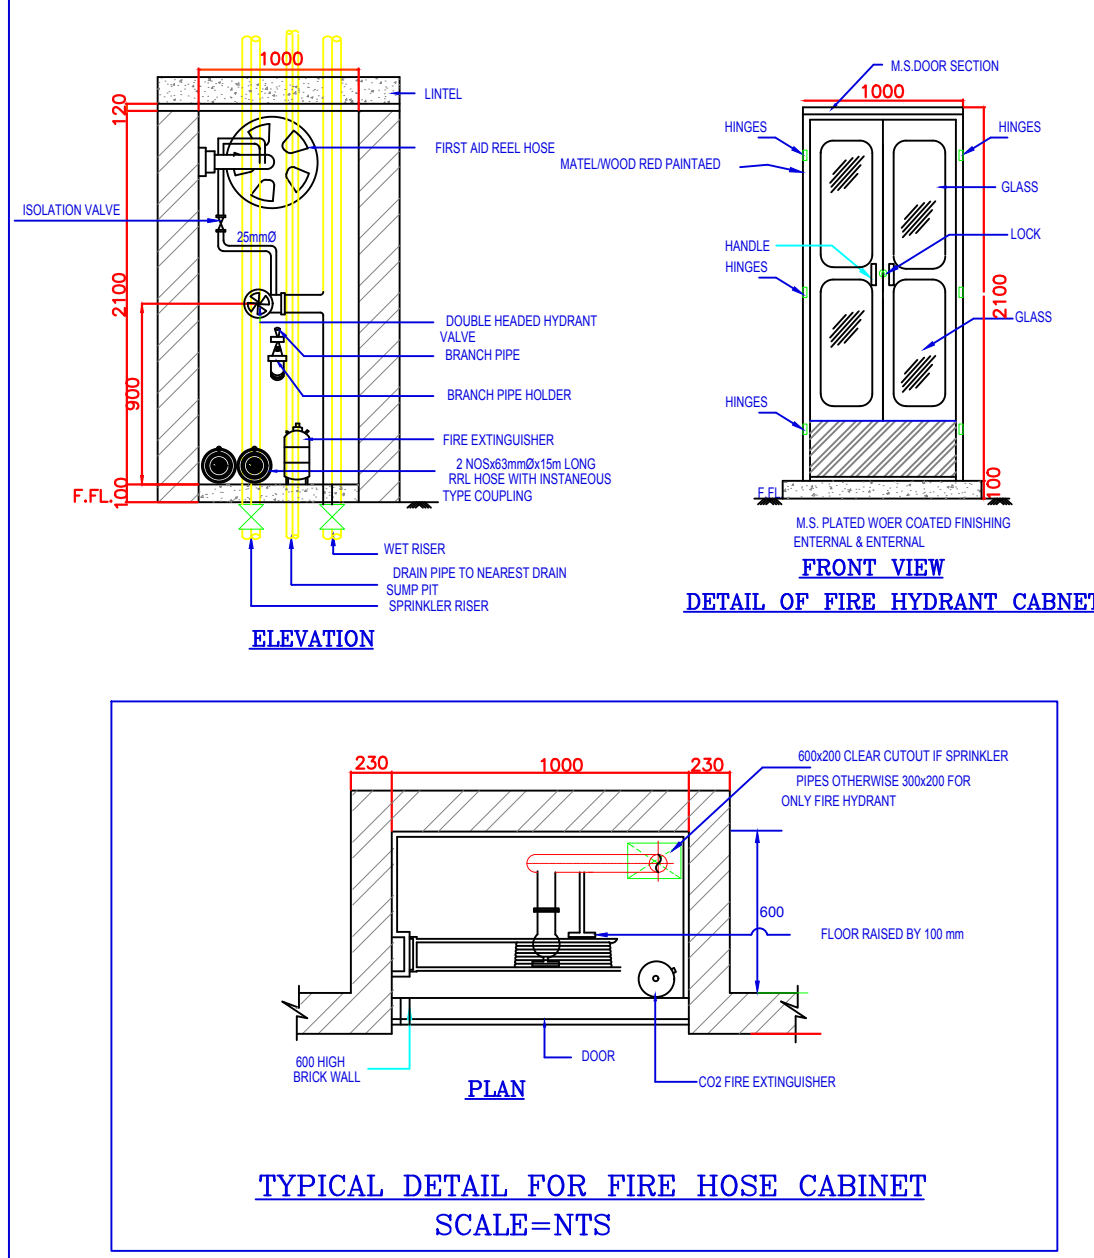

TITLE:-
TERRACE FLOOR FIRE
FIGHTING LAYOUT

SCALE:- NTS	DATE :-
CLIENT:-	
PROJECT:-	
DRAWING NO	
149	
ARCHITECTS:-	
OWNER	
ARCHITECTS	

TERRACE FLOOR PLAN