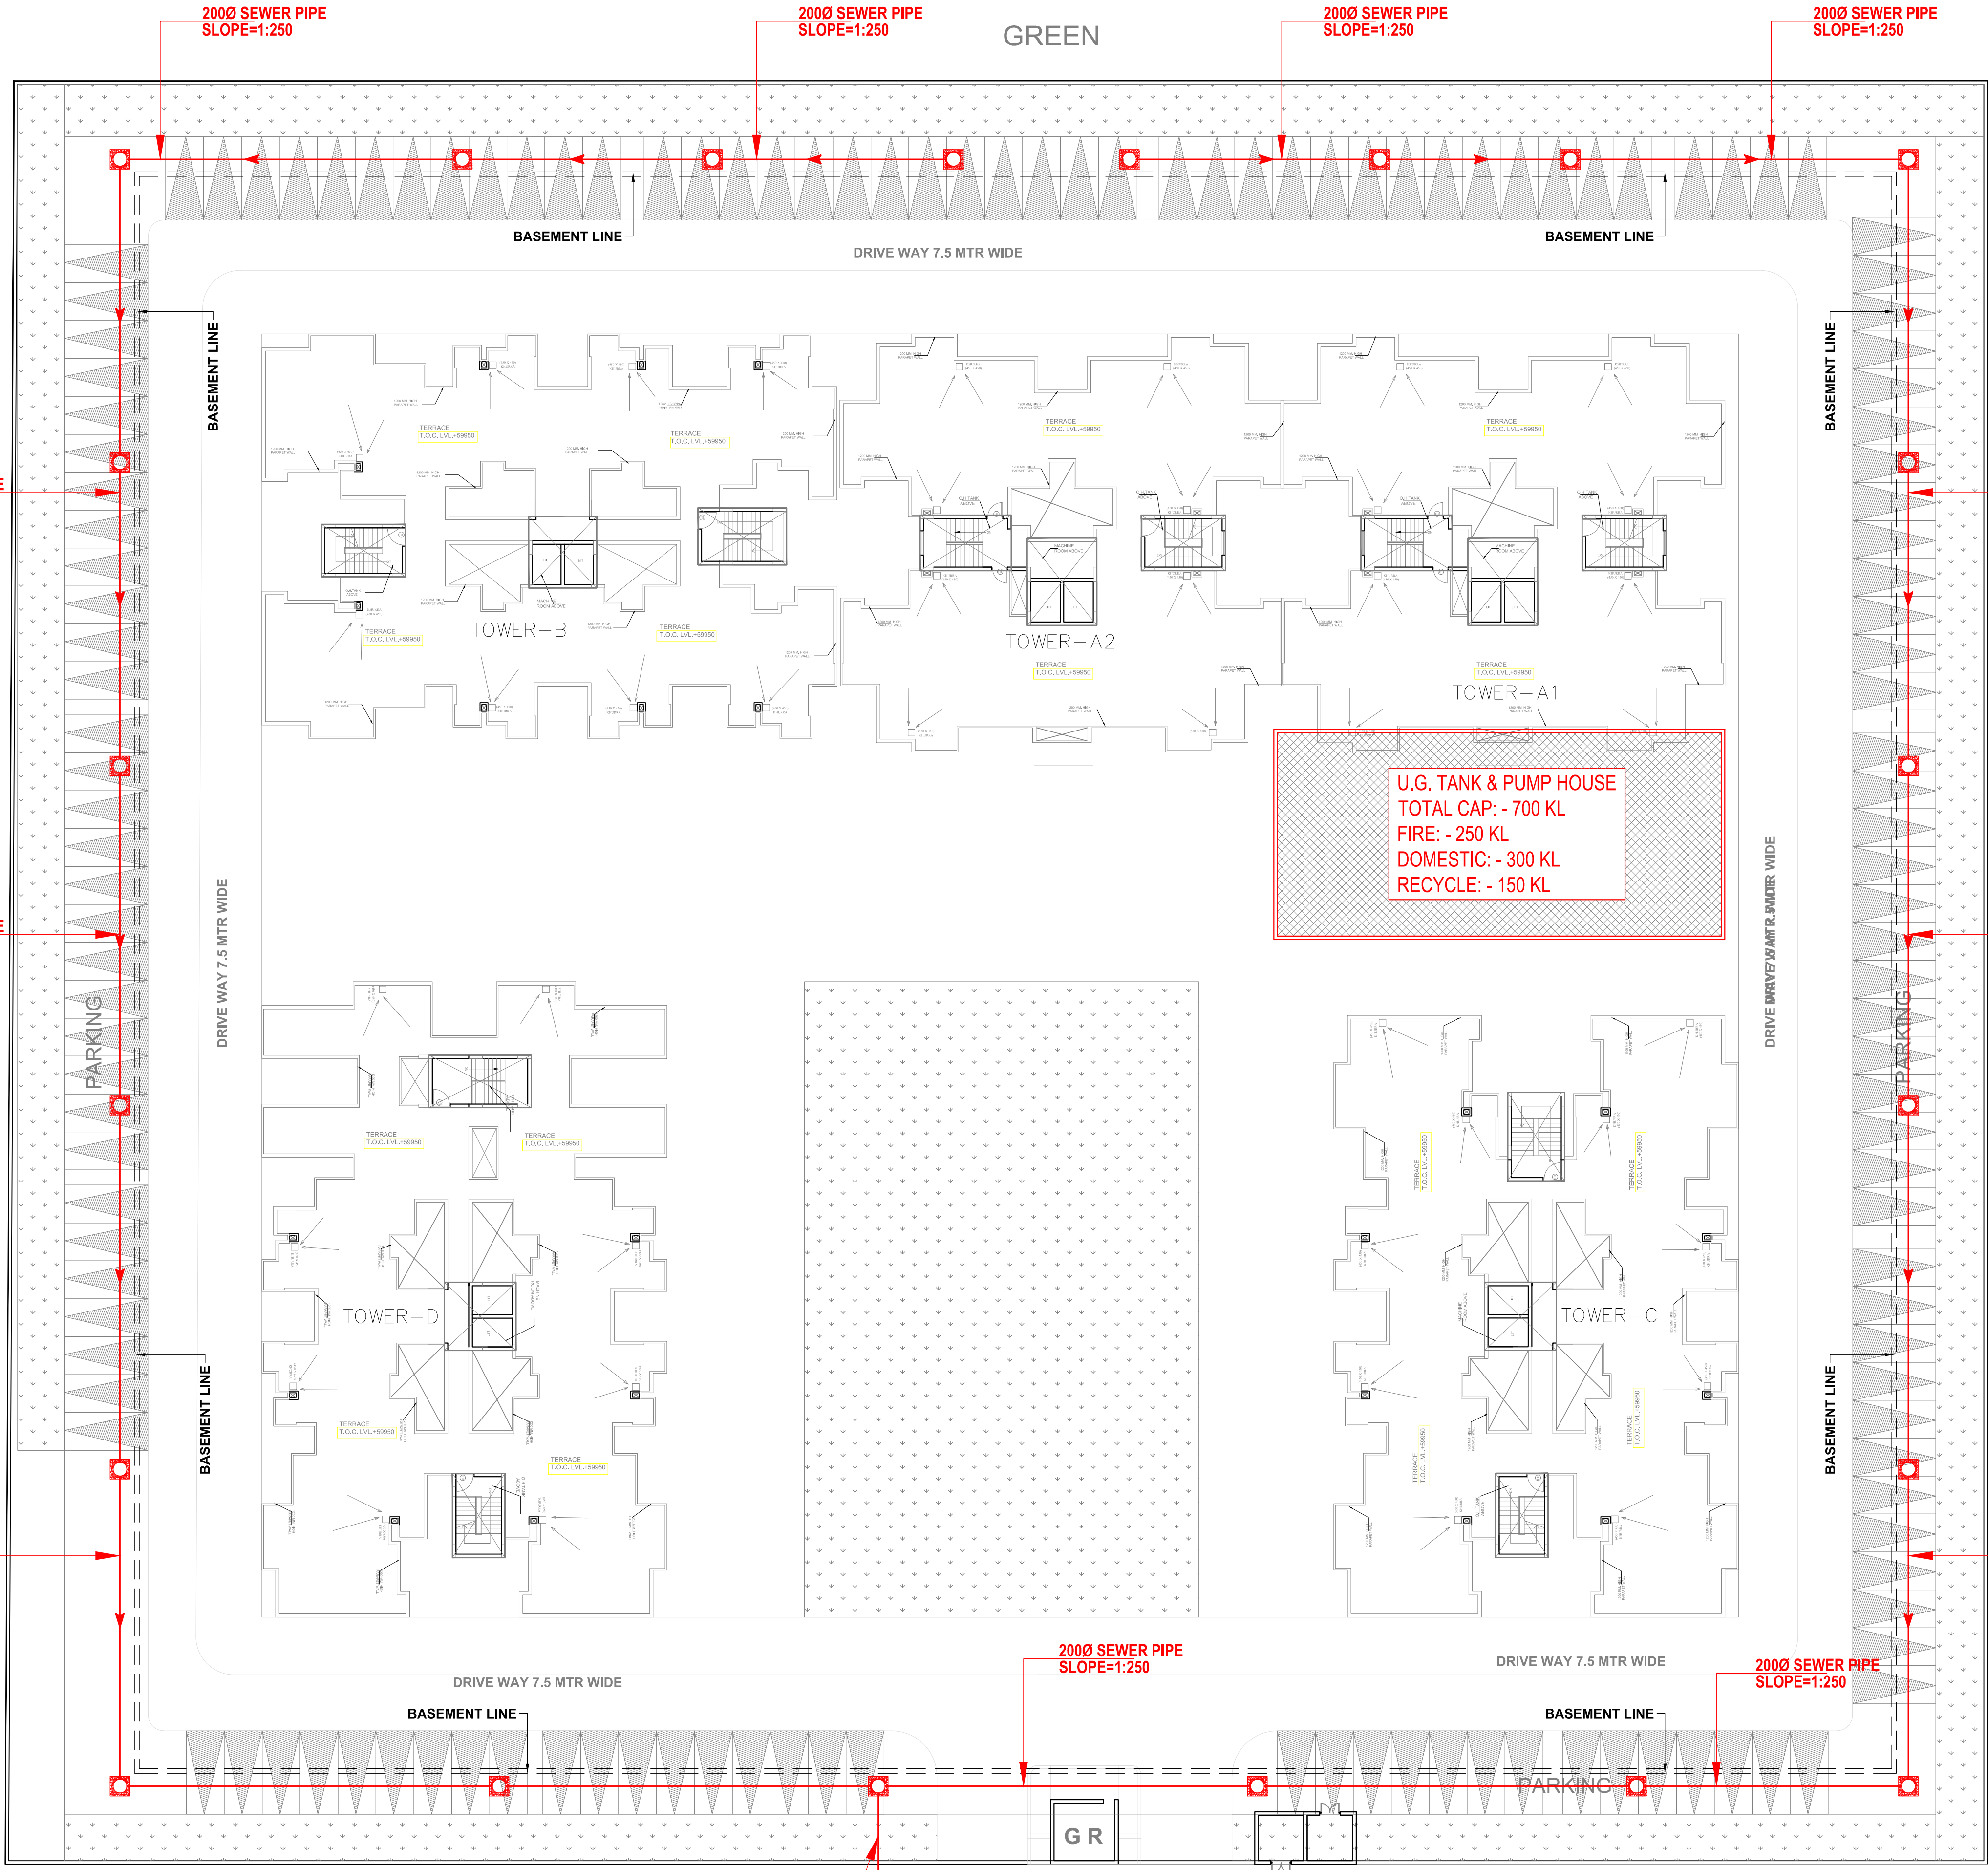


LEGEND : PLUMBING SYSTEM		
S. No.	SYMBOL	DESCRIPTION
1.	M.H.	MANHOLE
2.	—■—	SEWER LINE
3.	----	BASEMENT RETAINING WALL

..	..	..
rev. no.	date	revision

project
PROPOSED GROUP HOUSING AT PLOT NO.-D.1,
CHAK GANJARIA SCHEME, GOMTINAGAR EXTENSION, LUCKNOW

title
SITE PLAN

subtitle
EXTERNAL SEWAGE LAYOUT

drawing released for
☐ APPROVAL ☒ SUBMISSION
☐ ADVANCE COPY ☐ CONSTRUCTION

drg. no. CES / D.1 / SP / P-03 drawn by Sandeep

scale 1:250 @ A1 designed by Shakir Shabbir

date 12.11.2020 checked by Anand Havela

architects : GIAN P. MATHUR AND ASSOCIATES (P) LTD.
C - 55, East Of Kailash, New Delhi-110065
ARCHITECTS & PLANNERS T : 46599599 I F 46599512
E : info@gpmindia.com I W : www.gpmindia.com

services consultant
Consummate Engineering Services (P) Ltd.
Noida Office : B - 67, Sector - 67, Noida - 201 301
Tel : (0120) 2303500 (30 Lines)
Lko. Office : R 006, Rohitas Plumeria, Gomti Nagar, Lucknow
e mail : mail@cespl.in, website : www.cespl.in