


PRODUCED BY AN AUTODESK EDUCATIONAL PRODUCT

PRODUCED BY AN AUTODESK EDUCATIONAL PRODUCT



FOR DBR

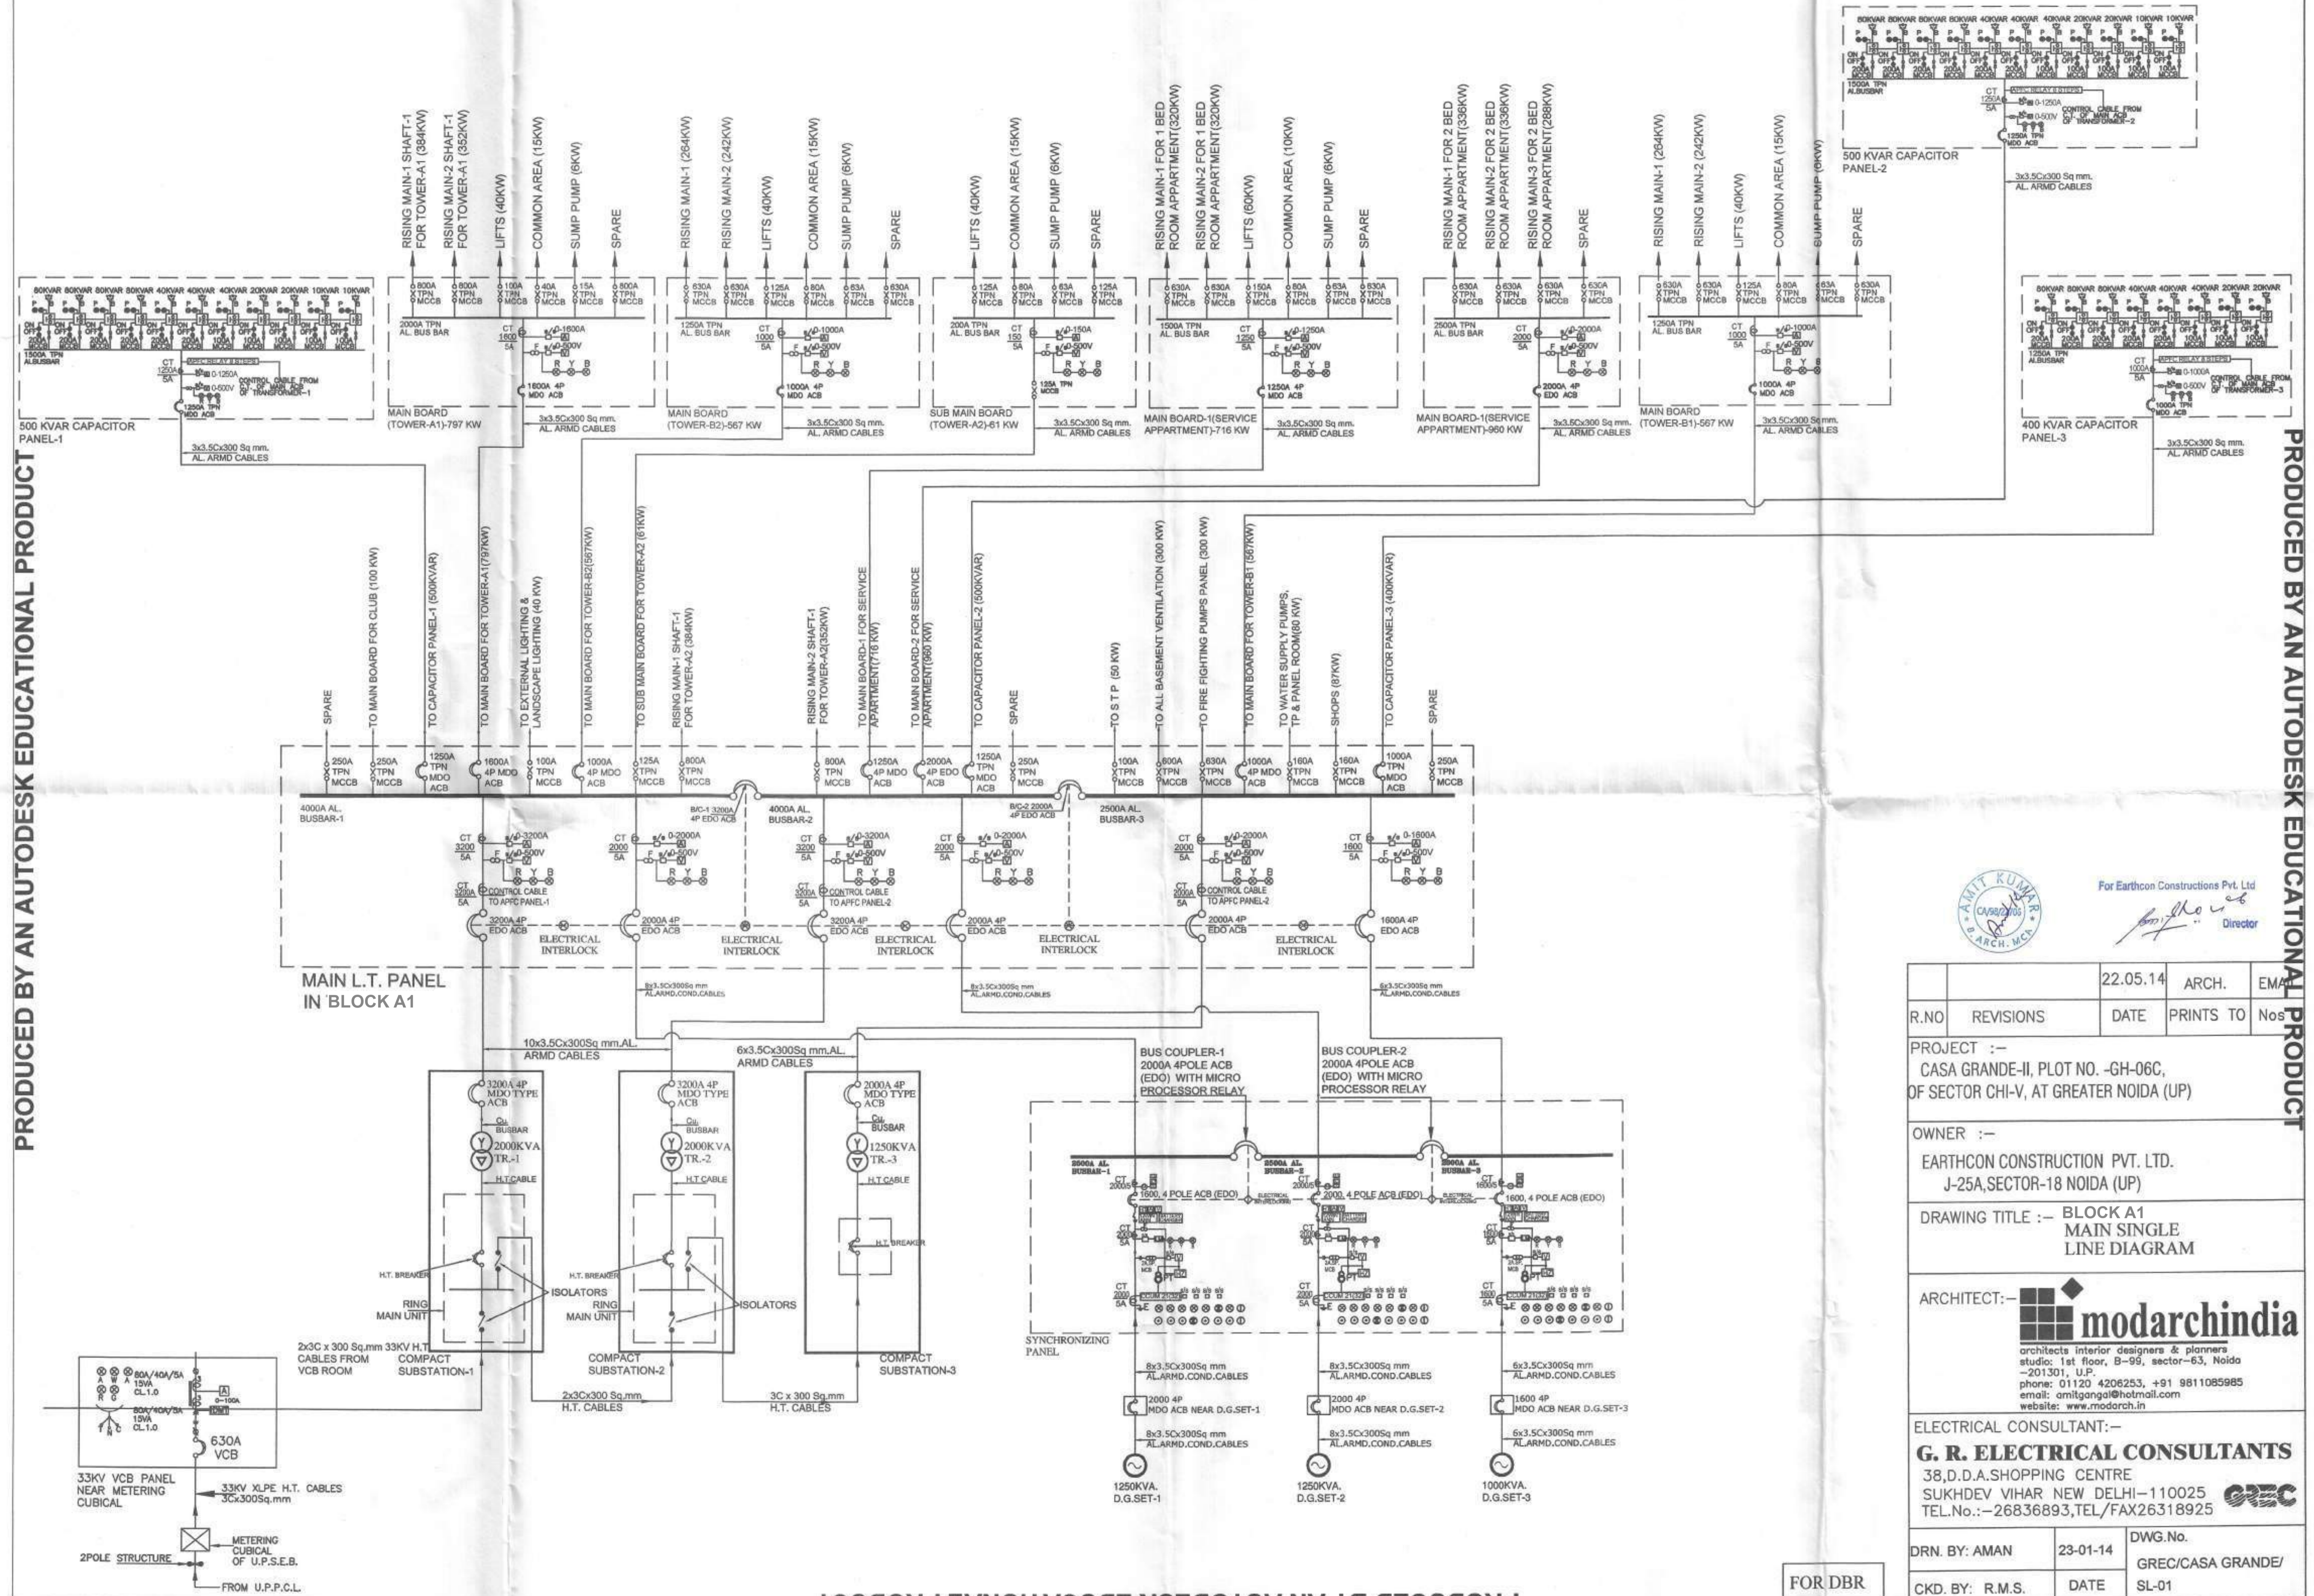

For Earthcon Constructions Pvt. Ltd.  
Director

R.NO	REVISIONS	DATE	PRINTS TO	No
		22.05.14	ARCH.	EMA
PROJECT :- CASA GRANDE-II, PLOT NO. -GH-06C, OF SECTOR CHI-V, AT GREATER NOIDA (UP)				
OWNER :- EARTHCON CONSTRUCTION PVT. LTD. J-25A, SECTOR-18 NOIDA (UP)				
DRAWING TITLE :- BLOCK A1 MAIN SINGLE LINE DIAGRAM				
ARCHITECT:- <b>modarchindia</b> architects interior designers & planners studio: 1st floor, B-99, sector-63, Noida -201301, U.P. phone: 01120 4206253, +91 9811085985 email: amitgonga@hotmail.com website: www.modarch.in				
ELECTRICAL CONSULTANT:- <b>G. R. ELECTRICAL CONSULTANTS</b> 38,D.D.A.SHOPPING CENTRE SUKHDEV VIHAR NEW DELHI-110025 TEL.No:-26836893,TEL/FAX26318925				
DRN. BY: AMAN	23-01-14	DWG.No.		
CKD. BY: R.M.S.	DATE	GREC/CASA GRANDE/ SL-01		