


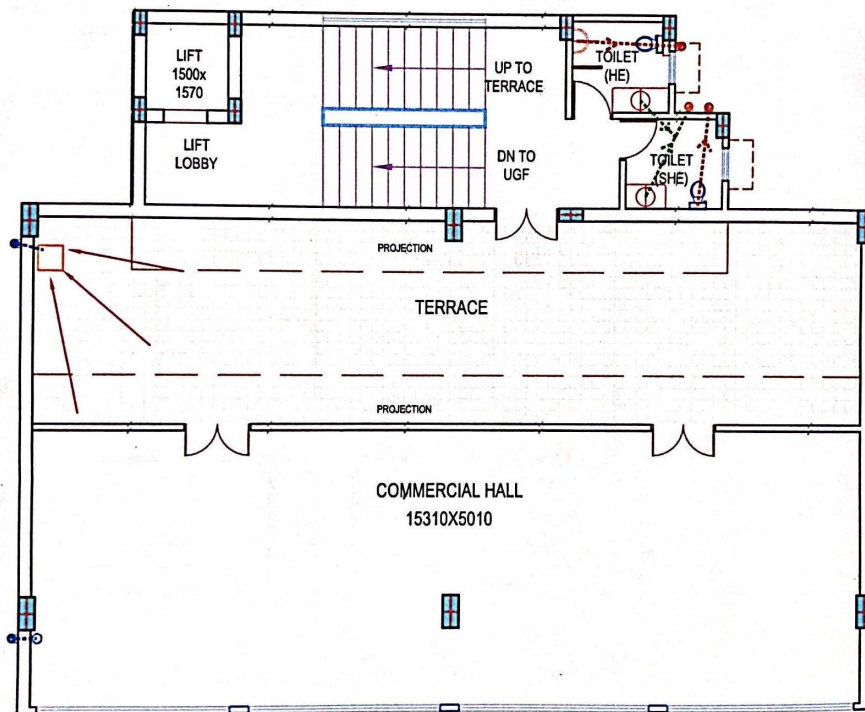

- 4"Ø WASTE WATER PIPE
- 4"Ø RAIN WATER PIPE
- 4"Ø SOIL WATER PIPE

PROJECT

PROPOSED SAPPHIRE SQUARE AT
SAPPHIRE ROYALE
AT KHARRA NO 797,
VILLAGE - JASHPUR BIRJHA
PARGANA & THANEIL
MOHANLALGANJ, LUCKNOW.

FIRST FLOOR PLAN

DATE	SCALE	REVISION	SHEET NO.
31/01/2028			AR-03
DRAWING NO.	SHEET SIZE		
SA-COMM-03	A4		

NOTE

- 1. ALL DIMENSIONS ARE IN MILLIMETERS.
- 2. NO DIMENSION TO BE LESS THAN THE DIMENSION NOTED.
- 3. IN CASE OF DISCREPANCY, LARGE SCALE DIMENSIONS SHALL PREVAIL OVER SMALL SCALE DIMENSIONS. THE DIMENSIONS SHALL BE TAKEN FROM THE LATEST REVISION OF THE DRAWING AND NOT FROM THE ORIGINAL DRAWING.
- 4. ALL DIMENSIONS SHALL BE TO FACE UNLESS OTHERWISE SPECIFIED.
- 5. ALL DIMENSIONS SHALL BE TO FACE UNLESS OTHERWISE SPECIFIED.
- 6. ALL DIMENSIONS SHALL BE TO FACE UNLESS OTHERWISE SPECIFIED.

SAPPHIRE INFRAVENTURES (P) LTD.

DIRECTOR

PROJECT TITLE -


WATER DISPOSAL
PLAN

architect's avenue
D-2/122, Sambhav Tower, Vibhuti
Khand Gomti Nagar, Lucknow, U.P.



FIRST FLOOR PLAN

-  4"Ø WASTE WATER PIPE
 4"Ø RAIN WATER PIPE
 4"Ø SOIL WATER PIPE

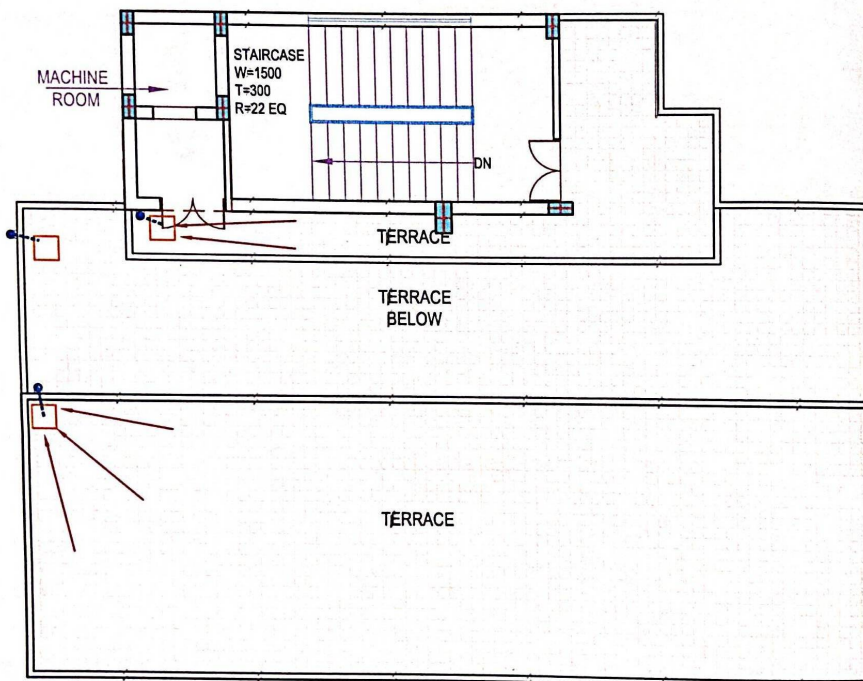

TERRACE PLAN

PROJECT

PROPOSED SAPPHIRE SQUARE AT
SAPPHIRE ROYALE
AT KHASRA NO 787,
VILLAGE - KASIMPUR BIRSHA
PARGANA & THANE,
MOHALLADANU LUCKNOW.

TERRACE PLAN

DATE	SCALE	REVISION	SHEET NO
31/01/2028			AR-04
DRAWING NO.	SHEET SIZE		
SA-COMM-04	A4		

NOTE

1. ALL DIMENSIONS ARE IN MILLIMETERS.
 2. NO DIMENSIONS TO BE TAKEN FROM THE UNFINISHED SURFACES UNLESS SPECIFIED OTHERWISE.
 3. IN CASE OF ANY DISCREPANCY BETWEEN THE DIMENSIONS SHOWN ON THE DRAWING AND THE DIMENSIONS SHOWN ON THE SITE, THE DIMENSIONS SHOWN ON THE DRAWING SHALL PREVAIL.
 4. ALL SERVICES SHALL TO BE PROVIDED ONLY FOR THE TECHNICAL REQUIREMENTS TO BE PROVIDED FOR THE PROJECT AND NOT FOR THE PROJECTS OF THE PROJECTS.
 5. ALL STRUCTURAL WORK AND STRUCTURAL DETAILS TO BE PROVIDED FOR ALL WORKS AT SITE.

SAPPHIRE INFRAVENTURES (P) LTD.

DIRECTOR


PROJECT TITLE -

WATER DISPOSAL
PLAN

architect's avenue
 D-2122, Sanjay Tower, Vardaan
 Khand Gomti Nagar, Lucknow, U.P.

ARCHITECT



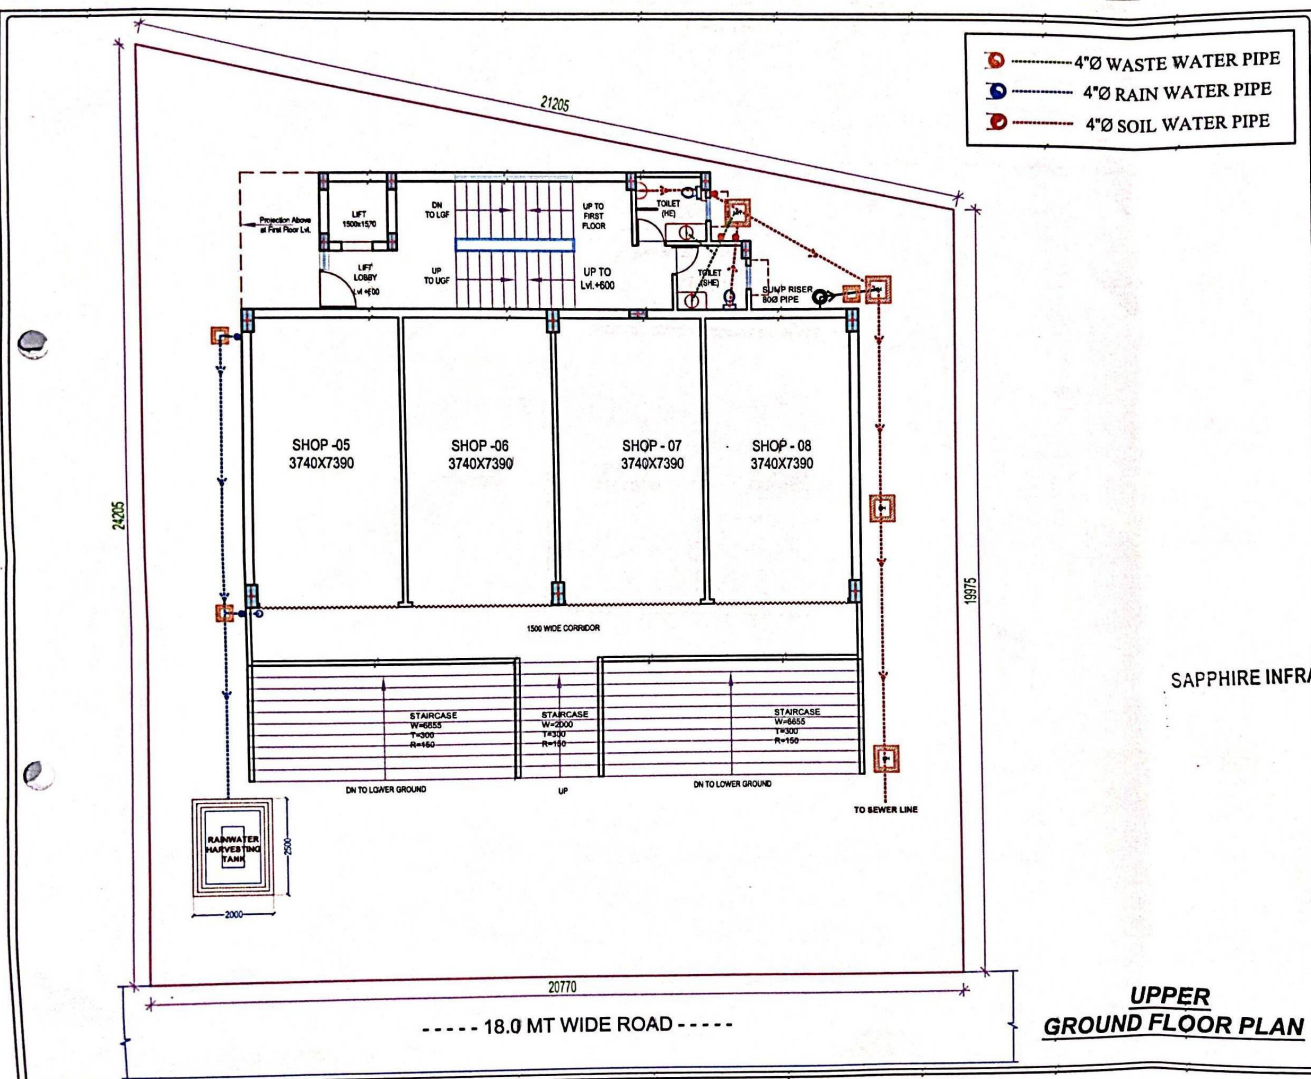

PROJECT			
PROPOSED SAPPHIRE SQUARE AT SAPPHIRE ROYALE AT KASERA NO 787, VILLAGE -KASIMPUR BIRUHA PARGANA & THASIL- MOHANLALGANJ LUCKNOW.			
UPPER GROUND FLOOR PLAN			
DATE	SCALE	REVISION	SHEET NO.
31/01/2028			AR-02
DRAWING NO.	SHEET SIZE		12
SA-COMM-02	A4		
NOTE			
1. ALL DIMENSIONS ARE IN MILLIMETERS. 2. ALL DIMENSIONS TO BE TAKEN FROM THE EXTERIOR FACE UNLESS OTHERWISE SPECIFIED. 3. IN CASE OF CONFLICT BETWEEN DIMENSIONS, THE DIMENSIONS SHOWN IN THE DRAWING SHALL BE THE GOVERNORING DIMENSIONS. 4. ALL WORKING SHALL BE TO BE DONE ONLY AS PER THE TECHNICAL AND SPECIFICATIONS MENTIONED IN THE DRAWING TO BE FOLLOWED FOR THE CONSTRUCTION OF THE PROJECT. 5. ALL STRUCTURAL, ROOF AND STRUCTURAL DETAILS TO BE APPROVED FROM STRUCTURAL ENGINEER'S OFFICE.			
SAPPHIRE INFRAVENTURES (P) LTD. <i>[Signature]</i> DIRECTOR			
PROJECT TITLE -			
WATER DISPOSAL PLAN			
architect's address D-2/122, Sambhav Tower, Vibhuti Khand Ganga Nagar, Lucknow, U.P.			
ARCHITECT			

**UPPER
GROUND FLOOR PLAN**

 4"Ø WASTE WATER PIPE
 4"Ø RAIN WATER PIPE
 4"Ø SOIL WATER PIPE

PROJECT

PROPOSED SAPPHIRE SQUARE AT
SAPPHIRE ROYALE
AT KHASRA NO 197,
VILLAGE KASIMPUR BIRUA
PARGANA & THAKUR,
MOHALLA GANJ LUCKNOW.

LOWER GROUND FLOOR PLAN

DATE

31/01/2022

SCALE

1/8"=1'-0"

DIVISION

AR-01

DRAWING NO.

SA-COMM-01

SHEET SIZE

A4

NOTE

1. ALL DIMENSIONS ARE IN METERS.

2. NO DIMENSIONS TO BE SHOWN FROM THE UNFINISHED SURFACE UNLESS SPECIFIED OTHERWISE.

3. IN CASE OF ANY DISCREPANCY BETWEEN THE DIMENSIONS SHOWN ON THIS DRAWING AND THE DIMENSIONS SHOWN ON THE SITE PLAN, THE DIMENSIONS ON THE SITE PLAN SHALL PREVAIL.

4. ALL DIMENSIONS SHALL BE TO THE CENTERLINE OF THE ROAD.

5. ALL DIMENSIONS SHALL BE TO THE CENTERLINE OF THE ROAD.

6. ALL DIMENSIONS SHALL BE TO THE CENTERLINE OF THE ROAD.

SAPPHIRE INFRAVENTURES (P) LTD.


 DIRECTOR

PROJECT TITLE -

WATER DISPOSAL PLAN

architect's avenue
 D-2/122, Sambhav Tower, Vibhuti
 Khand Gomti Nagar, Lucknow, U.P.



LOWER GROUND FLOOR PLAN

