


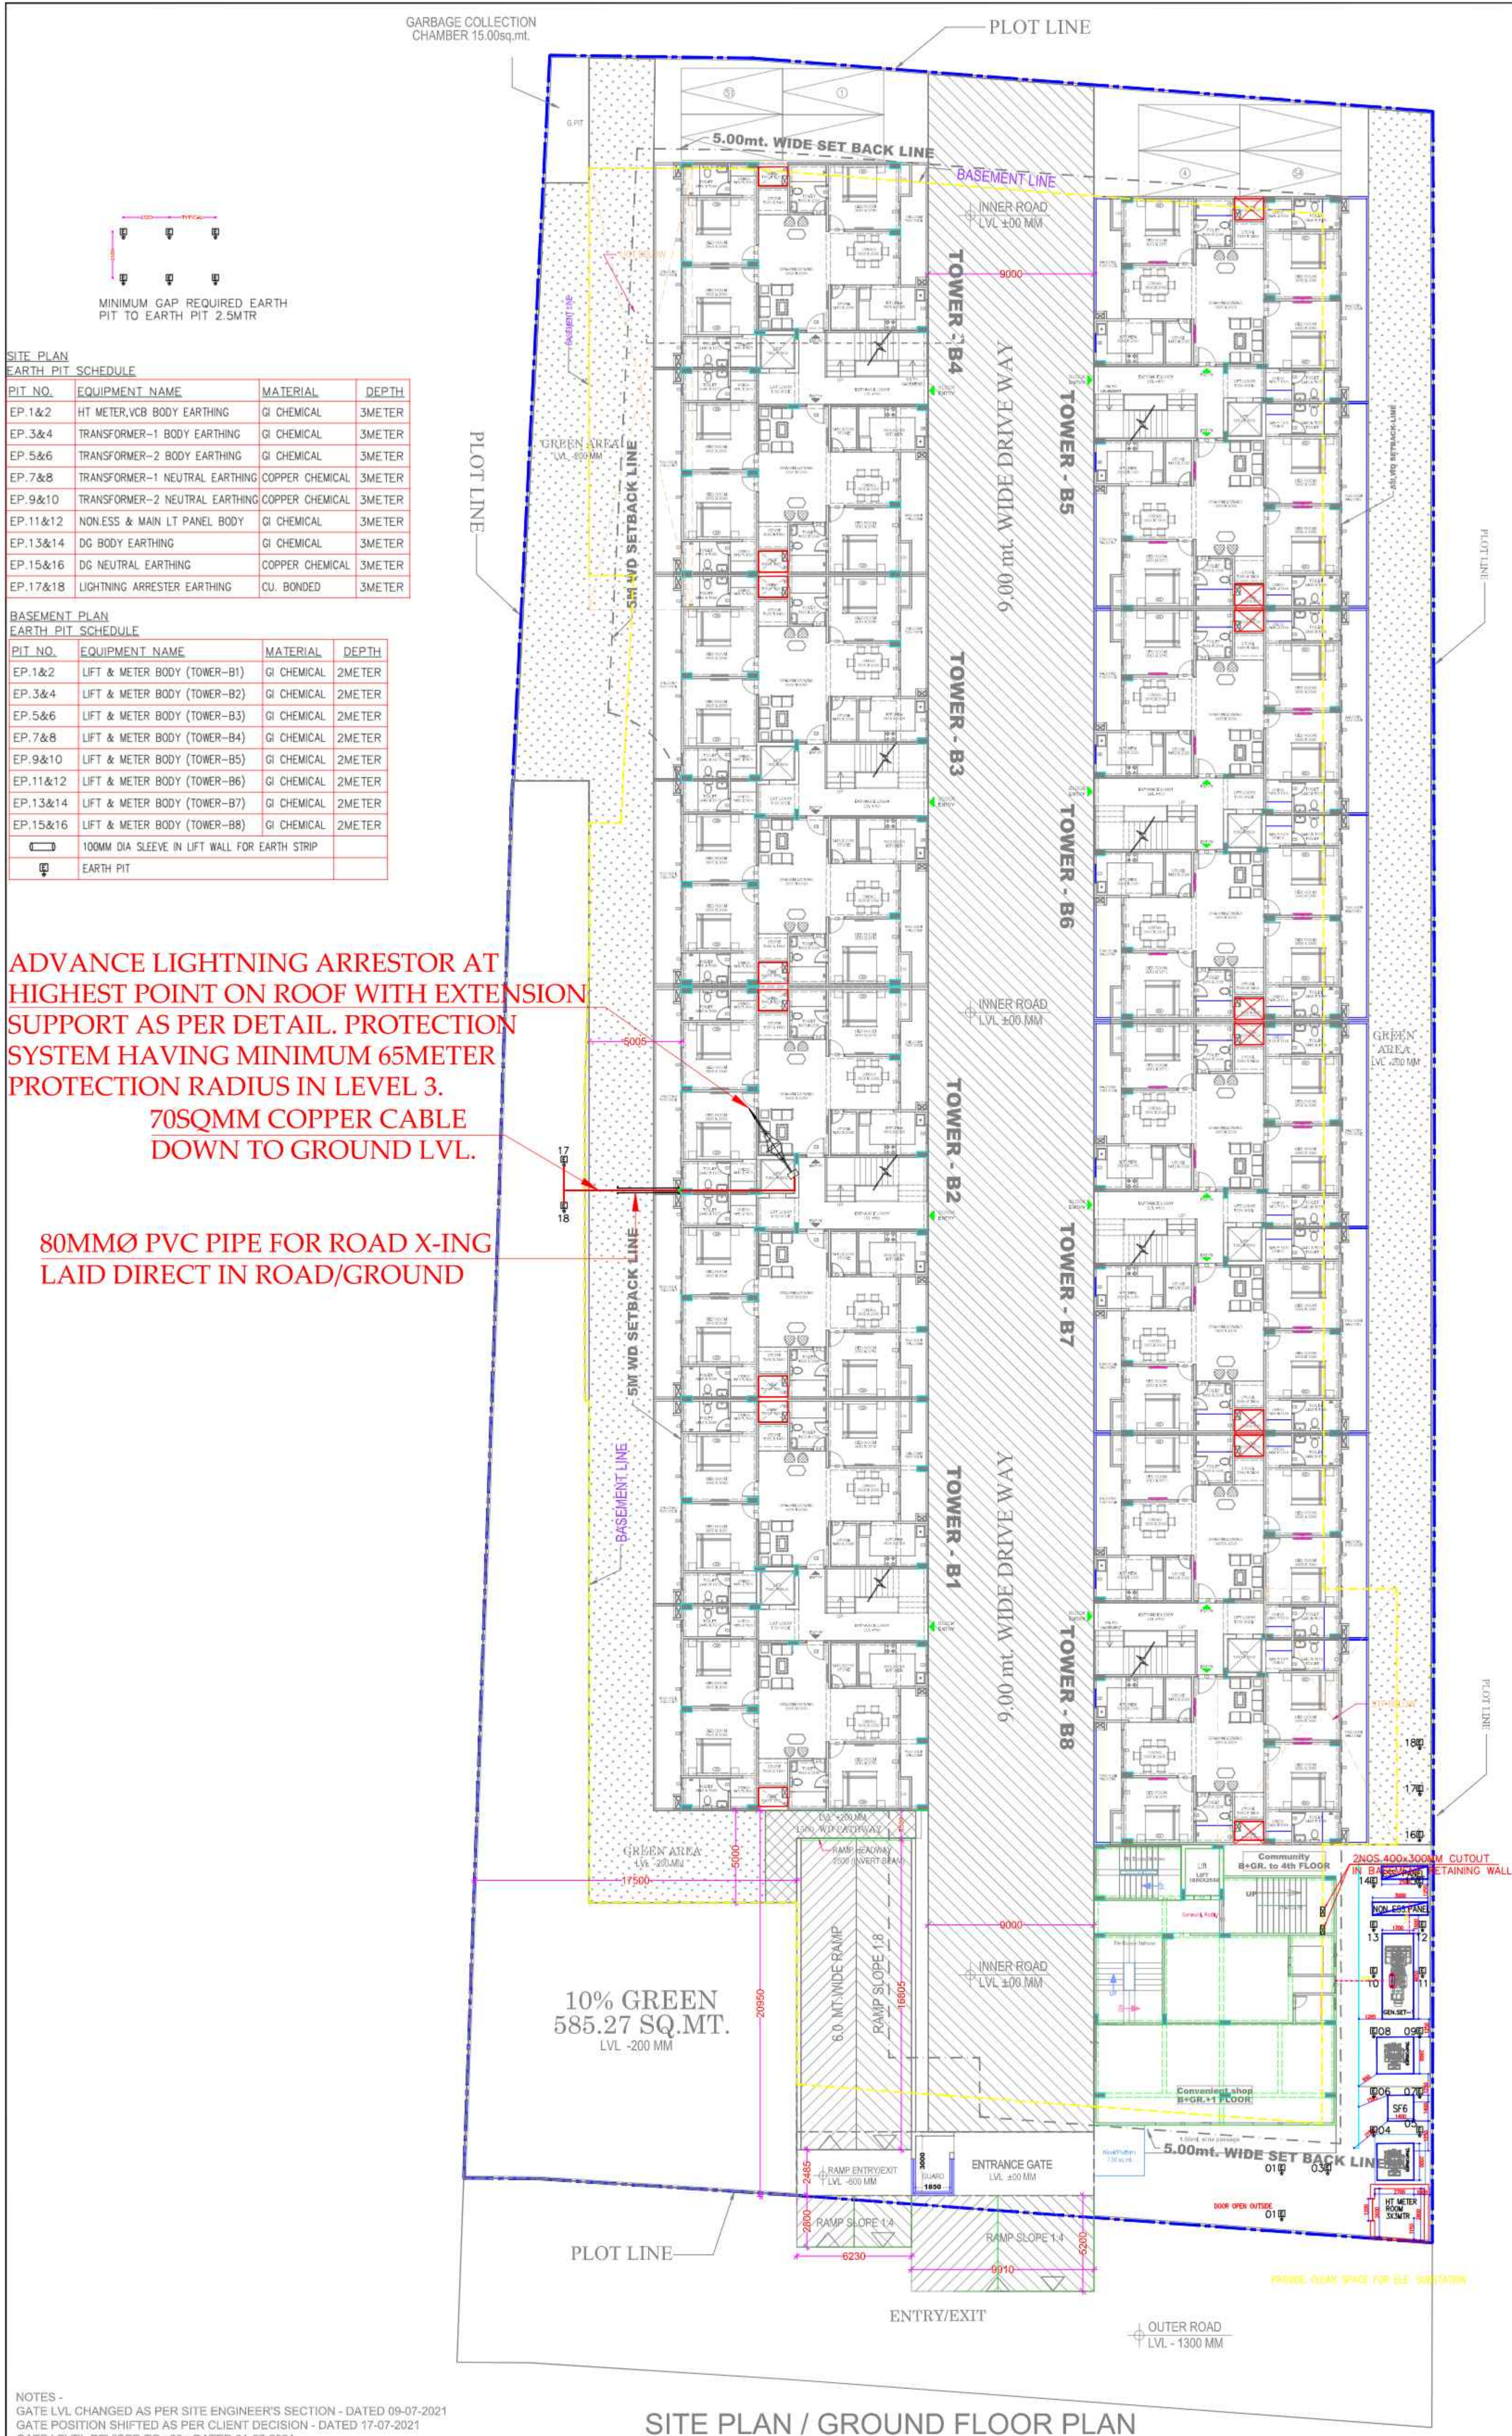

PROJECT:

" UNINAV EDEN " AT KHASRA NO - 1104 M AT
VILLAGE NOOR NAGAR GHAZIABAD (U.P.)
M/s. - UNINAV DEVELOPER'S PVT. LTD.


DRG. TITLE:-

ELECTRICAL LAYOUT
SITE PLAN

DRG/. NO.

UN/EDEN/SITE/MEP-01

Key Plan

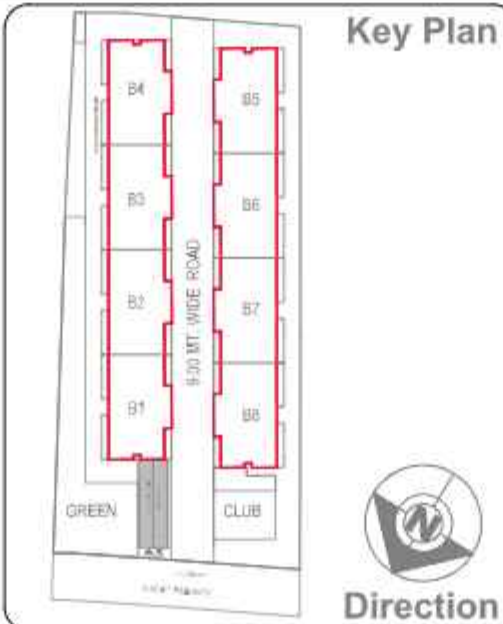

MEP SERVICES CONSULTANT



ECMS INDIA PVT. LTD.
WP-21 C-282, BASEMENT
NOIDA SECTOR-71,
UTTAR PRADESH-201307
E-mail: ecms.tech01@gmail.com
URL: www.ecmsindia.com
Ph.No. 0120-4205667

drawing released for

☐ APPROVAL

☐ ADVANCE COPY

☐ G.F.C.

☐ CONSTRUCTION



ANUJ AGARWAL ARCHITECTS
OFFICE:- A-244 KAUSHAMBI GHAZIABAD (U.P.)
Ph:0120 - 4165716 , 4563716 , 6454182
e-mail : arch.anujagarwal@gmail.com

scale:-

N.T.S.

date:-

13-08-2021

design by:-

RAJ

checked by:-

S.BEHERA