


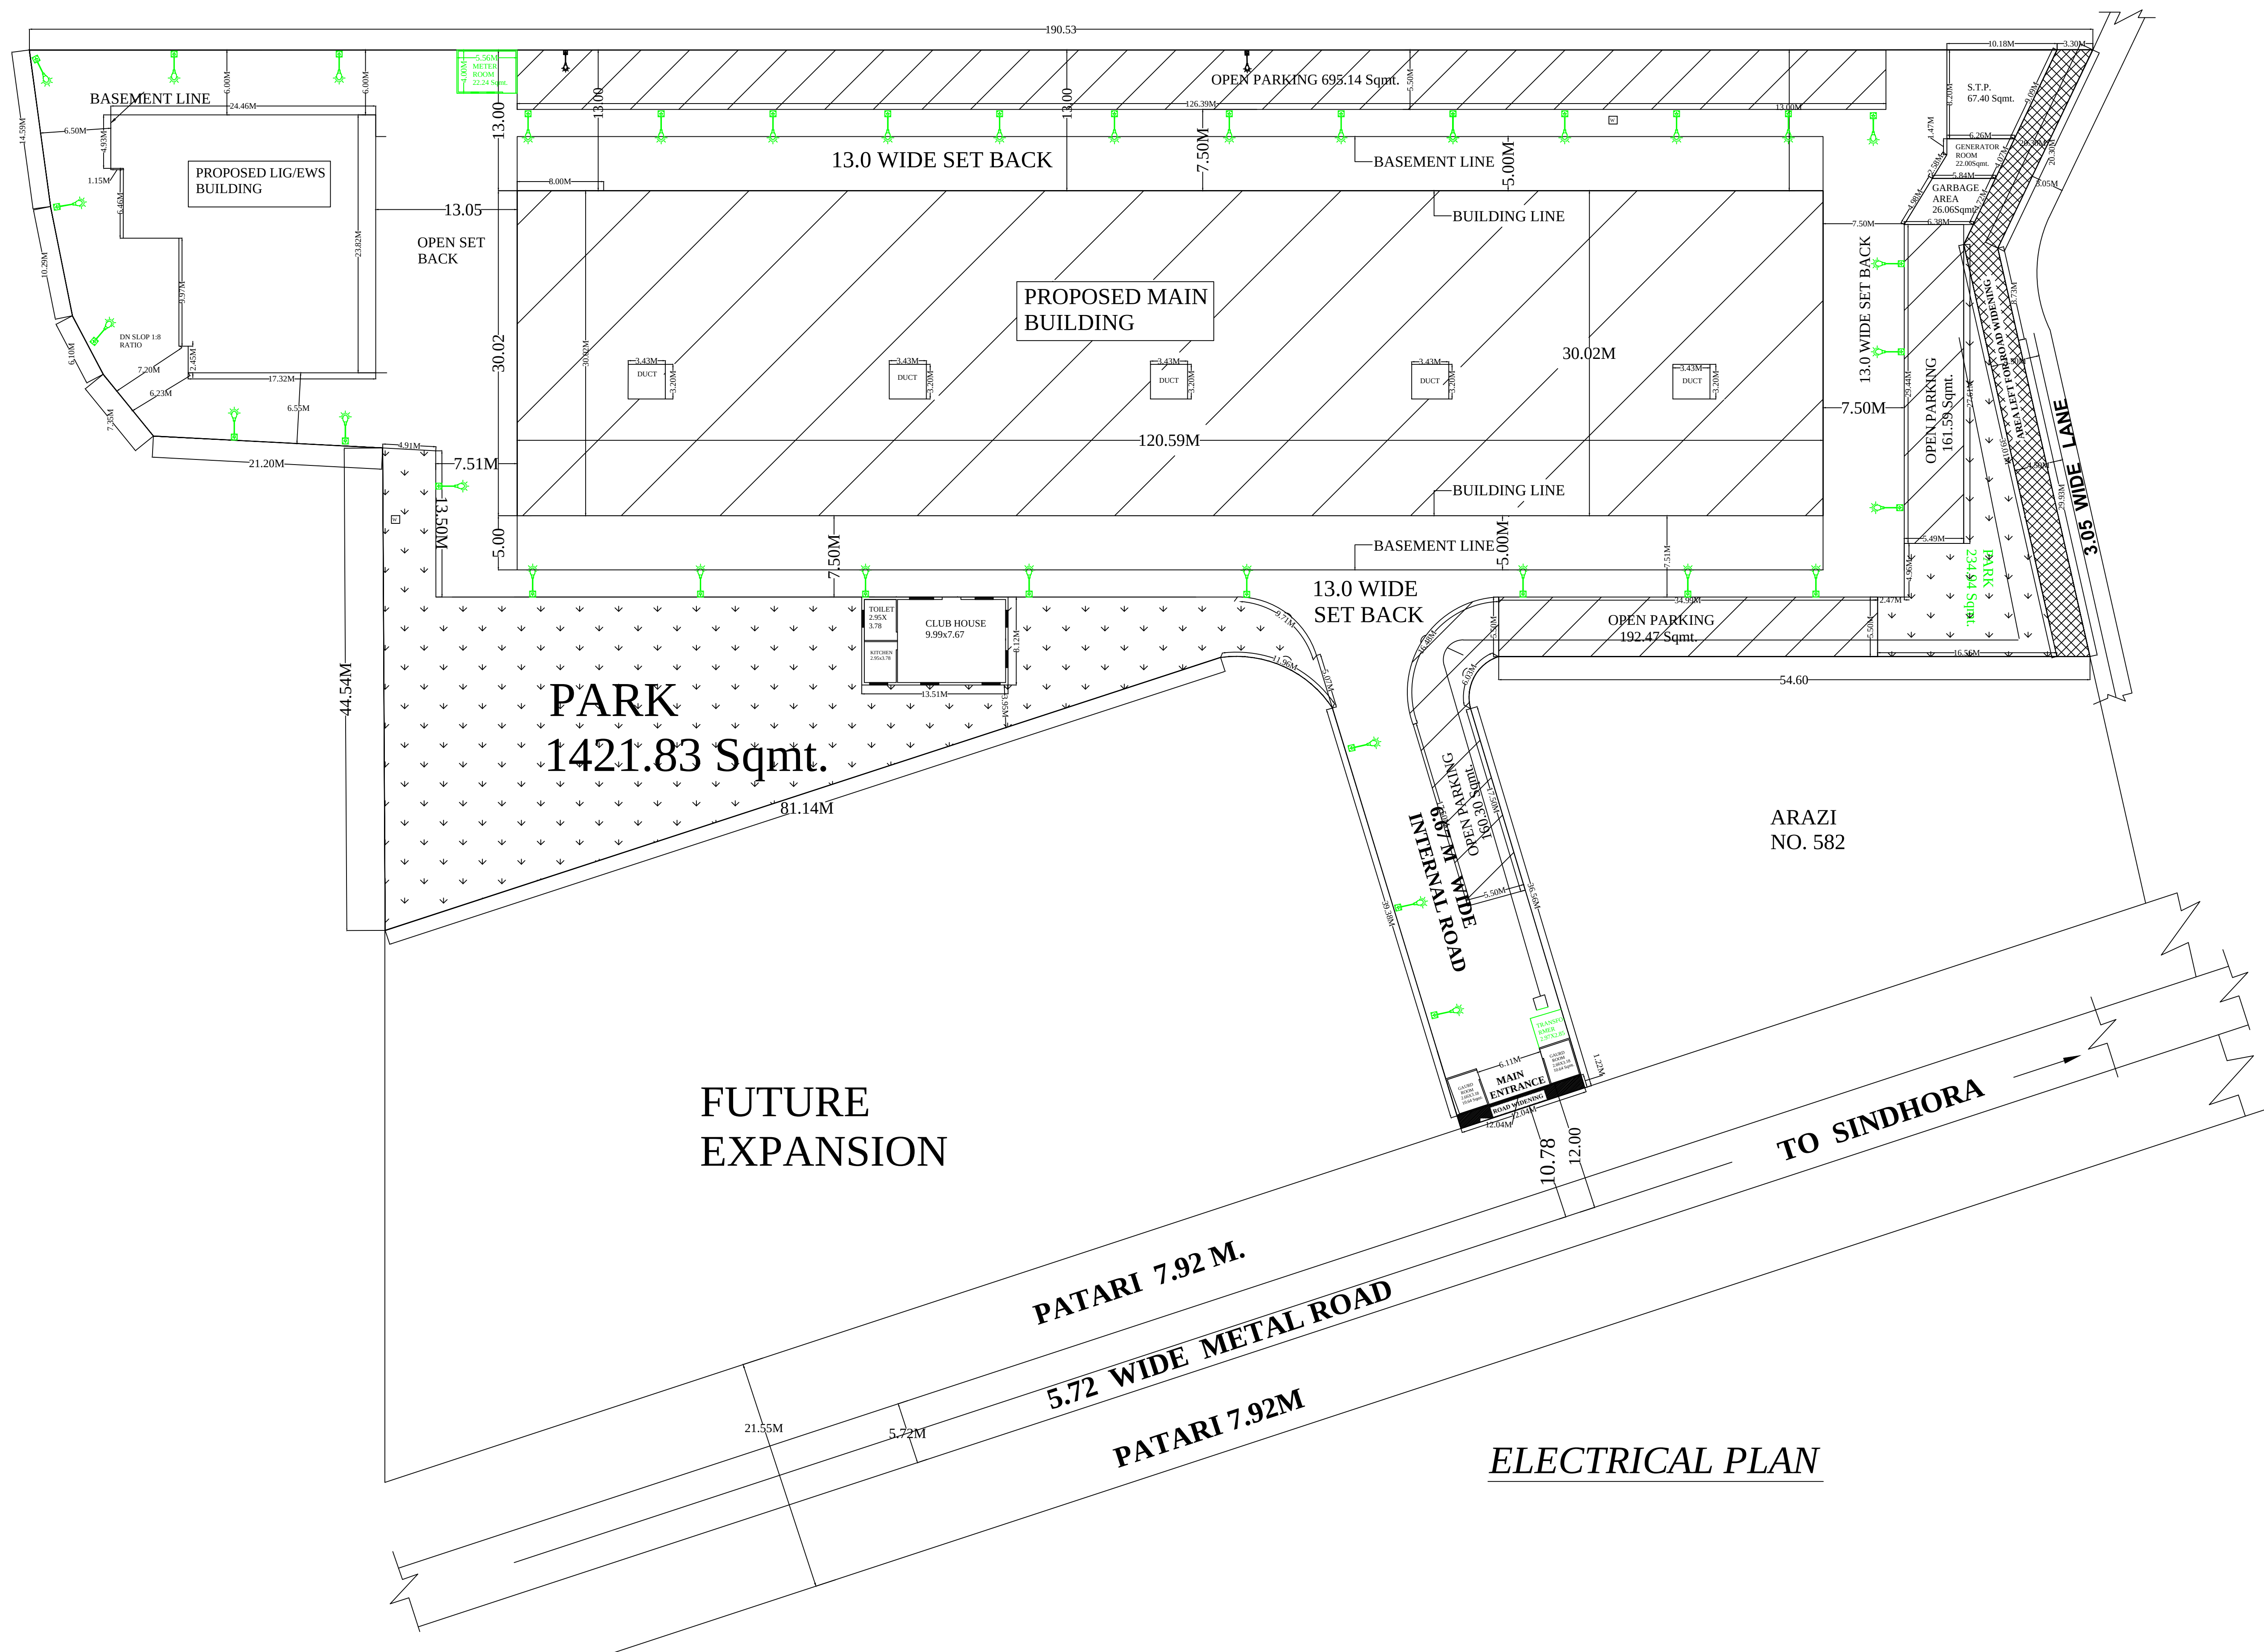

PROPOSED GROUP HOUSING
PLAN OF ARAZI NO. 581,
MAUZA- DANDUPUR,
PARAGANA-SHIVPUR,
TAHASIL- SADAR, DISTT. -
VARANASI

DEVELOPERS----
TIRUPATI BUILDER & DEVELOPERS.

1-SRI SANJEEV KUMAR AGRAWAL
SANJAY KUMAR AGRAWAL S/O SRI
VISHWAMBHAR PRASAD AGRAWAL

2-SRI SHASHI KUMAR SINGH
VINAY KUMAR SINGH S/O SRI SATYENDRA
KUMAR SINGH

3-SRI PANKAJ KUMAR SINGH S/O SRI VIKRAMA
SINGH
SMT. PRIYANKA SINGH W/O SRI PANKAJ KUMAR
SINGH

POWER OF ATTORNEY:-
SRI RAM SHANKAR SINGH
S/O SRI SARNATH SINGH

W
N
E
S
OWNER SIGN..

SHEET NO.
04/4

SCALE
1:100

DESIGN CENTRE
ARCHITECT ENGINEER INTT.
DESIGNER VALUER
OFFICE NO.11 IIND FLOOR
P.C.F. PLAZA MINT HOUSE
NADESAR VARANASI
PH. NO. 0542,2505233

ELECTRICAL PLAN