


LEGEND FOR STORM WATER

DESCRIPTION	SYMBOL
STORM WATER PIPE	
STORM WATER MANHOLE	
DE-SILTING CHAMBER 2.0X1.2M	
RAIN WATER HARVESTING PIT 3.0MX3.0M	

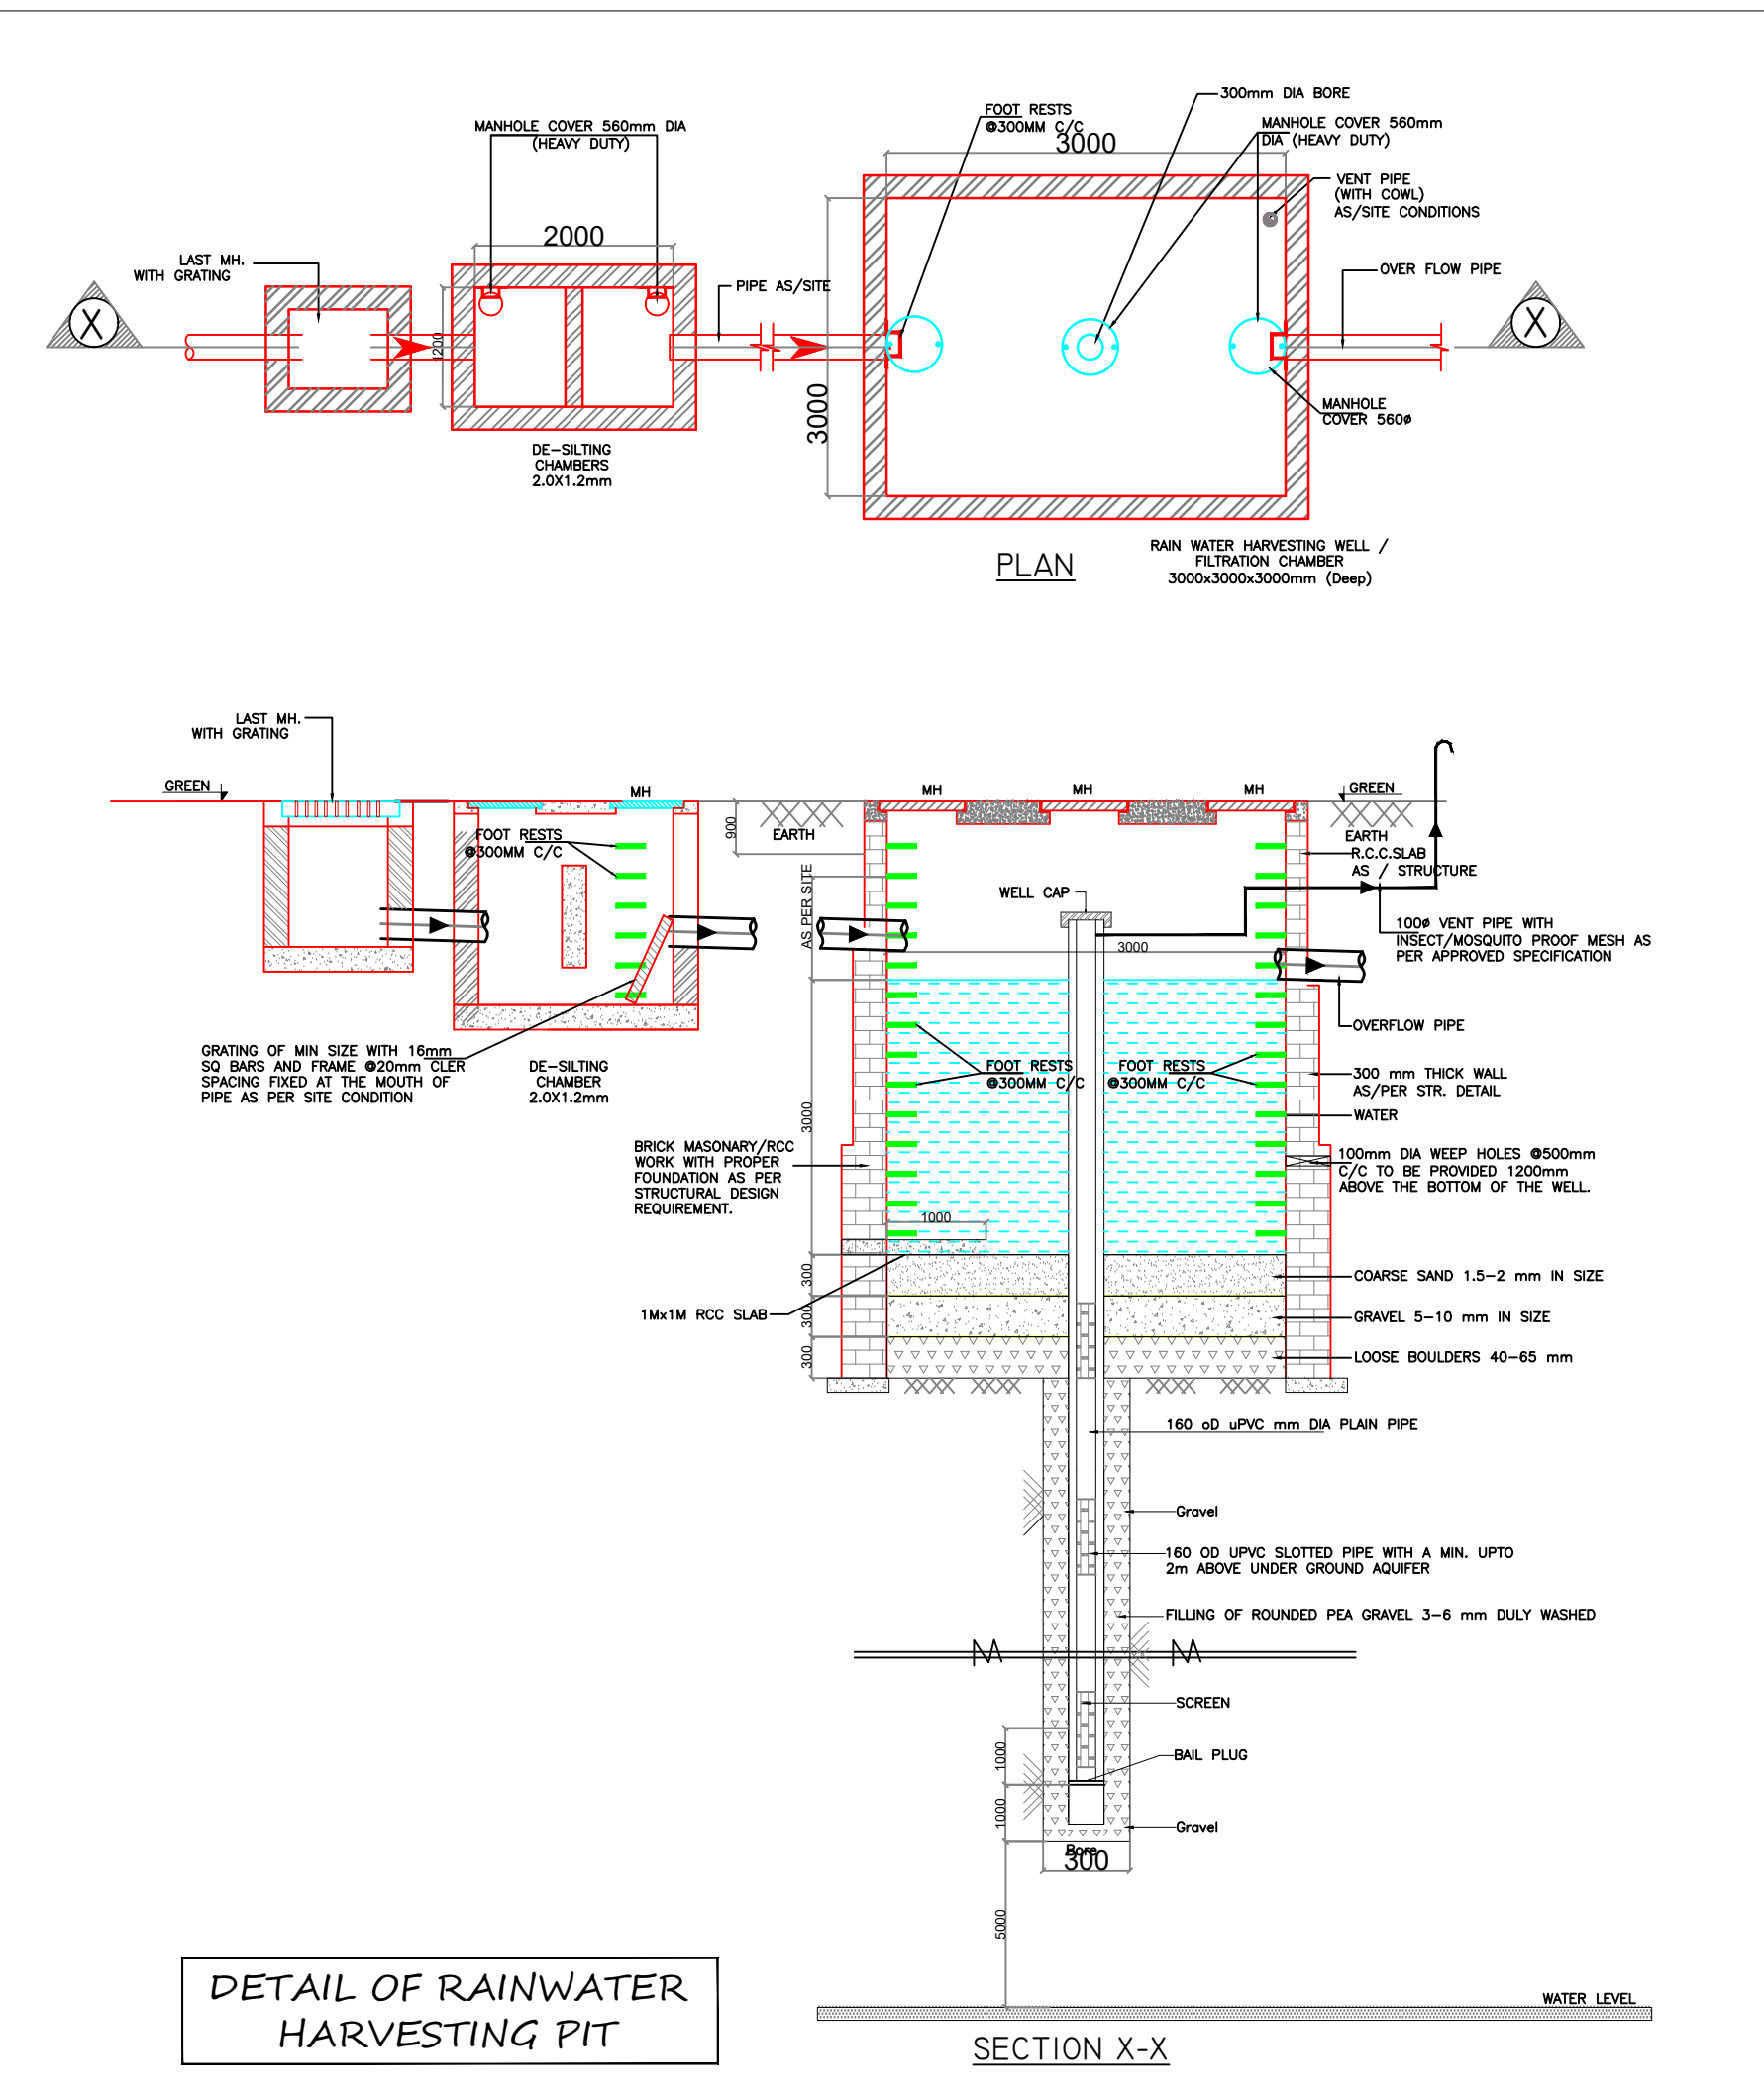

PROJECT
PROPOSED IT/ITES PARK AT
PLOT NO. 1B, SECTOR 140A, NOIDA

VASTUNIDHI

Vastunidhi
10A BLOCK, 1B SECTOR-44,
NOIDA, UTTAR PRADESH 201 301, INDIA
T: +91 9898 191 500

SERVICES CONSULTANTS
Proion Consultants Private Limited
Building Services - MEP Consulting
82, Sukhdev Vihar,
New Delhi 110 025, India.
Tel: 26324400, www.proion.net

ARCHITECT'S SIGNATURE

OWNER'S SIGNATURE

SITE PLAN
STORM WATER LAYOUT

SUBMISSION DRAWING

DRAWN BY	YOGENDRA	CHECKED BY	P.G.
DATE	02-11-2022	SCALE	1:400
SHEET SIZE	A0	SHEETS	1
NUMBER	PC-CRC-140A-PL-100	REV. NO.	