


LEGEND:-	
SYM.	DESCRIPTION
	AMMETER
	VOLT METER
	POWER FACTOR METER
	FREQUENCY METER
	AMMETER SELECTOR SWITCH
	VOLTMETER SELECTOR SWITCH
	CURRENT TRANSFORMER
	INDICATING LAMP
	POTENTIAL TRANSFORMER
	GROUNDING
	VACUUM CIRCUIT BREAKER
	CONTROL FUSE
	TRANSFORMER
	MASTER TRIP RELAY
	RESTRICTED EARTH FAULT

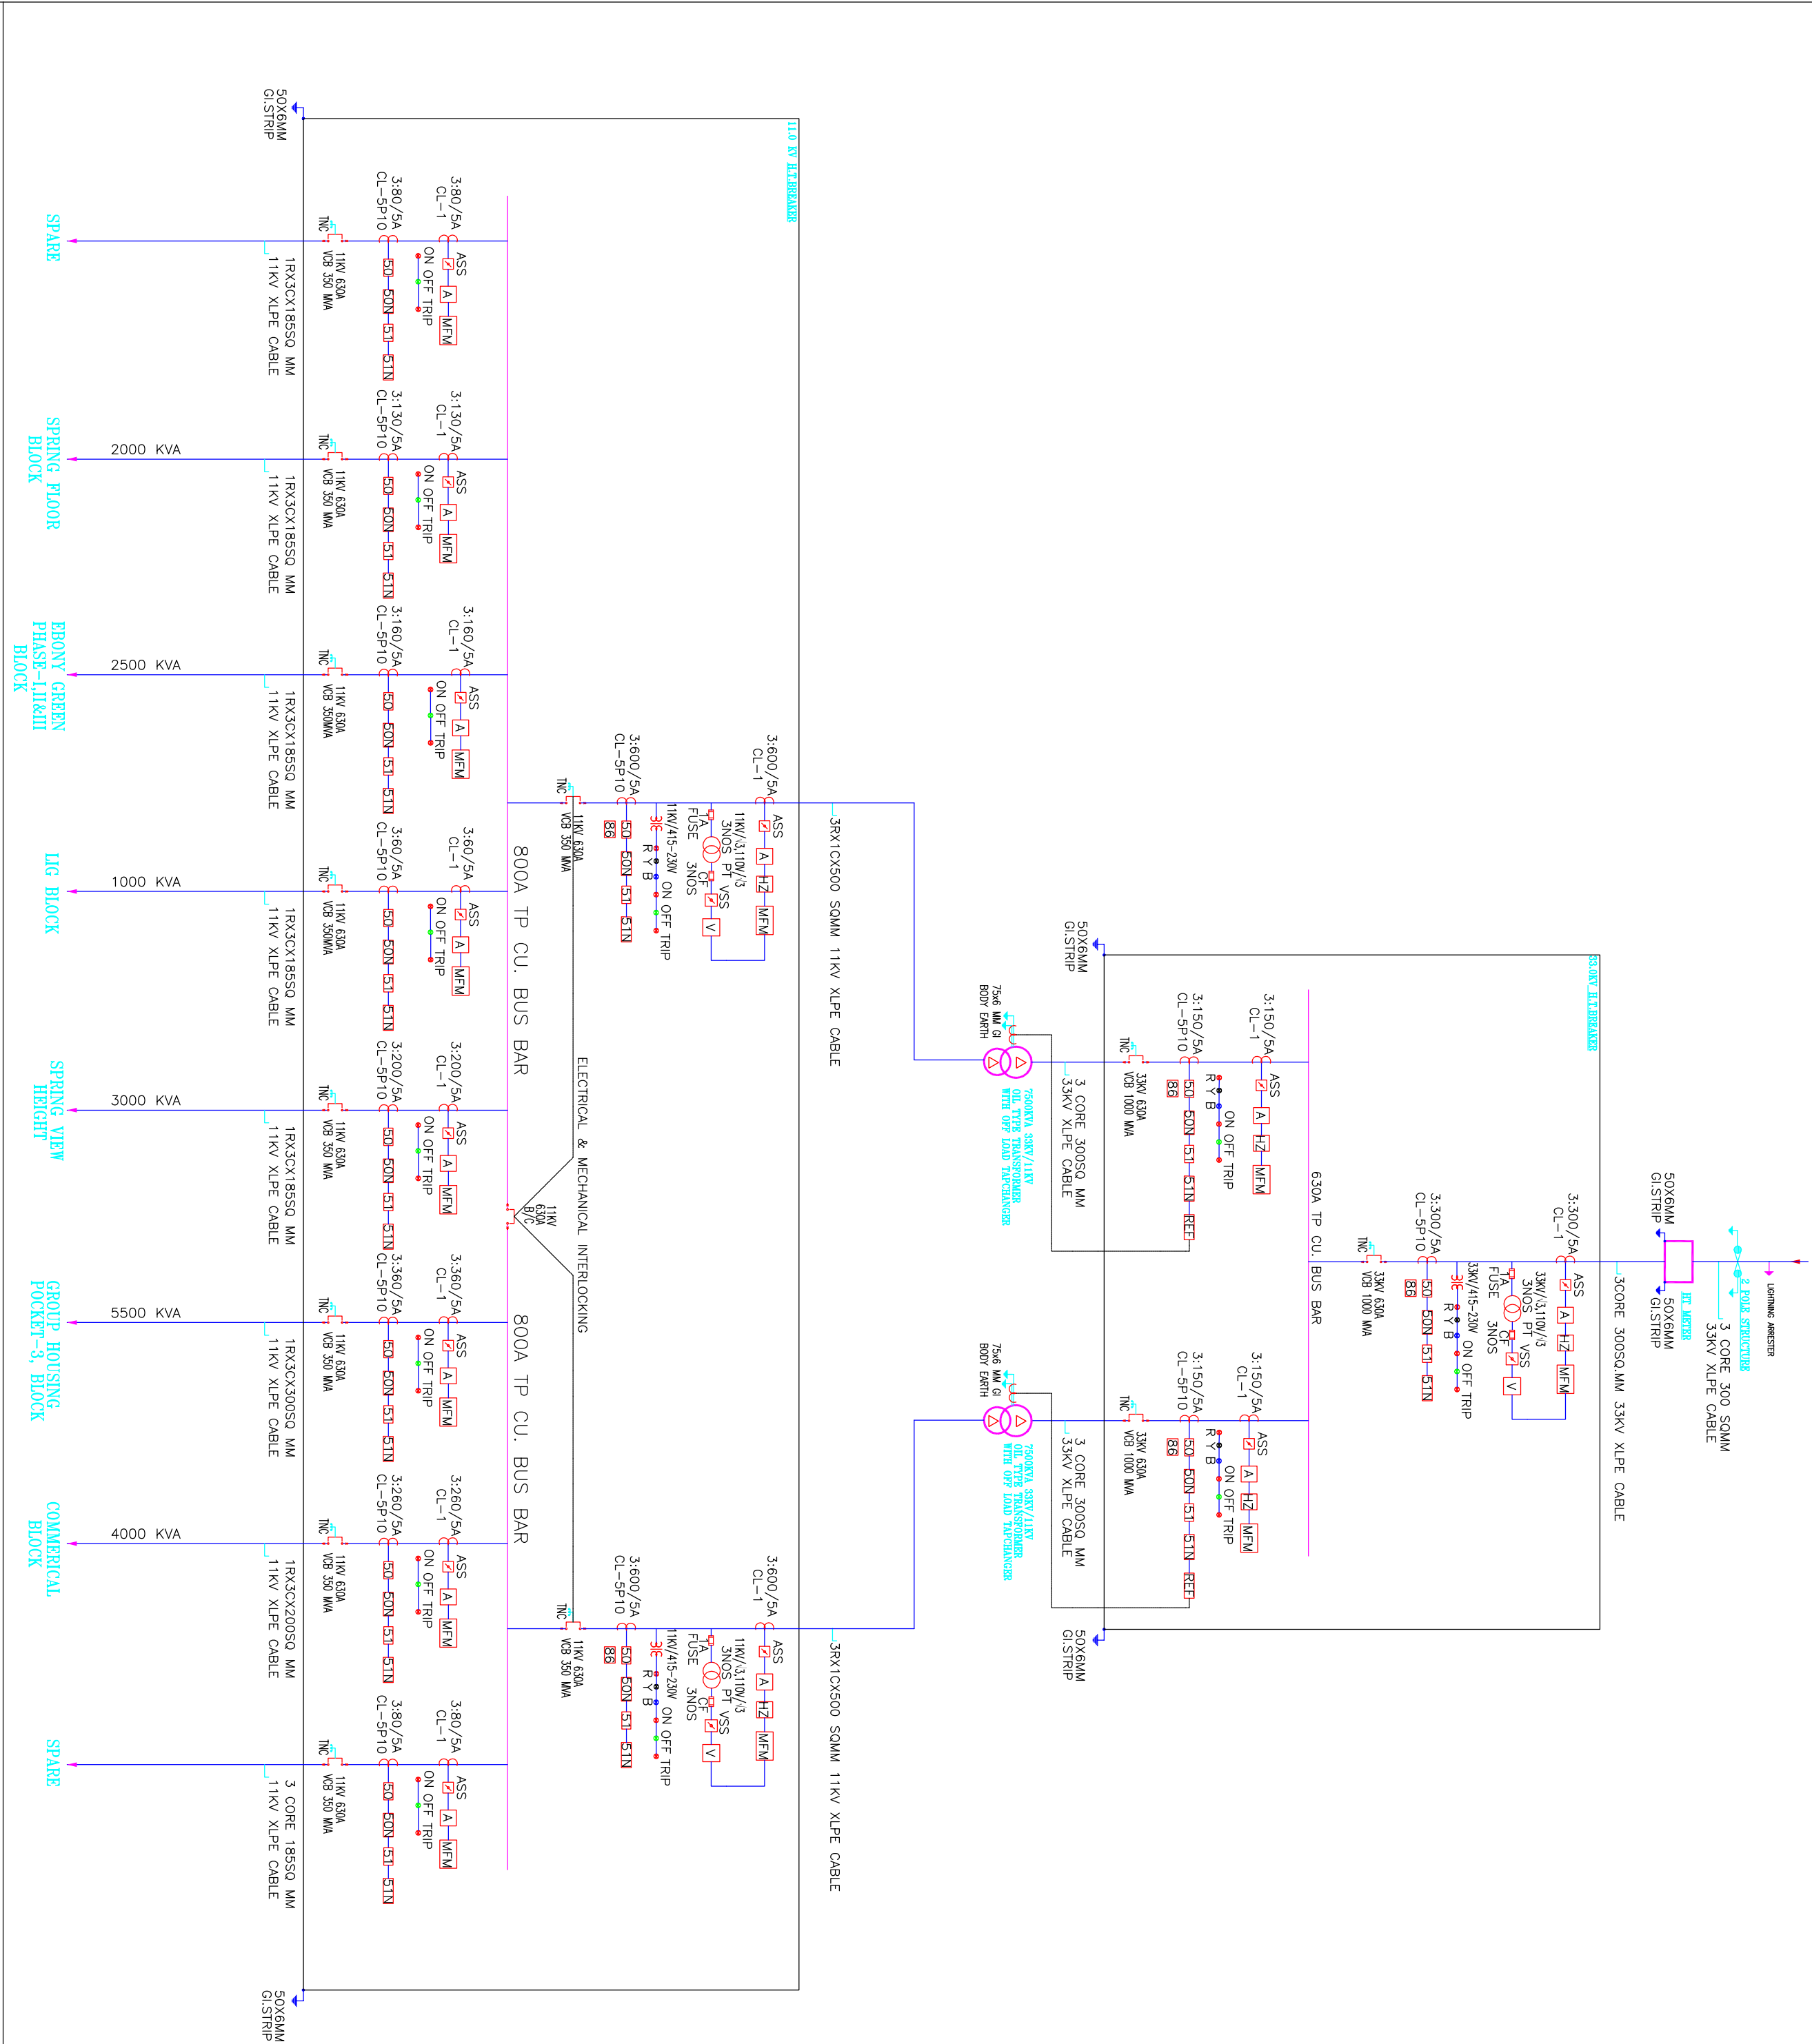

REVISION SCHEDULE			CLIENT:-	PROJECT :-	DRG. TITLE:-			MEP CONSULTANT	
REVISION NO	DESCRIPTION	DATE	SUGGESTED BY	SAAMAG CONSTRUCTION LTD.	INTEGRATED TOWNSHIP	ELECTRICAL SINGLE LINE DIAGRAM			DESIGN CENTRE CONSULTING ENGINEERS
				B-67, Sarita Vihar,	AT VILLAGE SHAHPUR	SCALE:-	DEALT:-	JOB NO:-	PVT. LTD.
				New Delhi, India	BAMHETA, GHAZIABAD	NTS	RAKESH	DCE/851	OFFICE NO. 44 TO 47, 4TH FLOOR
						DATE:-	CHKD. BY:-	DRG. NO:-	ANSAL PLAZA, DABUR CHOWK
						06-06-2014	CHANDRAPAL	DCE/851/01	VAISHALI, GHAZIABAD, UP
									PHONE: 0120-4333451,4333452
									E.MAIL : dce-ps@yahoo.com
									E.MAIL : thdkurpk1967@yahoo.com

