


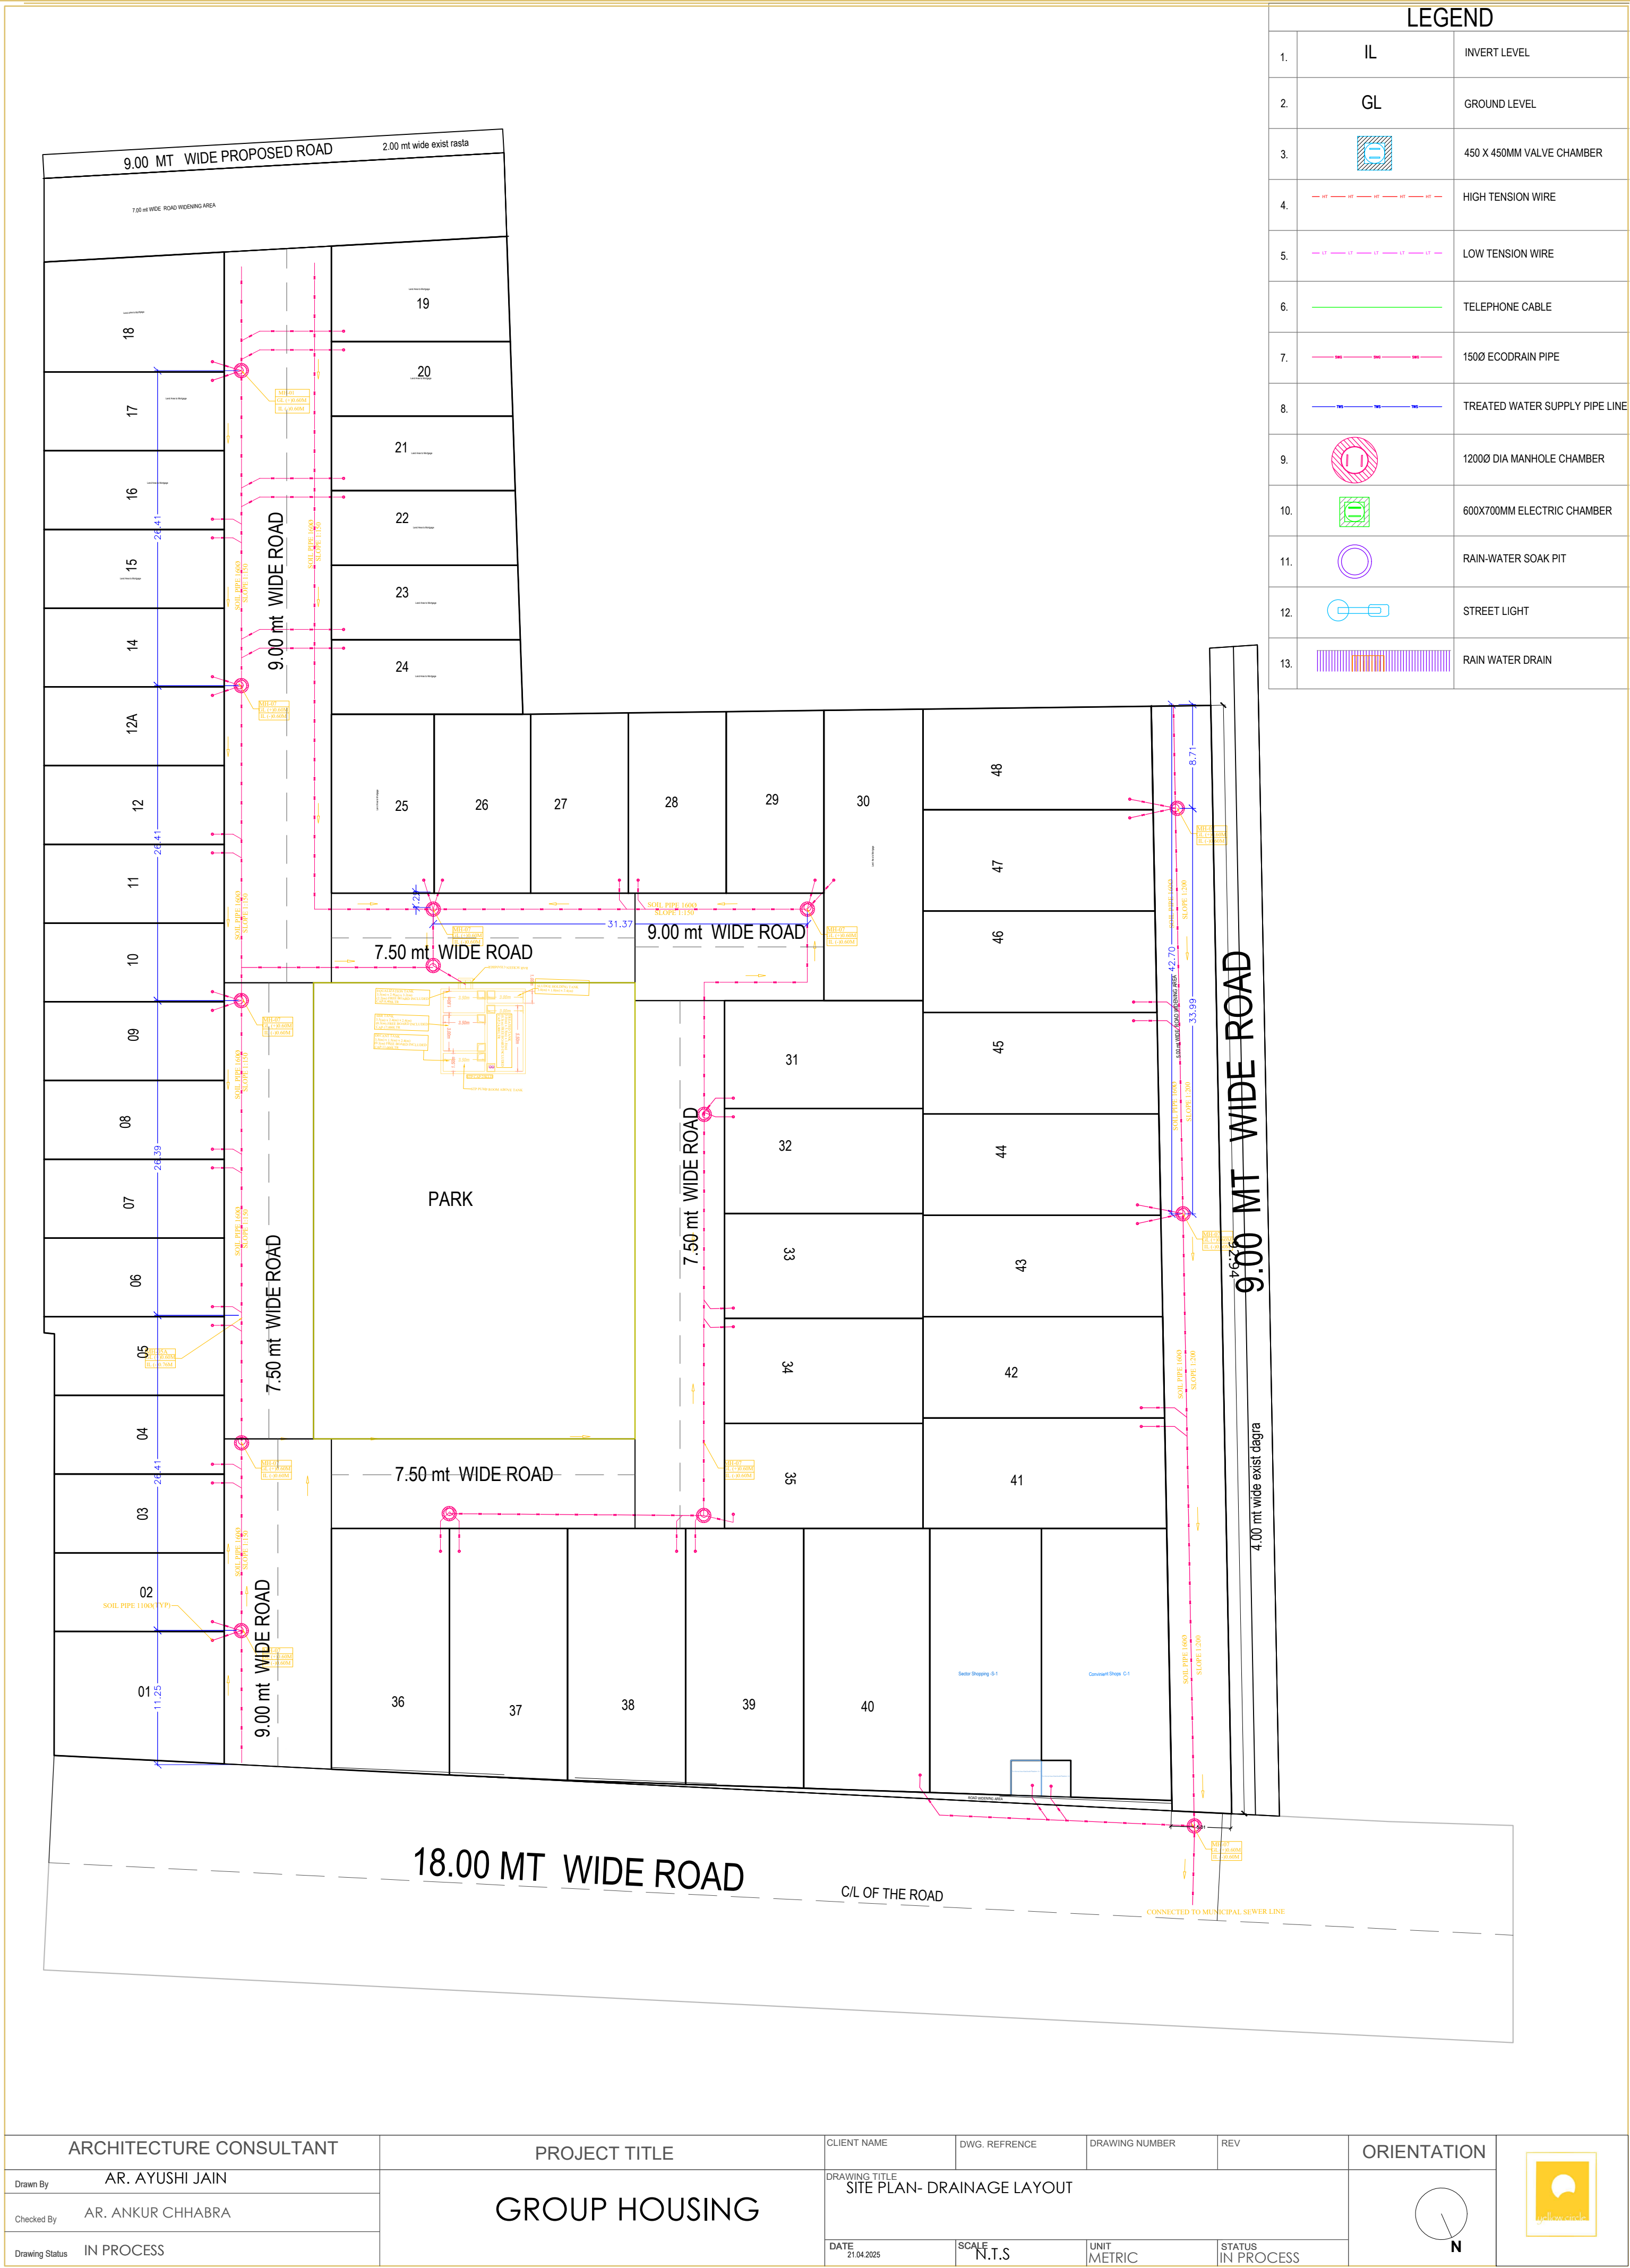

ARCHITECTURE CONSULTANT		PROJECT TITLE		CLIENT NAME	DWG. REFERENCE	DRAWING NUMBER	REV	ORIENTATION	
Drawn By AR. AYUSHI JAIN		GROUP HOUSING		DRAWING TITLE SITE PLAN- DRAINAGE LAYOUT					
Checked By AR. ANKUR CHHABRA									
Drawing Status IN PROCESS				DATE 21.04.2025	SCALE N.T.S	UNIT METRIC	STATUS IN PROCESS		