

प्रारूप-घ (संलग्नक-3)

औपबन्धिक (प्रोविजनल) अनापत्ति प्रमाणपत्र

यूआईडी संख्या: UPFS/2025/161441/GZB/GHAZIABAD/8938/CFO

दिनांक: 13-06-2025

प्रमाणित किया जाता है कि मैसर्स **ASTRUSCORP SUPERSTRUCTURE PRIVATE LIMITED** (भवन/प्रतिष्ठान का नाम) पता **PROPOSED COMMERCIAL BUILDING AT PLOT No. 1G, PINEWOOD ENCLAVE, SECTOR-2, WAVE CITY, GHAZIABAD** तहसील - **GHAZIABAD** प्लॉट एरिया **2225.52 sq.mt** (वर्गमीटर), कुल कवर्ड एरिया **5793.00** (वर्गमीटर), ब्लॉकों की संख्या **1** जिसमें

ब्लॉक/टावर	प्रत्येक ब्लॉक में तलों की संख्या	बेसमेन्ट की संख्या	ऊँचाई
COMMERCIAL BUILDING	3	2	15.00 mt.

है। भवन का अधिभोग मैसर्स **ASTRUSCORP SUPERSTRUCTURE PRIVATE LIMITED** द्वारा किया जायेगा। इनके द्वारा भवन में अग्नि निवारण एवं अग्नि सुरक्षा व्यवस्थाओं का प्राविधान एन0बी0सी0 एवं तत्संबंधी भारतीय मानक ब्यूरो के आई0एस0 के अनुसार किया गया है। इस भवन को औपबन्धिक अनापत्ति प्रमाणपत्र, एन0बी0सी0 की अधिभोग श्रेणी **Mercantile** के अन्तर्गत इस शर्त के साथ निर्गत किया जा रहा है कि प्रस्तावित भवन में अधिभोग श्रेणी के अनुसार सभी अग्निशमन व्यवस्थाओं के मानकों का अनुपालन पूर्ण रूप से किया जायेगा तथा भवन के निर्माण के पश्चात भवन के अधिभोग से पूर्व अग्नि सुरक्षा प्रमाण पत्र प्राप्त किया जायेगा। ऐसा न करने पर निर्गत प्रोविजनल अनापत्ति प्रमाणपत्र स्वतः ही निरस्त मान लिया जायेगा, जिसके लिए मैसर्स **ASTRUSCORP SUPERSTRUCTURE PRIVATE LIMITED** अधिभोगी पूर्ण रूप से जिम्मेदार होगा/होंगे।

Note : -

"यह प्रमाण-पत्र आपके द्वारा प्रस्तुत अभिलेखों, सूचनाओं के आधार पर निर्गत किया जा रहा है। इनके असत्य पाए जाने पर निर्गत प्रमाण-पत्र मान्य नहीं होगा। यह प्रमाण-पत्र भूमि / भवन के स्वामित्व / अधिभोग को प्रमाणित नहीं करता है।"

Note : -

निर्गत किये जाने का दिनांक : 17-06-2025
स्थान : GHAZIABAD


हस्ताक्षर (निर्गमन अधिकारी)
(मुख्य अग्निशमन अधिकारी)




Digitally Signed By
(Rahul Pal)

[AC551D1C1977602518FD17F7DCFBA9B10AD96EDA]

17-06-2025

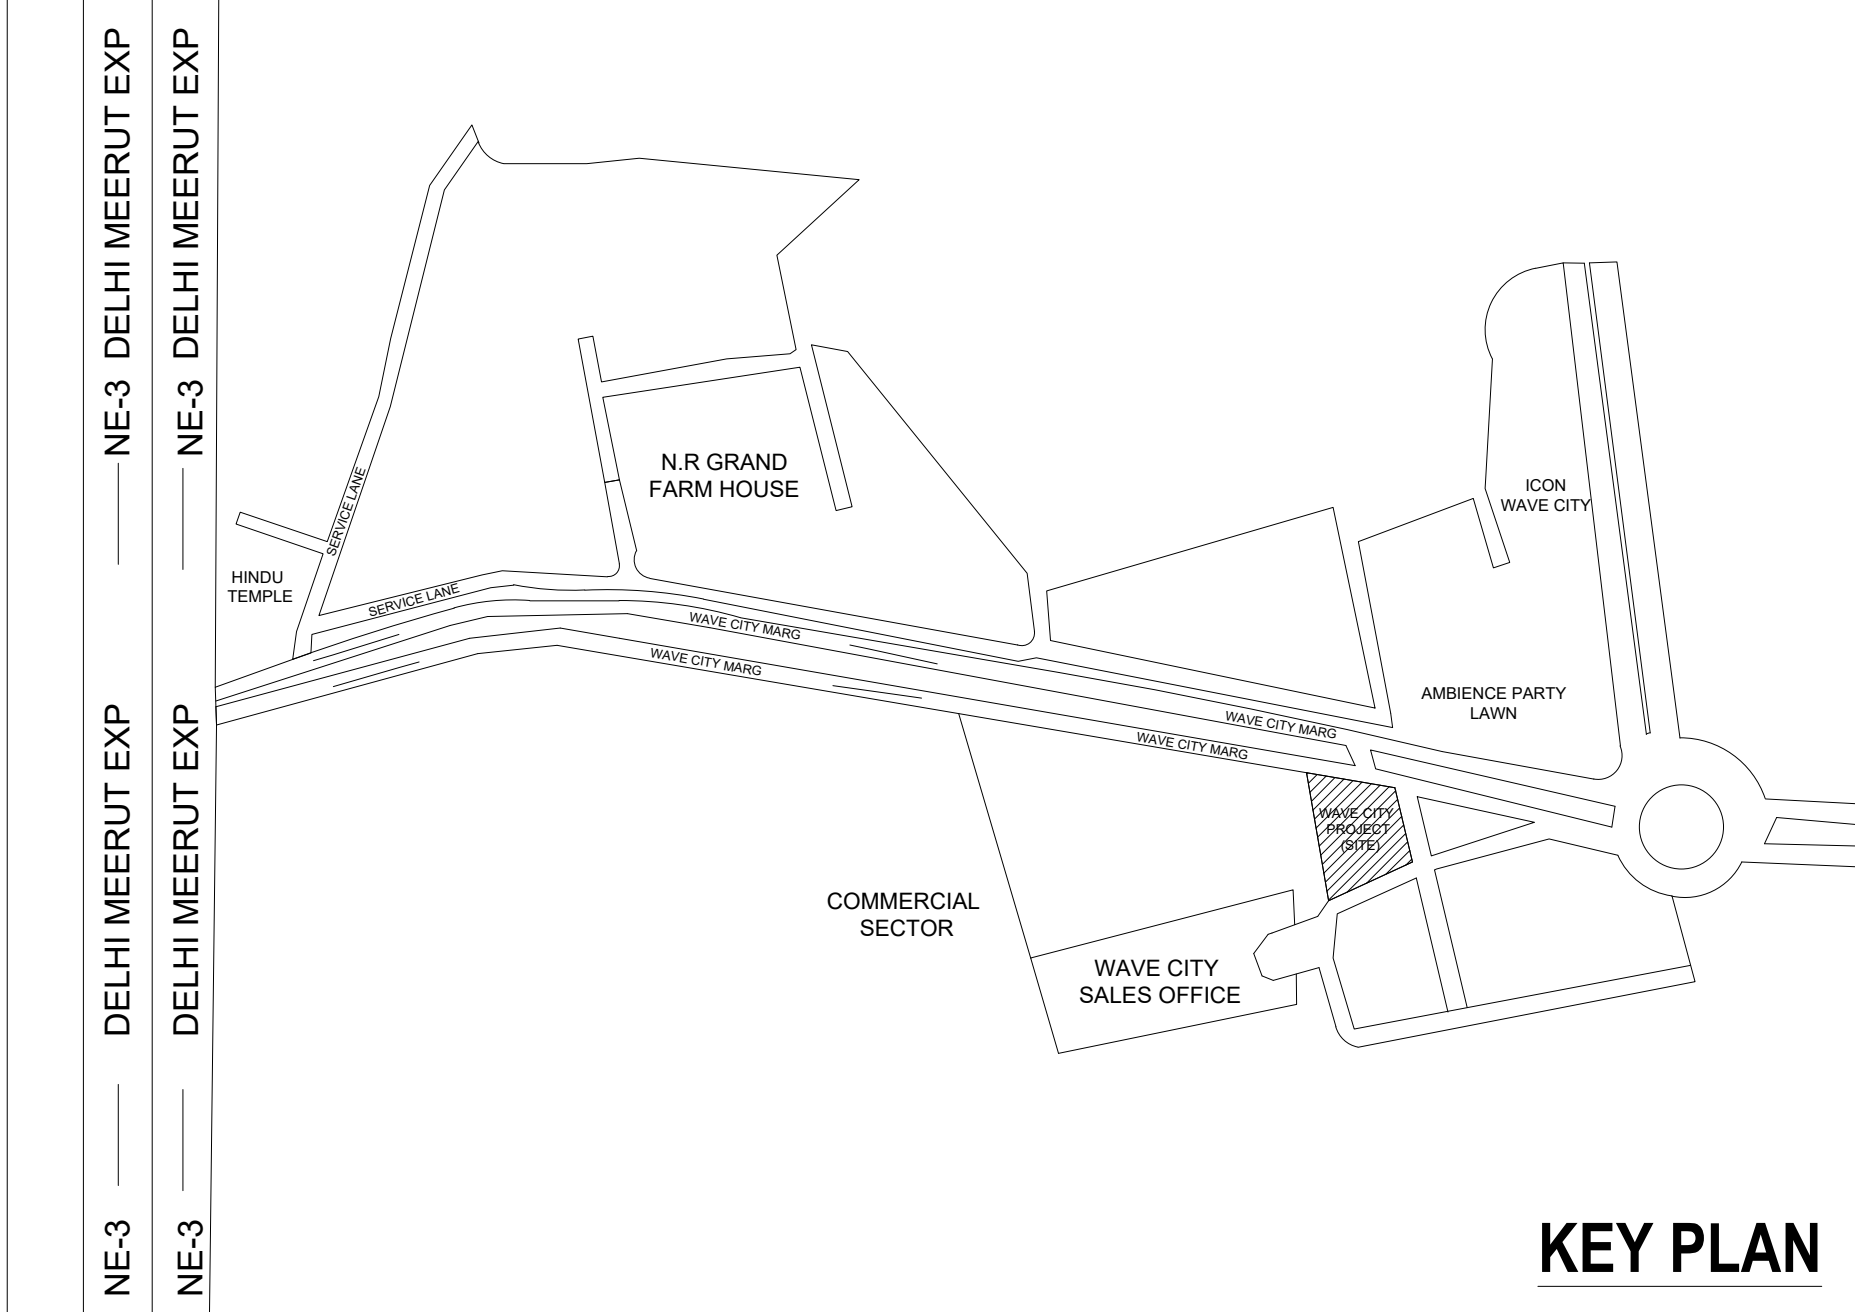

KEY PLAN

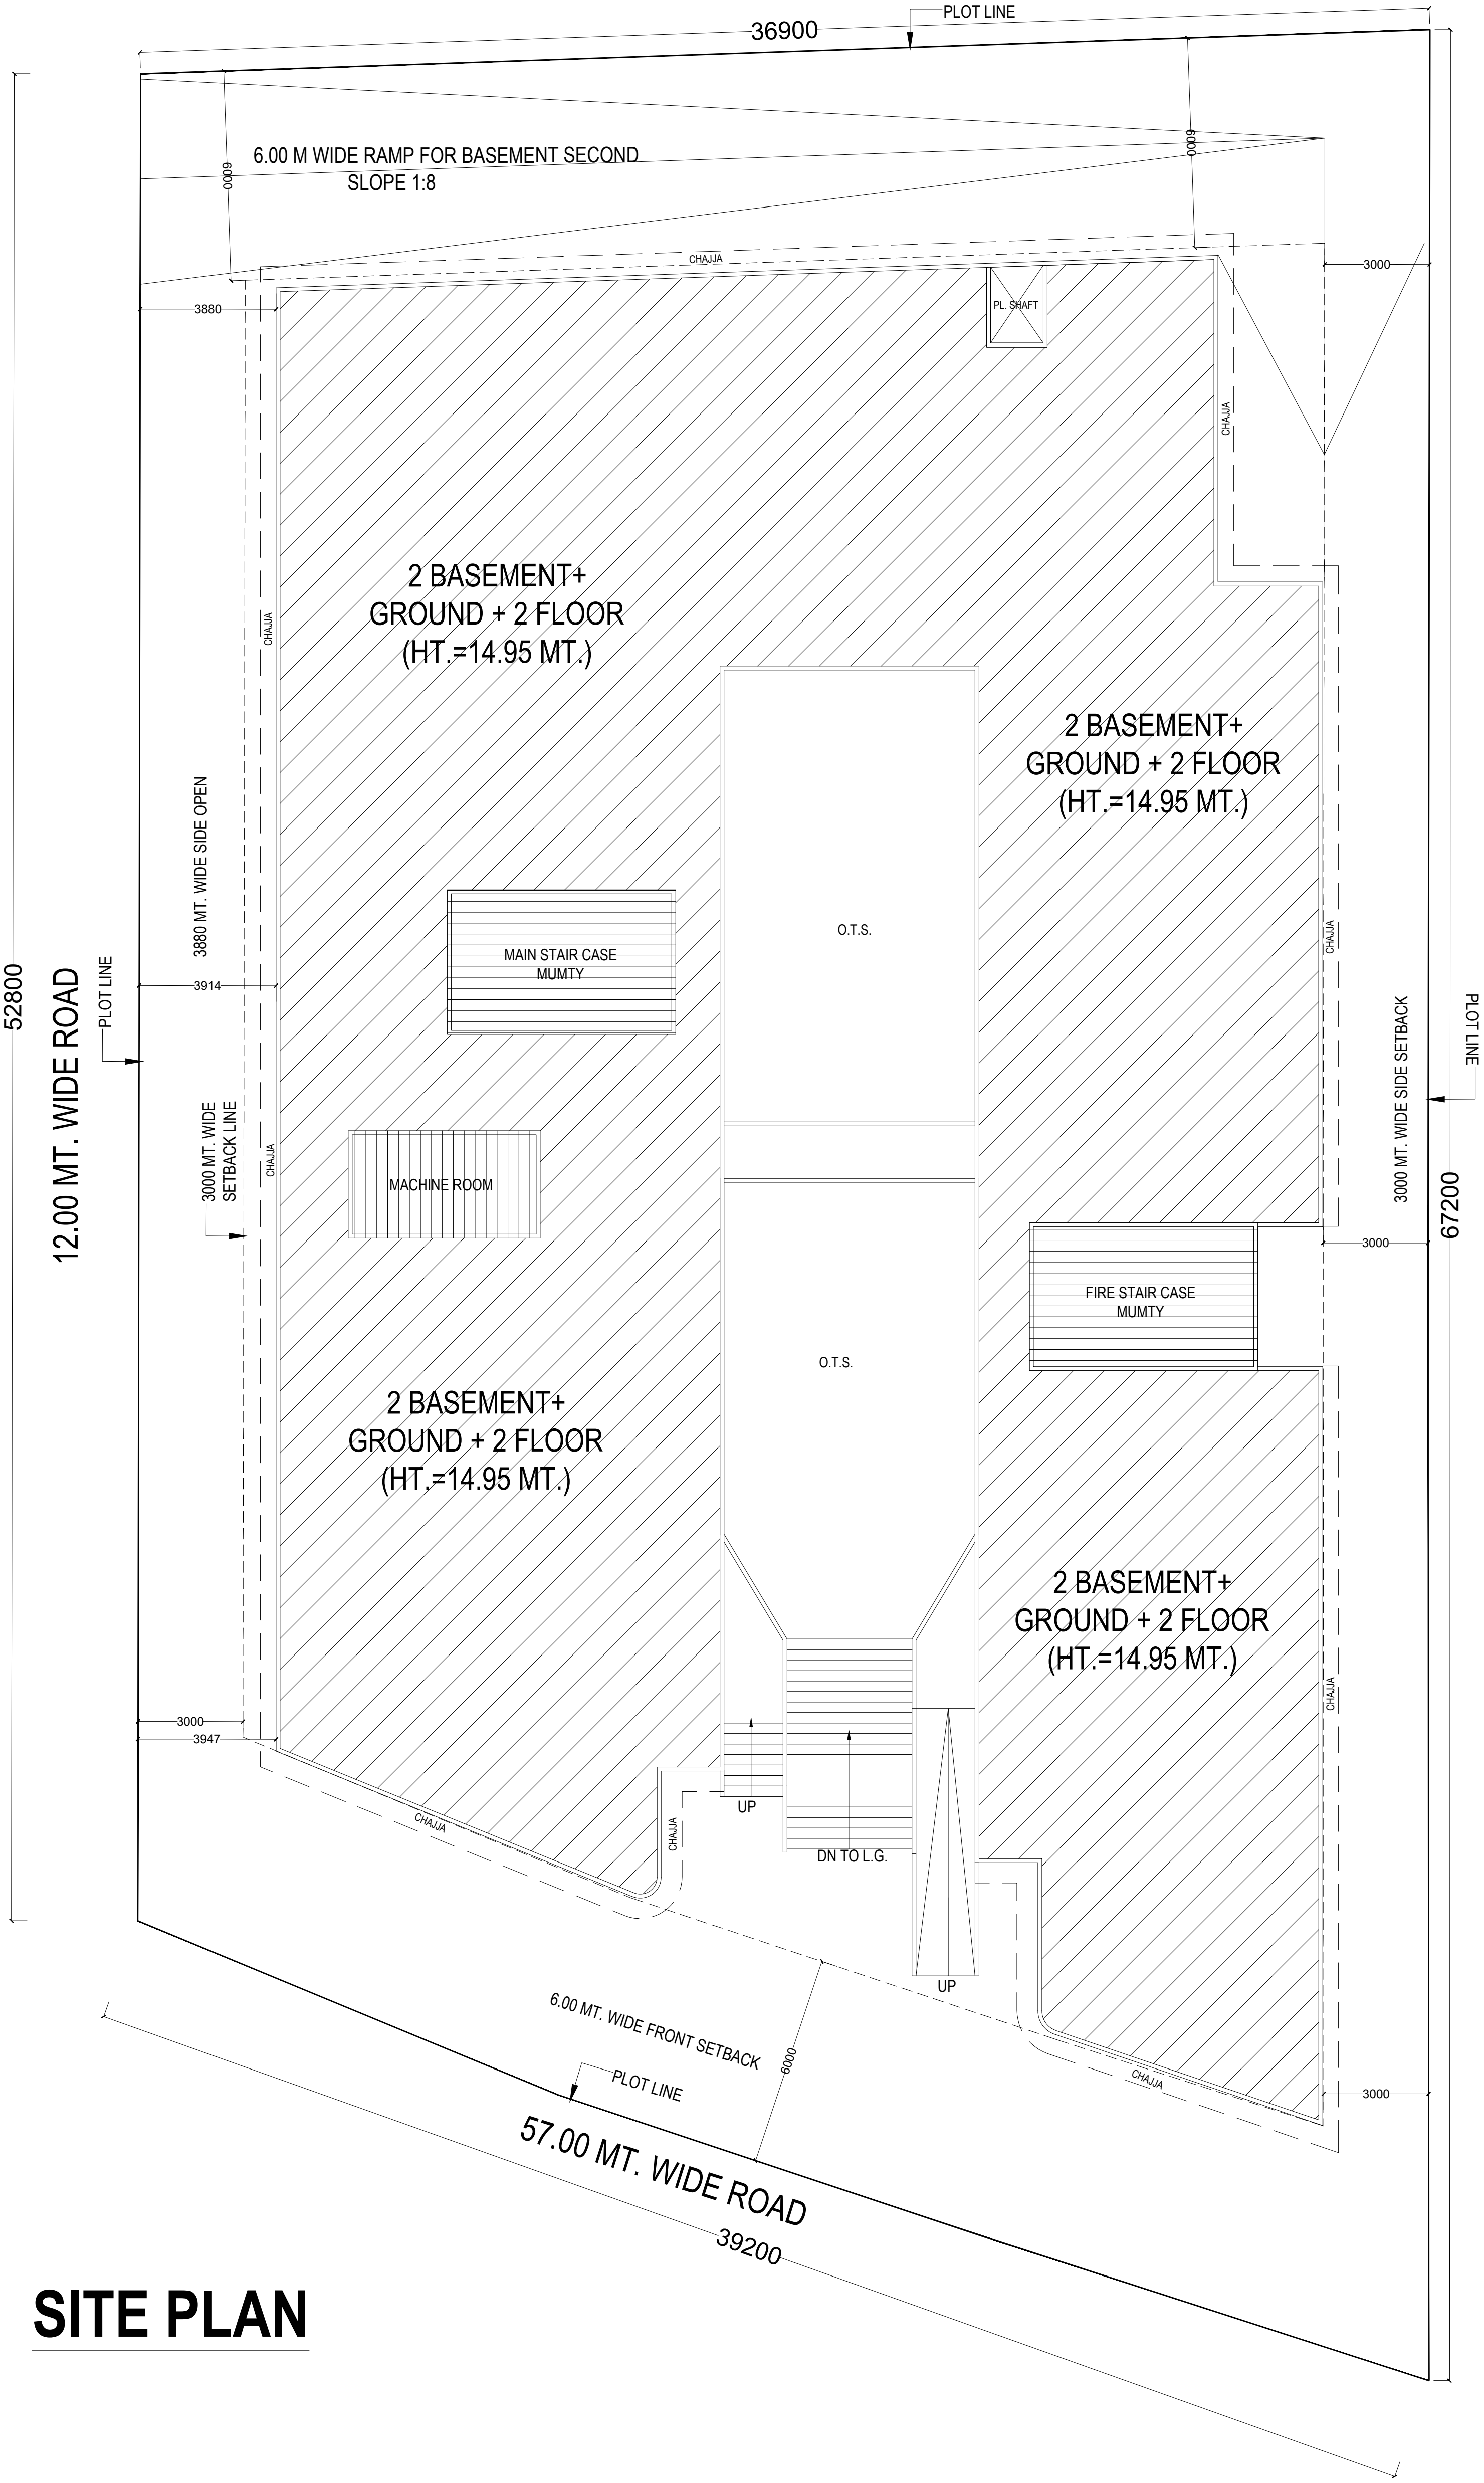

SITE PLAN

AREA STATEMENT			
S. NO.	PARTICULARS		AREA IN SQ.MT.
1	TOTAL PLOT AREA		2225.52
2	PERMISSIBLE GROUND COVERAGE =50% OF PLOT AREA		1112.76
3	PROPOSED GROUND COVERAGE	49.98%	1112.26
4	PERMISSIBLE F.A.R. AREA 2225.52 X 2.50 = 5563.80 SQ.MT.		5563.80
5	PROPOSED F.A.R. AREA	1.995	4440.59
	A	BASEMENT-01 F.A.R. AREA = 1153.81	
	B	GROUND FL. F.A.R. AREA = 1112.26	
	C	FIRST FL. F.A.R. AREA = 1087.26	
	D	SECOND FL. F.A.R. AREA = 1087.26	
	TOTAL F.A.R. AREA (A+B+C+D) = 4440.59		
6	PROPOSED NON F.A.R. AREA		1362.37
	A	BASEMENT-02 NON F.A.R. AREA = 1187.60	
	B	FIRE STAIR CASE & LIFT WELL NON F.A.R. AREA = 174.77 SQ.MT.	
	TOTAL F.A.R. AREA (A+B) = 1362.37		
7	TOTAL PROPOSED BUILT-UP AREA		5802.96
	A	PROPOSED F.A.R. AREA = 4440.59	
	B	PROPOSED NON F.A.R. AREA = 1362.37	
	TOTAL F.A.R. AREA (A+B) = 5802.96		
8	REQUIRED PARKING = F.A.R. AREA/100 X0.5 = 4440.59 /100 X1.25 = 55.50 CARS		56 CARS
9	PROPOSED PARKING IN BASEMENT-02 (MECHANICAL PARKING)		60 CARS

Rev. no.	Date	

Project
**PROPOSED COMMERCIAL BUILDING AT
COMMERCIAL PLOT NO. 1G, PINWOOD
ENCLAVE, SECTOR-2, WAVE CITY, GZB.**

Title
SITE PLAN

Subtitle
FIRE FIGHTING LAYOUT

drawing released for

☐ APPROVAL☐ SUBMISSION

☐ ADVANCE COPY☐ CONSTRUCTION

drg. no. FF-1ST.BF-01

drawn by: HIMANSHU

scale NTS

designed by: HIMANSHU

date 07.06.2025

checked by: D.K.

Architects

DIVYAKASH
ATELIER INC

ARCHITECTURAL . INTERIOR . PLANNING
CONSULTANTS

407, ORBIT PLAZA, CROSSING REPUBLIK, GHAZIABAD
CONTACT US - +91- 999609559
E mail- groupdivyakash@gmail.com

MEP Consultant:



WeDESIGN Associates

"Engineered to perfection"

Email - wedesignassociates@gmail.com

Mob. - 9999288416, 9999288407, 9882244495





LEGEND FOR FIRE FIGHTING:-	
FHC	FIRE HOSE CABINET
	PENDENT TYPE SPRINKLER
	9 Ltr. WATER GAS PRESSURE TYPE FIRE EXTINGUISHER
	4.5 kg CO ² TYPE FIRE EXTINGUISHER
	BUTTER FLY VALVE
	FLOW INDICATING SWITCH

S. NO.	NOTES :- (FOR SPRINKLER SYSTEM)															
1.	ALL SPRINKLER PIPE LINE SHALL BE SUSPENDED FROM CEILING THROUGH G. I. HANGERS OF MIN. 3mm THICK MEMBERS ALONG WITH ANCHOR FASTNERS.															
2.	<u>PIPE MATERIAL</u> - SPRINKLER PIPE - MS (CLASS C) HEAVY DUTY - DRAIN PIPE - G. I. (CLASS B) MEDIUM DUTY															
3.	<u>JOINING OF PIPE</u> a) UP TO 40 MM DIA - SCREW JOINT b) 50 MM & ABOVE DIA - WELDED JOINT															
4.	ALL FIRE PIPING ACCESSORIES SHOULD BE PAINTED BY FIRE RED COLOUR (SHADE NO. 536 AS PER IS : 5)															
5.	EXPANSION BELLOW IS TO BE USED AT ALL PLACES IN HYDRANT AND SPRINKLER PIPING WHERE, THE PIPE PASSES THROUGH BUILDING EXPANSION JOINT.															
6.	ANY MODIFICATION REQD. ARE CARRIED OUT AT SITE TO SUIT SITE CONDITION IN CONSULTATION WITH SITE IN-CHARGE.															
7.	ALL PIPE SIZES ARE IN MM. AND NOMINAL DIA . ONLY															
8.	THE SPACING OF FIRE PIPE SUPPORTS FOR SPRINKLER / CLEVIS HANGER SHALL NOT BE MORE THAN THAT SPECIFIED BELOW:-															
<table><tr><th>Nominal pipes diameter (mm)</th><th>Spacing between suppts (meter)</th><th>Support / Hanger rod diameter (mm)</th></tr><tr><td>Up to 25</td><td>2.00</td><td>8</td></tr><tr><td>32 to 50</td><td>2.50</td><td>8</td></tr><tr><td>65 to 80</td><td>2.50</td><td>10</td></tr><tr><td>100</td><td>2.50</td><td>12</td></tr></table>		Nominal pipes diameter (mm)	Spacing between suppts (meter)	Support / Hanger rod diameter (mm)	Up to 25	2.00	8	32 to 50	2.50	8	65 to 80	2.50	10	100	2.50	12
Nominal pipes diameter (mm)	Spacing between suppts (meter)	Support / Hanger rod diameter (mm)														
Up to 25	2.00	8														
32 to 50	2.50	8														
65 to 80	2.50	10														
100	2.50	12														
NOTE :- 1)EXTRA SUPPORTS SHALL BE PROVIDED AT THE BENDS AND AT HEAVY FITTINGS LIKE VALVES TO AVOID UNDUE STRESS ON THE PIPES. 2)THE THICKNESS OF CLAMP SHOULD BE MINIMUM 3mm																
9.	THE SUPPORT FOR 150 / 200mm DIA. PIPE SHALL BE BY 50x50x6mm MS ANGLE IRON @ 3.0 M. C/C (MAXIMUM).															
10.	THE SUPPORT DRILLING FOR FIRE PIPE HAS TO BE CO-ORDINATED WITH ELECTRICAL / FIRE ALARM / LV DRAWING TO AVOID ANY DAMAGE IN CONDUIT.															



BASEMENT-2 FLOOR PLAN

LEGEND:-		
S.NO.	DESCRIPTION	SYMBOL
	FIRE HOSE CABINET	
	FIRE HOSE CABINET COMPRISING OF:	
1. a.	1 NO. S.S.LANDING VALVE	
b.	1 NO. HOSE REEL DRUM WITH 30mtr. RUBBER HOSE	
c.	2 NOS. 15mtr. LONG RRL HOSE	
d.	1 NO. S.S.BRANCH PIPE	
e.	1 NO. 9 LTR WATER TYPE FIRE EXTINGUISHERS	
f.	1 NO. 5KG ABC TYPE FIRE EXTINGUISHERS	

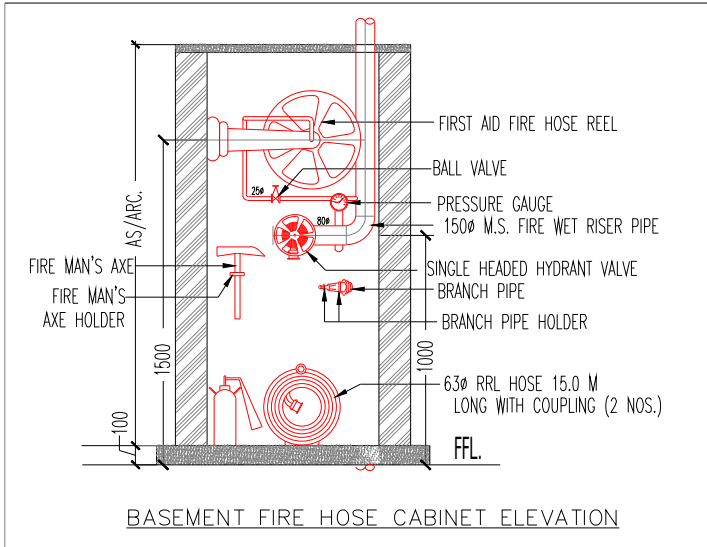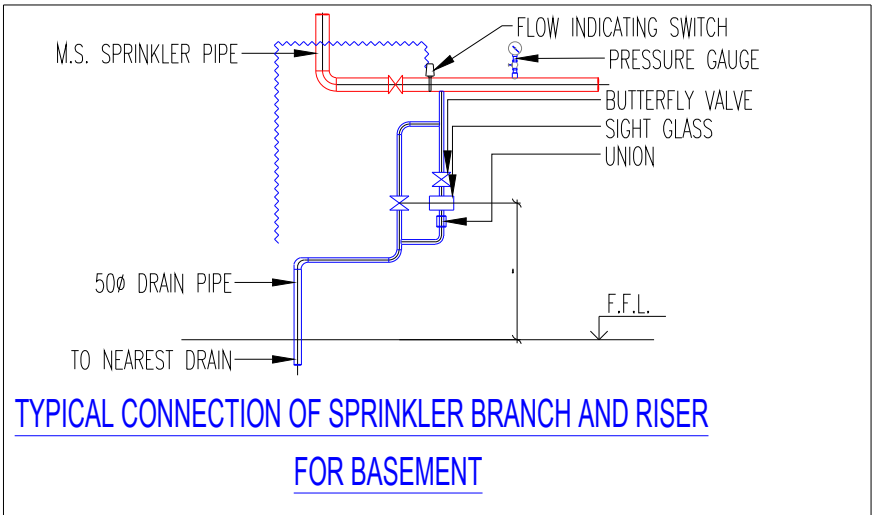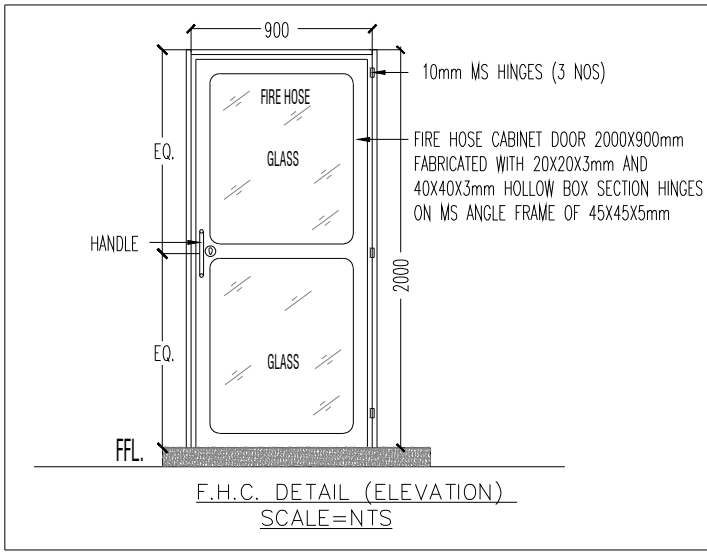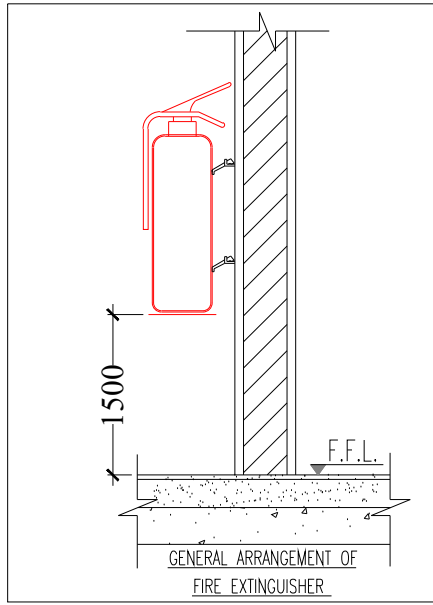

Rev. no.	Date

Project
**PROPOSED COMMERCIAL BUILDING AT
COMMERCIAL PLOT NO. 1G, PINWOOD
ENCLAVE, SECTOR-2, WAVE CITY, GZB.**

Title
BASEMENT ROOF LAYOUT

Subtitle
FIRE FIGHTING LAYOUT

drawing released for
☐ APPROVAL ☐ SUBMISSION
☐ ADVANCE COPY ☐ CONSTRUCTION

drg. no. FF-1ST.BF-01 drawn by: HIMANSHU


scale NTS designed by: HIMANSHU

date 07.06.2025 checked by: D.K.

Architects
**DIVYAKASH
ATELIER INC**
ARCHITECTURAL . INTERIOR . PLANNING
CONSULTANTS
407, ORBIT PLAZA, CROSSING REPUBLIK, GHAZIABAD
CONTACT US :- +91-9999609559
E mail- groupdivyakash@gmail.com

MEP Consultant:-

WeDESIGN Associates
"Engineered to perfection"
Email - wedesignassociates@gmail.com
Mob. - 9999288416, 9999288407, 9882244495

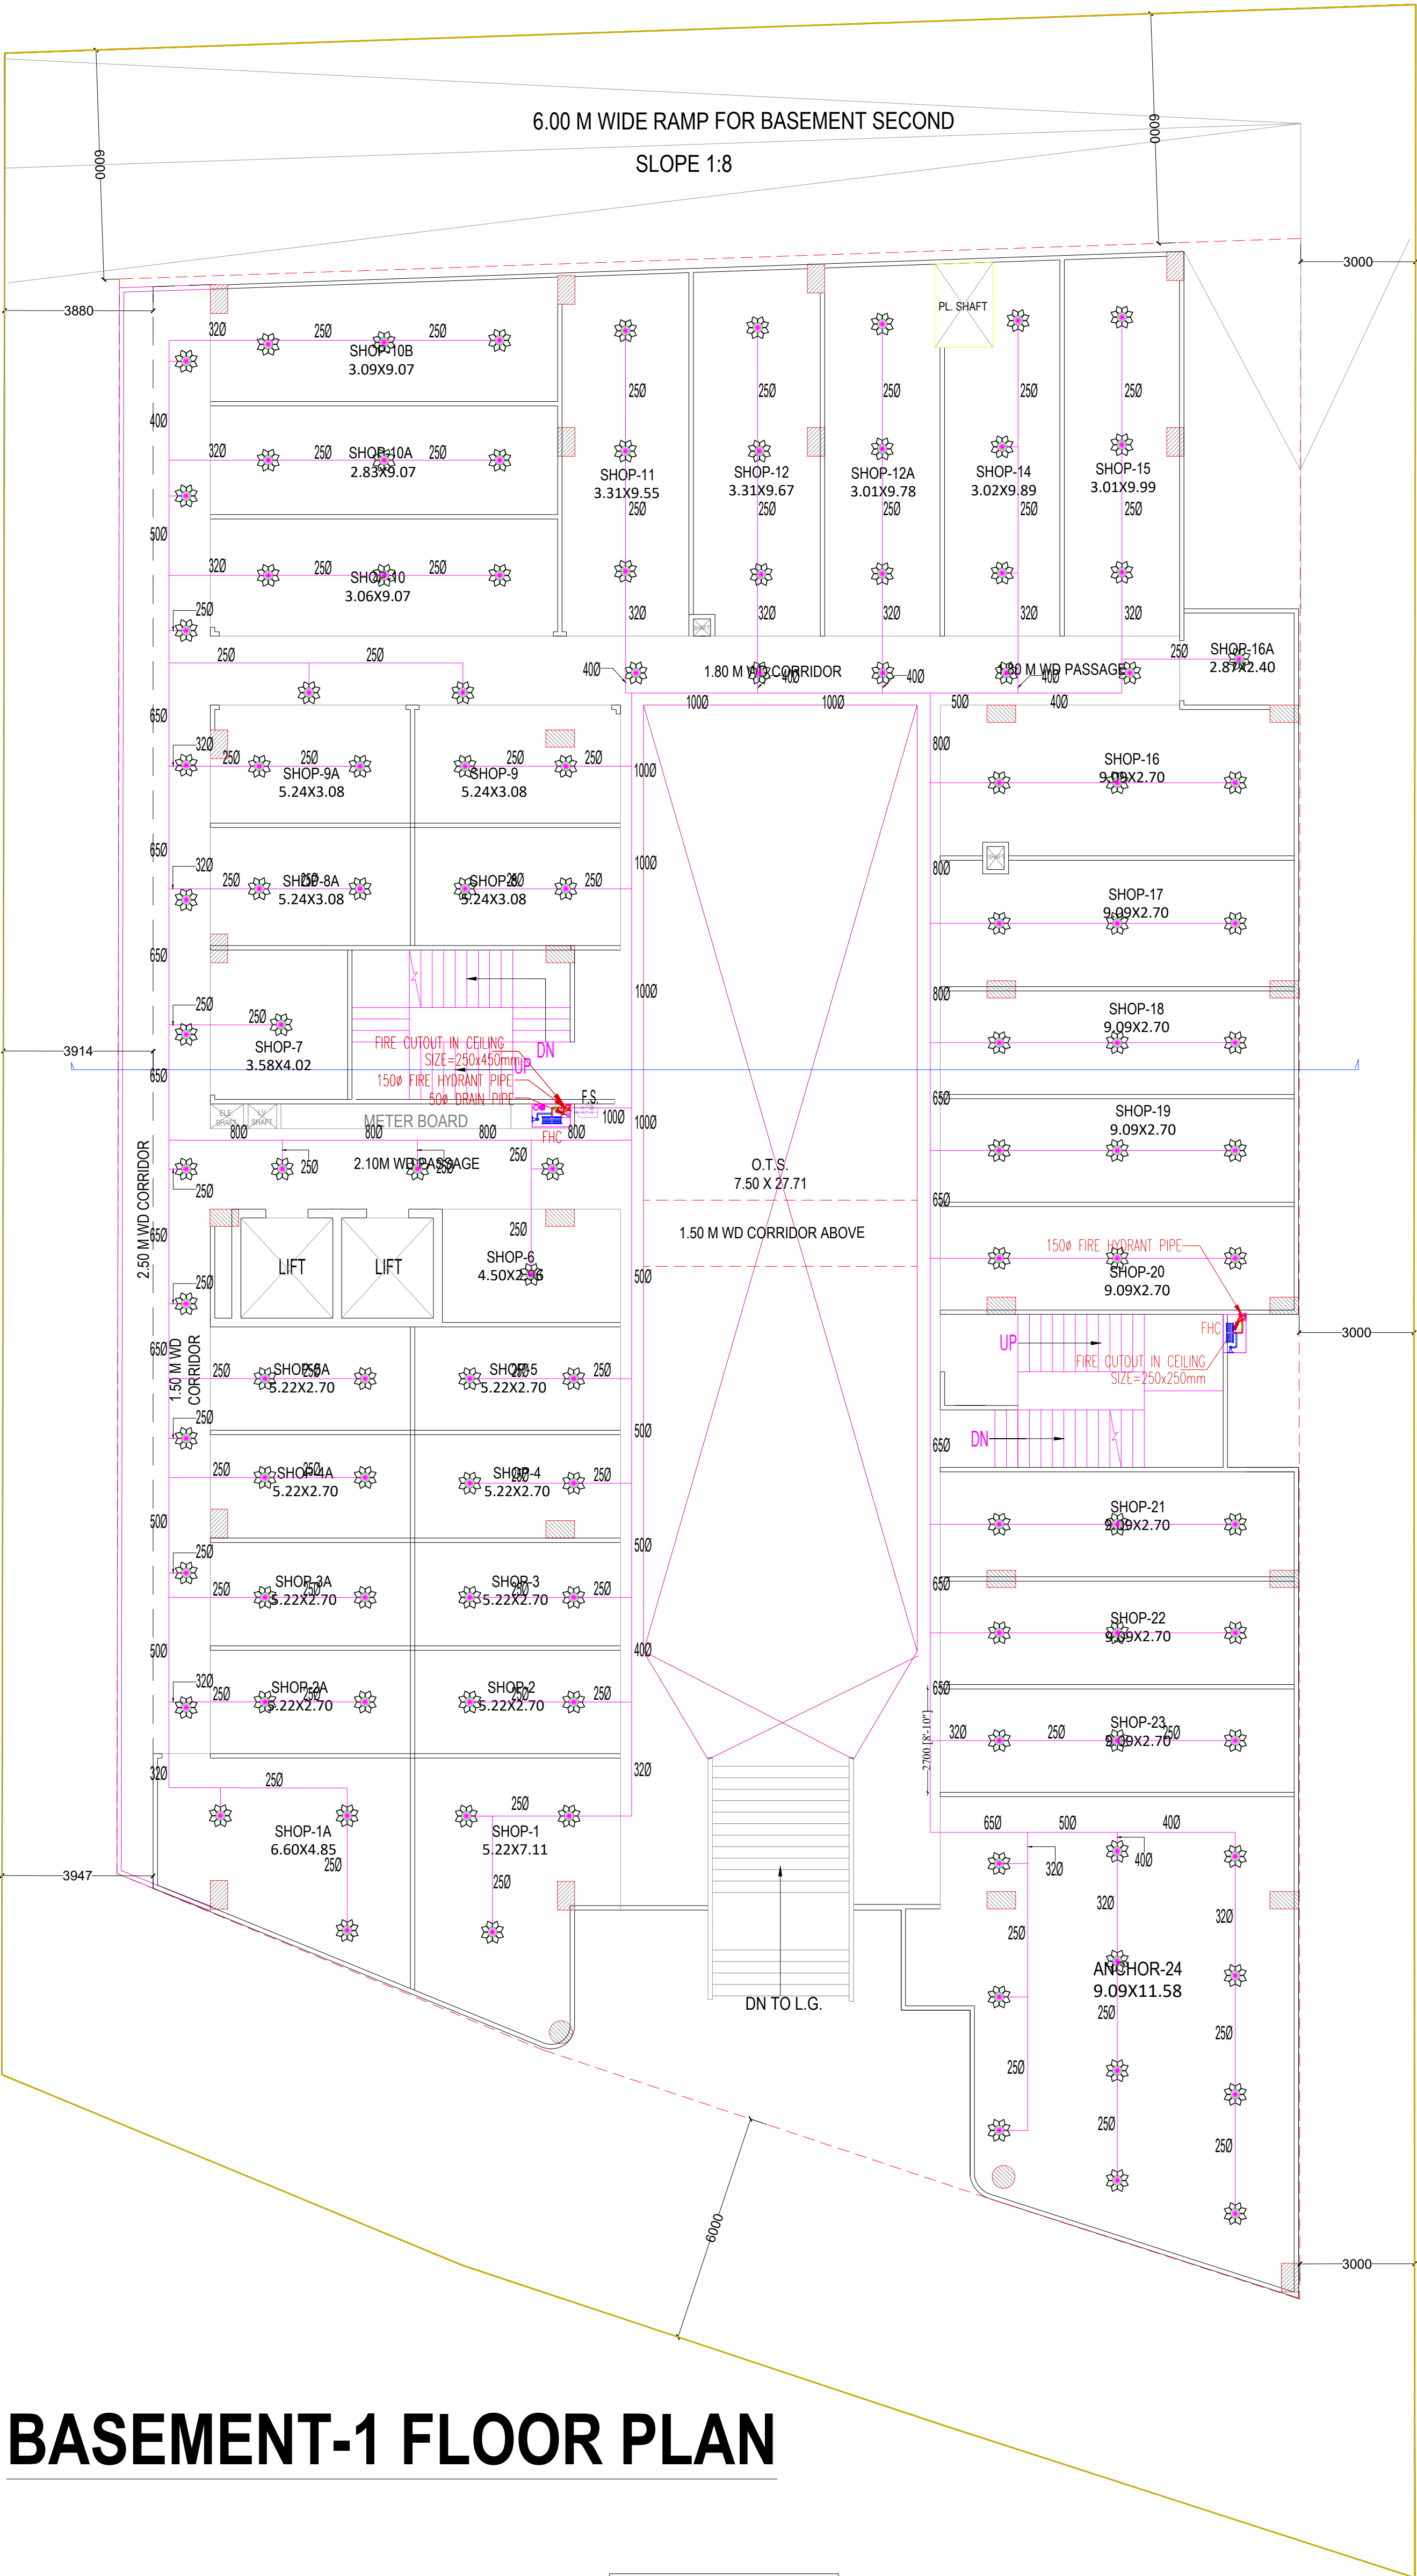

BASEMENT-1 FLOOR PLAN

LEGEND FOR FIRE FIGHTING:-

FHC	FIRE HOSE CABINET
	PENDENT TYPE SPRINKLER
	9 Ltr. WATER GAS PRESSURE TYPE FIRE EXTINGUISHER
	4.5 kg CO ² TYPE FIRE EXTINGUISHER
	BUTTER FLY VALVE
	FLOW INDICATING SWITCH

NOTES :- (FOR SPRINKLER SYSTEM)

- ALL SPRINKLER PIPE LINE SHALL BE SUSPENDED FROM CEILING THROUGH G. I. HANGERS OF MIN. 3mm THICK MEMBERS ALONG WITH ANCHOR FASTNERS.
- PIPE MATERIAL - SPRINKLER PIPE - MS (CLASS C) HEAVY DUTY
- DRAIN PIPE - G. I. (CLASS B) MEDIUM DUTY
- JOINING OF PIPE
a) UP TO 40 MM DIA - SCREW JOINT
b) 50 MM & ABOVE DIA - WELDED JOINT
- ALL FIRE PIPING ACCESSORIES SHOULD BE PAINTED BY FIRE RED COLOUR (SHADE NO. 536 AS PER IS : 5)
- EXPANSION BELLOW IS TO BE USED AT ALL PLACES IN HYDRANT AND SPRINKLER PIPING WHERE, THE PIPE PASSES THROUGH BUILDING EXPANSION JOINT.
- ANY MODIFICATION REQD. ARE CARRIED OUT AT SITE TO SUIT SITE CONDITION IN CONSULTATION WITH SITE IN-CHARGE.
- ALL PIPE SIZES ARE IN MM. AND NOMINAL DIA . ONLY
- THE SPACING OF FIRE PIPE SUPPORTS FOR SPRINKLER / CLEVIS HANGER SHALL NOT BE MORE THAN THAT SPECIFIED BELOW:-

Nominal pipes diameter (mm)	Spacing between supports (meter)	Support / Hanger rod diameter (mm)
Up to 25	2.00	8
32 to 50	2.50	8
65 to 80	2.50	10
100	2.50	12

NOTE :- 1)EXTRA SUPPORTS SHALL BE PROVIDED AT THE BENDS AND AT HEAVY FITTINGS LIKE VALVES TO AVOID UNDUE STRESS ON THE PIPES.
2)THE THICKNESS OF CLAMP SHOULD BE MINIMUM 3mm

- THE SUPPORT FOR 150 / 200mm DIA. PIPE SHALL BE BY 50x50x6mm MS ANGLE IRON @ 3.0 M. C/C (MAXIMUM).
- THE SUPPORT DRILLING FOR FIRE PIPE HAS TO BE CO-ORDINATED WITH ELECTRICAL / FIRE ALARM / LV DRAWING TO AVOID ANY DAMAGE IN CONDUIT.

Rev. no.

Date

Project

**PROPOSED COMMERCIAL BUILDING AT
COMMERCIAL PLOT NO. 1G, PINWOOD
ENCLAVE, SECTOR-2, WAVE CITY, GZB.**

Title

LOWER GROUND ROOF LAYOUT

Subtitle

FIRE FIGHTING LAYOUT

drawing released for



APPROVAL



SUBMISSION



ADVANCE COPY



CONSTRUCTION

drg. no.

FF-LGF-01

drawn by: HIMANSHU

scale

NTS

designed by: HIMANSHU

date

07.06.2025

checked by: D.K.

Architects

**DIVYAKASH
ATELIER INC**
ARCHITECTURAL . INTERIOR . PLANNING
CONSULTANTS

407, ORBIT PLAZA, CROSSING REPUBLIK, GHAZIABAD
CONTACT US :- +91-9999609559
E mail- groupdivyakash@gmail.com

MEP Consultant:



WeDESIGN Associates
"Engineered to perfection"





Email - wedesignassociates@gmail.com
Mob. - 9999288416, 9999288407, 9882244495

LEGEND:-


S.NO.	DESCRIPTION	SYMBOL
	FIRE HOSE CABINET	FHC
	FIRE HOSE CABINET COMPRISING OF:	
1. a.	1 NO. S.S.LANDING VALVE	
b.	1 NO. HOSE REEL DRUM WITH 30mtr. RUBBER HOSE	
c.	2 NOS. 15mtr. LONG RRL HOSE	
d.	1 NO. S.S.BRANCH PIPE	
e.	1 NO. 9 LTR WATER TYPE FIRE EXTINGUISHERS	
f.	1 NO. 5KG ABC TYPE FIRE EXTINGUISHERS	

NOTES : (FOR SPRINKLER SYSTEM)



- THE SIZE OF RANGE SPRINKLER PIPES SHALL BE AS HERE UNDER :-
a) 25ø 1 & 2-SPRINKLER
b) 32ø 3 - SPRINKLER
c) 40ø 4 & 5-SPRINKLER
d) 50ø 6 TO 10-SPRINKLER
e) 65ø 11 TO 27-SPRINKLER
f) 80ø 28 TO 46-SPRINKLER
g) 100ø 47 TO 105-SPRINKLER

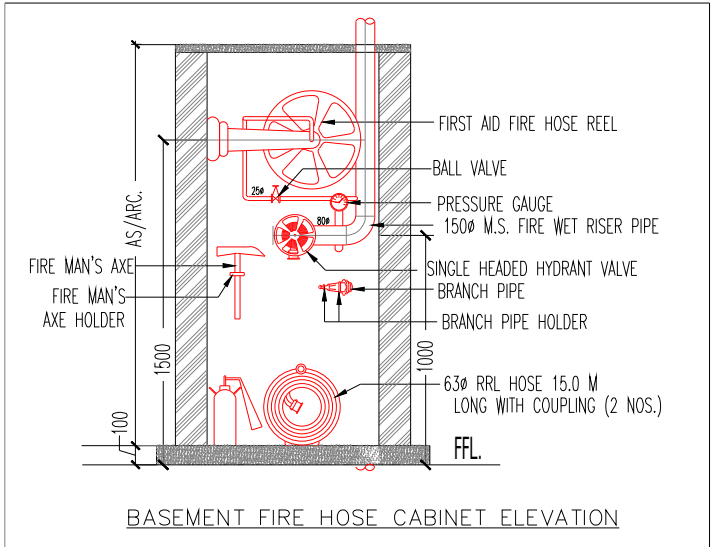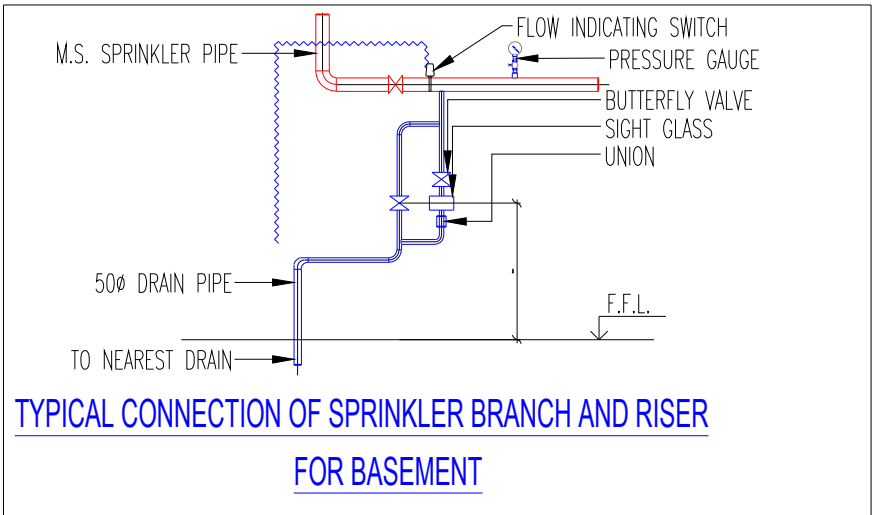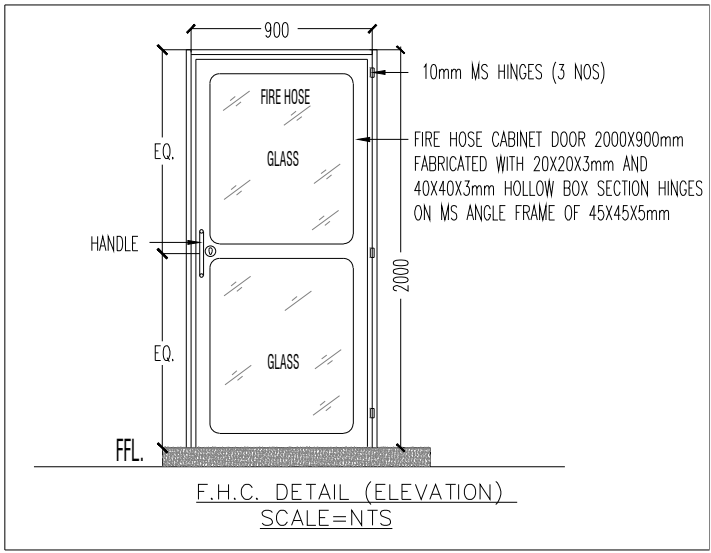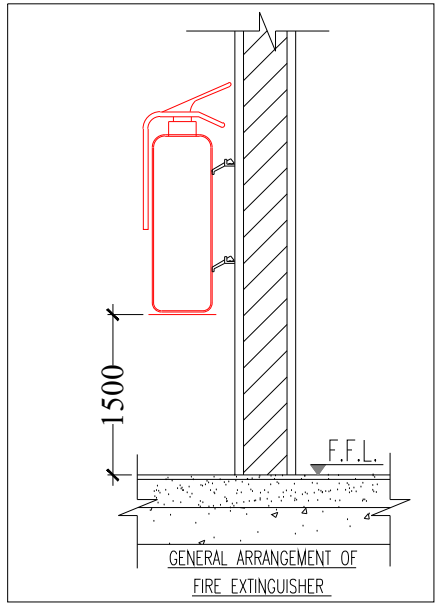

12.00 MT. WIDE ROAD



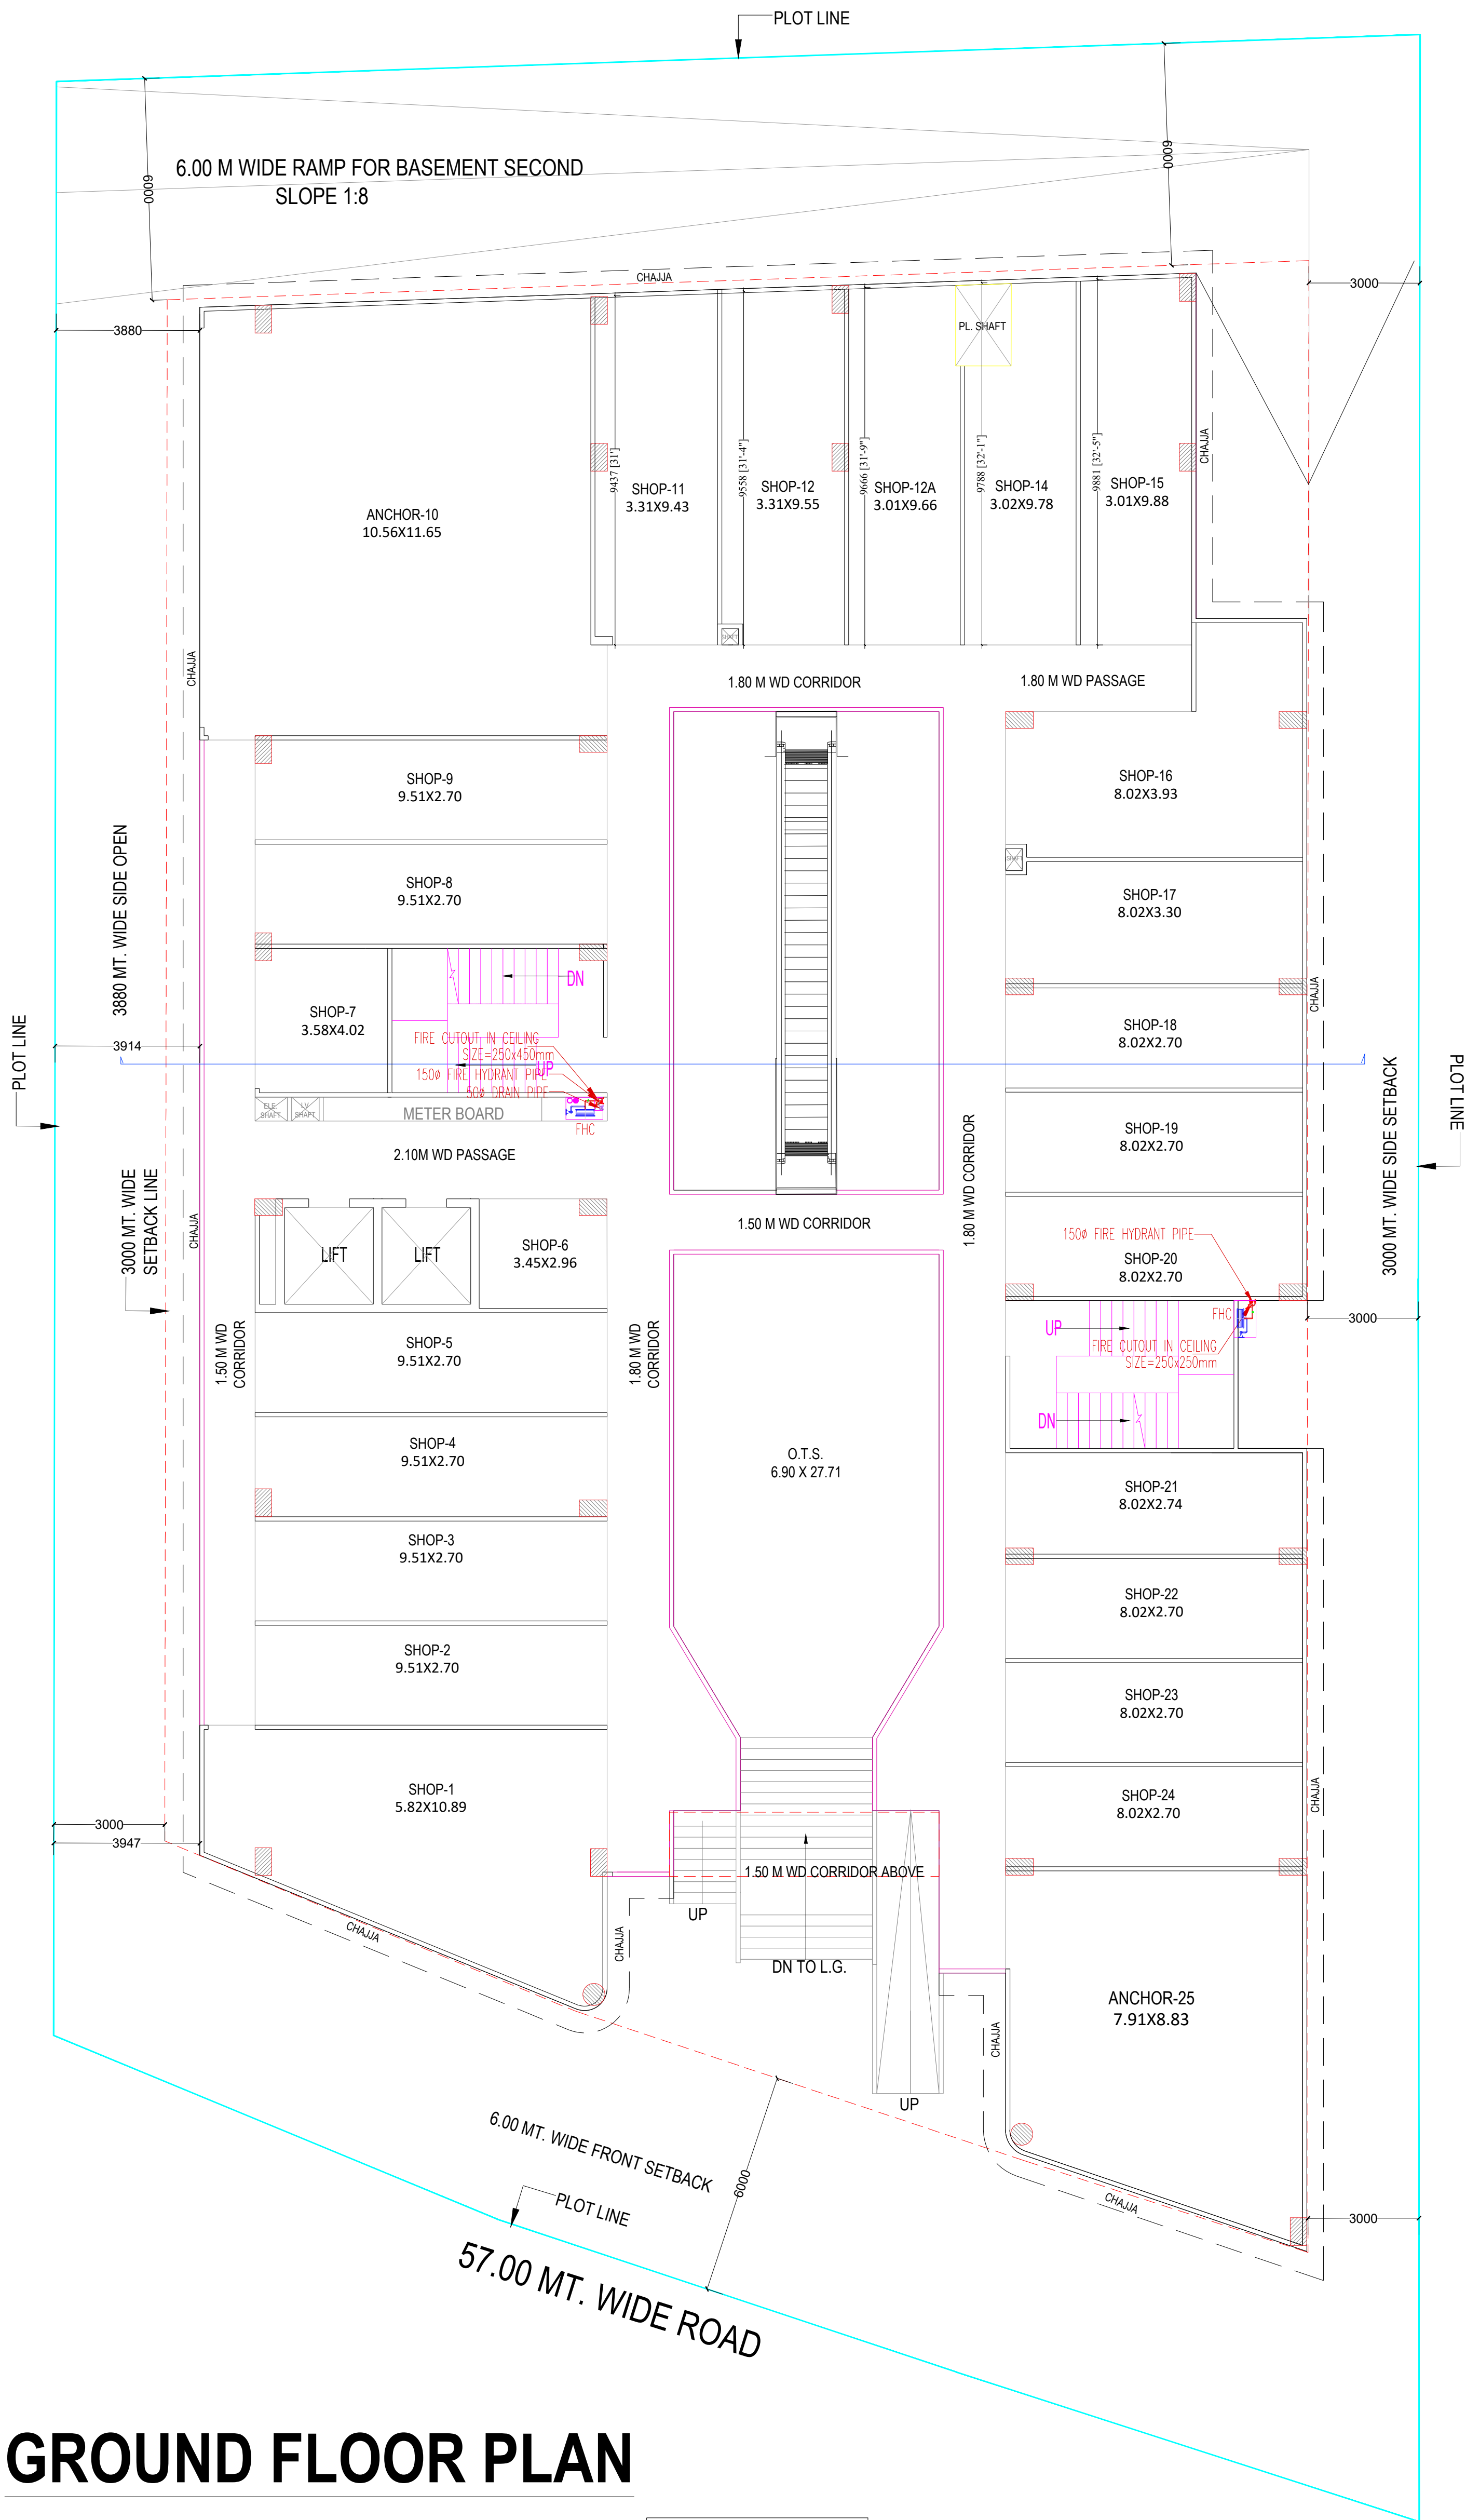




GROUND FLOOR PLAN

  LEGEND:-		
S.NO.	DESCRIPTION	SYMBOL
	FIRE HOSE CABINET	
	FIRE HOSE CABINET COMPRISING OF:	
1. a.	1 NO. S.S.LANDING VALVE	
b.	1 NO. HOSE REEL DRUM WITH 30mtr. RUBBER HOSE	
c.	2 NOS. 15mtr. LONG RRL HOSE	
d.	1 NO. S.S.BRANCH PIPE	
e.	1 NO. 9 LTR WATER TYPE FIRE EXTINGUISHERS	
f.	1 NO. 5KG ABC TYPE FIRE EXTINGUISHERS	

NOTES : (FOR SPRINKLER SYSTEM)

1.	THE SIZE OF RANGE SPRINKLER PIPES SHALL BE AS HERE UNDER :-
a)	25ø 1 & 2-SPRINKLER
b)	32ø 3 - SPRINKLER
c)	40ø 4 & 5-SPRINKLER
d)	50ø 6 TO 10-SPRINKLER
e)	65ø 11 TO 27-SPRINKLER
F)	80ø 28 TO 46-SPRINKLER
g)	100ø 47 TO 105-SPRINKLER

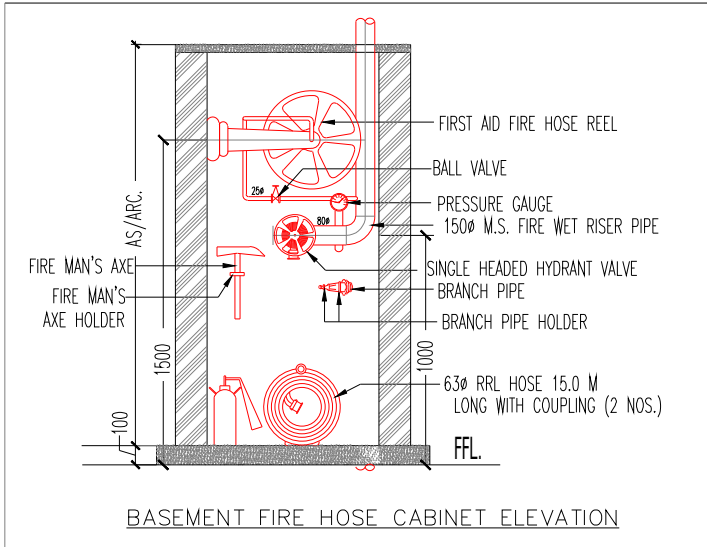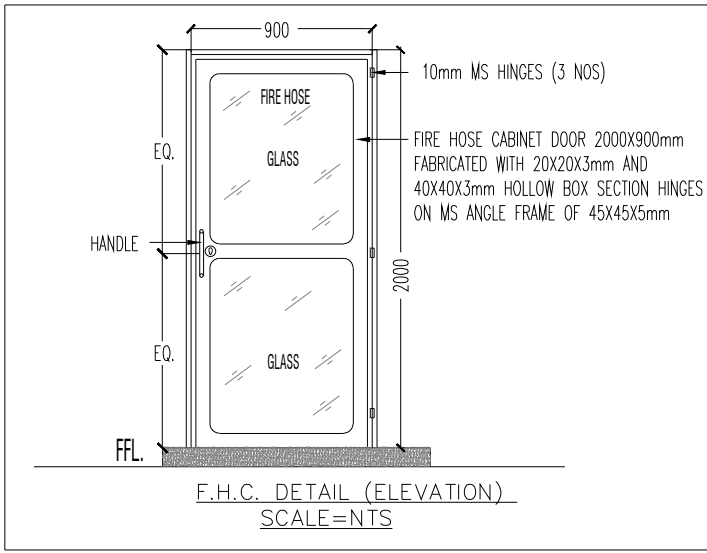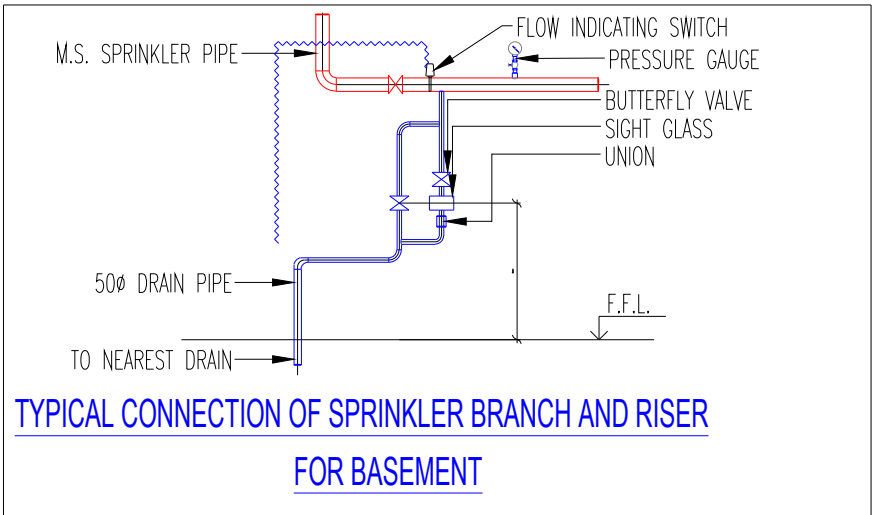

  LEGEND FOR FIRE FIGHTING:-	
FHC 	FIRE HOSE CABINET
	PENDENT TYPE SPRINKLER
	9 Ltr. WATER GAS PRESSURE TYPE FIRE EXTINGUISHER
	4.5 kg CO ² TYPE FIRE EXTINGUISHER
	BUTTER FLY VALVE
	FLOW INDICATING SWITCH

S. NO.	NOTES :- (FOR SPRINKLER SYSTEM)															
1.	ALL SPRINKLER PIPE LINE SHALL BE SUSPENDED FROM CEILING THROUGH G. I. HANGERS OF MIN. 3mm THICK MEMBERS ALONG WITH ANCHOR FASTNERS.															
2.	<u>PIPE MATERIAL</u> - SPRINKLER PIPE - MS (CLASS C) HEAVY DUTY - DRAIN PIPE - G. I. (CLASS B) MEDIUM DUTY															
3.	<u>JOINING OF PIPE</u> a) UP TO 40 MM DIA - SCREW JOINT b) 50 MM & ABOVE DIA - WELDED JOINT															
4.	ALL FIRE PIPING ACCESSORIES SHOULD BE PAINTED BY FIRE RED COLOUR (SHADE NO. 536 AS PER IS : 5)															
5.	EXPANSION BELLOW IS TO BE USED AT ALL PLACES IN HYDRANT AND SPRINKLER PIPING WHERE, THE PIPE PASSES THROUGH BUILDING EXPANSION JOINT.															
6.	ANY MODIFICATION REQD. ARE CARRIED OUT AT SITE TO SUIT SITE CONDITION IN CONSULTATION WITH SITE IN-CHARGE.															
7.	ALL PIPE SIZES ARE IN MM. AND NOMINAL DIA . ONLY															
8.	THE SPACING OF FIRE PIPE SUPPORTS FOR SPRINKLER / CLEVIS HANGER SHALL NOT BE MORE THAN THAT SPECIFIED BELOW:-															
	<table><tr><th>Nominal pipes diameter (mm)</th><th>Spacing between supports (meter)</th><th>Support / Hanger rod diameter (mm)</th></tr><tr><td>Up to 25</td><td>2.00</td><td>8</td></tr><tr><td>32 to 50</td><td>2.50</td><td>8</td></tr><tr><td>65 to 80</td><td>2.50</td><td>10</td></tr><tr><td>100</td><td>2.50</td><td>12</td></tr></table>	Nominal pipes diameter (mm)	Spacing between supports (meter)	Support / Hanger rod diameter (mm)	Up to 25	2.00	8	32 to 50	2.50	8	65 to 80	2.50	10	100	2.50	12
Nominal pipes diameter (mm)	Spacing between supports (meter)	Support / Hanger rod diameter (mm)														
Up to 25	2.00	8														
32 to 50	2.50	8														
65 to 80	2.50	10														
100	2.50	12														
	NOTE :- 1)EXTRA SUPPORTS SHALL BE PROVIDED AT THE BENDS AND AT HEAVY FITTINGS LIKE VALVES TO AVOID UNDUE STRESS ON THE PIPES. 2)THE THICKNESS OF CLAMP SHOULD BE MINIMUM 3mm															
9.	THE SUPPORT FOR 150 / 200mm DIA. PIPE SHALL BE BY 50x50x6mm MS ANGLE IRON @ 3.0 M. C/C (MAXIMUM).															
10.	THE SUPPORT DRILLING FOR FIRE PIPE HAS TO BE CO-ORDINATED WITH ELECTRICAL / FIRE ALARM / LV DRAWING TO AVOID ANY DAMAGE IN CONDUIT.															

Rev. no.	Date	

Project
PROPOSED COMMERCIAL BUILDING AT COMMERCIAL PLOT NO. 1G, PINWOOD ENCLAVE, SECTOR-2, WAVE CITY, GZB.

Title
UPPER GROUND ROOF LAYOUT

Subtitle
FIRE FIGHTING LAYOUT

drawing released for
☐ APPROVAL ☐ SUBMISSION
☐ ADVANCE COPY ☐ CONSTRUCTION


drg. no. FF-UGF-01 drawn by: HIMANSHU

scale NTS designed by: HIMANSHU

date 07.06.2025 checked by: D.K.

Architects
DIVYAKASH ATELIER INC
ARCHITECTURAL . INTERIOR . PLANNING CONSULTANTS
407, ORBIT PLAZA, CROSSING REPUBLIK, GHAZIABAD
CONTACT US :- +91-9999609559
E mail- groupdivyakash@gmail.com

MEP Consultant:
**WeDESIGN Associates**
"Engineered to perfection"
Email - wedesignassociates@gmail.com
Mob. - 9999288416, 9999288407, 9882244495

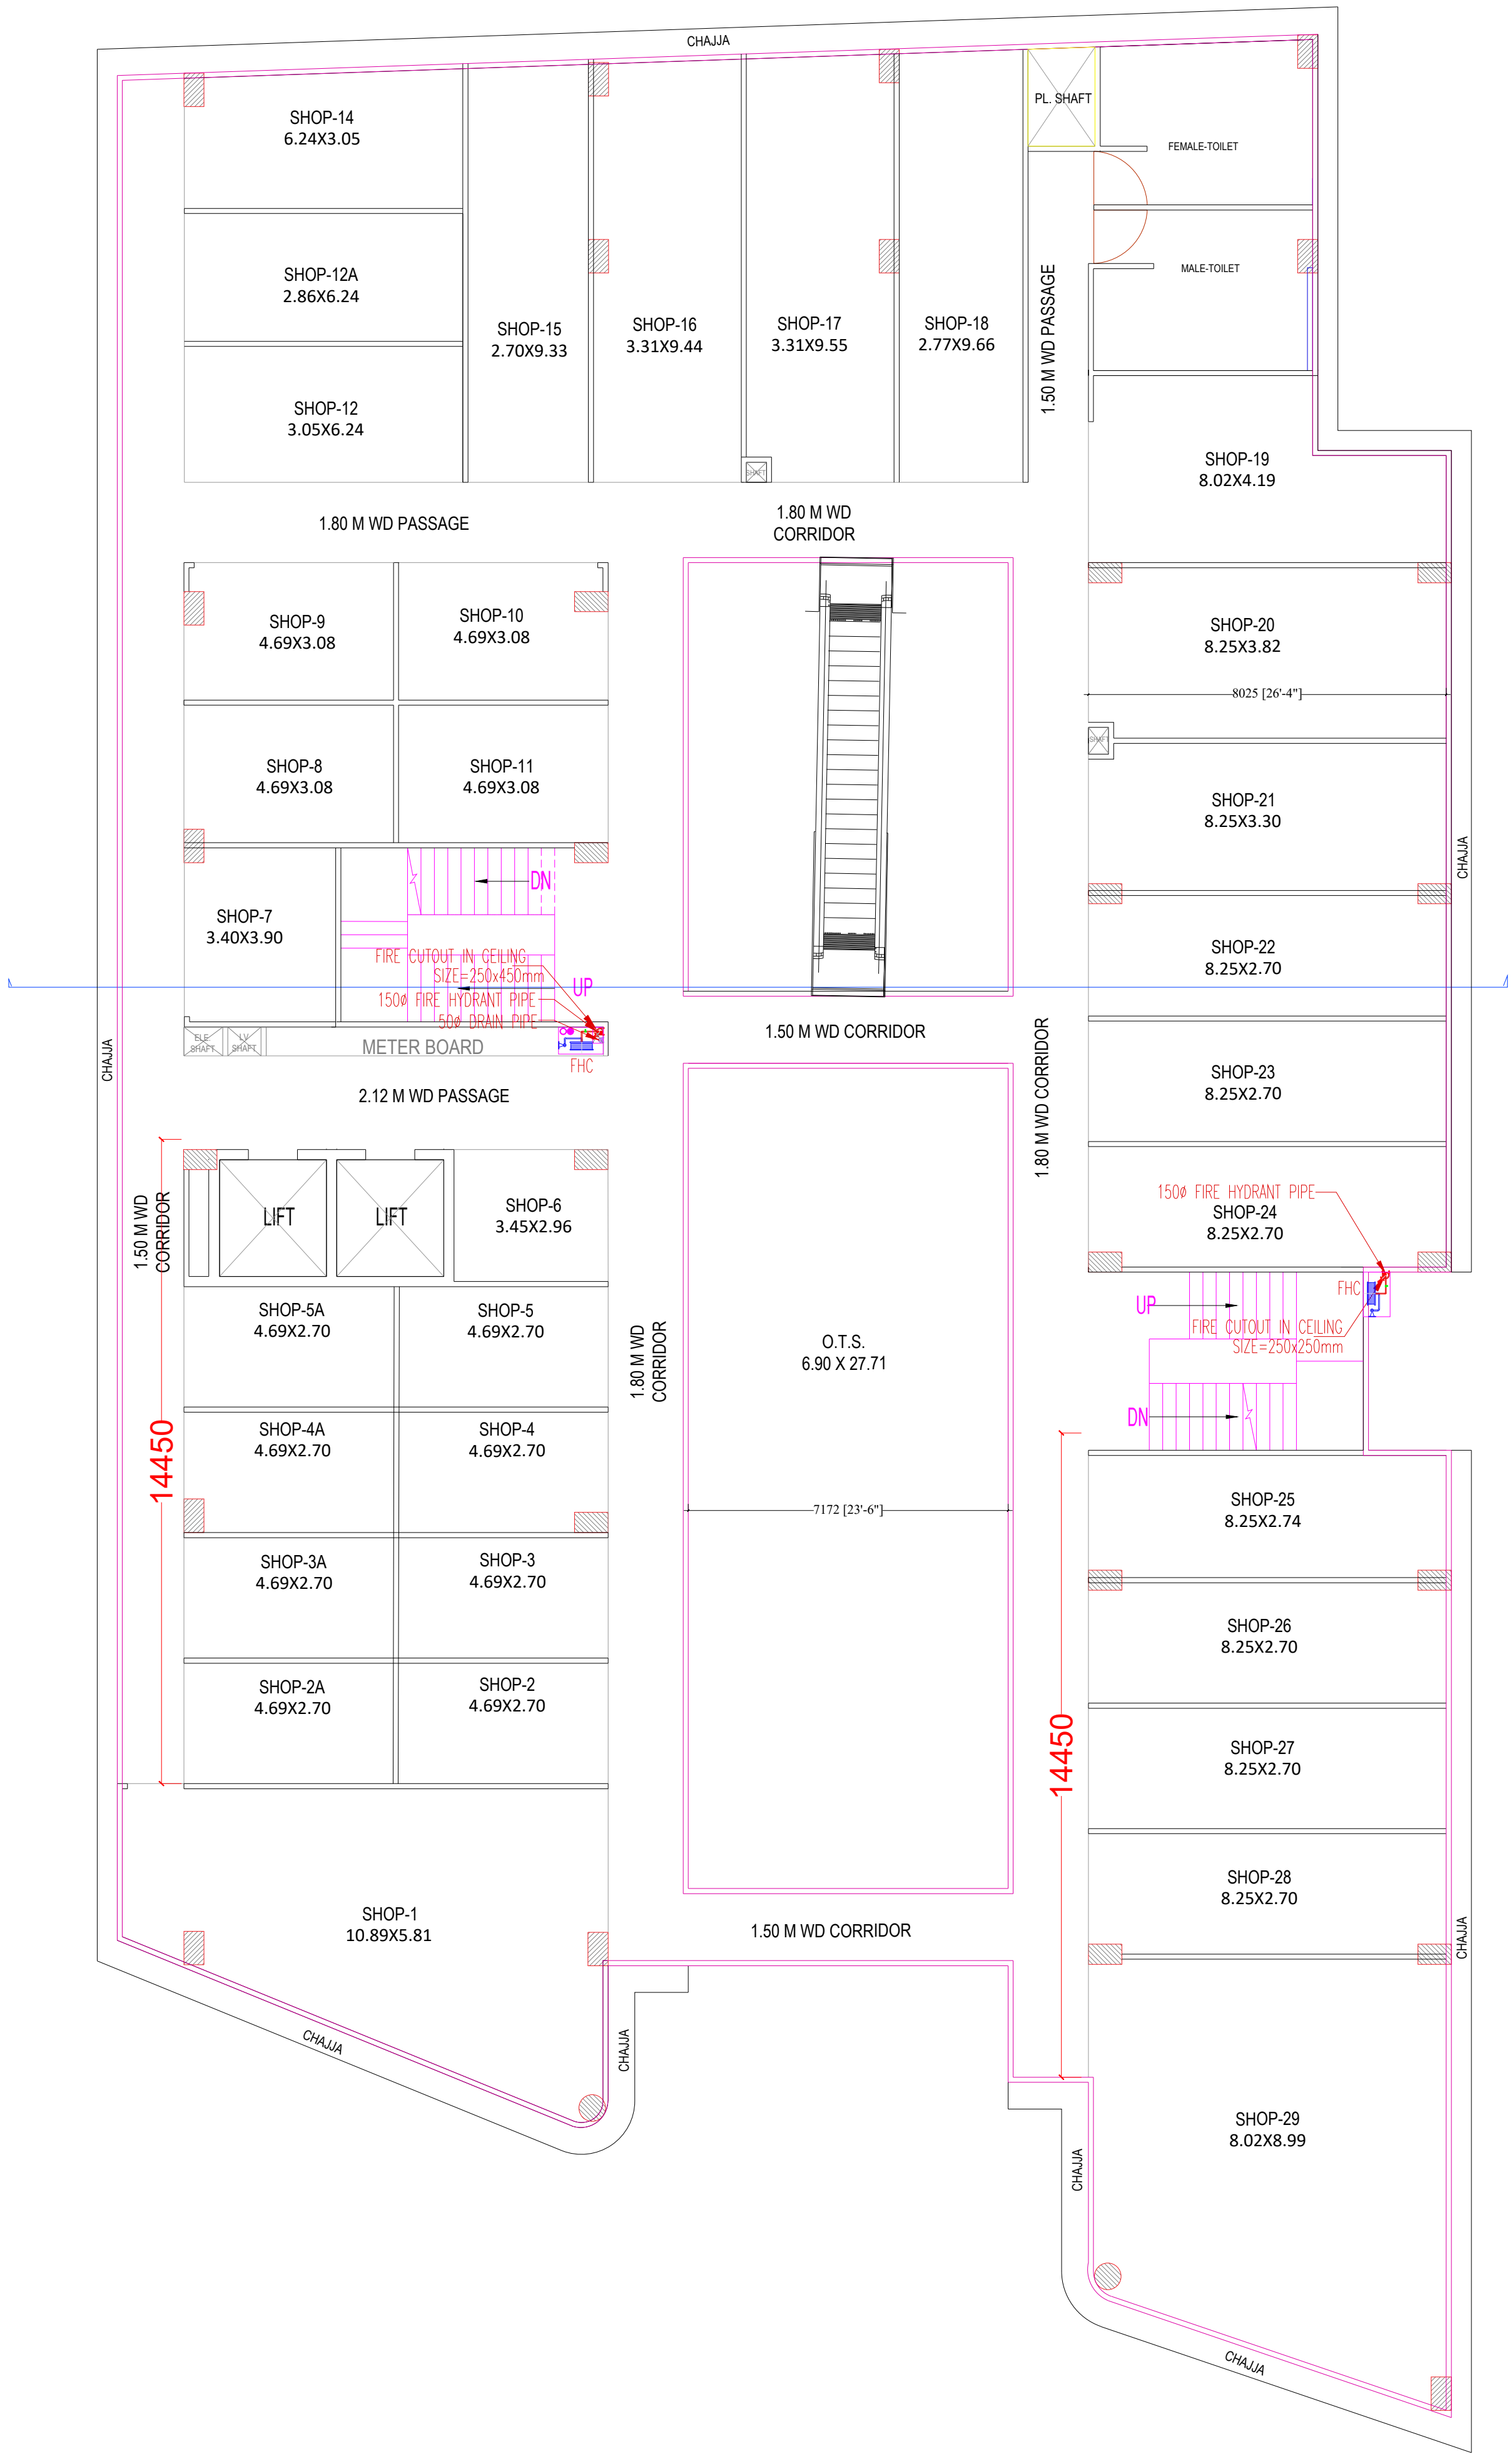

FIRST FLOOR PLAN

LEGEND FOR FIRE FIGHTING:-	
FHC	FIRE HOSE CABINET
	PENDENT TYPE SPRINKLER
	9 Ltr. WATER GAS PRESSURE TYPE FIRE EXTINGUISHER
	4.5 kg CO ² TYPE FIRE EXTINGUISHER
	BUTTER FLY VALVE
	FLOW INDICATING SWITCH

S. NO.	NOTES :- (FOR SPRINKLER SYSTEM)															
1.	ALL SPRINKLER PIPE LINE SHALL BE SUSPENDED FROM CEILING THROUGH G. I. HANGERS OF MIN. 3mm THICK MEMBERS ALONG WITH ANCHOR FASTNERS.															
2.	<u>PIPE MATERIAL</u> - SPRINKLER PIPE - MS (CLASS C) HEAVY DUTY - DRAIN PIPE - G. I. (CLASS B) MEDIUM DUTY															
3.	<u>JOINING OF PIPE</u> a) UP TO 40 MM DIA - SCREW JOINT b) 50 MM & ABOVE DIA - WELDED JOINT															
4.	ALL FIRE PIPING ACCESSORIES SHOULD BE PAINTED BY FIRE RED COLOUR (SHADE NO. 536 AS PER IS : 5)															
5.	EXPANSION BELLOW IS TO BE USED AT ALL PLACES IN HYDRANT AND SPRINKLER PIPING WHERE, THE PIPE PASSES THROUGH BUILDING EXPANSION JOINT.															
6.	ANY MODIFICATION REQD. ARE CARRIED OUT AT SITE TO SUIT SITE CONDITION IN CONSULTATION WITH SITE IN-CHARGE.															
7.	ALL PIPE SIZES ARE IN MM. AND NOMINAL DIA . ONLY															
8.	THE SPACING OF FIRE PIPE SUPPORTS FOR SPRINKLER / CLEVIS HANGER SHALL NOT BE MORE THAN THAT SPECIFIED BELOW:-															
<table><tr><th>Nominal pipes diameter (mm)</th><th>Spacing between supports (meter)</th><th>Support / Hanger rod diameter (mm)</th></tr><tr><td>Up to 25</td><td>2.00</td><td>8</td></tr><tr><td>32 to 50</td><td>2.50</td><td>8</td></tr><tr><td>65 to 80</td><td>2.50</td><td>10</td></tr><tr><td>100</td><td>2.50</td><td>12</td></tr></table>		Nominal pipes diameter (mm)	Spacing between supports (meter)	Support / Hanger rod diameter (mm)	Up to 25	2.00	8	32 to 50	2.50	8	65 to 80	2.50	10	100	2.50	12
Nominal pipes diameter (mm)	Spacing between supports (meter)	Support / Hanger rod diameter (mm)														
Up to 25	2.00	8														
32 to 50	2.50	8														
65 to 80	2.50	10														
100	2.50	12														
NOTE :- 1)EXTRA SUPPORTS SHALL BE PROVIDED AT THE BENDS AND AT HEAVY FITTINGS LIKE VALVES TO AVOID UNDUE STRESS ON THE PIPES. 2)THE THICKNESS OF CLAMP SHOULD BE MINIMUM 3mm																
9.	THE SUPPORT FOR 150 / 200mm DIA. PIPE SHALL BE BY 50x50x6mm MS ANGLE IRON @ 3.0 M. C/C (MAXIMUM).															
10.	THE SUPPORT DRILLING FOR FIRE PIPE HAS TO BE CO-ORDINATED WITH ELECTRICAL / FIRE ALARM / LV DRAWING TO AVOID ANY DAMAGE IN CONDUIT.															

Rev. no.	Date	

Project
PROPOSED COMMERCIAL BUILDING AT COMMERCIAL PLOT NO. 1G, PINWOOD ENCLAVE, SECTOR-2, WAVE CITY, GZB.

Title
FIRST ROOF LAYOUT

Subtitle
FIRE FIGHTING LAYOUT

drawing released for
☐ APPROVAL ☐ SUBMISSION
☐ ADVANCE COPY ☐ CONSTRUCTION

drg. no. FF-FF-01 drawn by: HIMANSHU

scale NTS designed by: HIMANSHU

date 07.06.2025 checked by: D.K.

Architects
DIVYAKASH ATELIER INC
ARCHITECTURAL . INTERIOR . PLANNING CONSULTANTS
407, ORBIT PLAZA, CROSSING REPUBLIK, GHAZIABAD
CONTACT US :- +91-9999609559
E mail- groupdivyakash@gmail.com





MEP Consultant:


WeDESIGN Associates
"Engineered to perfection"
Email - wedesignassociates@gmail.com
Mob. - 9999288416, 9999288407, 9882244495

LEGEND:-		
S.NO.	DESCRIPTION	SYMBOL
	FIRE HOSE CABINET	FHC
	FIRE HOSE CABINET COMPRISING OF:	
1. a.	1 NO. S.S.LANDING VALVE	
b.	1 NO. HOSE REEL DRUM WITH 30mtr. RUBBER HOSE	
c.	2 NOS. 15mtr. LONG RRL HOSE	
d.	1 NO. S.S.BRANCH PIPE	
e.	1 NO. 9 LTR WATER TYPE FIRE EXTINGUISHERS	
f.	1 NO. 5KG ABC TYPE FIRE EXTINGUISHERS	

NOTES : (FOR SPRINKLER SYSTEM)

- THE SIZE OF RANGE SPRINKLER PIPES SHALL BE AS HERE UNDER :-
 - 25ø 1 & 2-SPRINKLER
 - 32ø 3 - SPRINKLER
 - 40ø 4 & 5-SPRINKLER
 - 50ø 6 TO 10-SPRINKLER
 - 65ø 11 TO 27-SPRINKLER
 - 80ø 28 TO 46-SPRINKLER
 - 100ø 47 TO 105-SPRINKLER

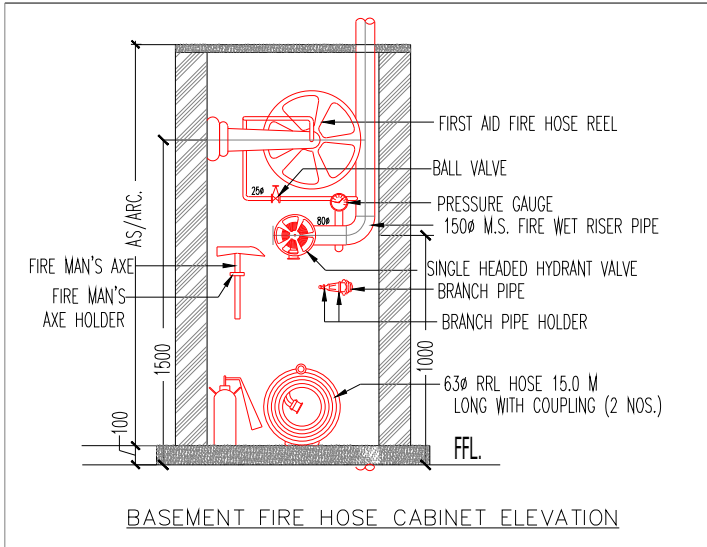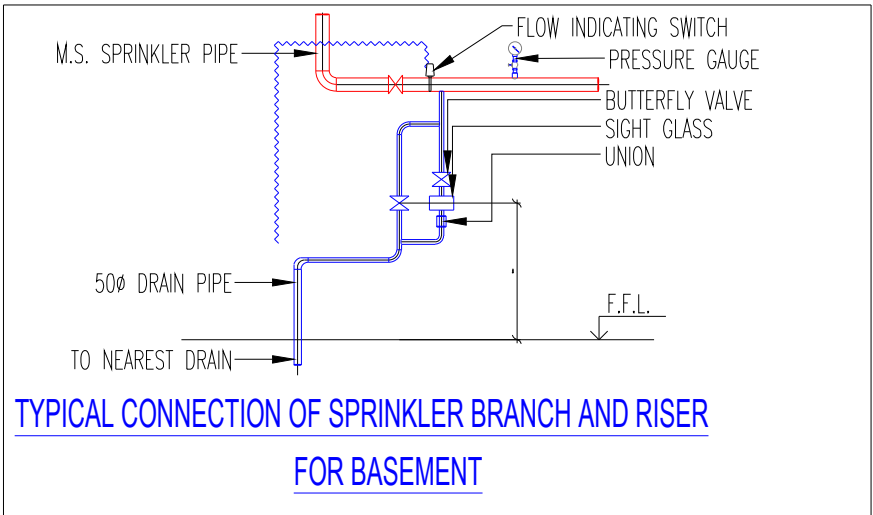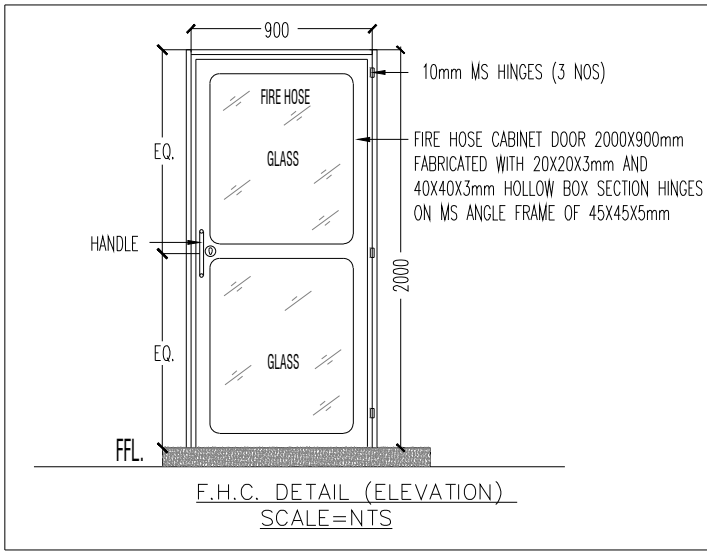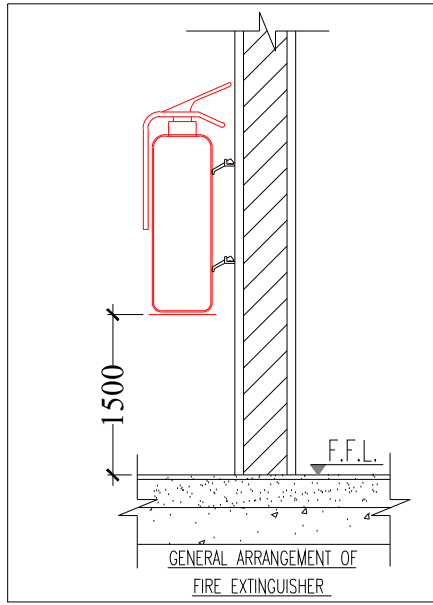

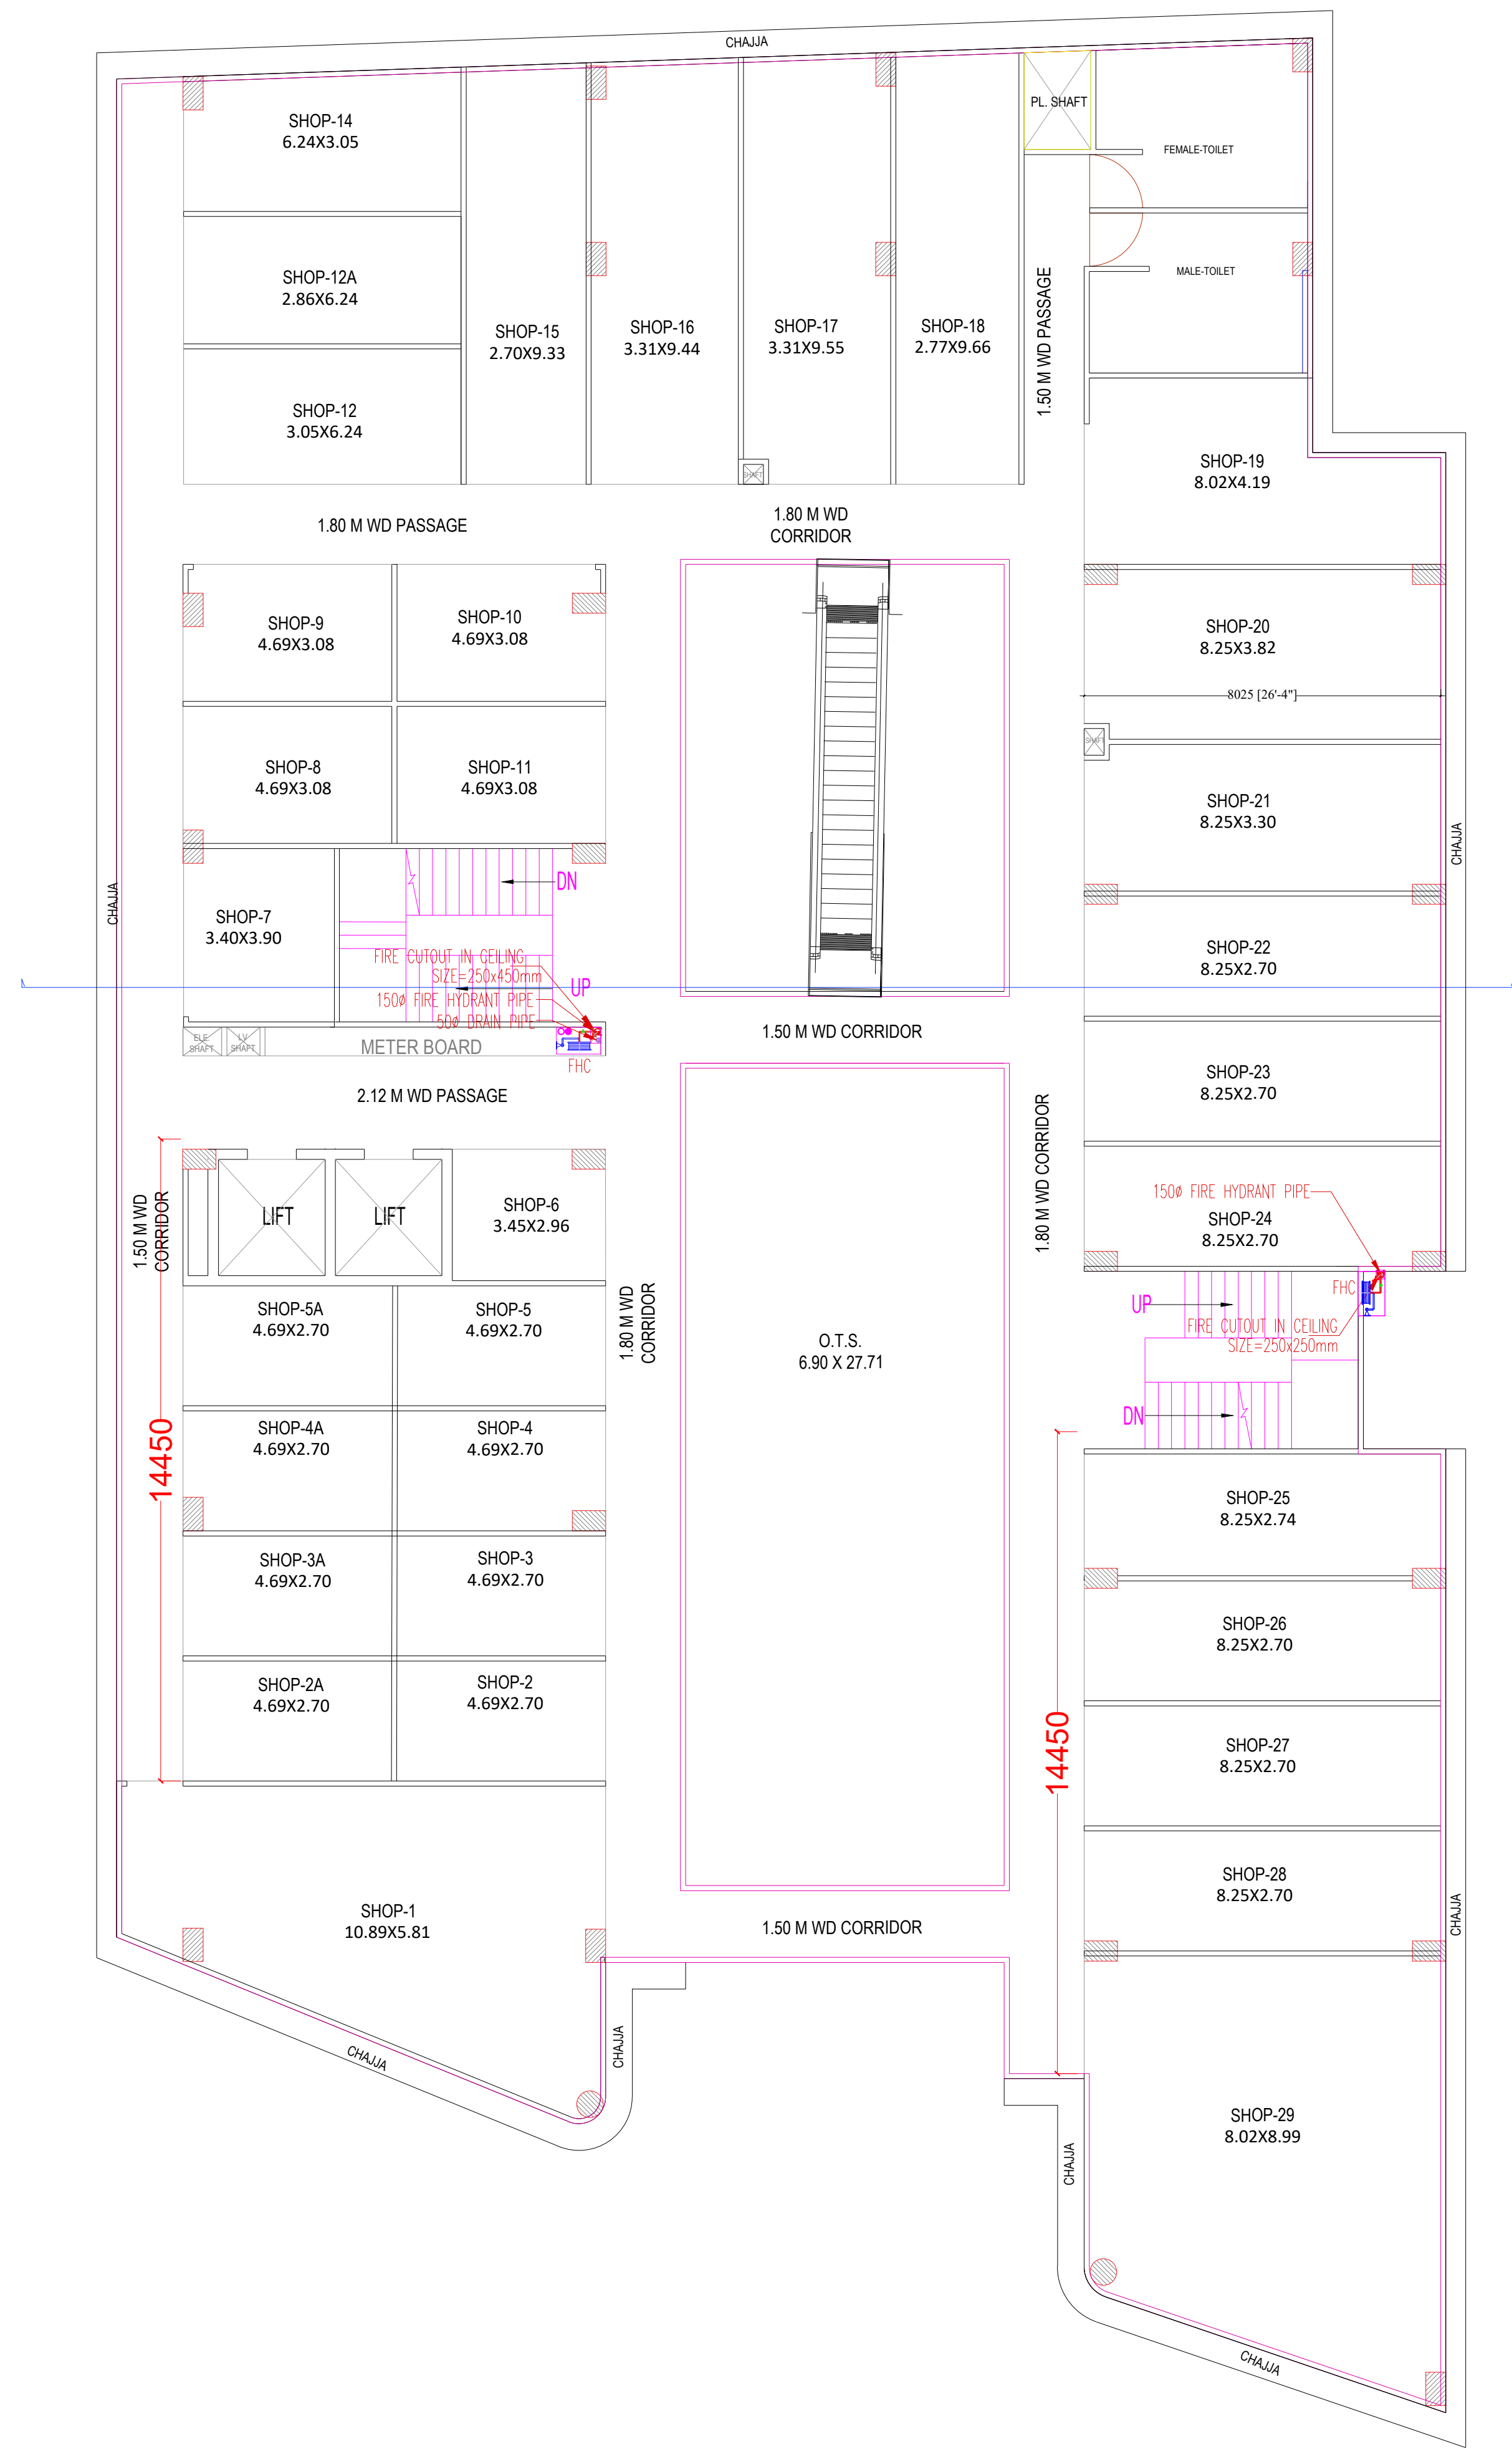

SECOND FLOOR PLAN

LEGEND FOR FIRE FIGHTING:-	
FHC	FIRE HOSE CABINET
	PENDENT TYPE SPRINKLER
	9 Ltr. WATER GAS PRESSURE TYPE FIRE EXTINGUISHER
	4.5 kg CO ² TYPE FIRE EXTINGUISHER
	BUTTER FLY VALVE
	FLOW INDICATING SWITCH

S. NO.	NOTES :- (FOR SPRINKLER SYSTEM)															
1.	ALL SPRINKLER PIPE LINE SHALL BE SUSPENDED FROM CEILING THROUGH G. I. HANGERS OF MIN. 3mm THICK MEMBERS ALONG WITH ANCHOR FASTNERS.															
2.	<u>PIPE MATERIAL</u> - SPRINKLER PIPE - MS (CLASS C) HEAVY DUTY - DRAIN PIPE - G. I. (CLASS B) MEDIUM DUTY															
3.	<u>JOINING OF PIPE</u> a) UP TO 40 MM DIA - SCREW JOINT b) 50 MM & ABOVE DIA - WELDED JOINT															
4.	ALL FIRE PIPING ACCESSORIES SHOULD BE PAINTED BY FIRE RED COLOUR (SHADE NO. 536 AS PER IS : 5)															
5.	EXPANSION BELLOW IS TO BE USED AT ALL PLACES IN HYDRANT AND SPRINKLER PIPING WHERE, THE PIPE PASSES THROUGH BUILDING EXPANSION JOINT.															
6.	ANY MODIFICATION REQD. ARE CARRIED OUT AT SITE TO SUIT SITE CONDITION IN CONSULTATION WITH SITE IN-CHARGE.															
7.	ALL PIPE SIZES ARE IN MM. AND NOMINAL DIA . ONLY															
8.	THE SPACING OF FIRE PIPE SUPPORTS FOR SPRINKLER / CLEVIS HANGER SHALL NOT BE MORE THAN THAT SPECIFIED BELOW:-															
<table><tr><th>Nominal pipes diameter (mm)</th><th>Spacing between supports (meter)</th><th>Support / Hanger rod diameter (mm)</th></tr><tr><td>Up to 25</td><td>2.00</td><td>8</td></tr><tr><td>32 to 50</td><td>2.50</td><td>8</td></tr><tr><td>65 to 80</td><td>2.50</td><td>10</td></tr><tr><td>100</td><td>2.50</td><td>12</td></tr></table>		Nominal pipes diameter (mm)	Spacing between supports (meter)	Support / Hanger rod diameter (mm)	Up to 25	2.00	8	32 to 50	2.50	8	65 to 80	2.50	10	100	2.50	12
Nominal pipes diameter (mm)	Spacing between supports (meter)	Support / Hanger rod diameter (mm)														
Up to 25	2.00	8														
32 to 50	2.50	8														
65 to 80	2.50	10														
100	2.50	12														
NOTE :- 1)EXTRA SUPPORTS SHALL BE PROVIDED AT THE BENDS AND AT HEAVY FITTINGS LIKE VALVES TO AVOID UNDUE STRESS ON THE PIPES. 2)THE THICKNESS OF CLAMP SHOULD BE MINIMUM 3mm																
9.	THE SUPPORT FOR 150 / 200mm DIA. PIPE SHALL BE BY 50x50x6mm MS ANGLE IRON @ 3.0 M. C/C (MAXIMUM).															
10.	THE SUPPORT DRILLING FOR FIRE PIPE HAS TO BE CO-ORDINATED WITH ELECTRICAL / FIRE ALARM / LV DRAWING TO AVOID ANY DAMAGE IN CONDUIT.															

Rev. no.	Date	

Project
PROPOSED COMMERCIAL BUILDING AT COMMERCIAL PLOT NO. 1G, PINWOOD ENCLAVE, SECTOR-2, WAVE CITY, GZB.

Title
SECOND ROOF LAYOUT

Subtitle
FIRE FIGHTING LAYOUT

drawing released for
☐ APPROVAL ☐ SUBMISSION
☐ ADVANCE COPY ☐ CONSTRUCTION

drg. no. FF-2ND.F-01 drawn by: HIMANSHU

scale NTS designed by: HIMANSHU





date 07.06.2025 checked by: D.K.


Architects
DIVYAKASH ATELIER INC
ARCHITECTURAL . INTERIOR . PLANNING CONSULTANTS
407, ORBIT PLAZA, CROSSING REPUBLIK, GHAZIABAD
CONTACT US :- +91-9999609559
E mail- groupdivyakash@gmail.com

MEP Consultant:

WeDESIGN Associates
"Engineered to perfection"
Email - wedesignassociates@gmail.com
Mob. - 9999288416, 9999288407, 9882244495

LEGEND:-		
S.NO.	DESCRIPTION	SYMBOL
	FIRE HOSE CABINET	FHC
	FIRE HOSE CABINET COMPRISING OF:	
1. a.	1 NO. S.S.LANDING VALVE	
b.	1 NO. HOSE REEL DRUM WITH 30mtr. RUBBER HOSE	
c.	2 NOS. 15mtr. LONG RRL HOSE	
d.	1 NO. S.S.BRANCH PIPE	
e.	1 NO. 9 LTR WATER TYPE FIRE EXTINGUISHERS	
f.	1 NO. 5KG ABC TYPE FIRE EXTINGUISHERS	

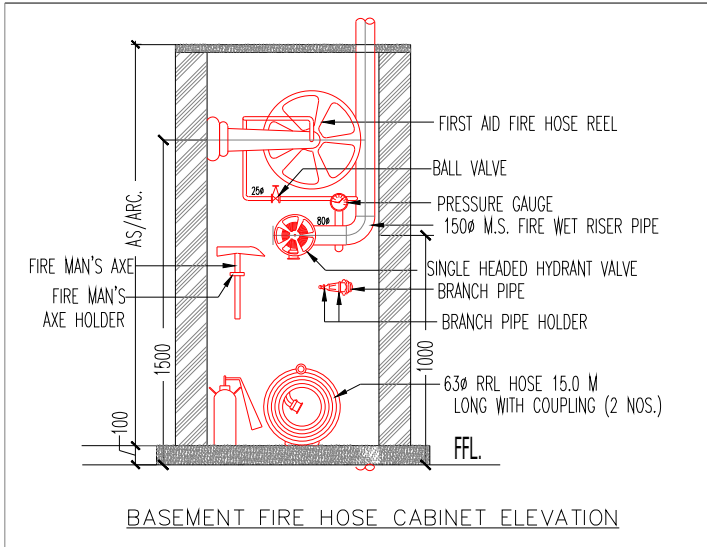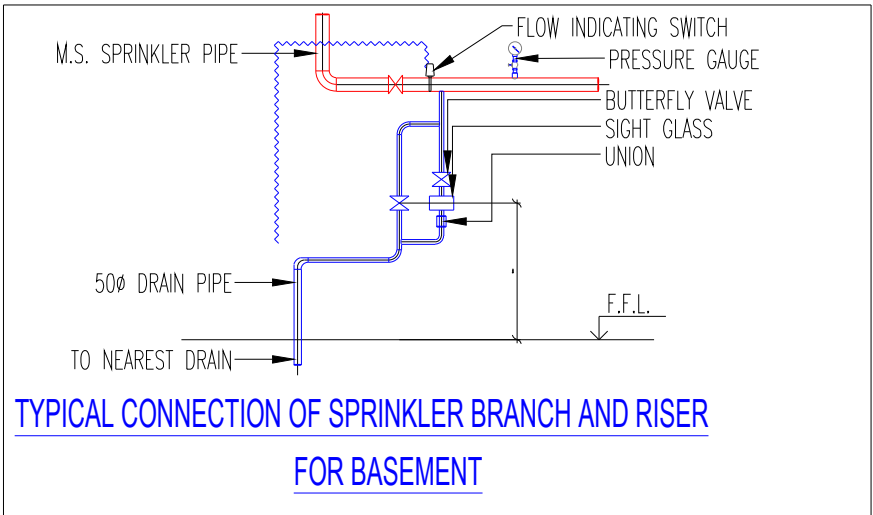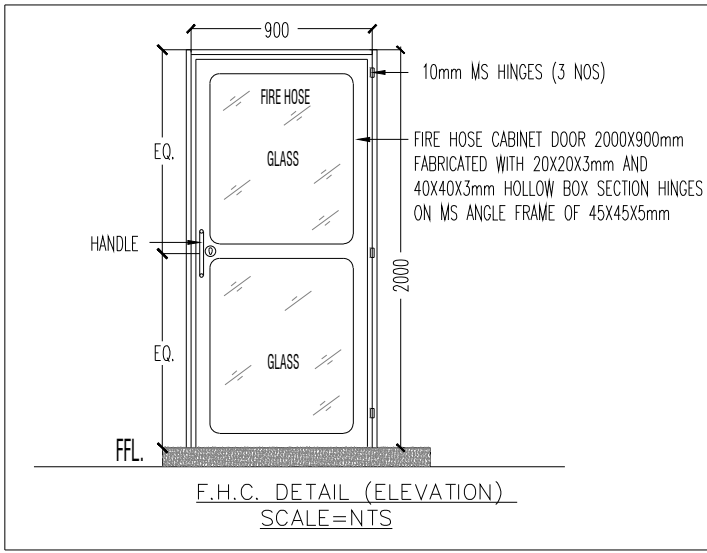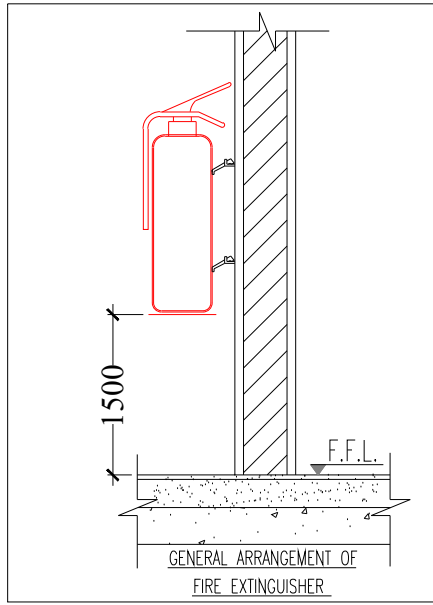

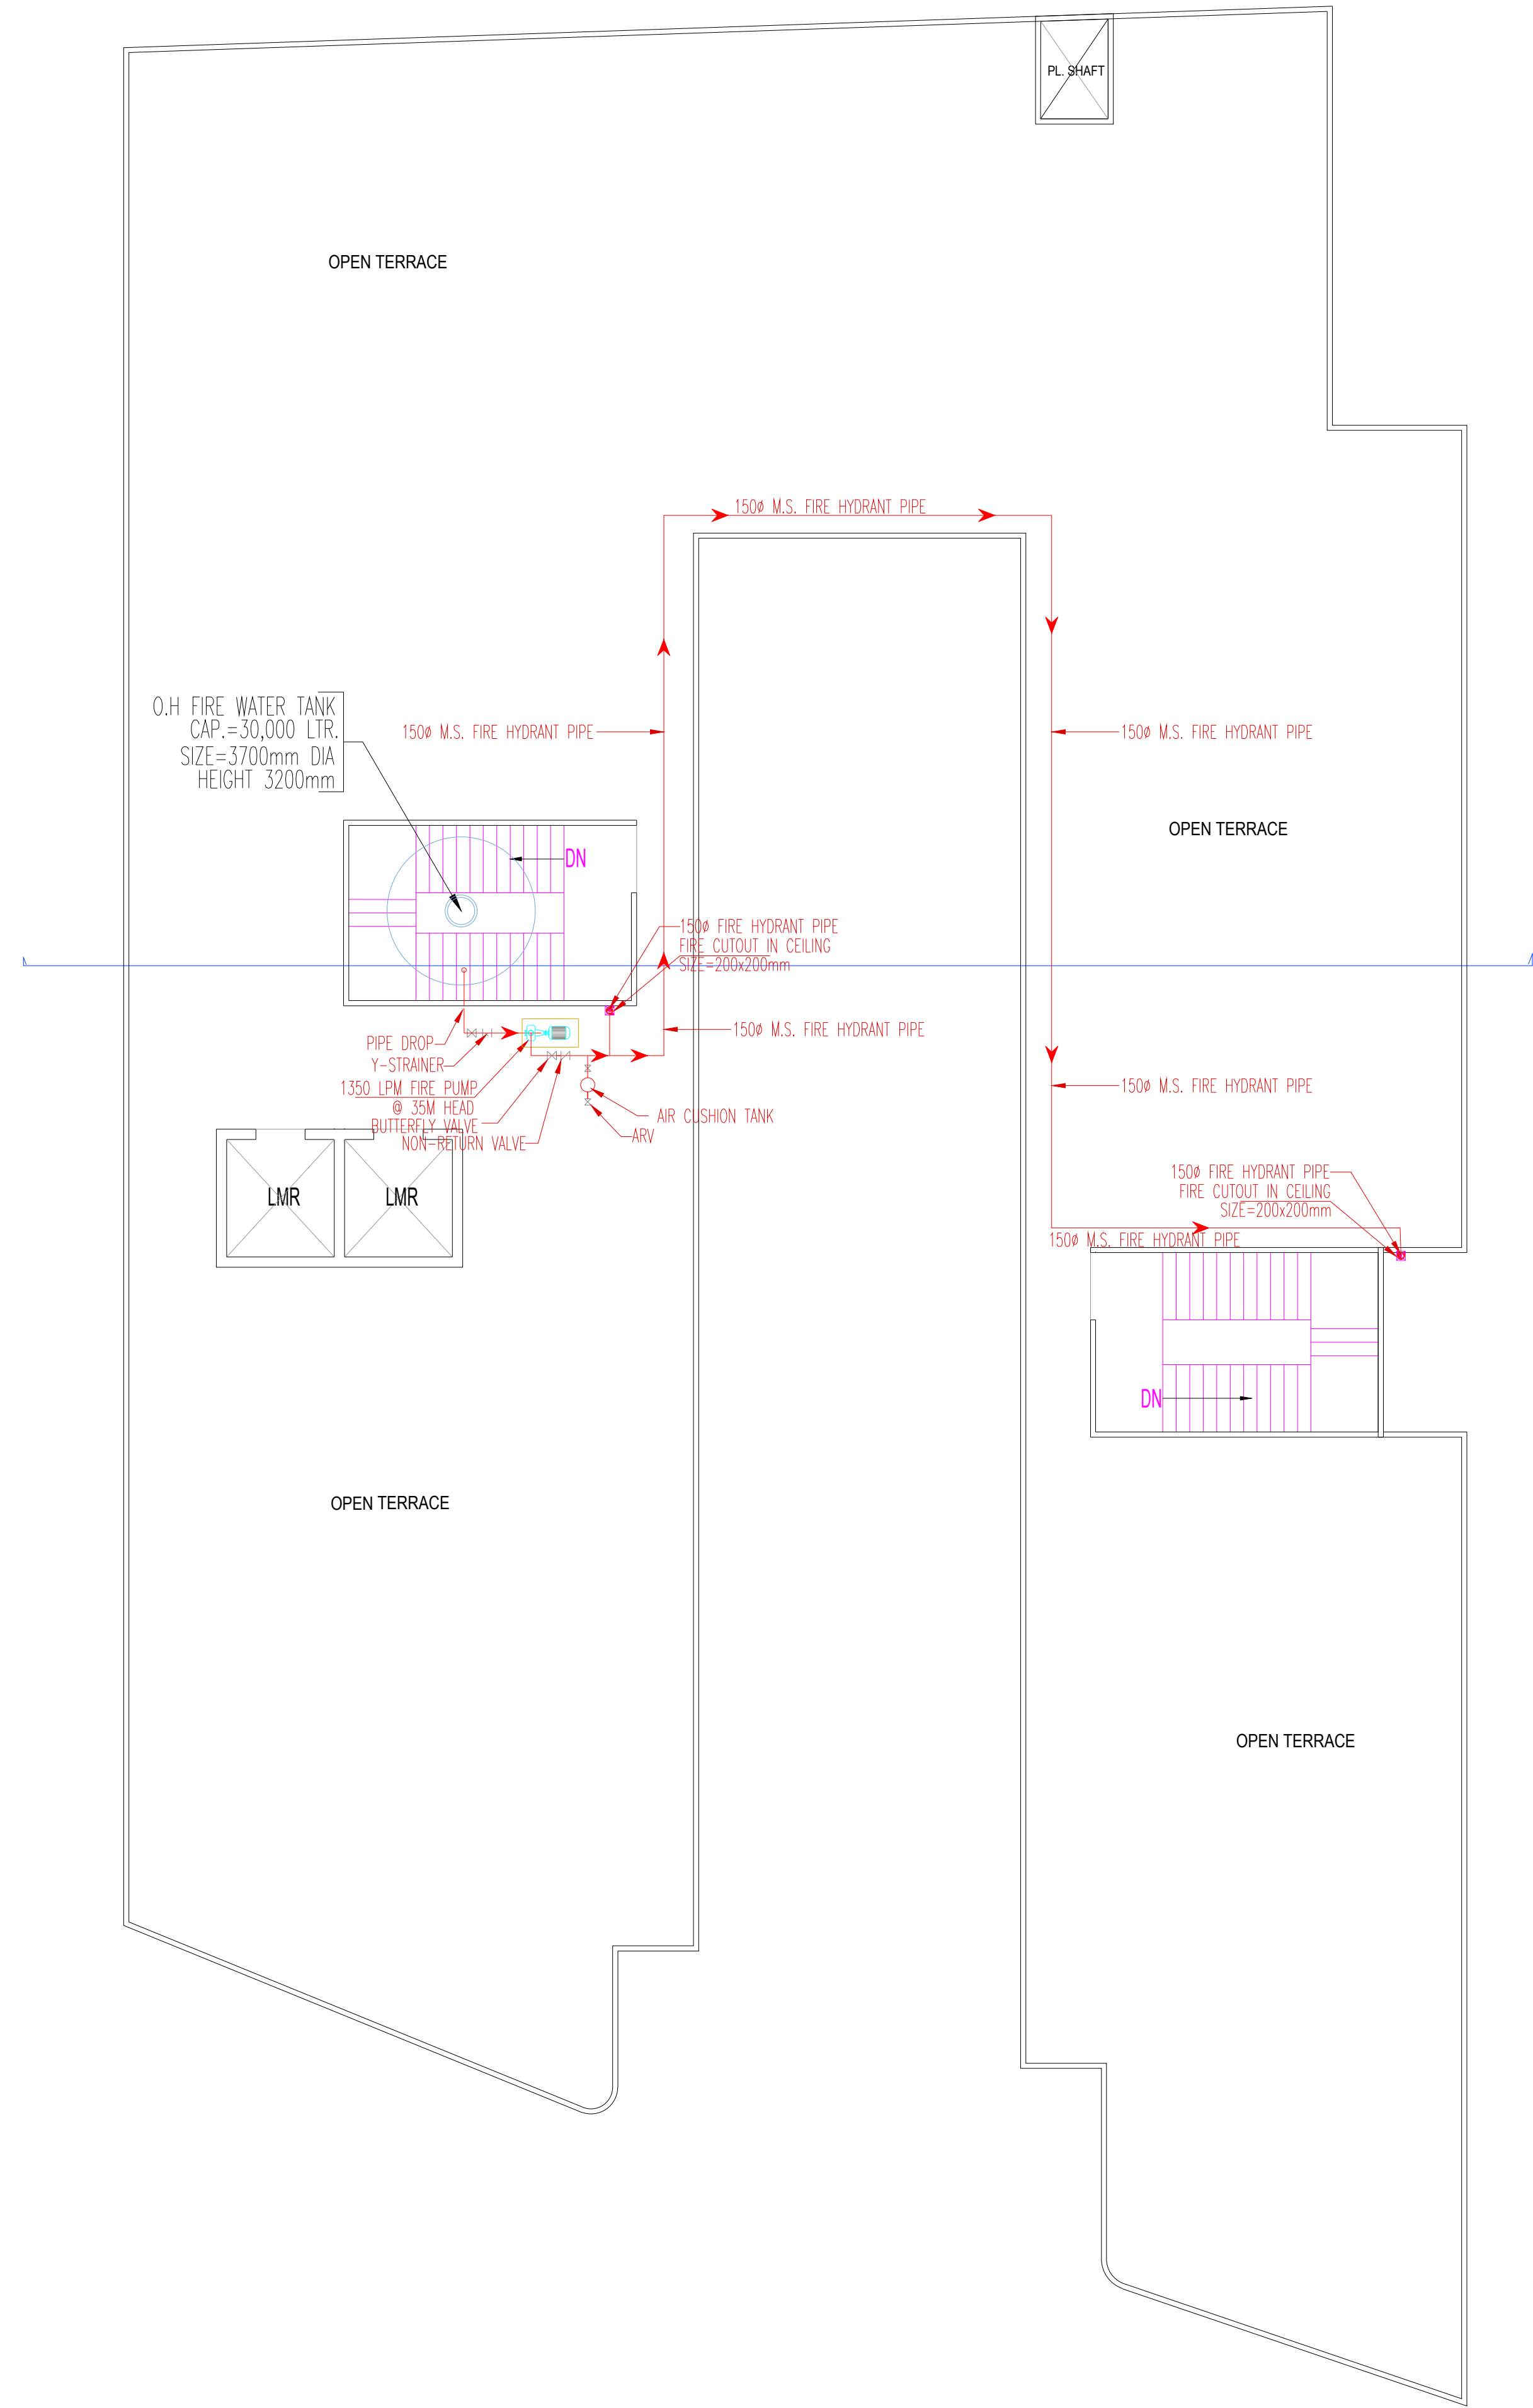

TERRACE FLOOR PLAN

LEGEND FOR FIRE FIGHTING:-	
FHC	FIRE HOSE CABINET
	PENDENT TYPE SPRINKLER
	9 Ltr. WATER GAS PRESSURE TYPE FIRE EXTINGUISHER
	4.5 kg CO ² TYPE FIRE EXTINGUISHER
	BUTTER FLY VALVE
	FLOW INDICATING SWITCH

S. NO.	NOTES :- (FOR SPRINKLER SYSTEM)															
1.	ALL SPRINKLER PIPE LINE SHALL BE SUSPENDED FROM CEILING THROUGH G. I. HANGERS OF MIN. 3mm THICK MEMBERS ALONG WITH ANCHOR FASTNERS.															
2.	<u>PIPE MATERIAL</u> - SPRINKLER PIPE - MS (CLASS C) HEAVY DUTY - DRAIN PIPE - G. I. (CLASS B) MEDIUM DUTY															
3.	<u>JOINING OF PIPE</u> a) UP TO 40 MM DIA - SCREW JOINT b) 50 MM & ABOVE DIA - WELDED JOINT															
4.	ALL FIRE PIPING ACCESSORIES SHOULD BE PAINTED BY FIRE RED COLOUR (SHADE NO. 536 AS PER IS : 5)															
5.	EXPANSION BELLOW IS TO BE USED AT ALL PLACES IN HYDRANT AND SPRINKLER PIPING WHERE, THE PIPE PASSES THROUGH BUILDING EXPANSION JOINT.															
6.	ANY MODIFICATION REQD. ARE CARRIED OUT AT SITE TO SUIT SITE CONDITION IN CONSULTATION WITH SITE IN-CHARGE.															
7.	ALL PIPE SIZES ARE IN MM. AND NOMINAL DIA . ONLY															
8.	THE SPACING OF FIRE PIPE SUPPORTS FOR SPRINKLER / CLEVIS HANGER SHALL NOT BE MORE THAN THAT SPECIFIED BELOW:-															
<table><tr><th>Nominal pipes diameter (mm)</th><th>Spacing between suppts (meter)</th><th>Support / Hanger rod diameter (mm)</th></tr><tr><td>Up to 25</td><td>2.00</td><td>8</td></tr><tr><td>32 to 50</td><td>2.50</td><td>8</td></tr><tr><td>65 to 80</td><td>2.50</td><td>10</td></tr><tr><td>100</td><td>2.50</td><td>12</td></tr></table>		Nominal pipes diameter (mm)	Spacing between suppts (meter)	Support / Hanger rod diameter (mm)	Up to 25	2.00	8	32 to 50	2.50	8	65 to 80	2.50	10	100	2.50	12
Nominal pipes diameter (mm)	Spacing between suppts (meter)	Support / Hanger rod diameter (mm)														
Up to 25	2.00	8														
32 to 50	2.50	8														
65 to 80	2.50	10														
100	2.50	12														
NOTE :- 1)EXTRA SUPPORTS SHALL BE PROVIDED AT THE BENDS AND AT HEAVY FITTINGS LIKE VALVES TO AVOID UNDUE STRESS ON THE PIPES. 2)THE THICKNESS OF CLAMP SHOULD BE MINIMUM 3mm																
9.	THE SUPPORT FOR 150 / 200mm DIA. PIPE SHALL BE BY 50x50x6mm MS ANGLE IRON @ 3.0 M. C/C (MAXIMUM).															
10.	THE SUPPORT DRILLING FOR FIRE PIPE HAS TO BE CO-ORDINATED WITH ELECTRICAL / FIRE ALARM / LV DRAWING TO AVOID ANY DAMAGE IN CONDUIT.															

Rev. no.	Date	

Project
PROPOSED COMMERCIAL BUILDING AT COMMERCIAL PLOT NO. 1G, PINWOOD ENCLAVE, SECTOR-2, WAVE CITY, GZB.

Title
TERRACE ROOF LAYOUT

Subtitle
FIRE FIGHTING LAYOUT

drawing released for

☐ APPROVAL

☐ SUBMISSION

☐ ADVANCE COPY

☐ CONSTRUCTION

drg. no.

FF-T.F-01

scale

NTS

date

07.06.2025

drawn by: HIMANSHU

designed by: HIMANSHU

checked by: D.K.

Architects

DIVYAKASH ATELIER INC

ARCHITECTURAL . INTERIOR . PLANNING CONSULTANTS

407, ORBIT PLAZA, CROSSING REPUBLIK, GHAZIABAD
CONTACT US : - +91-9999609559
E mail- groupdivyakash@gmail.com

MEP Consultant:





WeDESIGN Associates



"Engineered to perfection"

Email - wedesignassociates@gmail.com

Mob. - 9999288416, 9999288407, 9882244495

LEGEND:-		
S.NO.	DESCRIPTION	SYMBOL
FIRE HOSE CABINET		FHC
FIRE HOSE CABINET COMPRISING OF:		
1. a.	1 NO. S.S.LANDING VALVE	
b.	1 NO. HOSE REEL DRUM WITH 30mtr. RUBBER HOSE	
c.	2 NOS. 15mtr. LONG RRL HOSE	
d.	1 NO. S.S.BRANCH PIPE	
e.	1 NO. 9 LTR WATER TYPE FIRE EXTINGUISHERS	
f.	1 NO. 5KG ABC TYPE FIRE EXTINGUISHERS	

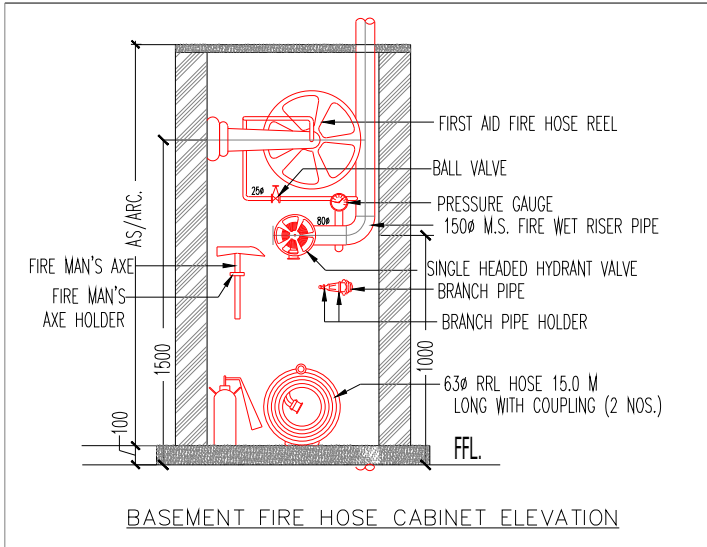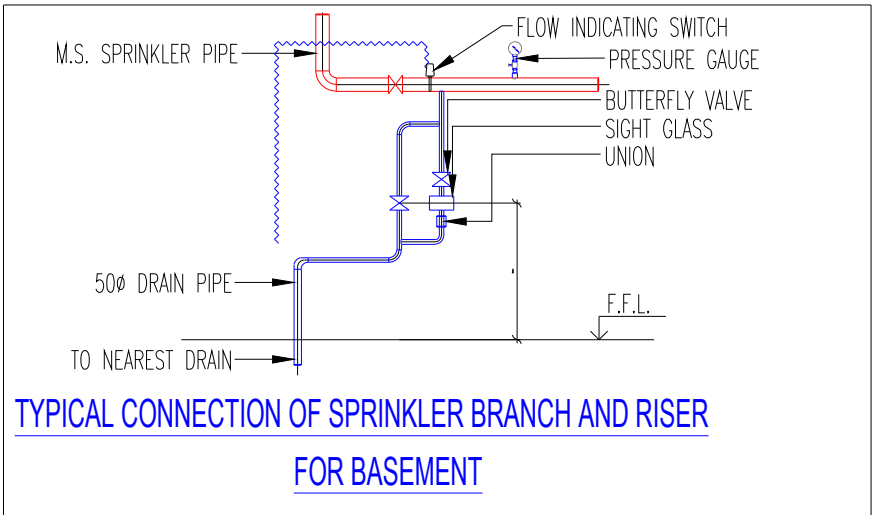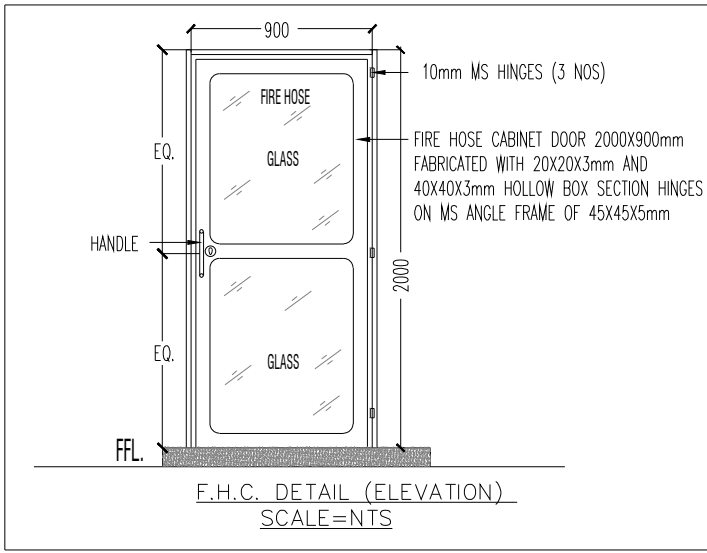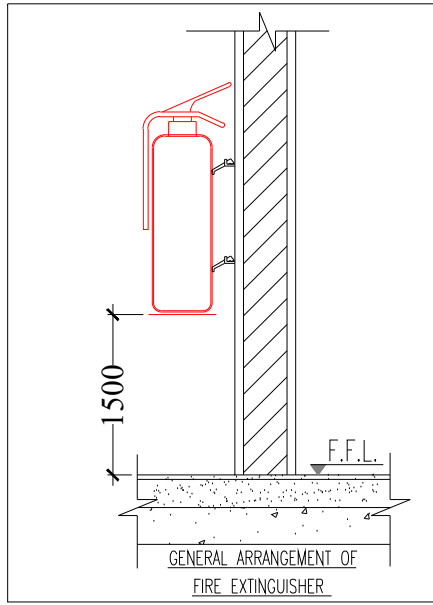

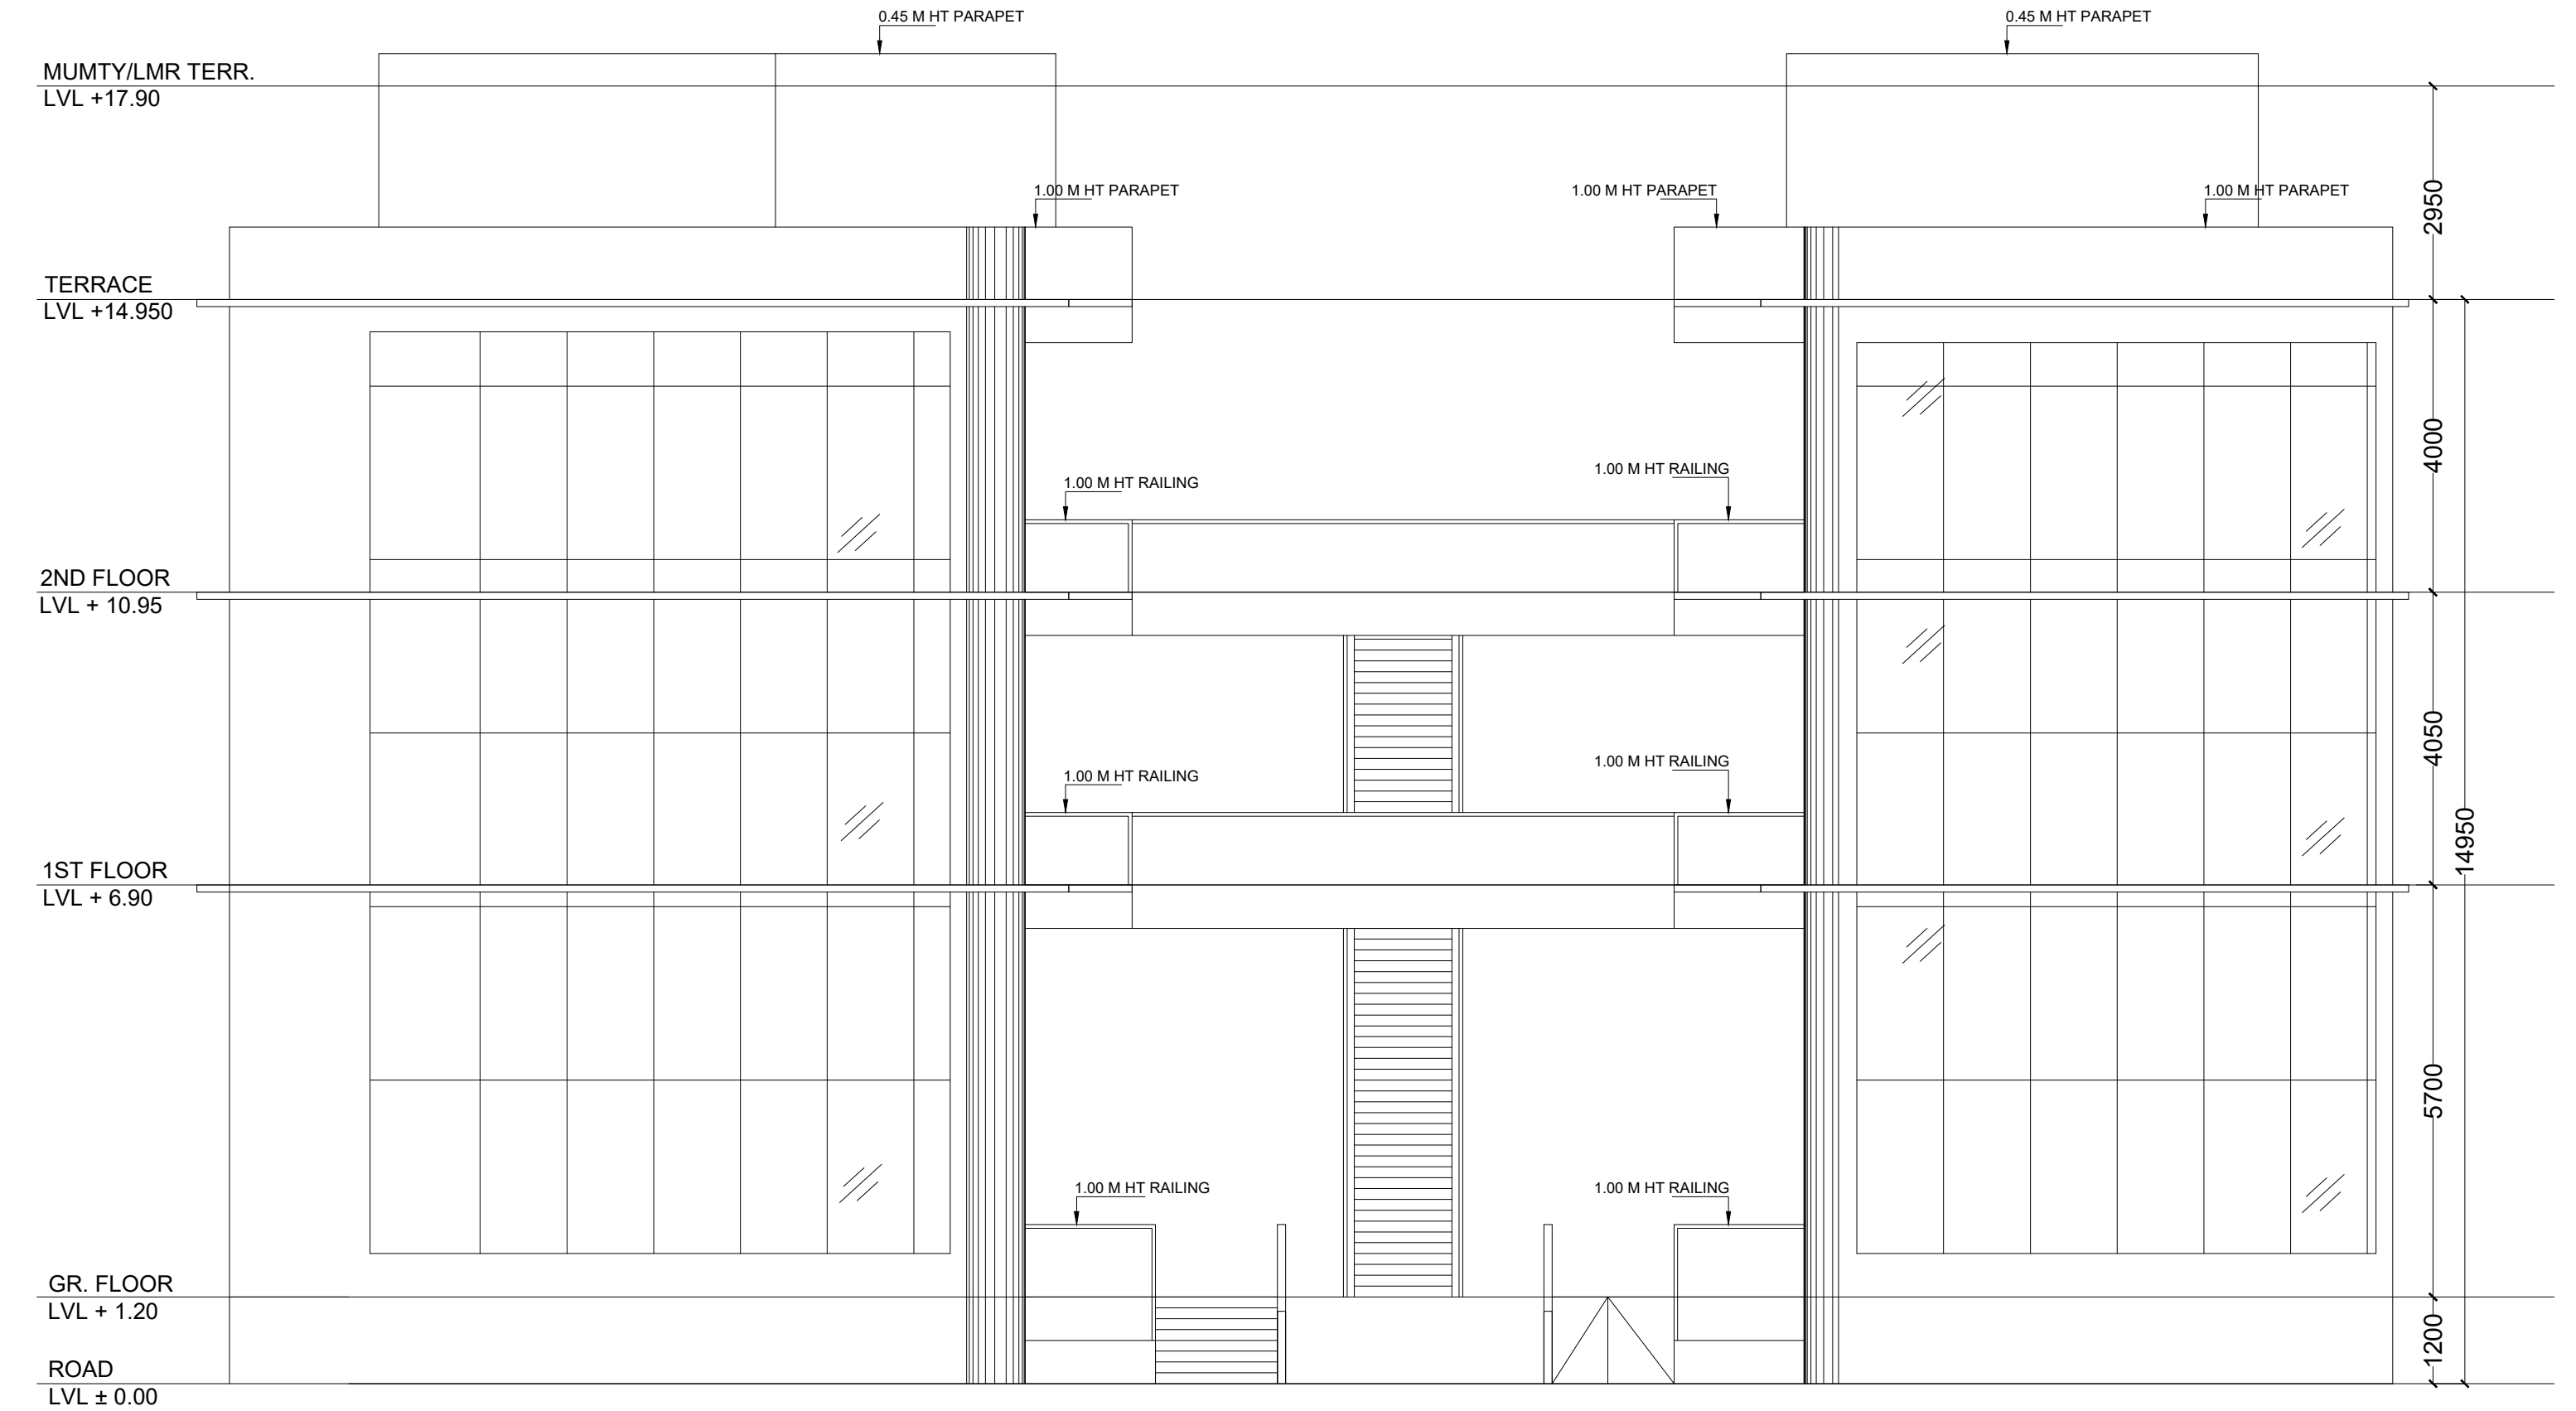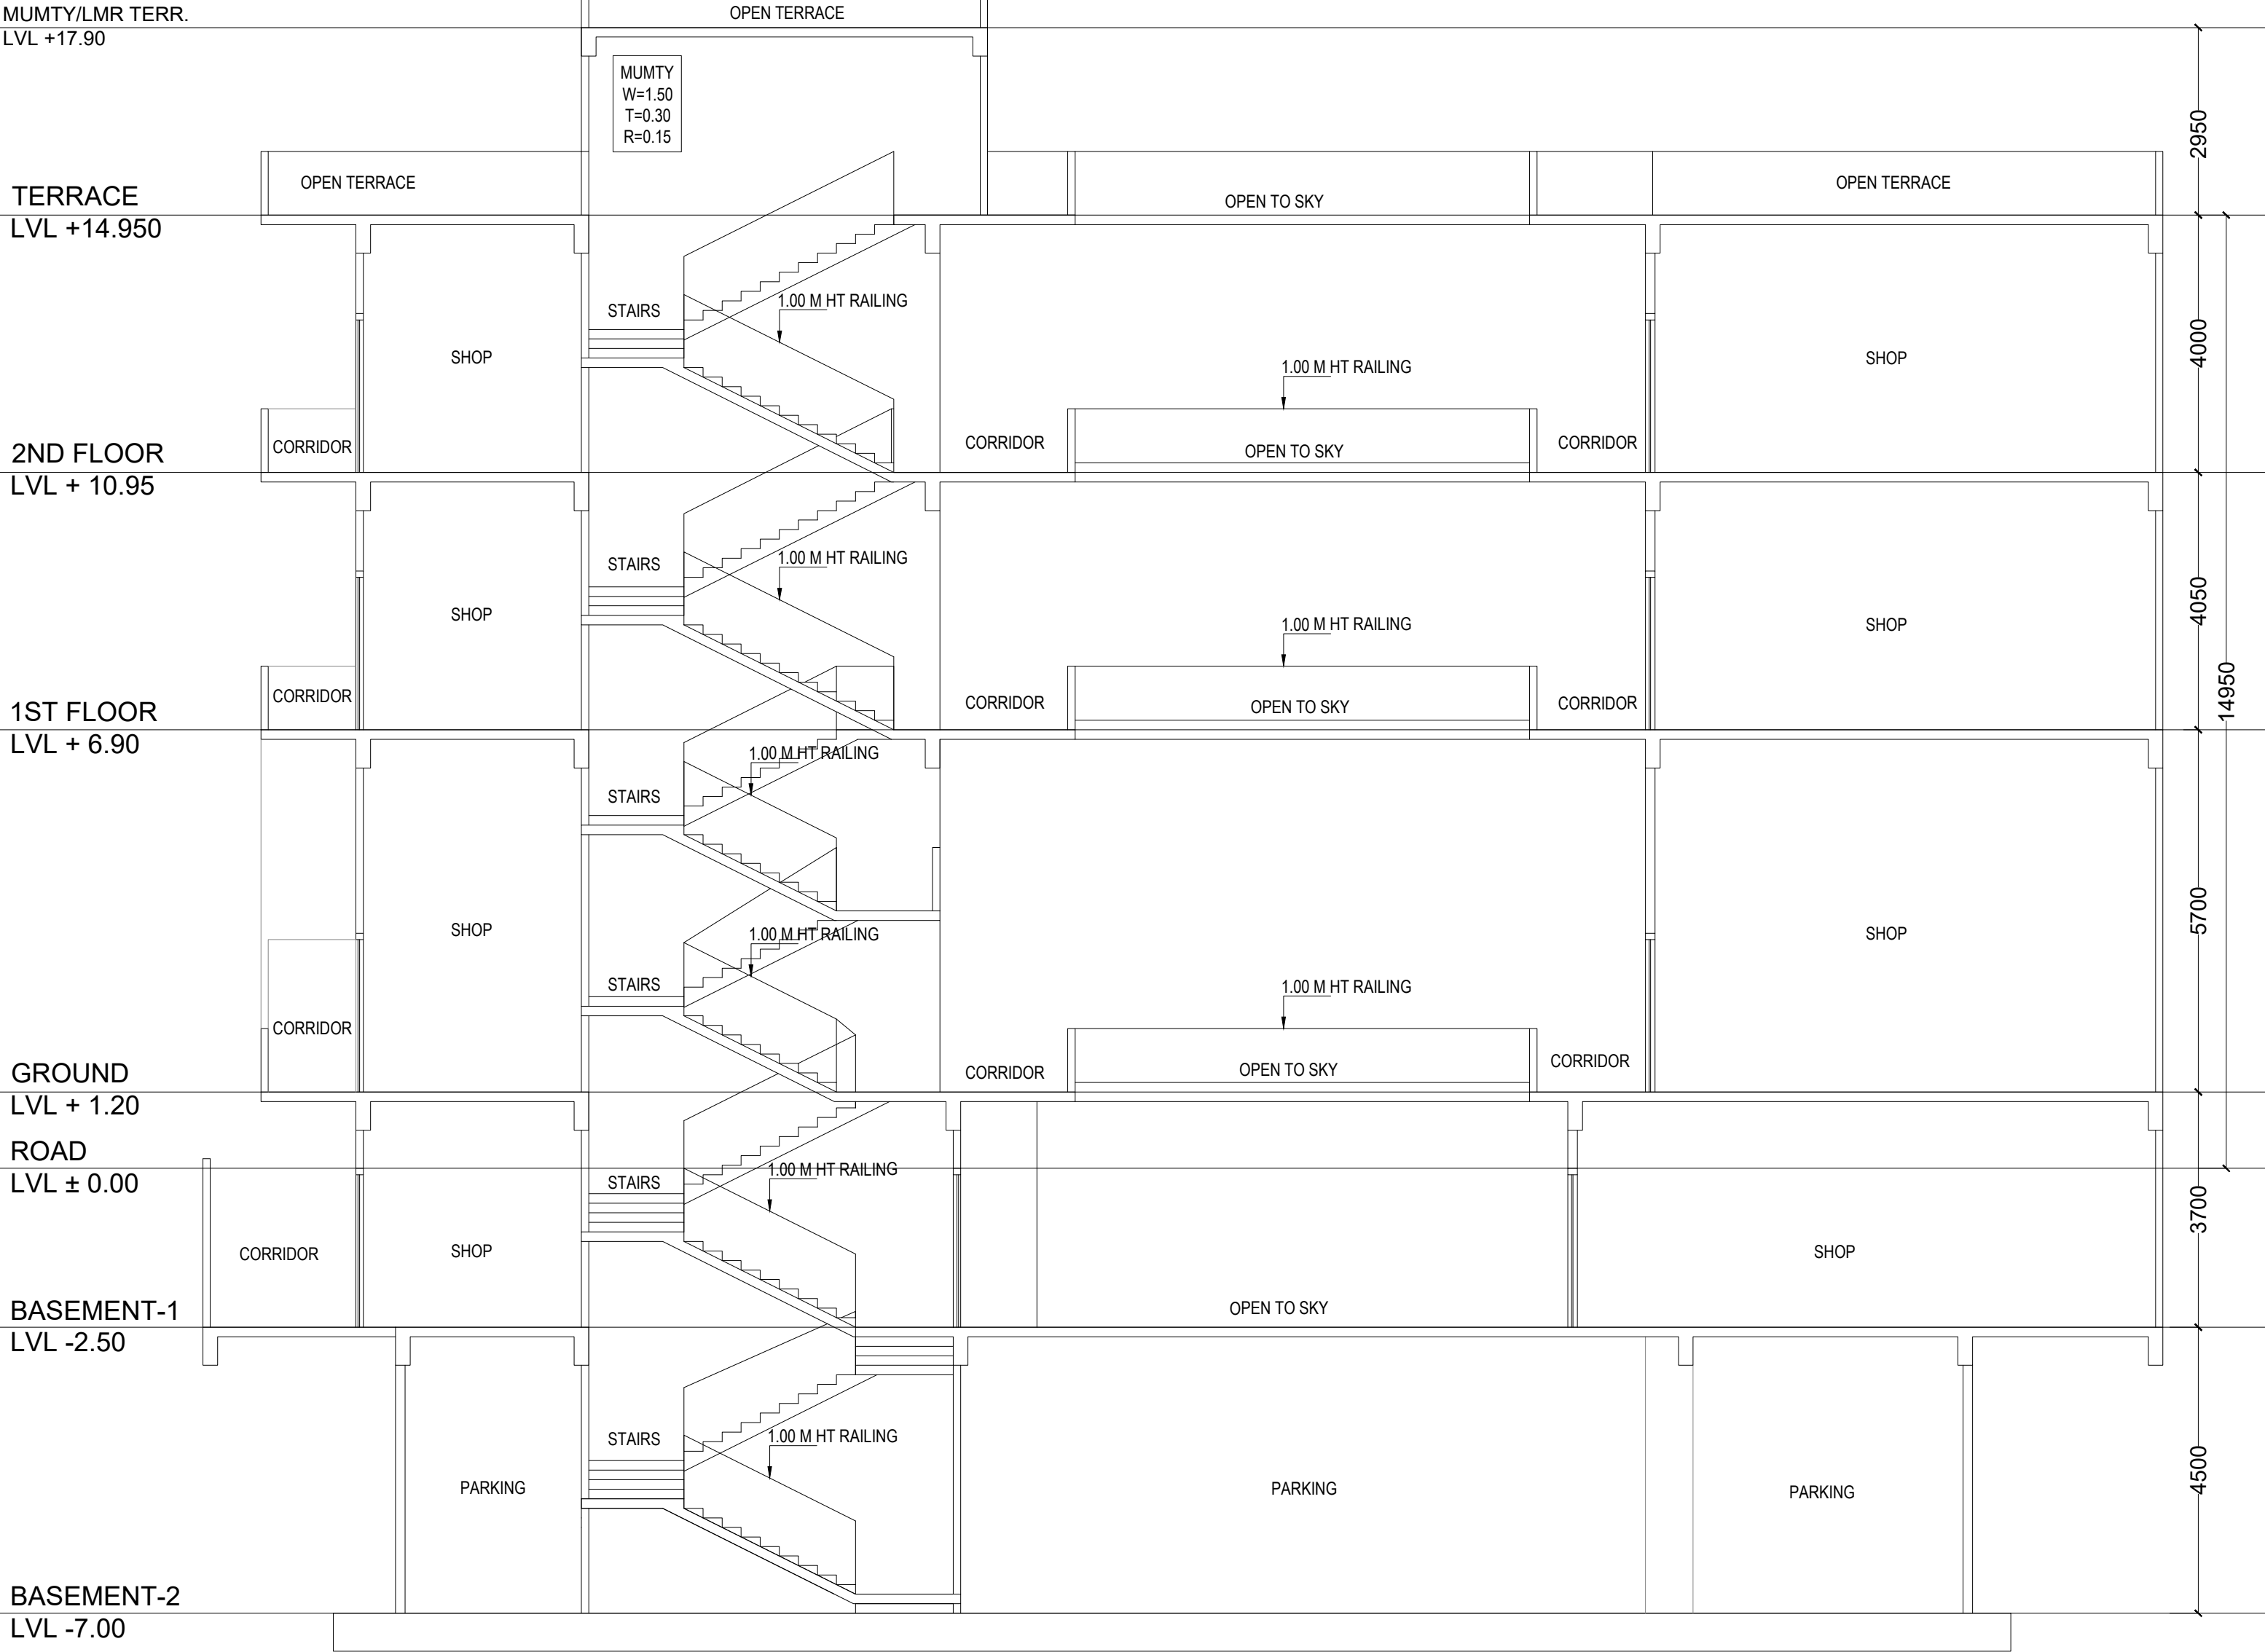

FRONT ELEVATION

Rev. no.	Date	

Project
**PROPOSED COMMERCIAL BUILDING AT
COMMERCIAL PLOT NO. 1G, PINWOOD
ENCLAVE, SECTOR-2, WAVE CITY, GZB.**

Title
ELEVATION AND SECTION

Subtitle
FIRE FIGHTING LAYOUT

drawing released for
☐ APPROVAL ☐ SUBMISSION
☐ ADVANCE COPY ☐ CONSTRUCTION

drg. no. FF-1ST.BF-01 drawn by: HIMANSHU

scale NTS designed by: HIMANSHU

date 07.06.2025 checked by: D.K.

Architects
**DIVYAKASH
ATELIER INC**
ARCHITECTURAL . INTERIOR . PLANNING
CONSULTANTS
407, ORBIT PLAZA, CROSSING REPUBLIK, GHAZIABAD
CONTACT US :+91- 999609559
E mail: groupdivyakash@gmail.com

MEP Consultant:



WeDESIGN Associates
"Engineered to perfection"
Email - wedesignassociates@gmail.com
Mob: - 9999288416, 9999288407, 9882244495