



S.No.	DESCRIPTION	SYMBOL
1.	DOMESTIC WATER SUPPLY RISER LINE	
2.	FLUSHING WATER SUPPLY RISER LINE	
3.	MUNICIPAL WATER SUPPLY LINE	
4.	BORE WELL WATER SUPPLY LINE	
5.	IRRIGATION WATER SUPPLY LINE	
6.	GARDEN HYDRANT	

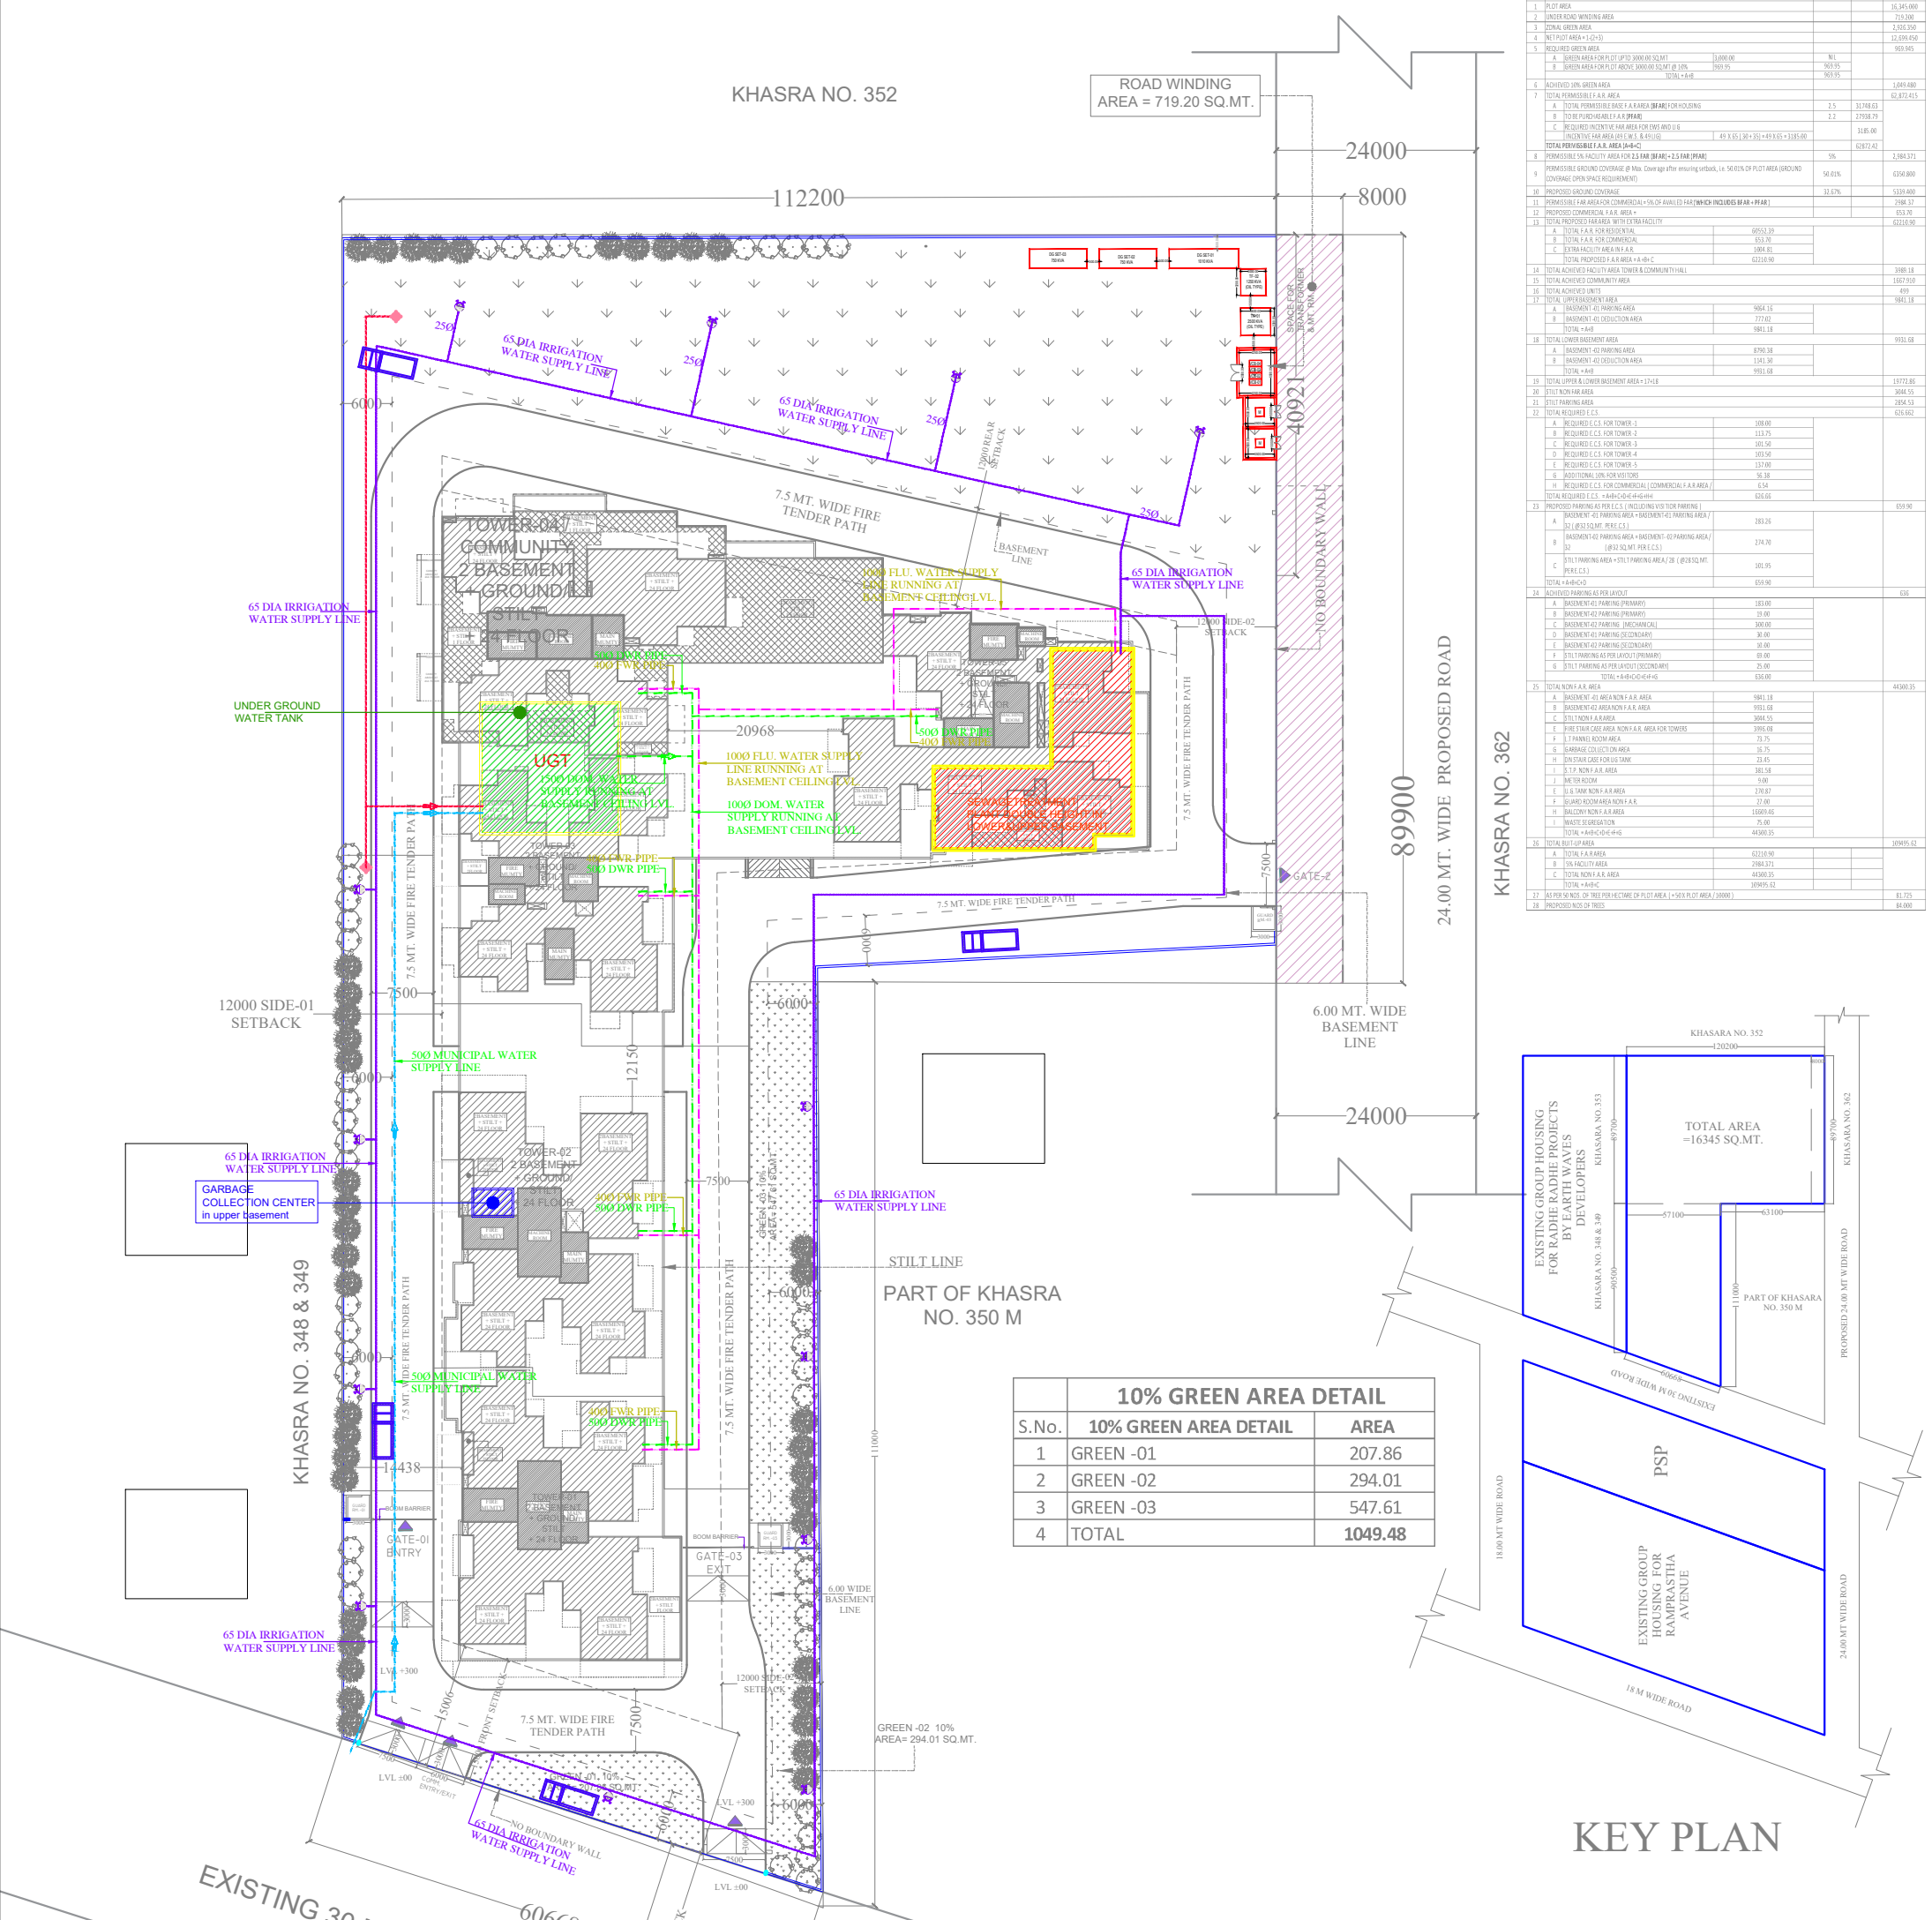

S.No.	10% GREEN AREA DETAIL	AREA
1	GREEN -01	207.86
2	GREEN -02	294.01
3	GREEN -03	547.61
4	TOTAL	1049.48

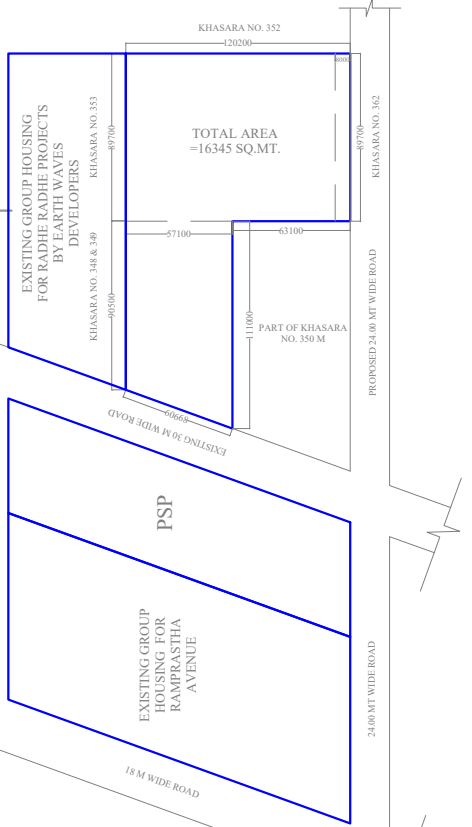

KEY PLAN

SITE PLAN

PROJECT :-
 PROPOSED GROUP HOUSING "SG ORCHARD"
 AT KHASRA NO - 351 & 350M,
 VILL. BHOVAPUR, PARGANA,
 JALALABAD, GHAZIABAD

BUILDERS & PROMOTER :-
 SG. ESTATE PVT. LTD.

DRAWING TITLE :-
 WATER SUPPLY PLAN

ARCHITECTS :-
Space Designers International
 B - 34, SECTOR-67, NOIDA
 PH : +91 9711633717, 18, 19 & 20
 Mob: 9811070399, 9811336231
 e-mail : spacesdi@gmail.com, www.spacedi.com

DRAWN BY :- KAMAL
 CHECKED BY :- PKS
 SCALE :- NTS.
 DATED :- 03-01-2026

OWNER NAME:- GAURAV GUPTA

For S.G. Estates Pvt. Ltd.
 Director

ARCHITECT'S SIGN.

 DRG.NO.-PL-02

S.No.	DESCRIPTION	SYMBOL
1.	DOMESTIC WATER SUPPLY RISER LINE	
2.	FLUSHING WATER SUPPLY RISER LINE	
3.	MUNICIPAL WATER SUPPLY LINE	
4.	BORE WELL WATER SUPPLY LINE	
5.	IRRIGATION WATER SUPPLY LINE	
6.	GARDEN HYDRANT	

Missing or invalid reference
 File: C:\Users\narendra\Desktop\23-08-2025\Google Maps sg.pdf
 Sheet: 1

SITE SUPERIMPOSED ON GOOGLE IMAGE

MEP CONSULTANT:

PKV Consulting Engineers (P) Ltd.
 C-815, DDA Flats, Loni Road, Delhi - 110003
 TELE FAX - 011-22816207
 E-mail: pramod@pkv.co.in
 info@pkv.co.in

