


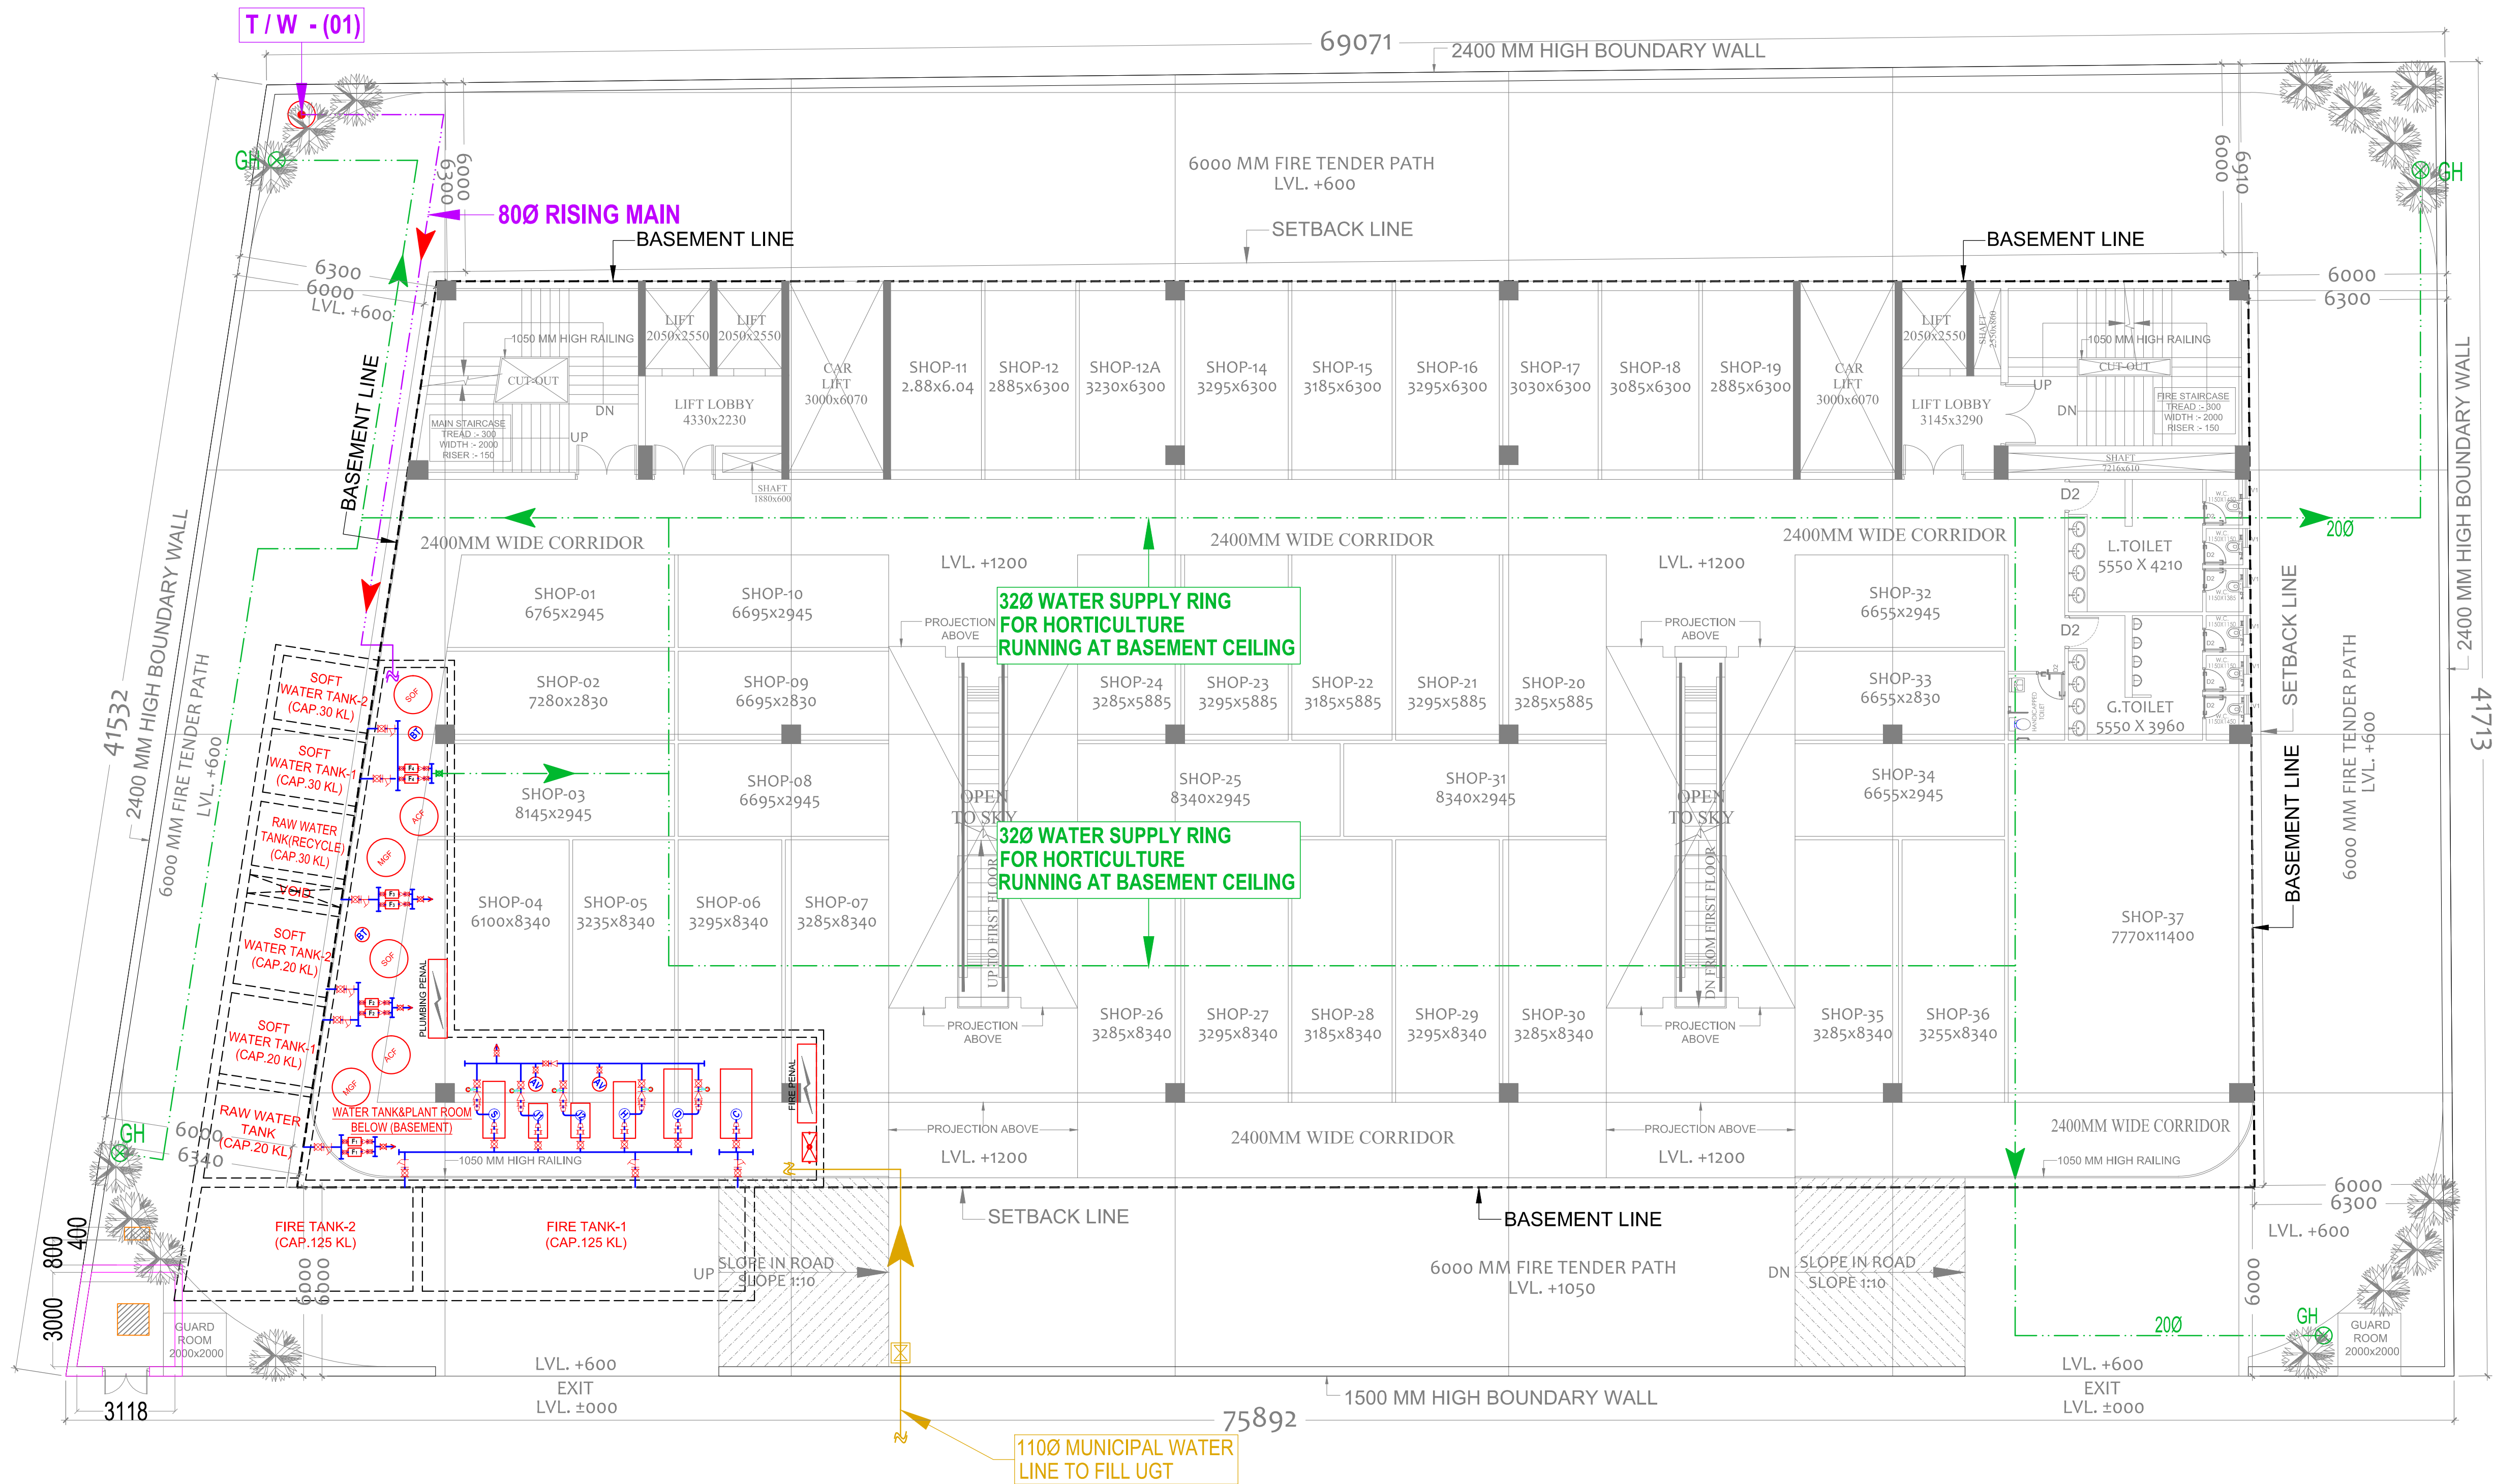

| LEGEND : PLUMBING SYSTEM |        |                                             |
|--------------------------|--------|---------------------------------------------|
| S. No.                   | SYMBOL | DESCRIPTION                                 |
| 1.                       |        | MUNICIPAL WATER SUPPLY PIPE LINE.           |
| 2.                       |        | RECYCLED WATER SUPPLY LINE FOR HORTICULTURE |
| 3.                       |        | GARDEN HYDRANT                              |
| 4.                       |        | MASONRY CHAMBER FOR ISOLATING VALVE         |
| 5.                       |        | RIISING MAIN LINE (FROM T/W TO U.G.T.)      |
| 6.                       |        | PROPOSED TUBE WELL                          |
| 7.                       |        | BASEMENT RETAINING WALL                     |

|          |      |          |
|----------|------|----------|
| ..       | ..   | ..       |
| rev. no. | date | revision |

project  
**PROPOSED SUBMISSION DRAWING FOR**  
COMMERCIAL CENTER-05, DUDA HERA, GHAZIABAD, UP.

Owner  
**GOLD COAST DEVELOPERS PVT. LTD.**  
A-106, POCKET-4, PANDAV NAGAR, MAYUR VIHAR, DELHI- 110091

title  
**SITE PLAN**

subtitle  
**EXTERNAL WATER SUPPLY LAYOUT**

drawing released for  
☐ APPROVAL ☒ SUBMISSION  
☐ ADVANCE COPY ☐ CONSTRUCTION

drg. no. CES / G.C / SP / P-04 drawn by Sandeep

scale 1:125 @ A1 designed by Shakir Shabbir

date 16.09.2021 checked by Anand Havella

architects :  
**modarchindia**  
architects interior designers & planners  
studio: 1st floor, B-99, sector-63, Noida -201301, U.P.  
phone: 0120-4206253, email: amitganga@hotmail.com  
website: www.modarch.in

services consultant  
**Consummate Engineering Services (P) Ltd.**  
Noida Office : B - 67, Sector - 67, Noida - 201 301  
Tel : (0120) 2303500 ( 30 Lines )  
Lko. Office : R 006, Rohas Plumeria, Gomti Nagar, Lucknow  
e mail : mail@cespl.in, website : www.cespl.in