


COMMERCIAL ESS-1

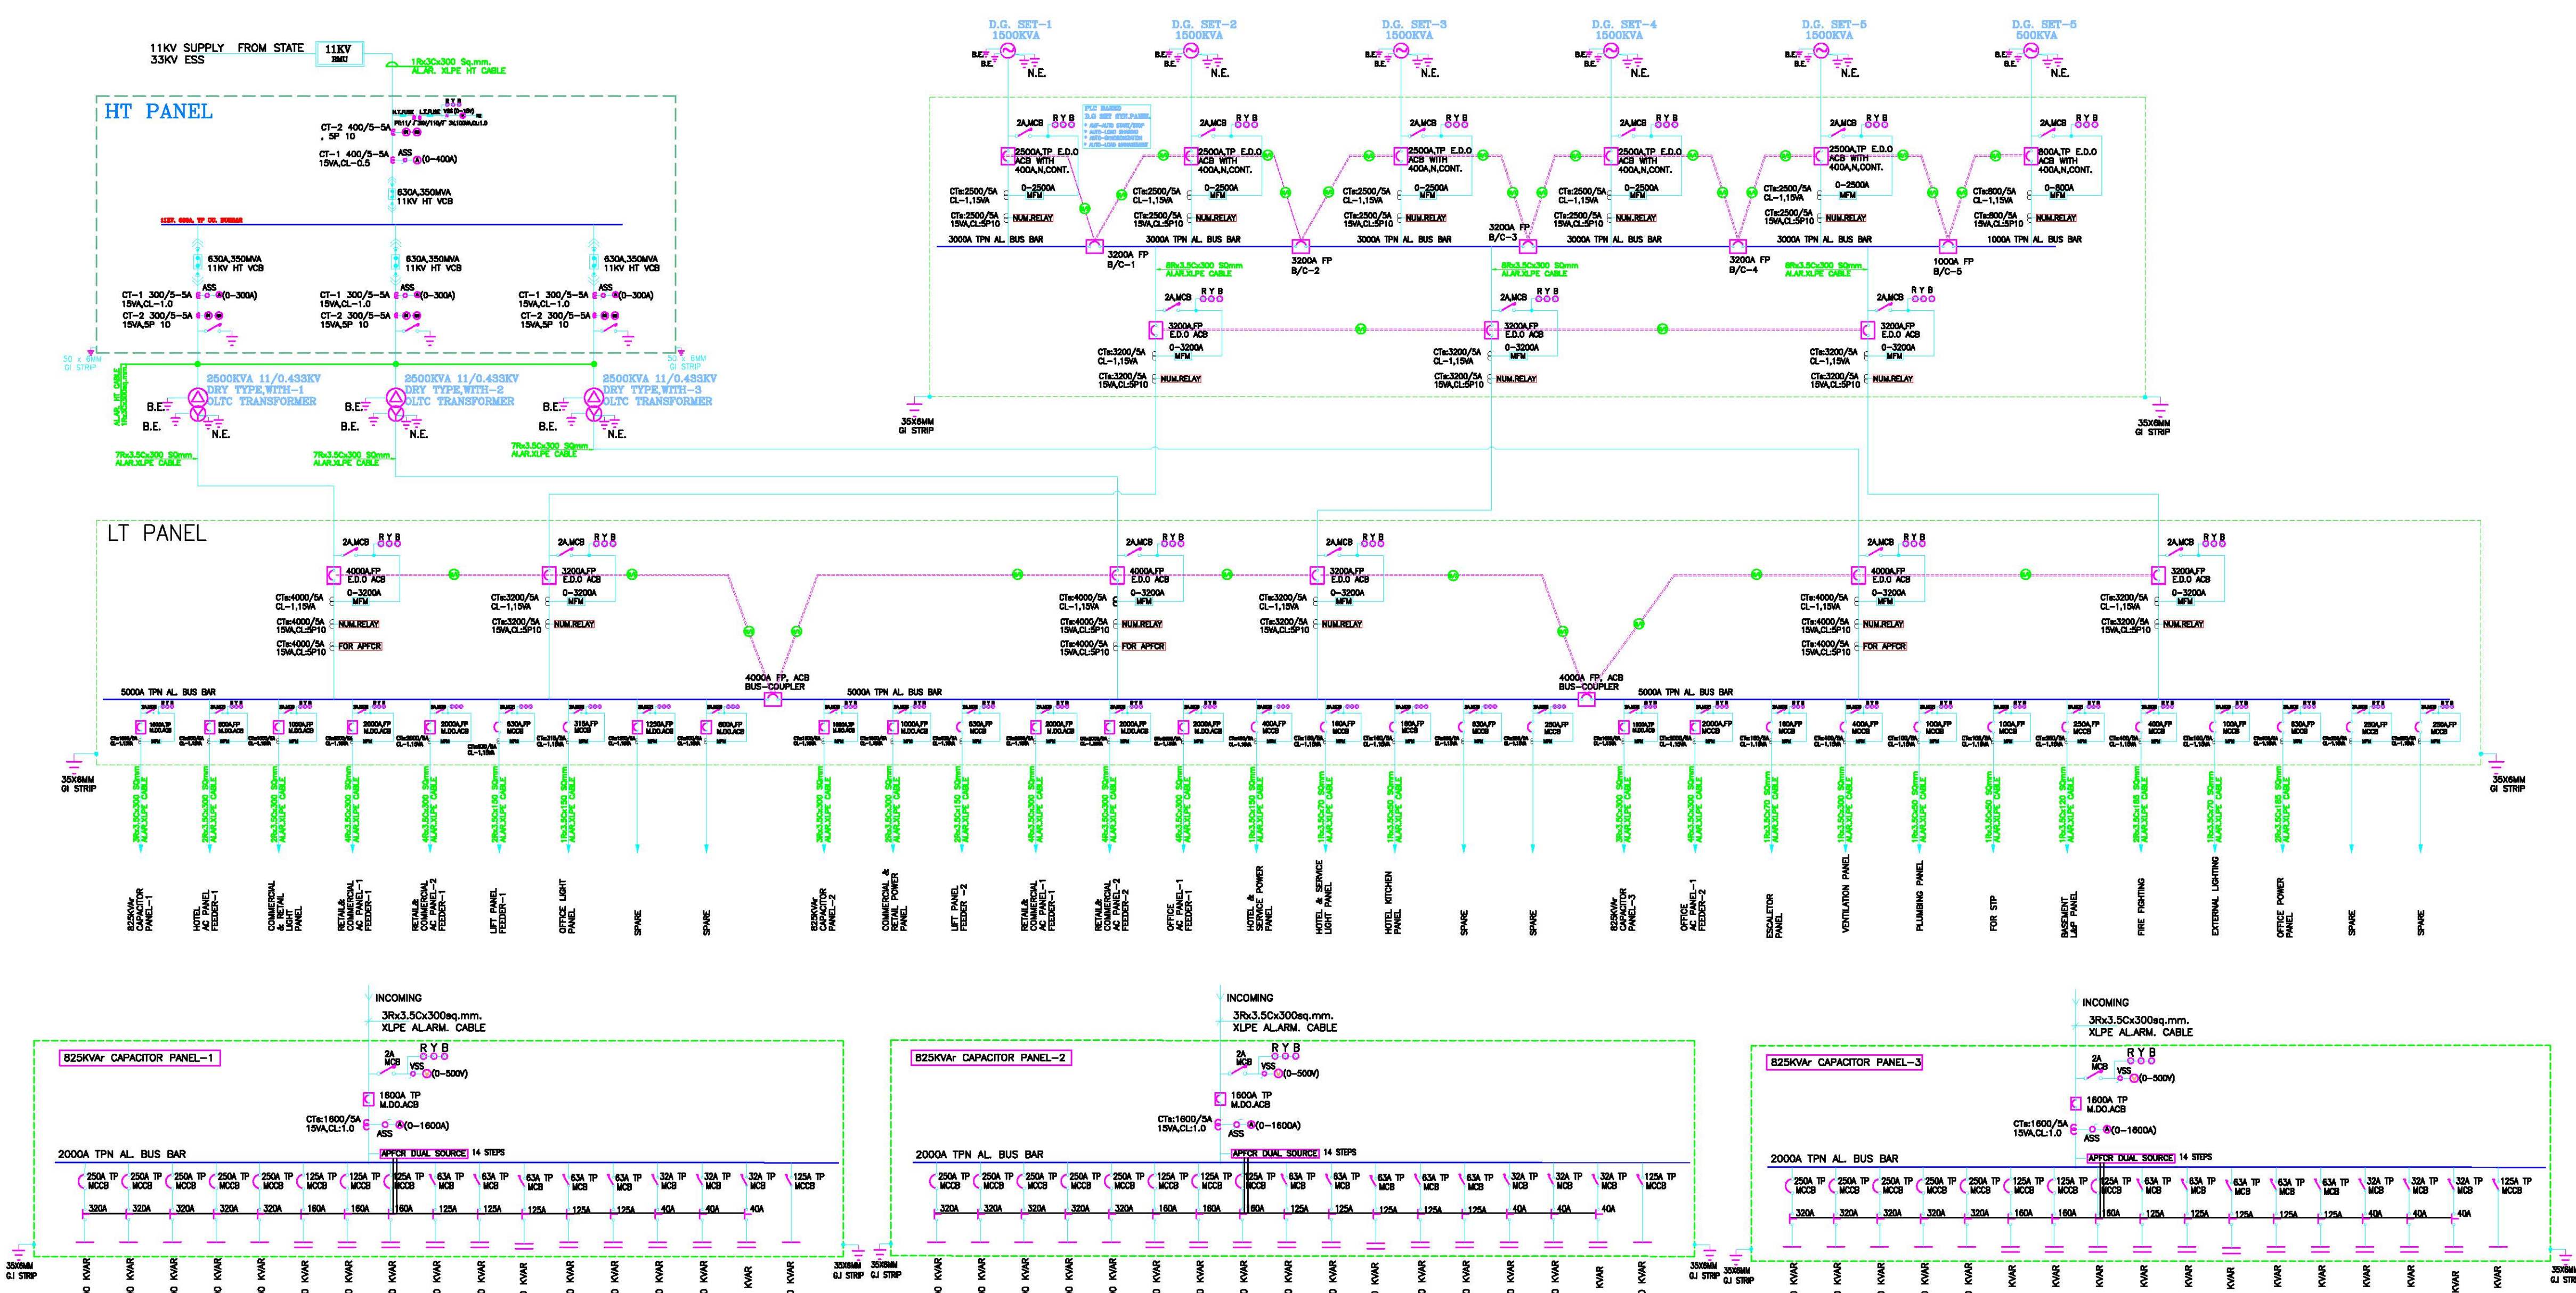

LEGEND FOR 33KV :-

	CURRENT TRANSFORMER
	POTENTIAL TRANSFORMER
	FUSE
	AMMETER
	AMMETER SELECTOR SWITCH
	VOLT METER
	VOLTMETER SELECTOR SWITCH
	MOULDED CASE CIRCUIT BREAKER (MCCB)
	AIR CIRCUIT BREAKER(ACB)
	MINIATURE CIRCUIT BREAKER
	LED INDICATING LAMPS
	KWH METER
	AUTO MANUAL SELECTOR SWITCH
	REVERSE POWER RELAY
	PHASE SEQUENCE RELAY
	MASTER TRIP RELAY
	CAPACITOR BANK
	TRANSFORMER
	VACUUM CIRCUIT BREAKER (VCB)
	INTER LOCKING
	EARTHING
	MULTI FUNCTIONAL METER

DATE REV DESCRIPTION BY

MEP CONSULTANT:

V.S. KUKREJA & ASSOCIATES PVT. LTD.
CONSULTING ENGINEERS
165-A,GAUTAM NAGAR
NEW DELHI-110049 PH:26521075/76
FAX. 26967867
EMAIL:vsukreja@gmail.com

ARCHITECTS:

GIAN P. MATHUR & ASSOCIATES (P) LTD.
ARCHITECTS, ENGINEERS & PLANNERS
C-55,EAST OF KAILASH, NEW DELHI - 65
PH- 011-41624771, 41621129

PROJECT:

BEING DEVELOPED BY M/S PKS
BUILDSMART PVT. LTD.
PROPOSED BUILDING PLAN OF
COMMERCIAL AT
PLOT NO.- C4 , SECTOR-16B
GREATER NOIDA

DRAWING TITLE:

MAIN SINGLE LINE DIAGRAM

JOB NO.	VKPL-
DATE	02-11-2016
SCALE	NTS
DRAWN	SUNIL
CHKD. BY	ANIL
DRG.NO:	EL-SLD-01