


LEGEND :

	MANHOLE
	SEWAGE TREATMENT PLANT
	SOIL ,WASTE WATER PIPE/
	DRAIN PIPE
	TANK FILLING PIPE LINE

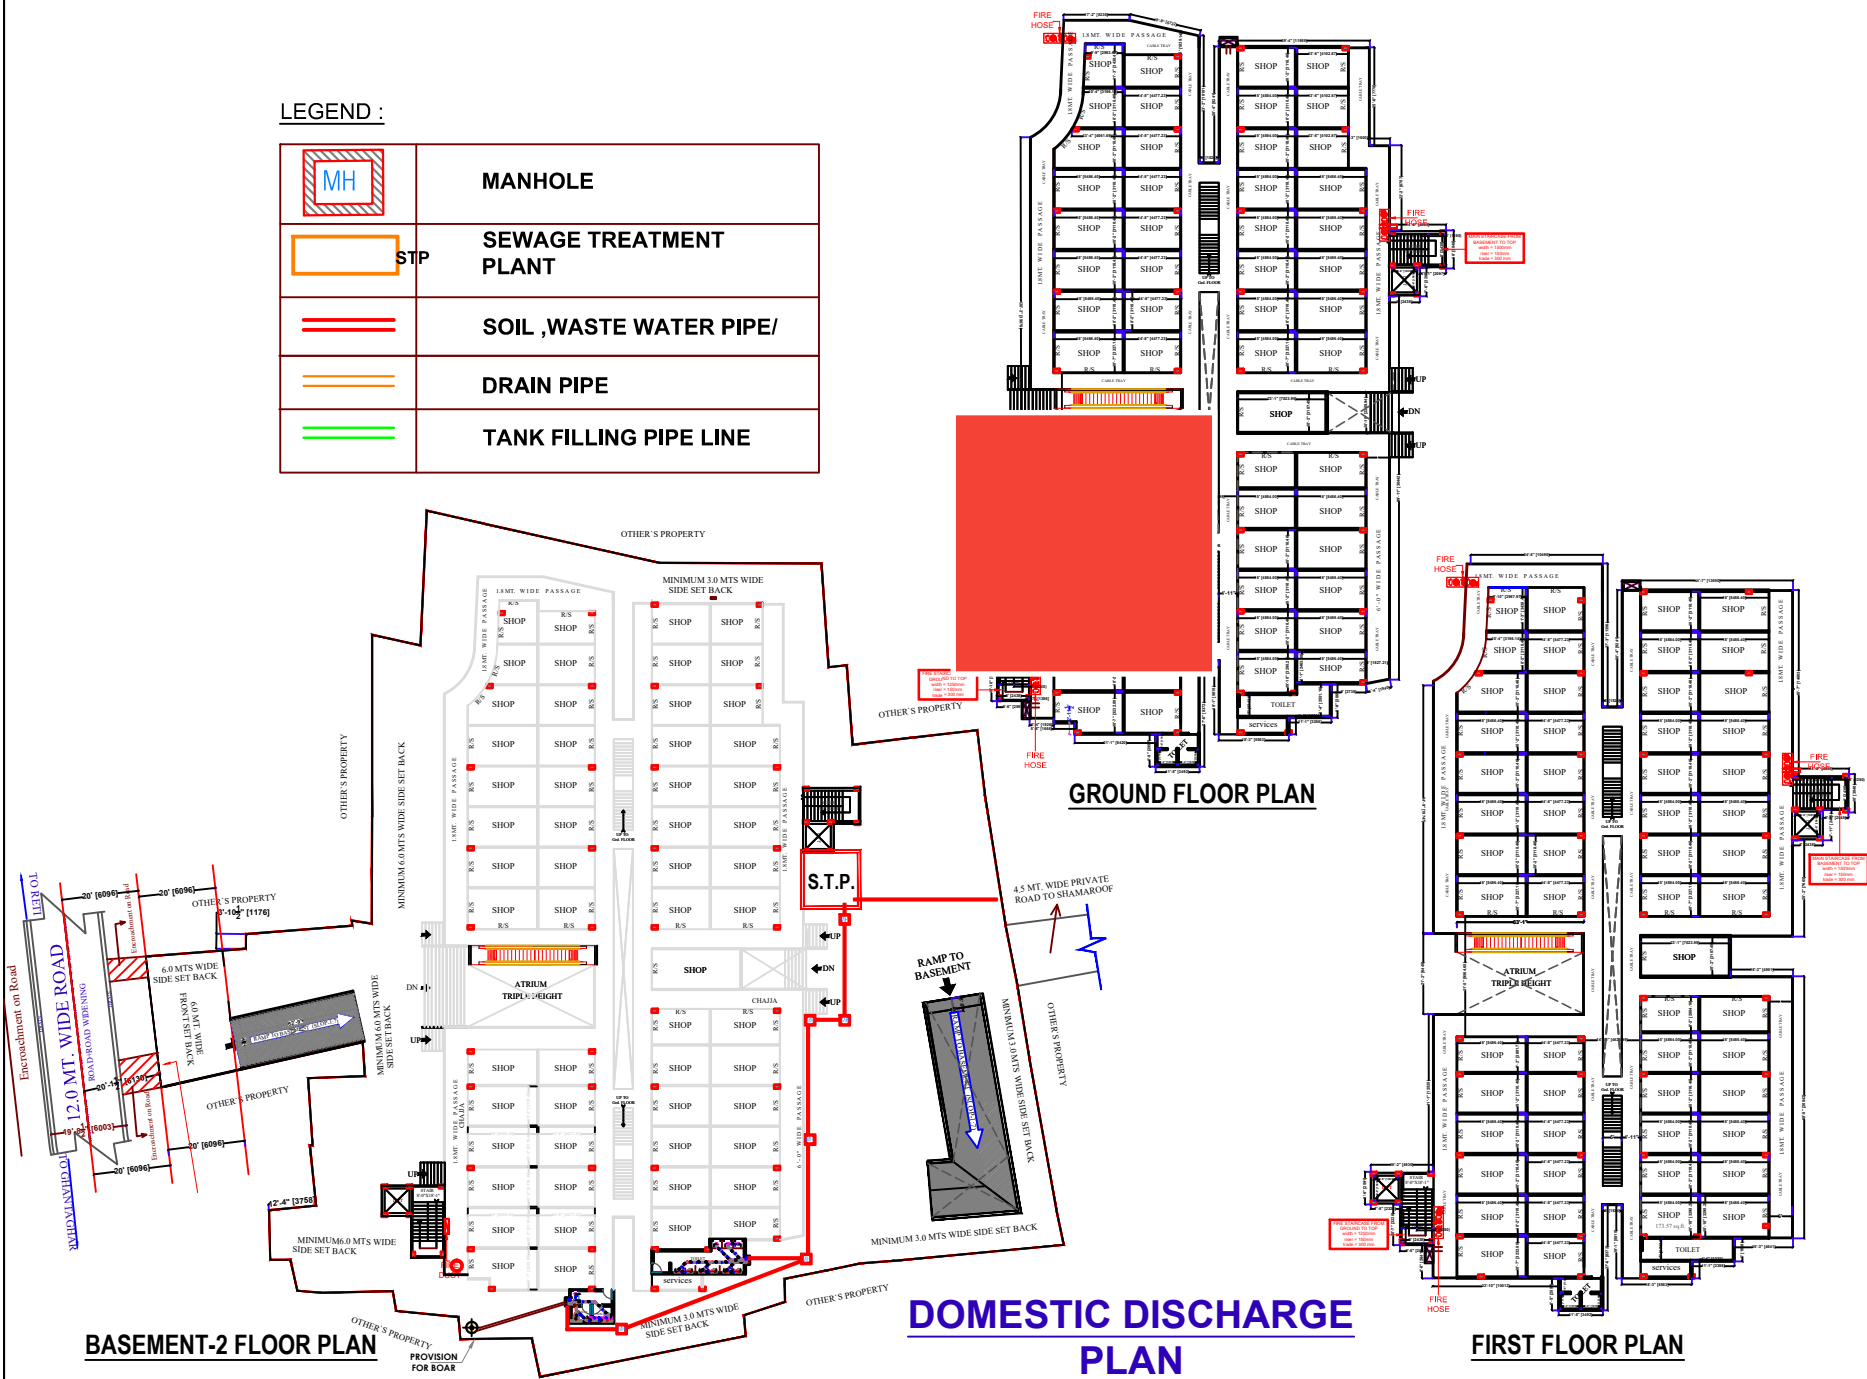

APPROVAL OF G.D.A.:

PROJECT TITLE

BASEMENT - 1
BASEMENT - 2
FIRST FLOOR PLAN
SECOND FLOOR PLAN
SECTION AT A-A
SECTION AT B-B
KEY PLAN

Sheet number 02

OWN BY:

CKD BY:

OWNER SIGN.

ACORE ARCHITECTURAL SERVICES PVT. LTD

ARCHITECT:ASHISH SRIVASTAVA (B. ARCH)

BRANCH OFFICE : 9380 MATRI ANCHAL NEAR
GORAKHNATH RAILWAY CROSSING GORAKHPUR

TEL: OFF:3294813,RESI:2255290, MOBILE:9415321836

