


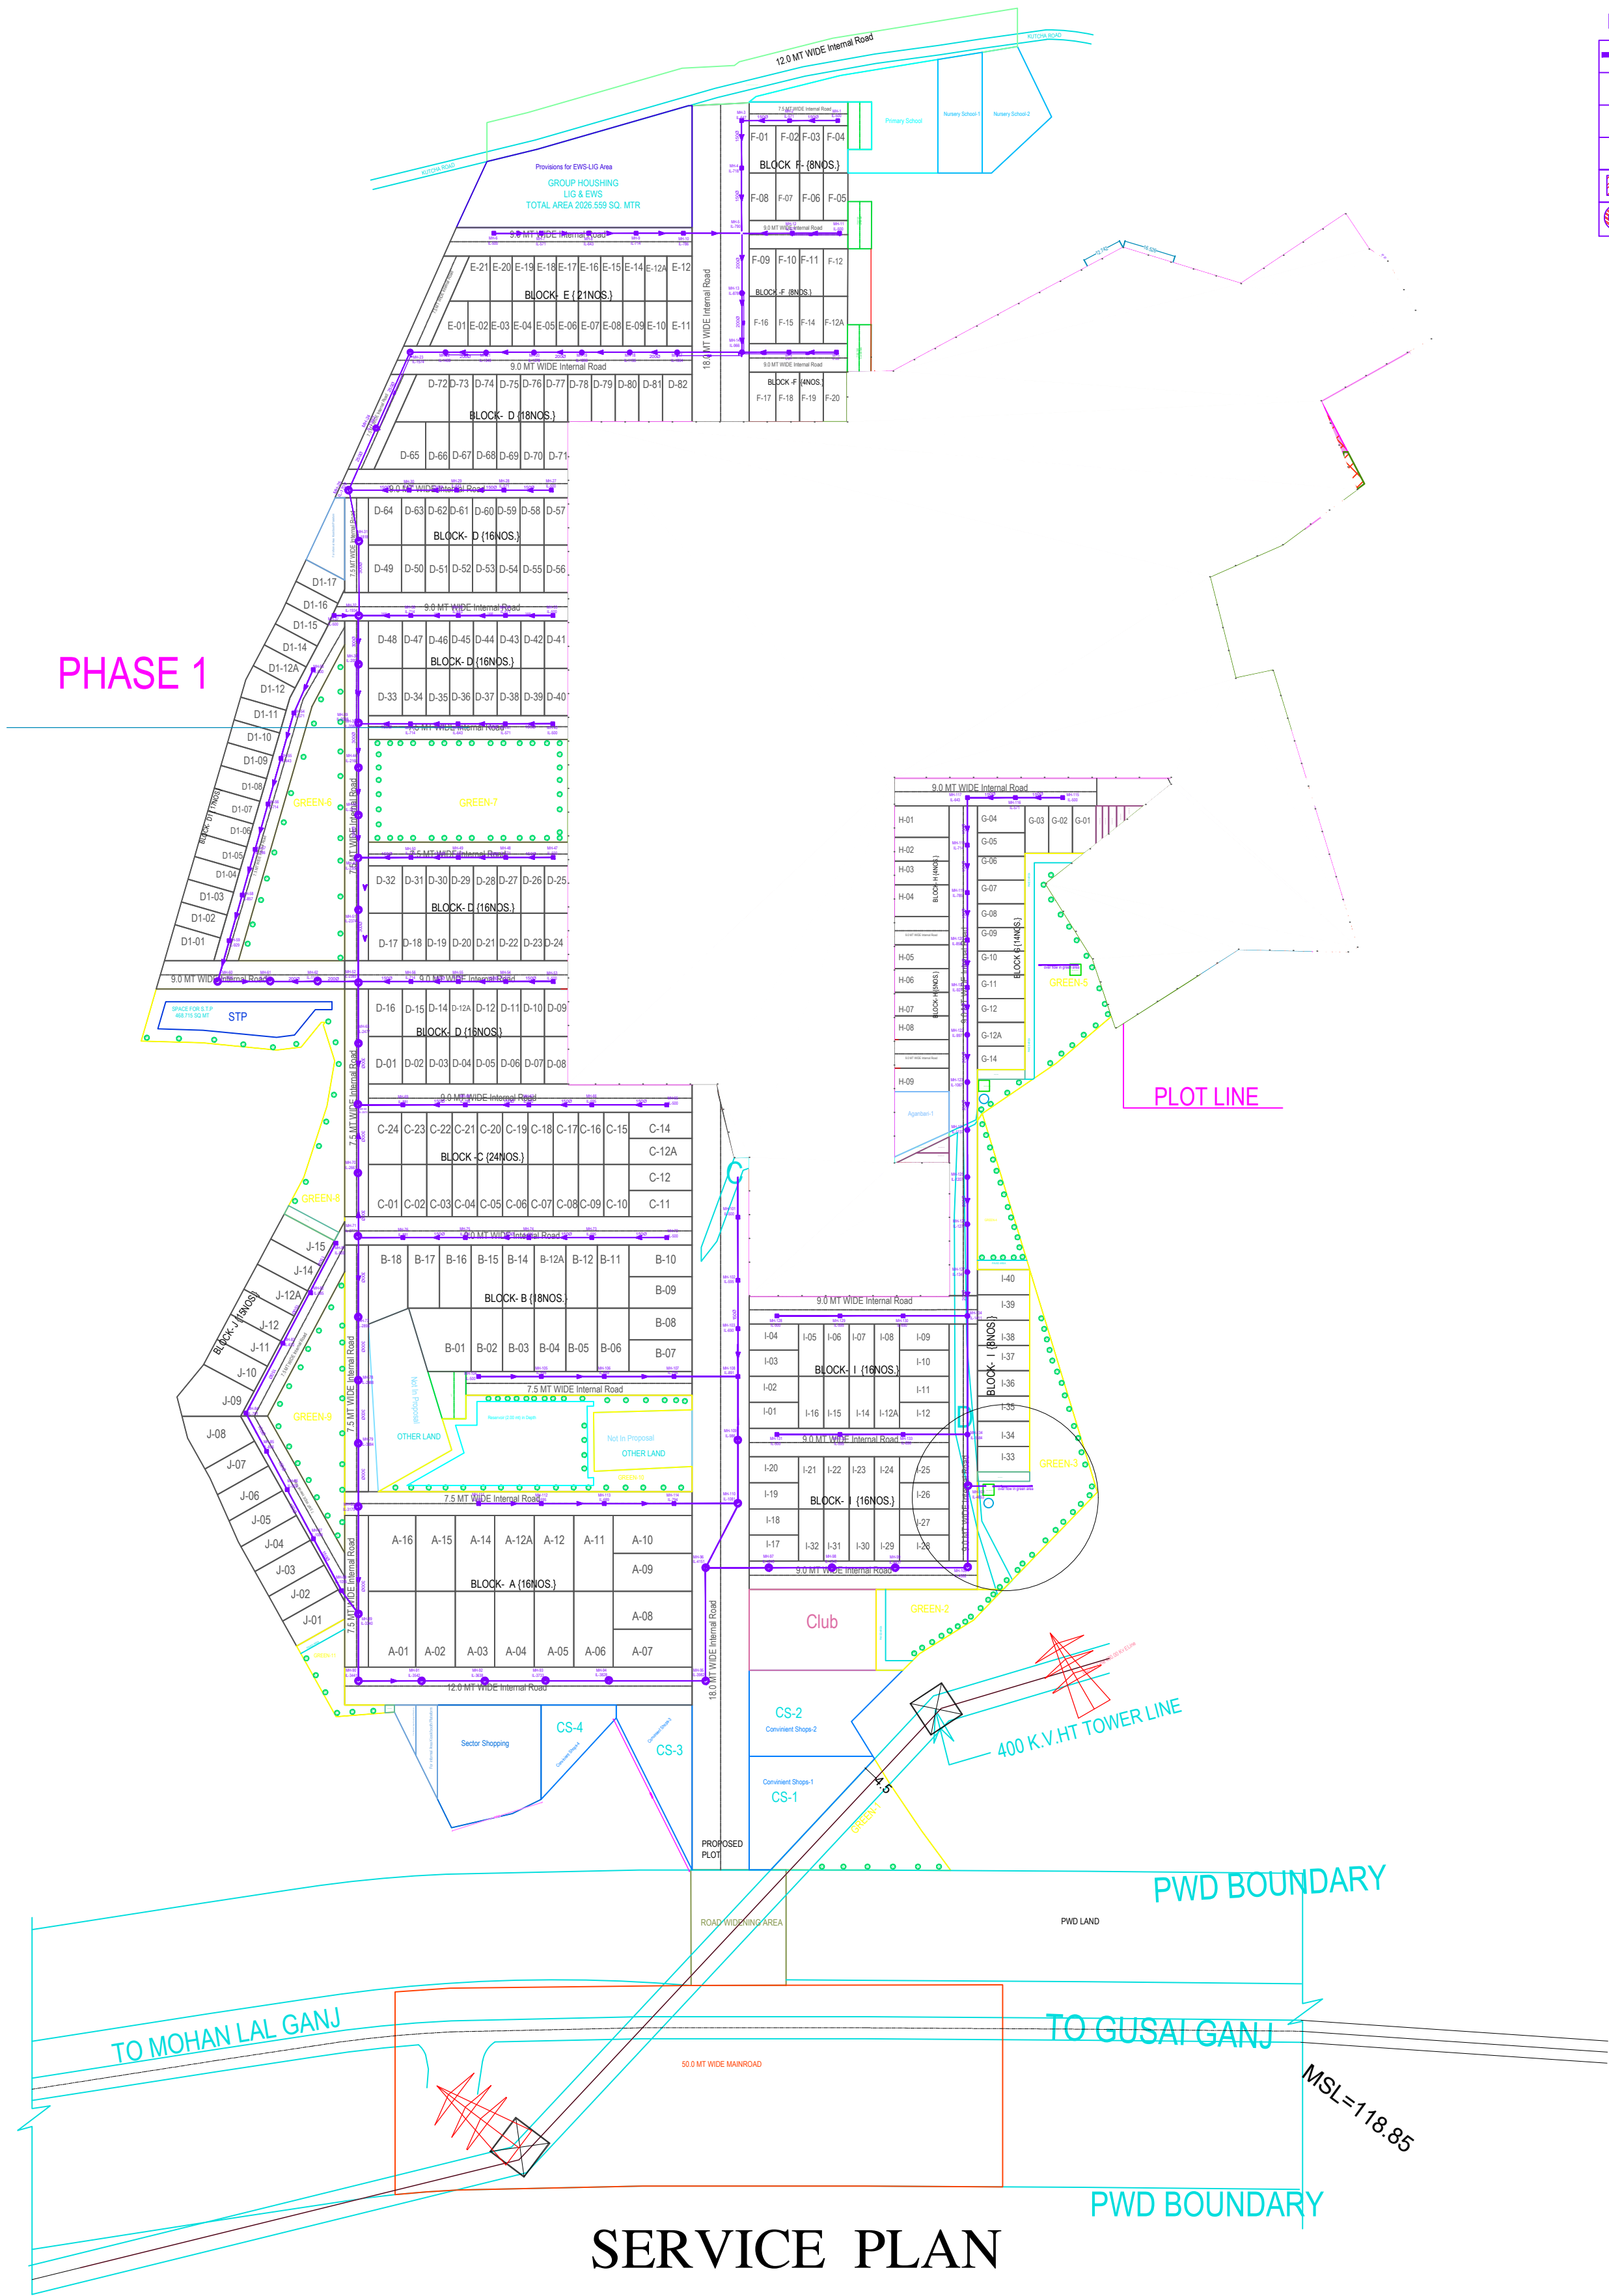

LEGEND FOR STORM WATER LINE	
	STORM WATER LINE
	2000 STORM WATER PIPE
	2500 STORM WATER PIPE
	3000 STORM WATER PIPE
	600X600 SEWERAGE MANHOLE
	9100/12200/15200 SEWERAGE MANHOLE

MEP CONSULTANT: M.S ASSOCIATES MEP CONSULTANT ENGINEERS B-400, Gali No.-10, Veerbazar Road Near Krishna Dramsala, Gaurav Nagar, Prem Nagar Part-II, Nangloi, New Delhi-110086 E-Mail: msassociates95@gmail.com, ajay20051978@yahoo.com Tel. 09213274289, 09555954522	PROJECT: Aashrayam Ph-1	DRG. NO. PL-03	ARCHITECTURE CONSULTANT - RAGHAVA ARCHITECTS Head office Indirapuram : Plot No. Cs-09, 2nd floor, Commerical Market, Gyan Khand-II, Near St. Thomas School, Indirapuram Ghaziabad-201014 (U.P) Branch office Wave City Shop No. 43, Dream Bazar, Dreams Homes, Housing Society, Sector-5, 57 Meter Road, Wavacity, NH-24, Ghaziabad - 201002 Indirapuram, Wave City, Lucknow Meerut +91 9810379715, 9891146128 www.raghavaarchitects.com raghavaarchitects@gmail.com
	DEVELOPER: M/s Agrasheel Infratech Private Limited	ORGL. DATE: 03-09-2024	
	DRAWING TITLE: EXTERNAL SITE PLAN STORM WATER LAYOUT PLAN PLUMBING DRAWING		