


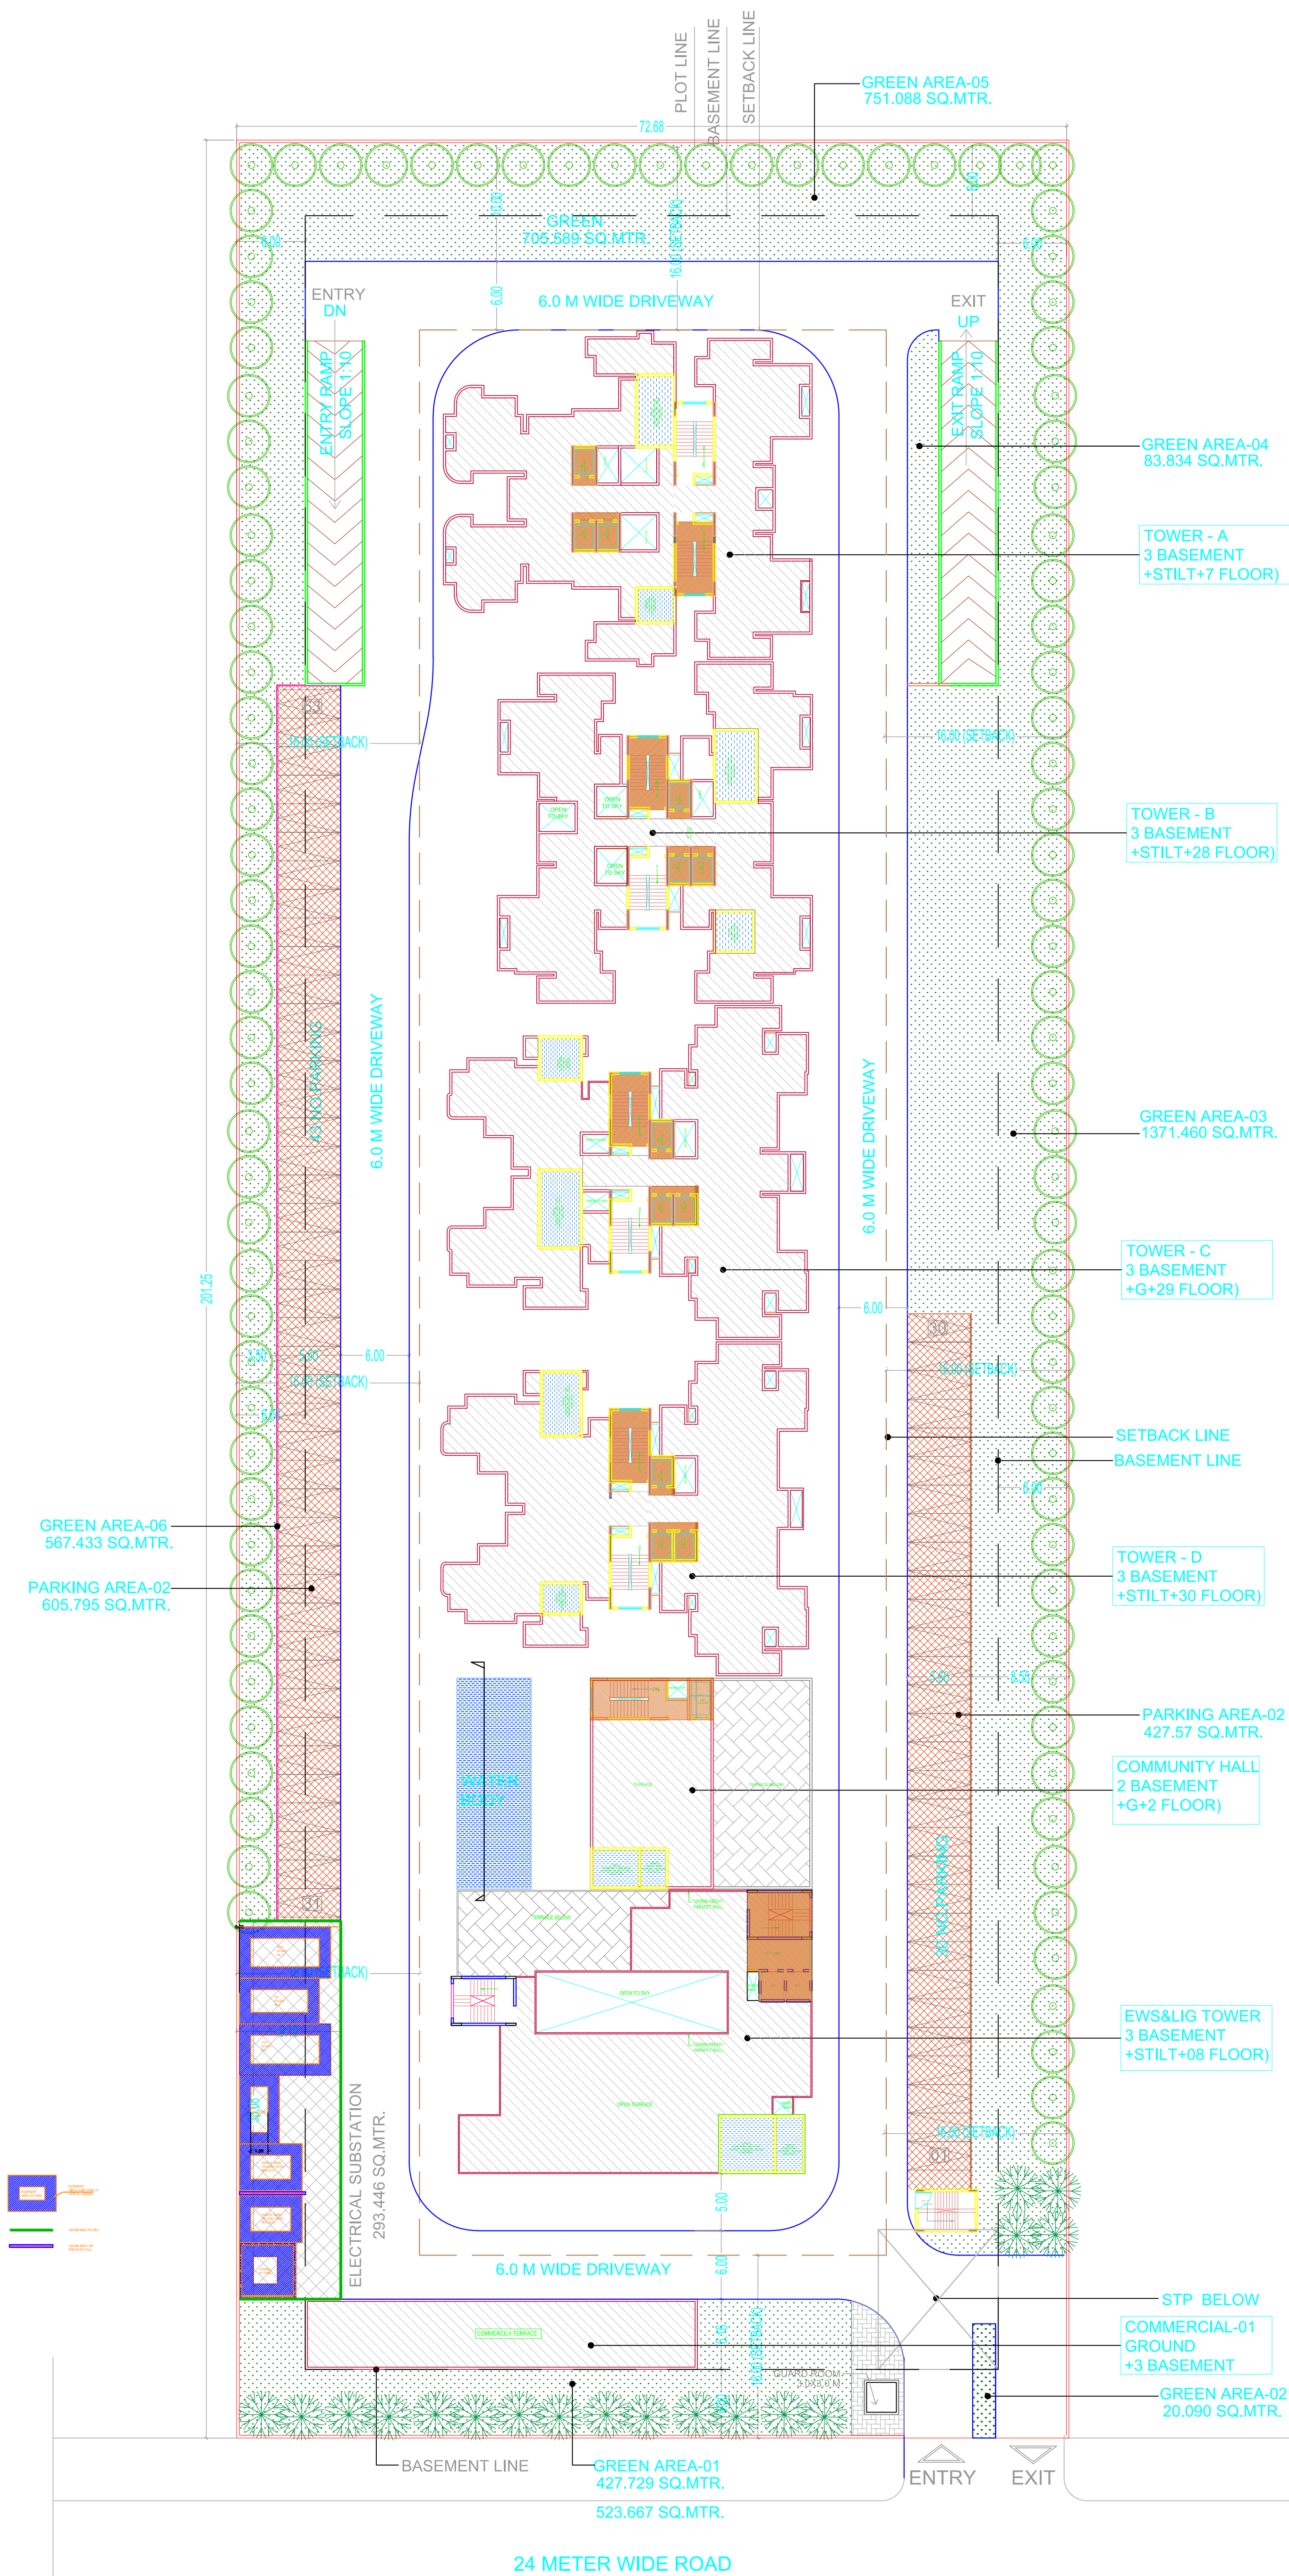

SITE PLAN

DRAWING NO. : PL-SP05-601

SERVICES CONSULTANTS :-

SAVIRAM

ENGINEERING CONSULTANTS PRIVATE LIMITED

Regd off : 22, Duplex-I, Rajat Vihar, Sector-62, Noida-201301

Telephone: (+91-120)-2494877, 4261877, 4261878 Fax: (+91-120)-2494877

E-mail: saviramnoida@gmail.com