


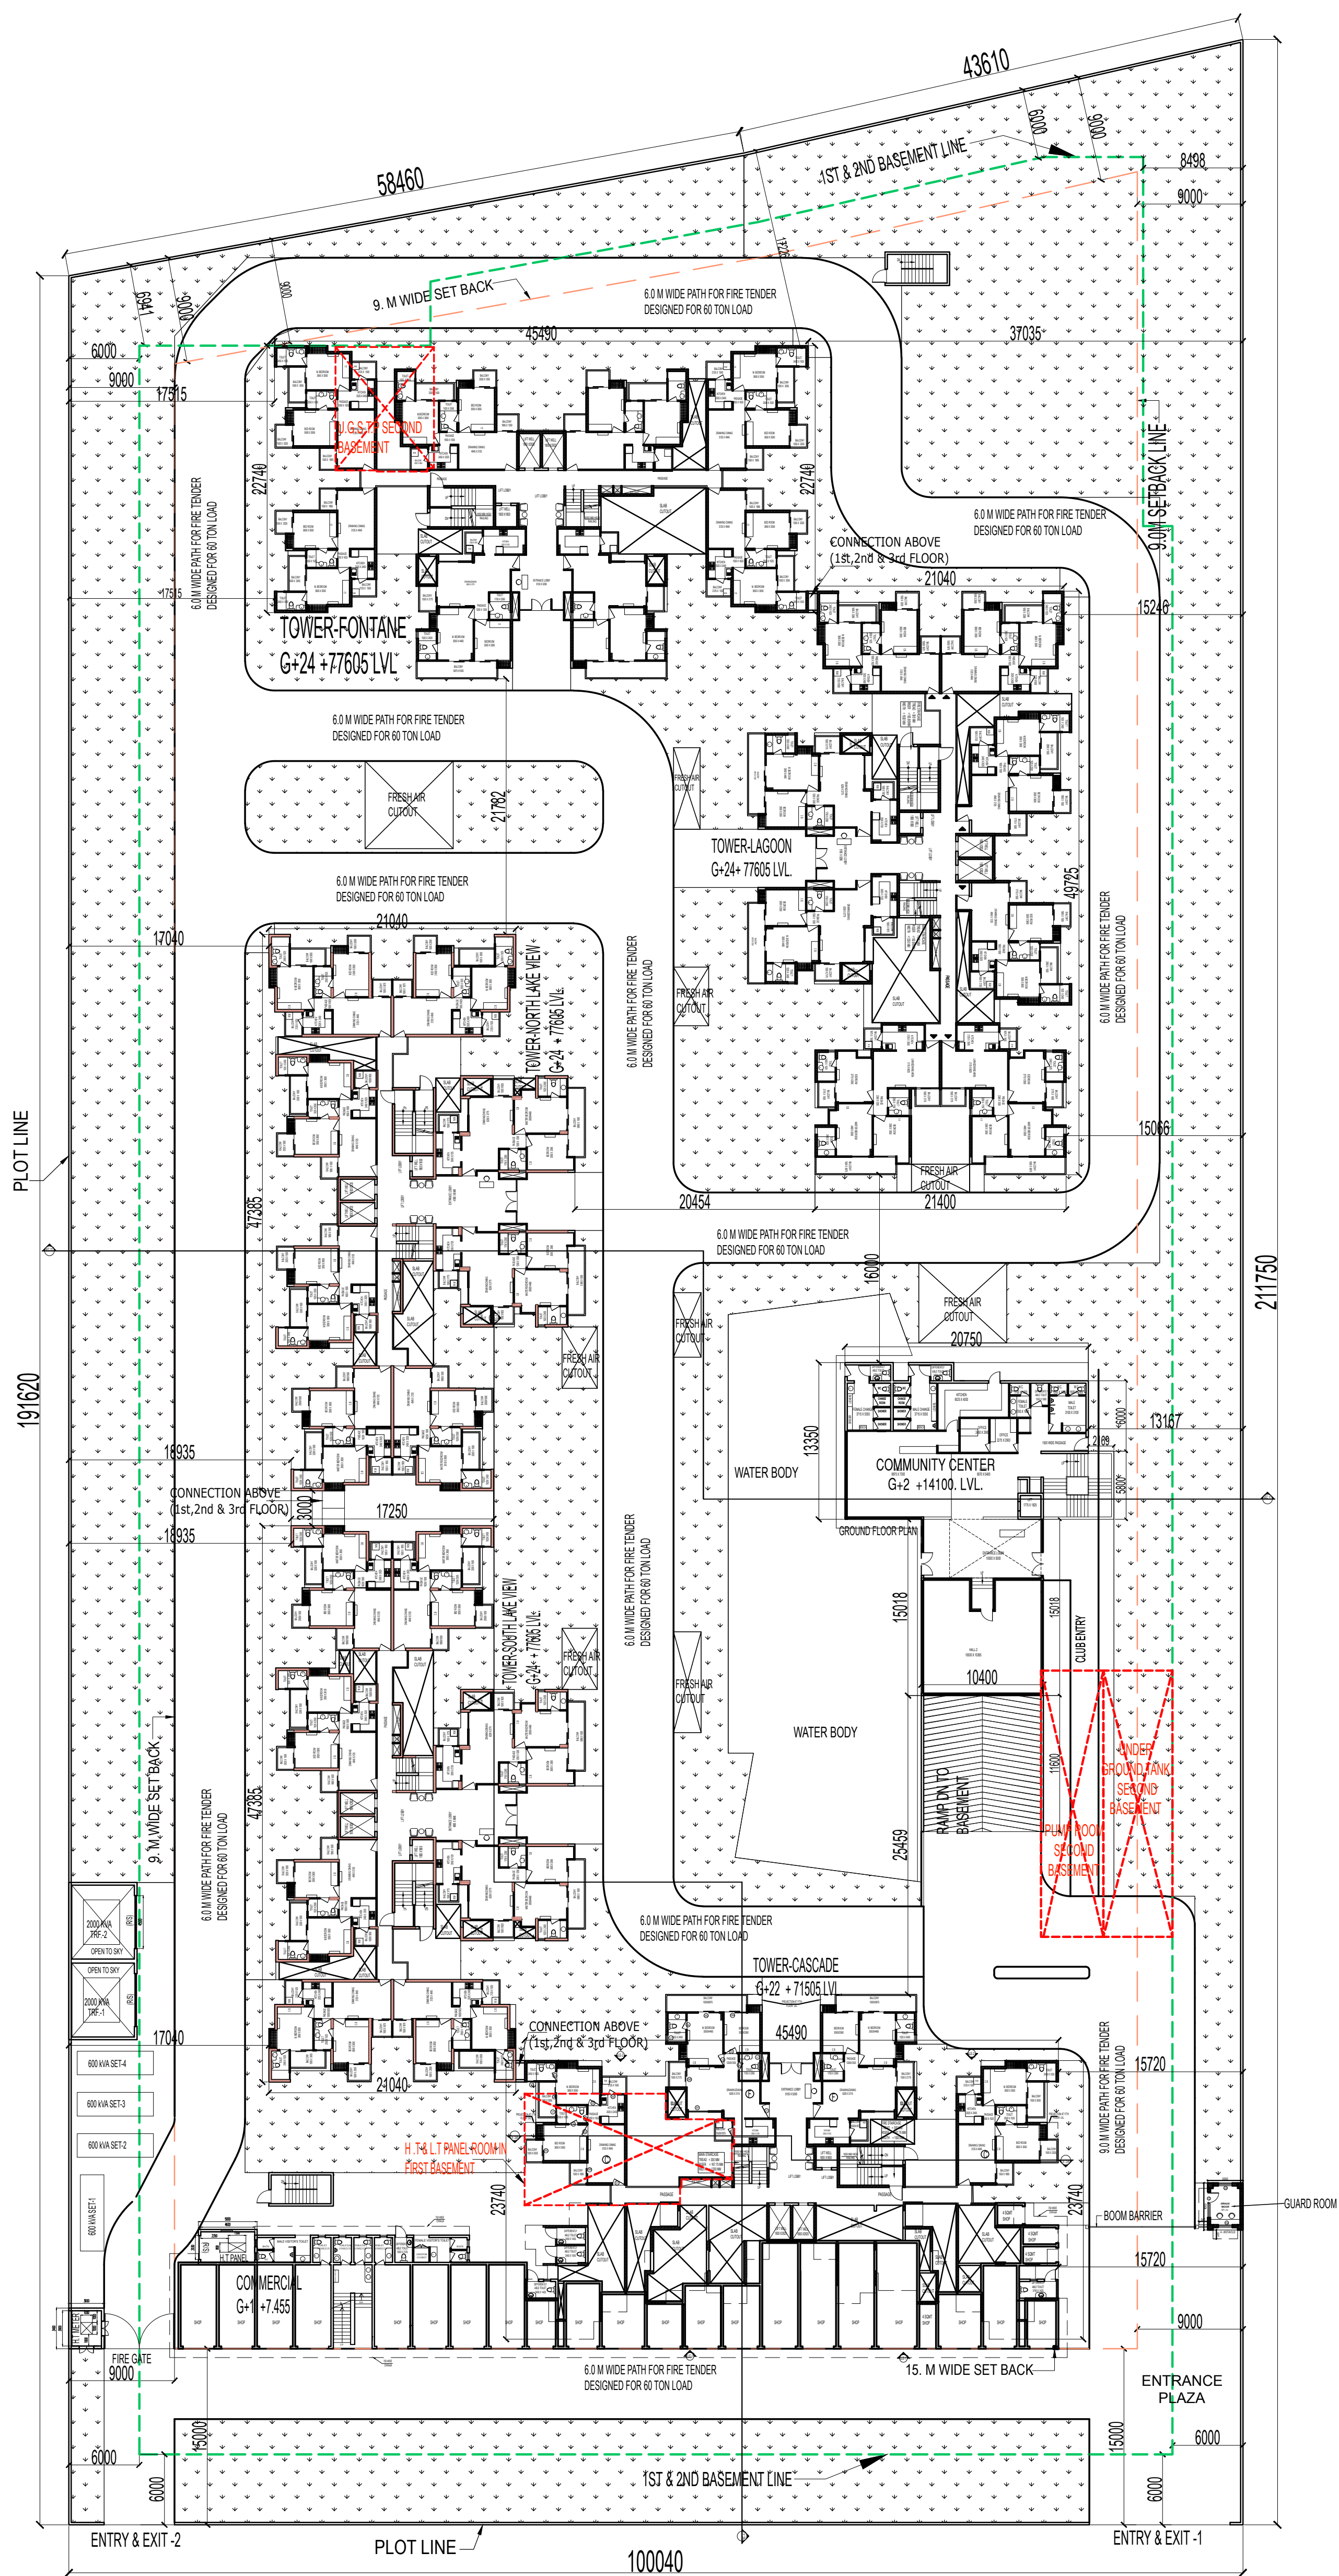

Windows OLE Object

OWNER SIGN		ARCHITECT SIGN	
OWNER M/S DECENT BUILDWELL PVT. LTD.		SUBMISSION DRAWING	
KEYPLAN		PROJECT PROPOSED GROUP HOUSING FOR DECENT BUILDWELL PVT. LTD. AT PLOT NO: - GH-05A, SECTOR- 16B, GREATER NOIDA, (U.P.)	
DATE 27-10-16	PROJECT INCH. DEVESH SHAKYA	CHECKED BY DEVESH SHAKYA	
SCALE 1:400	DEALT BY ABDHESH JHA	APPROVED BY VISHAL SHARMA	
DRAWING TITLE ELECTRICAL LAYOUT PLAN			
ARCHITECTS			
S-20, OK-2 N-24-48, INDIA architecture Ph: +91-11-26012006 Ph: +91-11-42564788 urban design con@confluence.com www.confluence.com hoopitality Member of IGC ISO - 9001:2005 interiors			
DRAWING NO. S-60		REVISION	