



PROJECT
PROPOSED GROUP HOUSING
 FOR
PUKHYA CONSTRUCTION PVT. LTD.
 DIRECTOR- Mr.VIKAS GUPTA
 AT
 KH.NO.1196, MADIYAN (GODIYN PURWA)
 TEHSIL-BAKSHI KA TALAB
 DISTRICT-LUCKNOW

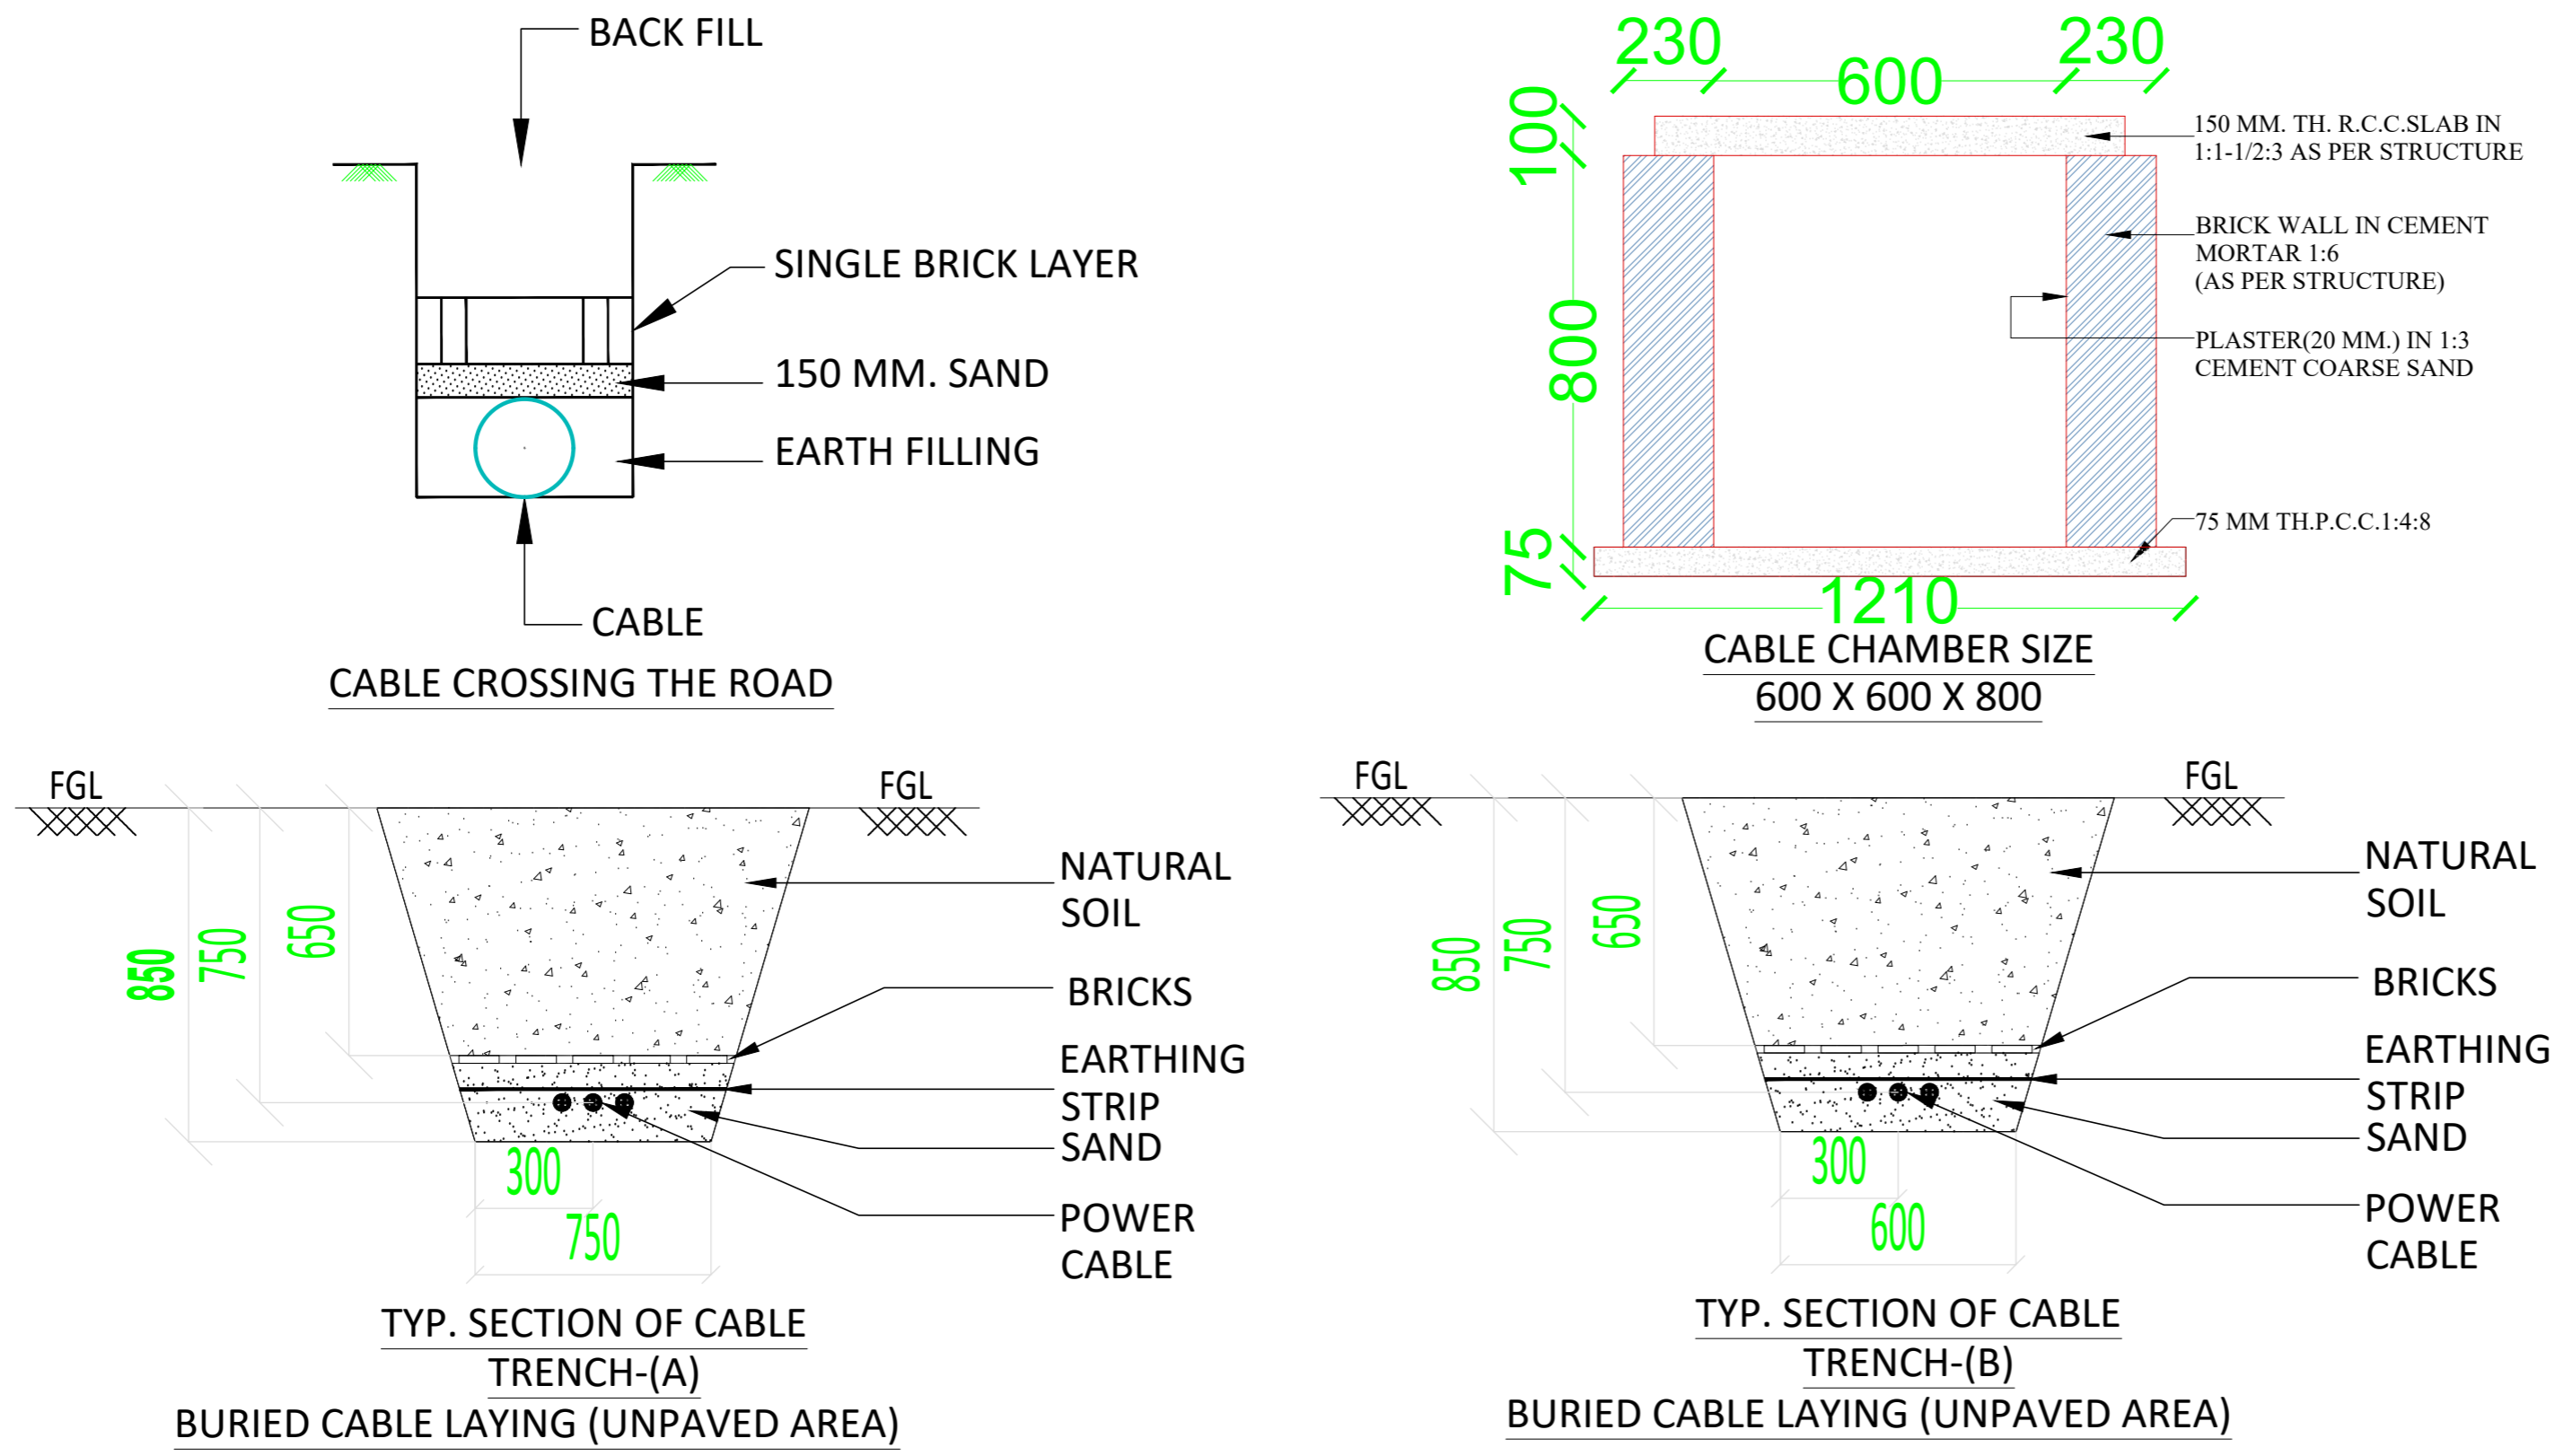


LEGEND:-

1.	4.0 M HIGH POST TOP LANTERN SUITABLE FOR 1x70W S.V. LAMP	30
2.	GATE LIGHT	04
3.	CABLE TRENCH	
4.	RCC HUME PIPE	
5.	UNDER GROUND AR. AL.CABLE	
6.	ELECTRICAL MAN HOLE (600MM x 600MM x 800MM DEEP)	02

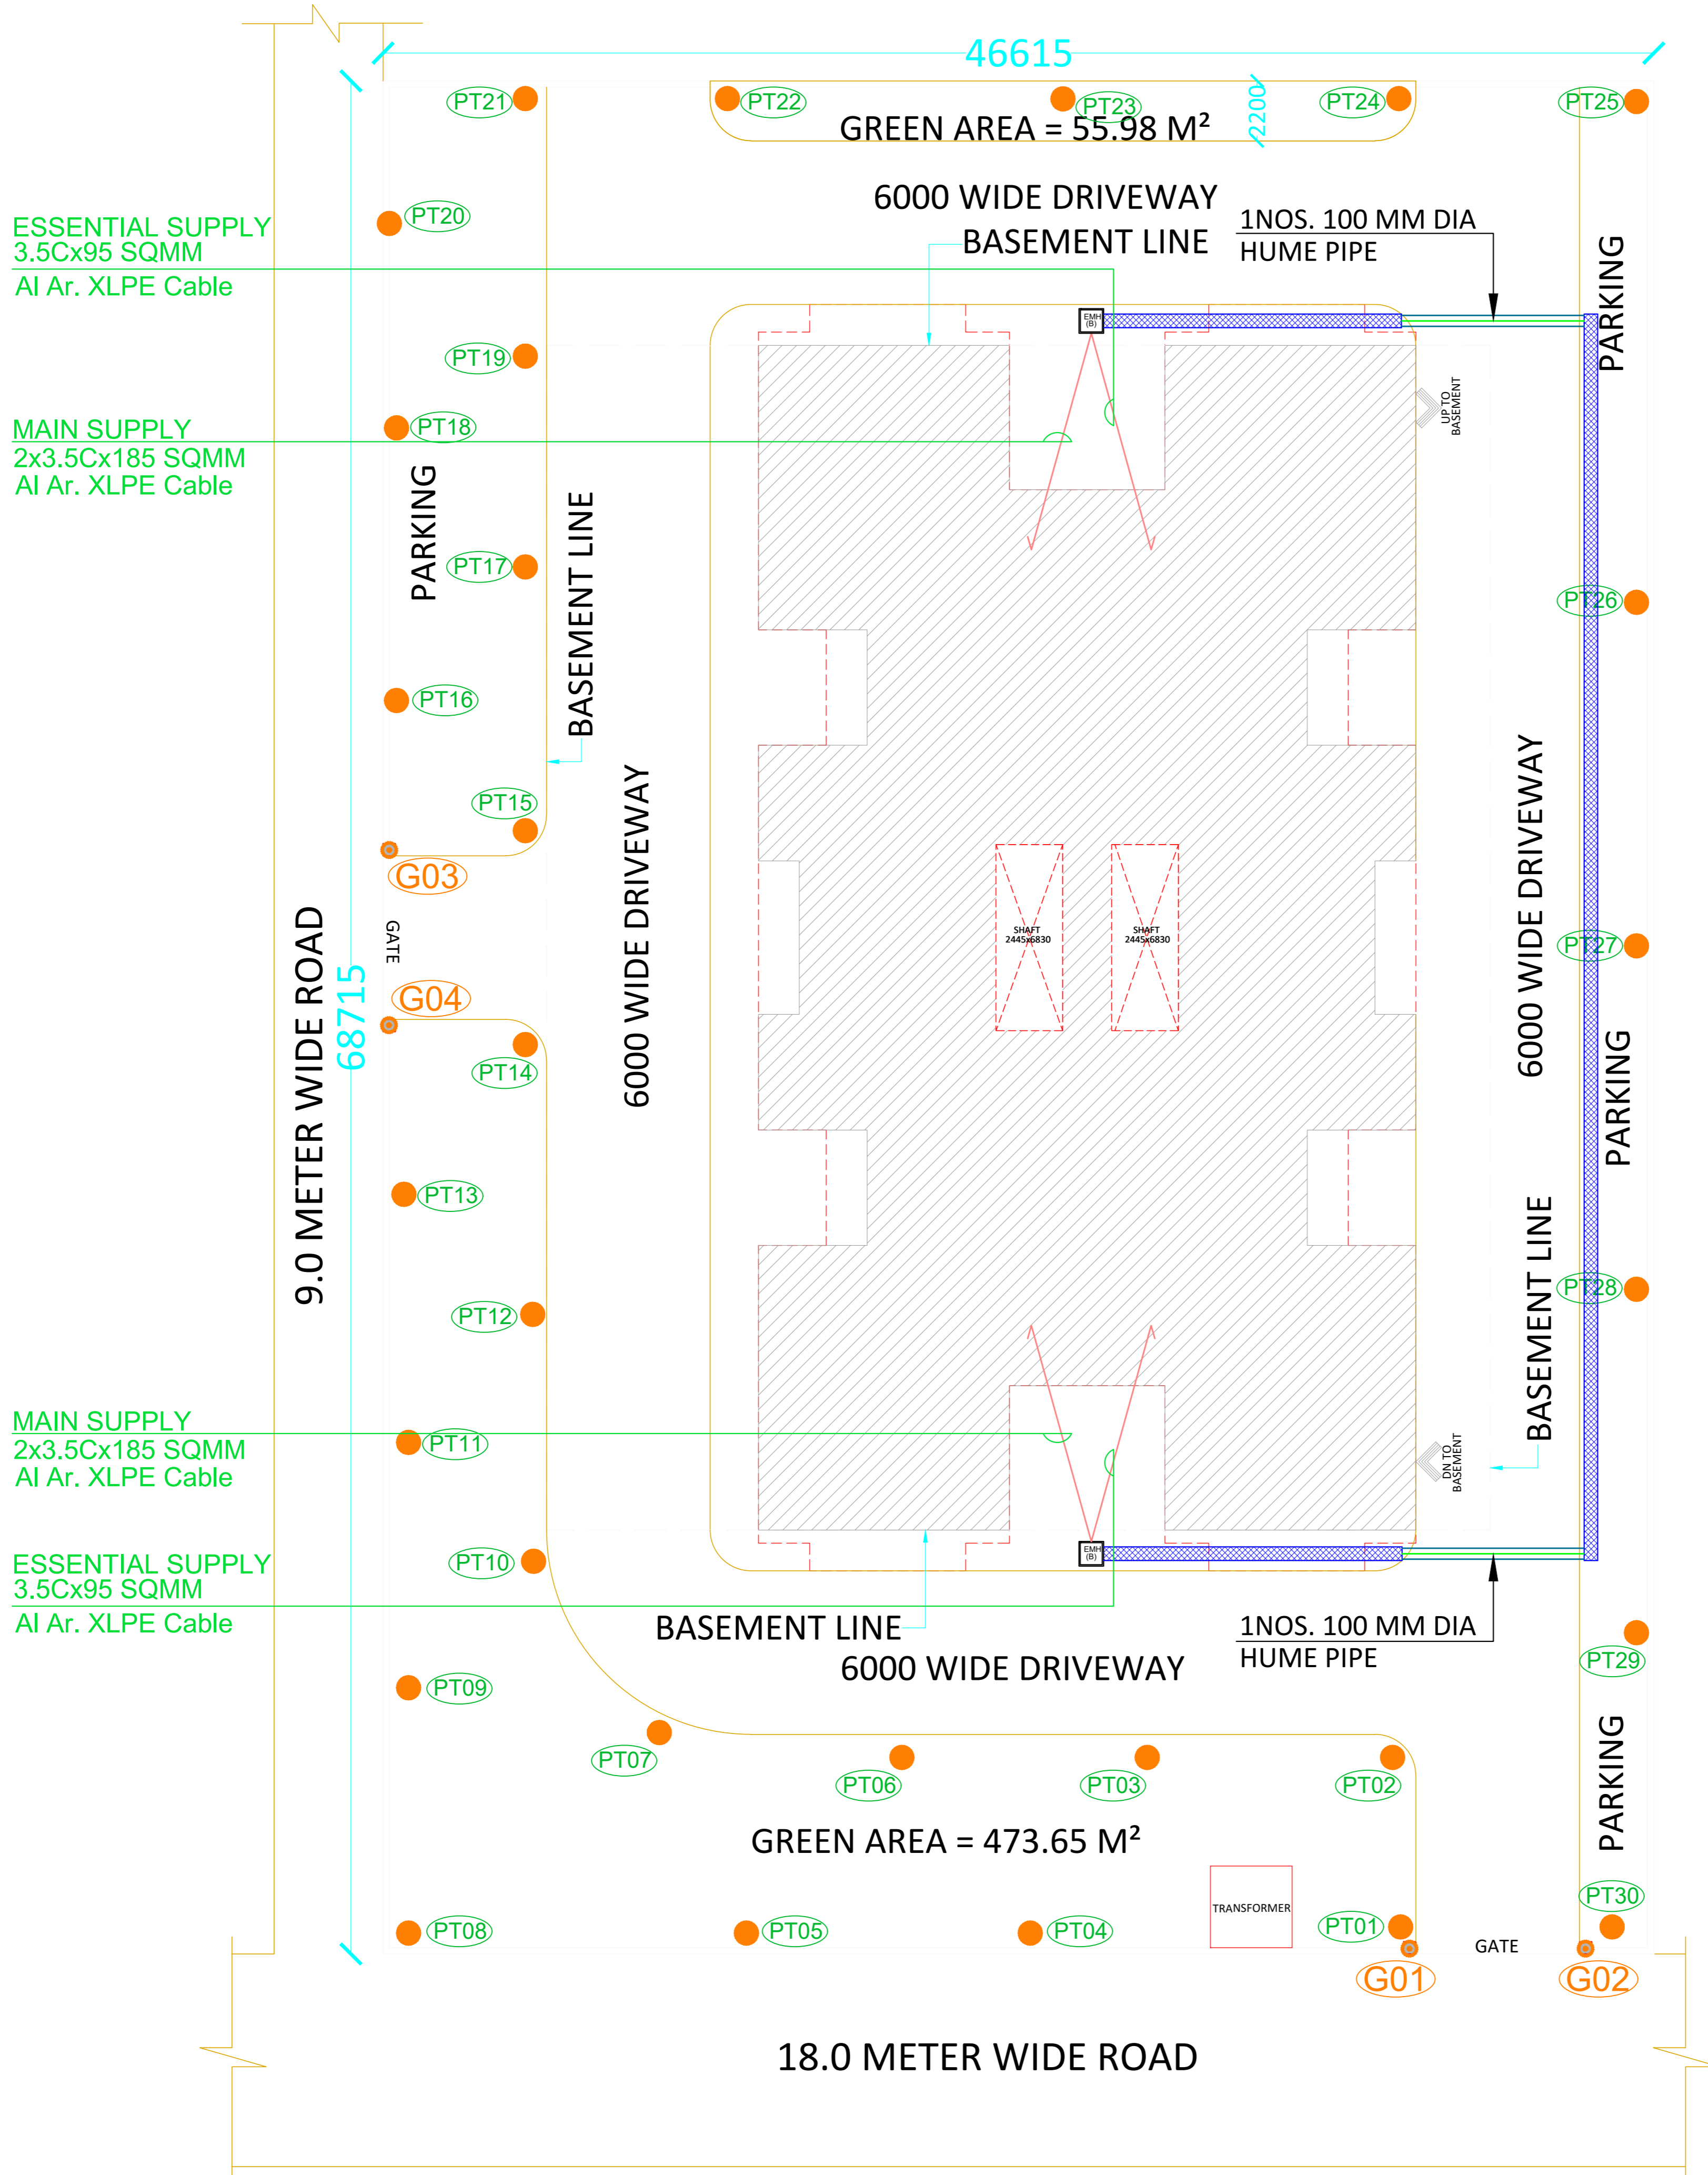

DRG. TITLE
ELECTRICAL LAYOUT PLAN

DRAWN BY	DRG. NO.-
SCALE	DATE

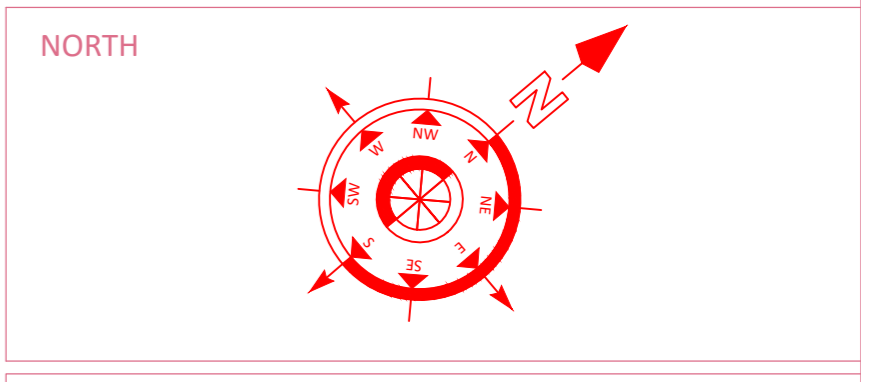

PUNIT SRIVASTAV
VASTULIPI
 ARCHITECTS & INTERIOR DESIGNERS
 VASTU SHASTRA CONSULTANTS
 5/171, VIRAM KHAND, GOMTI NAGAR, LUCKNOW
 PH. NO.- 9415418151, 9935590999
 email - vastulipi@gmail.com
 website - www.vastulipi.com