


THIRD FLOOR	AREA 1000 SQ. FT.	1000 SQ. FT.
SECOND FLOOR	AREA 1000 SQ. FT.	1000 SQ. FT.
FIRST FLOOR	AREA 1000 SQ. FT.	1000 SQ. FT.
GROUND FLOOR	AREA 1000 SQ. FT.	1000 SQ. FT.
TOTAL COVERED AREA	4000 SQ. FT.	4000 SQ. FT.

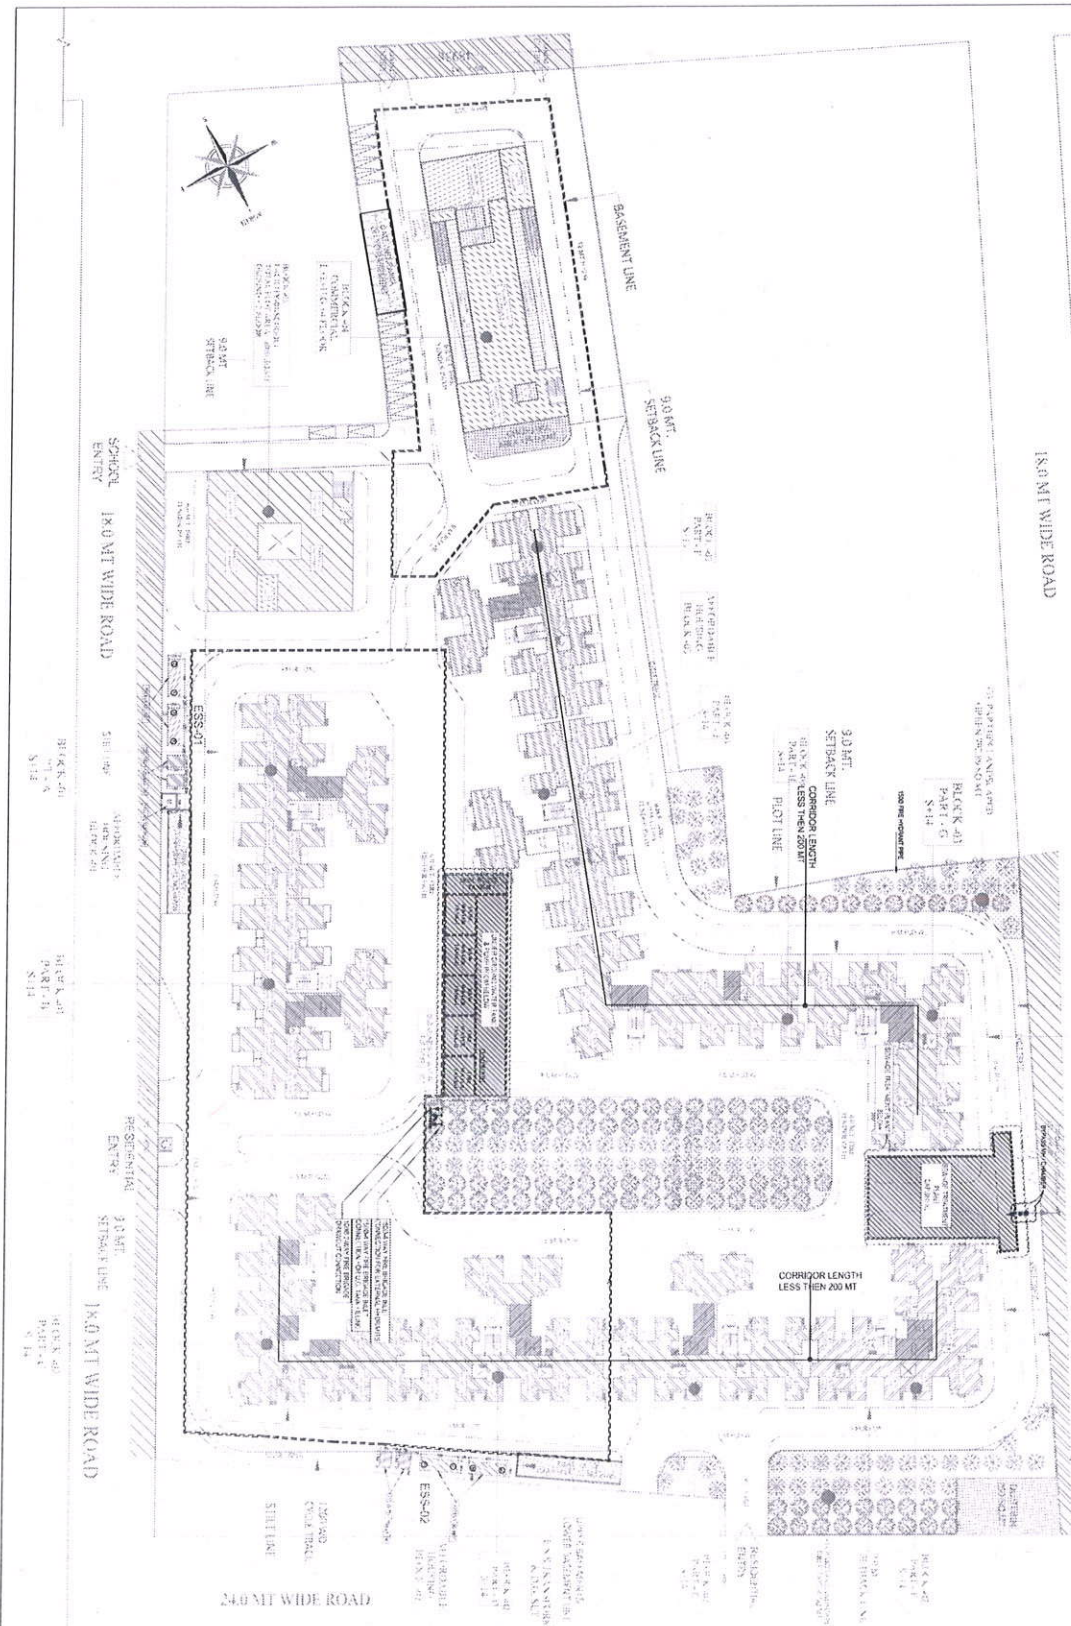

For NILAYA INFRA PVT. LTD.
For NILAYA INFRA PVT. LTD.
Director
Authorised Signatory

REV. NO.	DATE	REVISION
1	10/10/2023	PROPOSED APPROBABLE HOUSING AT KHASRA NO. 1015/1022 VILLAGE - MORIA GHANABAD
SITE PLAN		
ELECTRICAL LAYOUT PLAN		
drawing released by		
☐ APPROVAL	☐ SUBMISSION	
☐ ADVANCE COPY	☐ CONSTRUCTION	
DATE	NO. (10/10/2023)	DESIGNED BY
10/10/2023		10/10/2023
CHECKED BY		
10/10/2023		
DRAWN BY		
10/10/2023		
PROJECT NO.		
10/10/2023		
PROJECT NAME		
10/10/2023		
PROJECT LOCATION		
10/10/2023		
PROJECT STATUS		
10/10/2023		
PROJECT OWNER		
10/10/2023		
PROJECT CONTACT		
10/10/2023		
PROJECT ADDRESS		
10/10/2023		
PROJECT PHONE		
10/10/2023		
PROJECT EMAIL		
10/10/2023		
PROJECT WEBSITE		
10/10/2023		
PROJECT SOCIAL MEDIA		
10/10/2023		
PROJECT OTHER		
10/10/2023		