


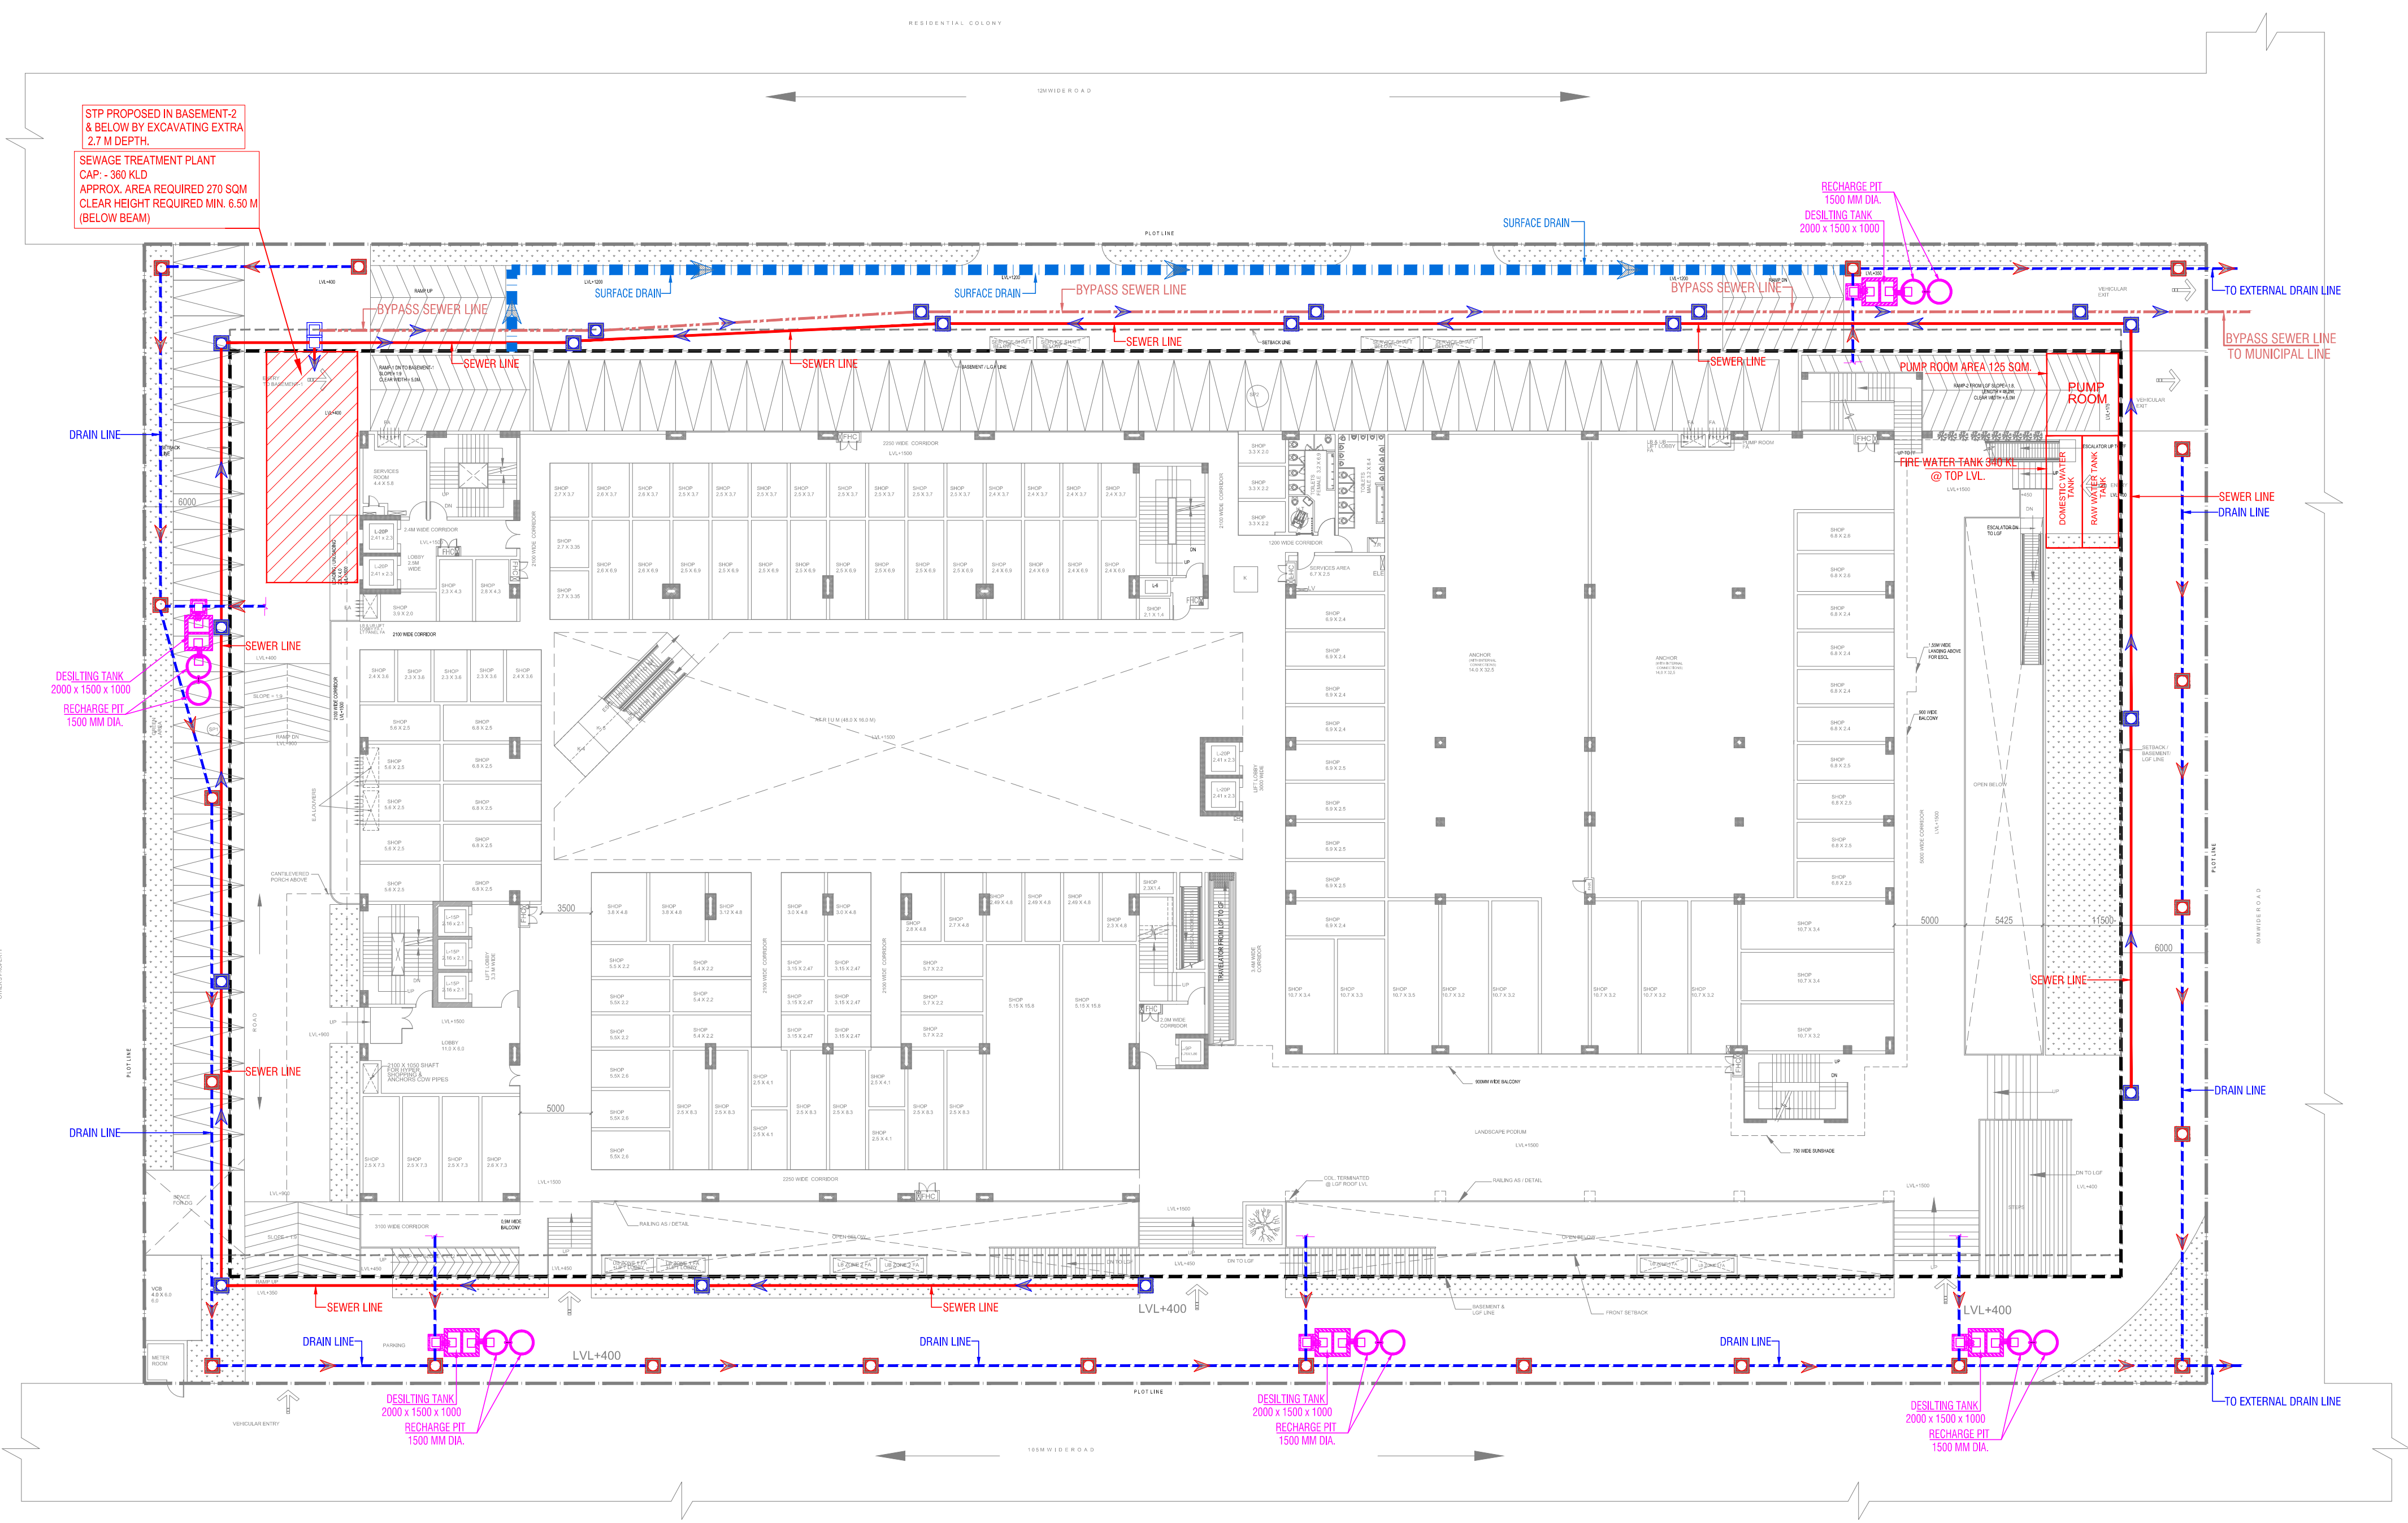

LEGEND :		
S. No.	SYMBOL	DESCRIPTION
1.	M.H.	MANHOLE
2.	SEWER LINE	SEWER LINE
3.	BYPASS MANHOLE	BYPASS MANHOLE
4.	BYPASS SEWER LINE	BYPASS SEWER LINE
5.	C.P.	CATCH PIT
6.	UNDER GROUND DRAIN	UNDER GROUND DRAIN
7.	SURFACE DRAIN	SURFACE DRAIN
8.	RAIN WATER HARVESTING	RAIN WATER HARVESTING
9.	BASEMENT LINE	BASEMENT LINE

Rev. no.	Date	Revision

OWNERS:
M/S ADHM DEVELOPERS PVT LTD, AT
B-1/504, SATYAM APARTMENTS, THE NEW PROGRESSIVE,
CGHS LTD, 20-B, VASUNDHARA ENCLAVE, DELHI-110096

Project
PROPOSED THE COMMERCIAL /MULTIPLEX/OFFICES AT C-3,
COMMERCIAL BELT, ALPHA II, GREATER NOIDA,
GAUTAMBUDH NAGAR U.P.

Title
SITE PLAN

Subtitle
EXTERNAL SEWERAGE & DRAINAGE SYSTEM

Drawing released for
☐ APPROVAL ☒ SUBMISSION
☐ ADVANCE COPY ☐ CONSTRUCTION

Drg. no. G. N. / EX / S-01 Drawn by Kulwant

Scale 1:300 @ A1 Designed by R.K.

Date .. Checked by Anand Havella

Architects
BRUJ (INDIA) ARCHITECTS
F-89, GREEN PARK, NEW DELHI -16.
Ph. +91-11-26853815, 26858307, Fax: +91-11-26850788
E-mail: barch@rediffmail.com, info@atwin.in
Website: www.atwin.in

Services Consultant
Consummate Engineering Services (P) Ltd.
Noida Office : B - 67, Sector - 67, Noida - 201 301
Tel : (0120) 6943500 (23 Lines)
Lko. Office : R 006, Rohtas Plumeria, Gomti Nagar, Lucknow
e mail : mail@cespl.in, website : www.cespl.in

