
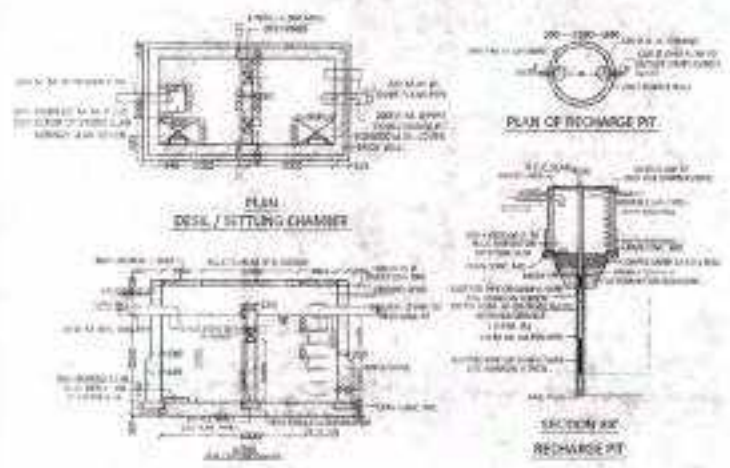


PROJECT
**PROPOSED COMMERCIAL CUM
 STUDIO APARTMENT**
 AT
**PLOT NO. TC/G-6, VIBHUTI KHAND,
 GOMTI NAGAR,
 LUCKNOW**

संकेत नं. 13/15
 विवरण एवं मालिक का नाम देना।

आवक एवं निष्कासक के नाम देना।
 निम्न अंशों में आवक एवं निष्कासक के नाम देना।
 आवक एवं निष्कासक के नाम देना।
 आवक एवं निष्कासक के नाम देना।

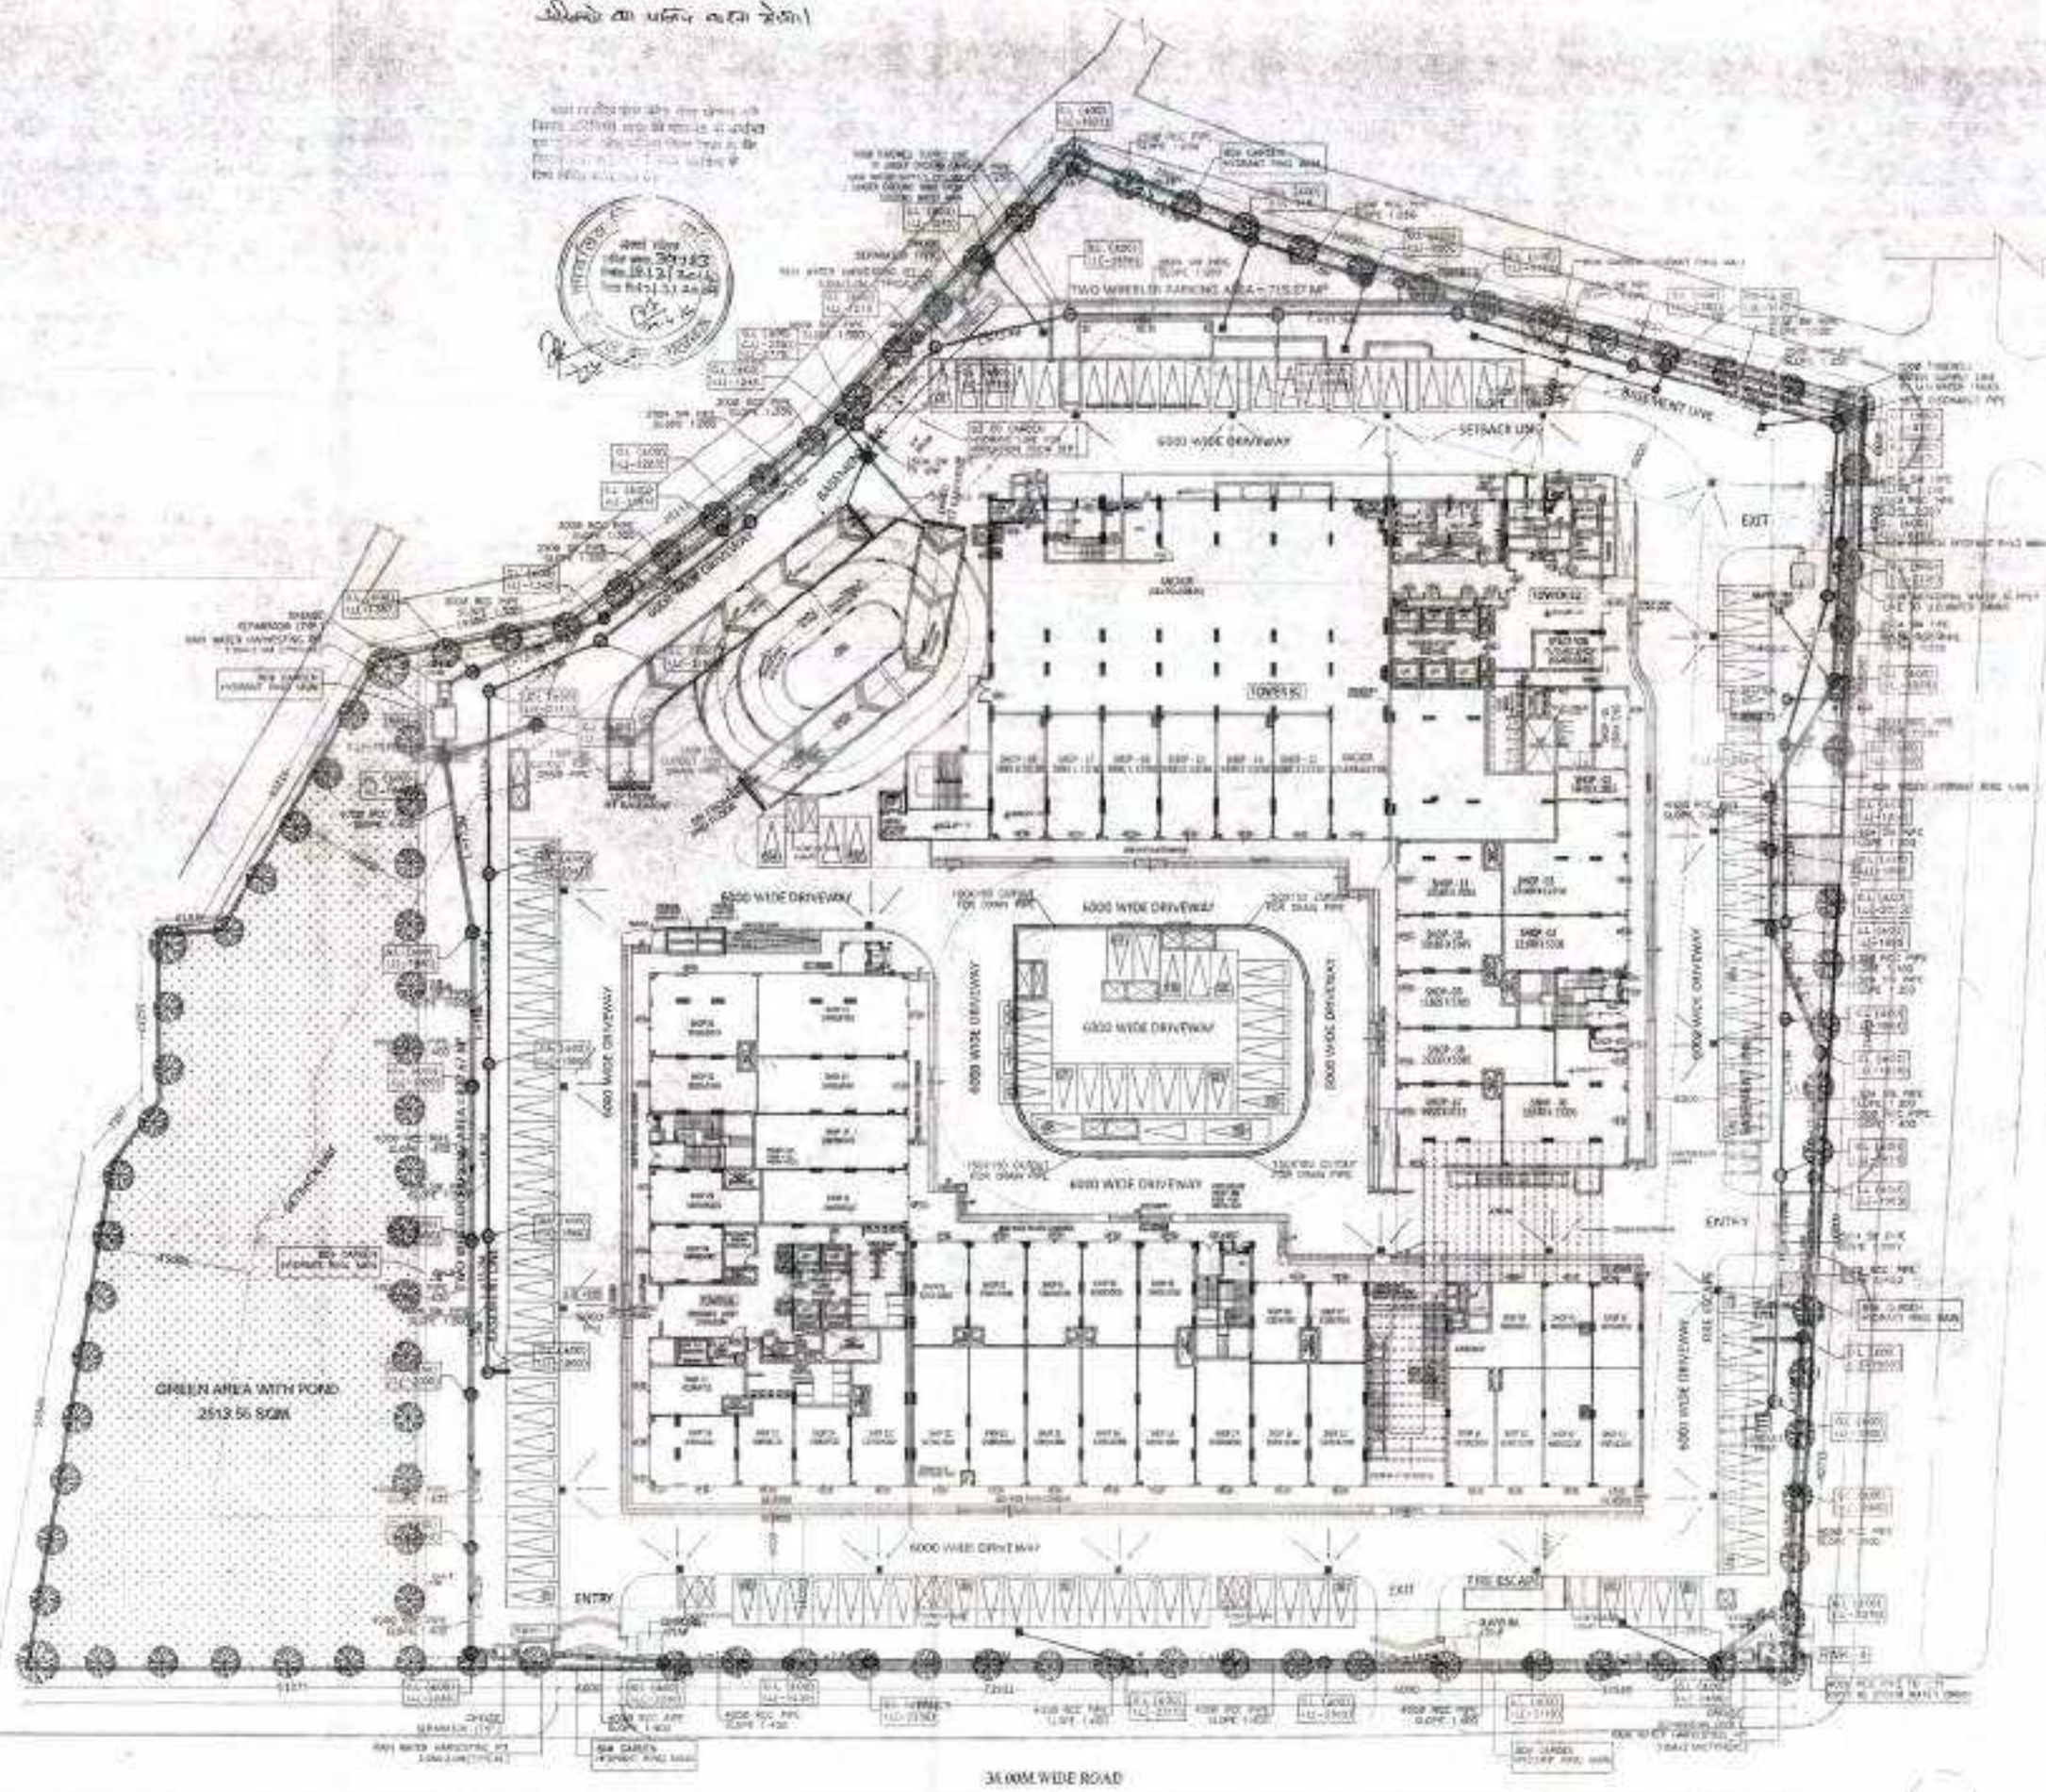

LEGEND:

	DRAINAGE MAIN HOLE
	SEWER MAIN HOLE
	TUBE WELL
	SEWAGE LINE
	TUBEWELL LINE
	MUNICIPAL LINE
	GARDEN HYDRANT LINE
	SUMP DISCHARGE PIPE
	STORM WATER LINE
	STP DISCHARGE LINE

ALL THE INFORMATION FOR PREPARING THIS SERVICE FLOOR PLAN IS PROVIDED BY THE OWNER.
 ARCHITECTS SHALL NOT BE RESPONSIBLE FOR ANY LOSS OR DAMAGE TO THE PROPERTY OF THE OWNER.


REVISED SUBMISSION DRAWING

SCALE	DATE
1 : 300	JAN - 2016
DRG. TITLE	DRG. NO.
SERVICE FLOOR PLAN	13/15
DRAWN BY	NORTH
Asst. Engineer	
OWNER SIGNATURE	ARCHITECT SIGNATURE

SERVICE FLOOR PLAN



VASTULI
 ARCHITECTS & INTERIOR DESIGNERS
 VASTU SHASTRA CONSULTANTS
 20/13, VIBHUTI KHAND, GOMTI NAGAR
 LUCKNOW
 PH. NO. - 9415481515, 9955509999
 EMAIL - vastuli@rediffmail.com
 website - www.vastuli.com

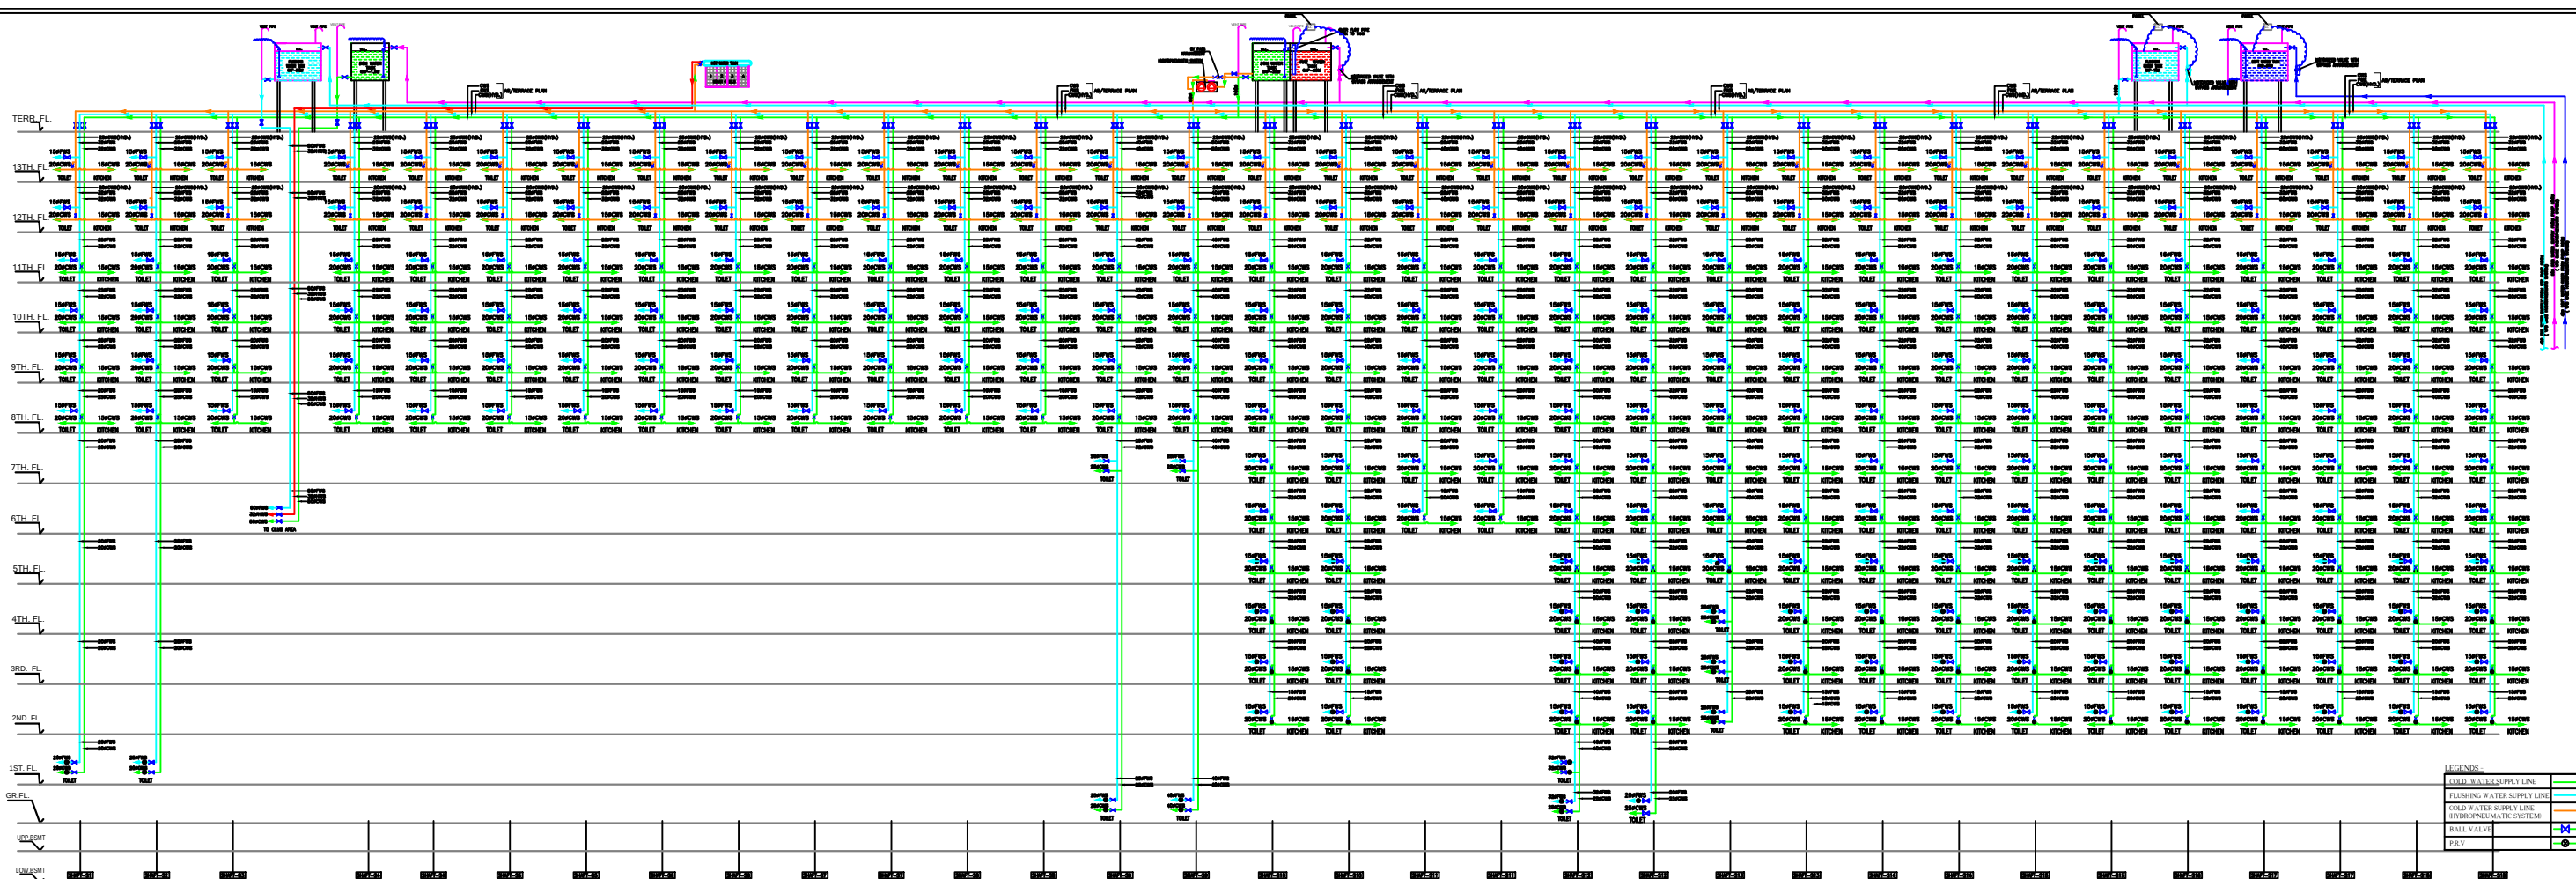[illegible]

