
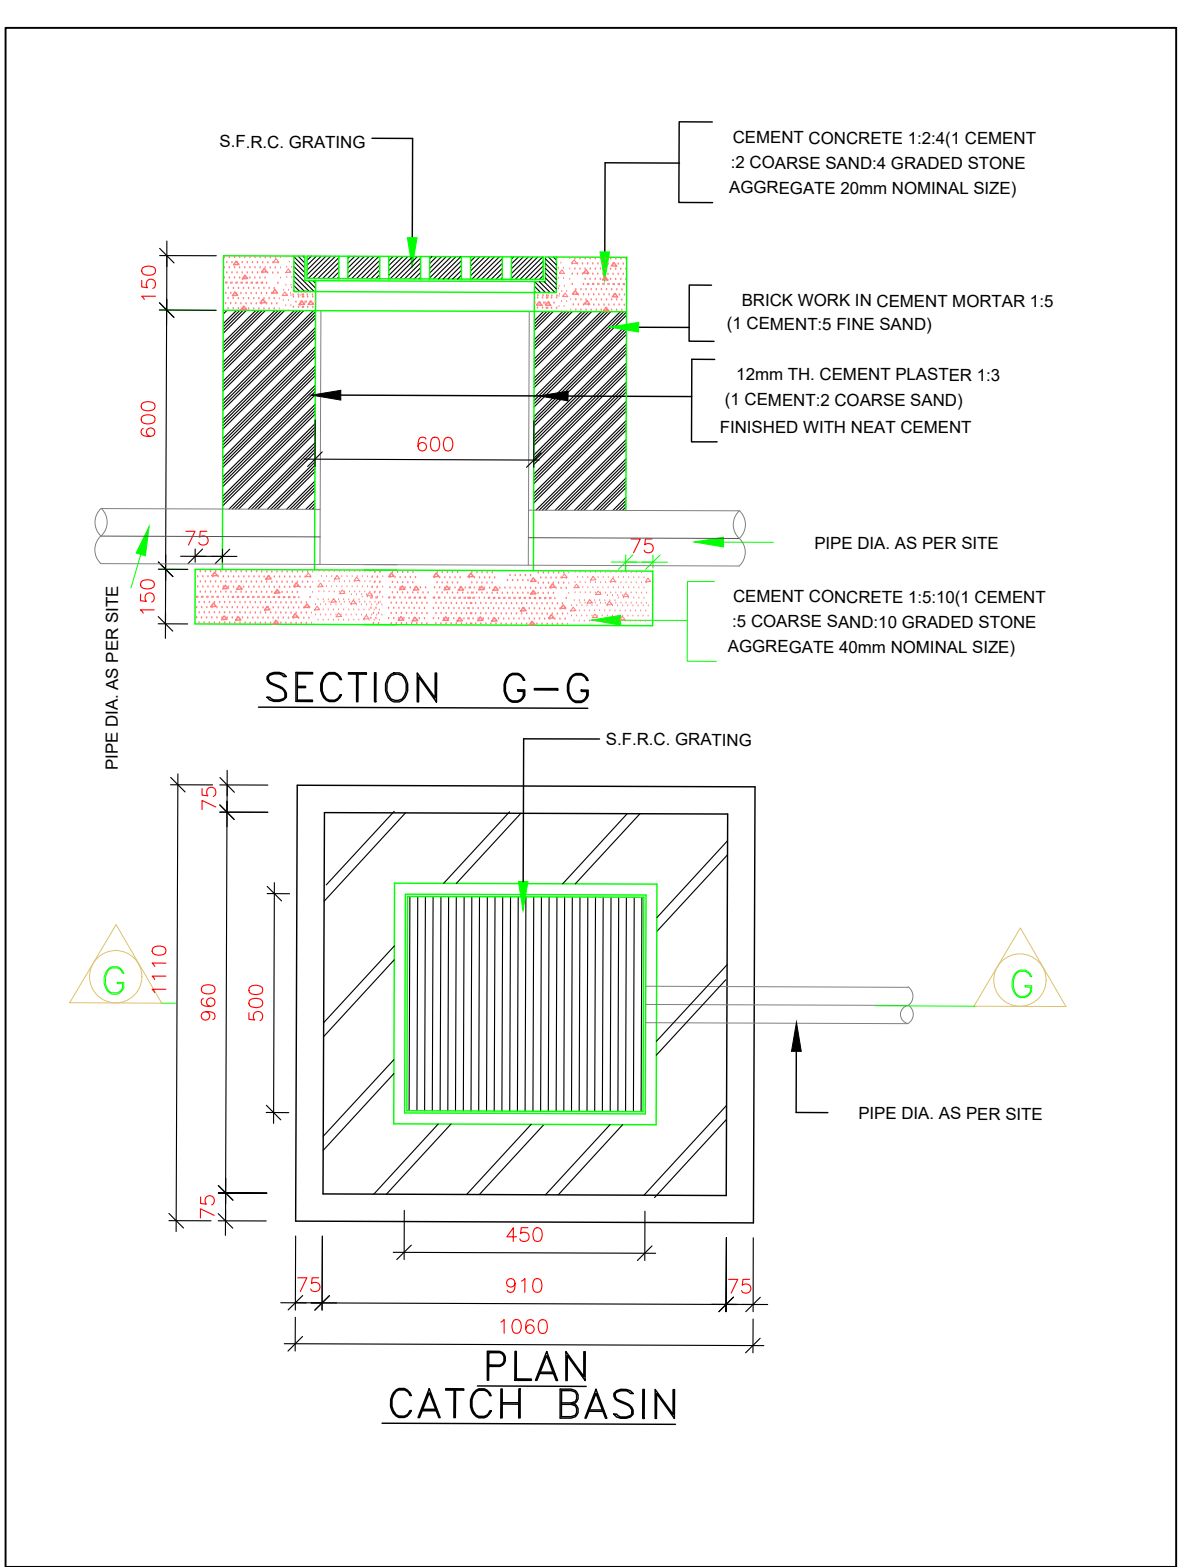
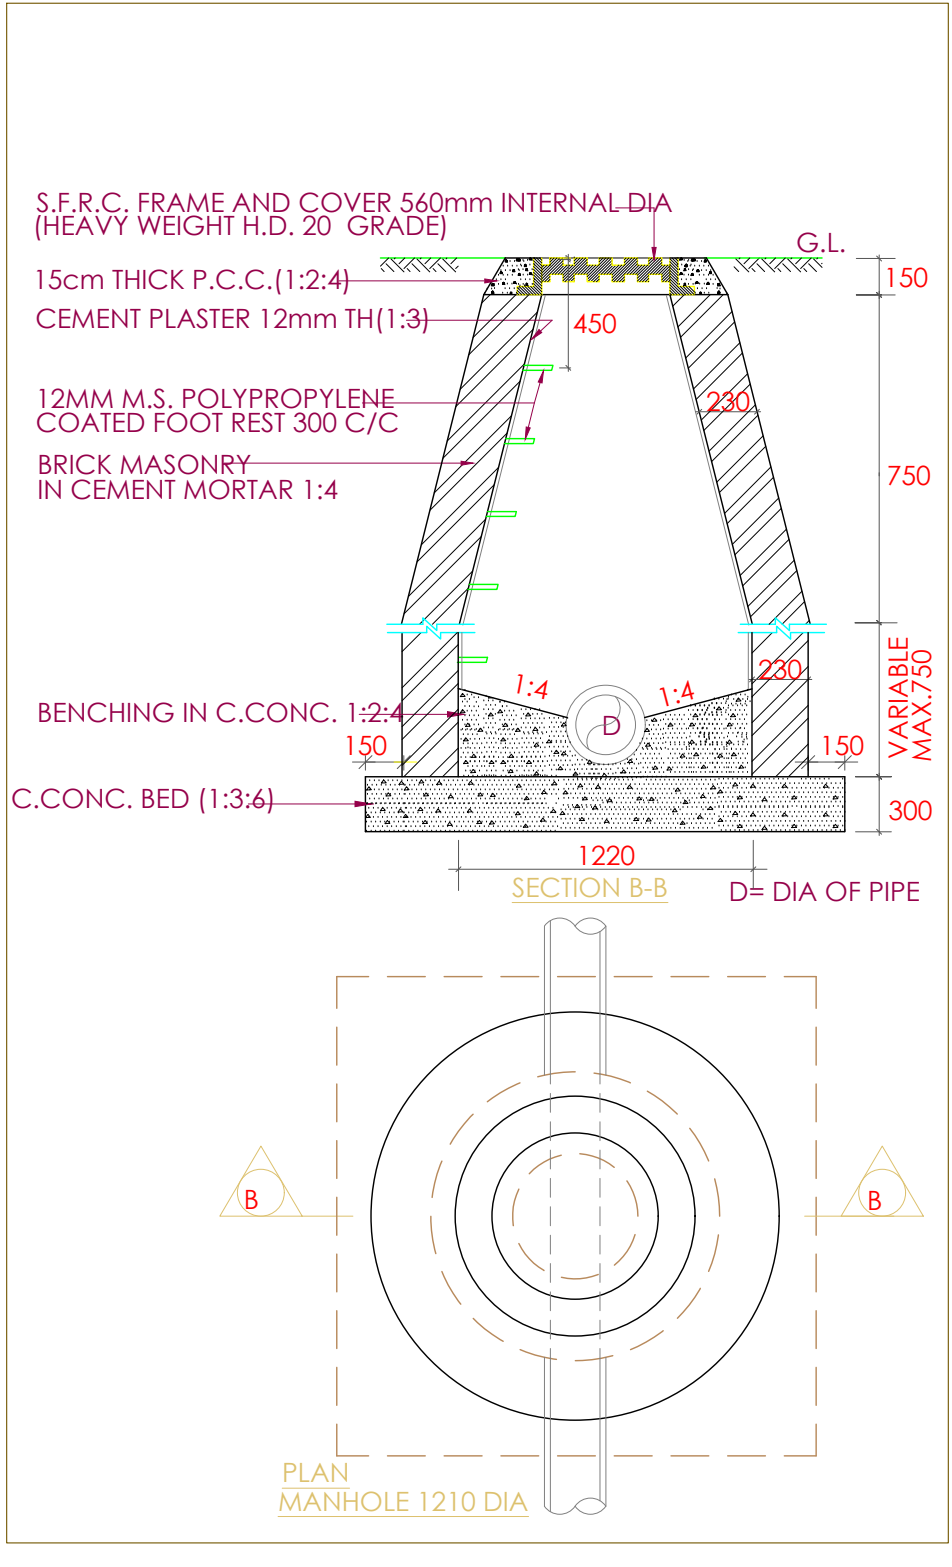
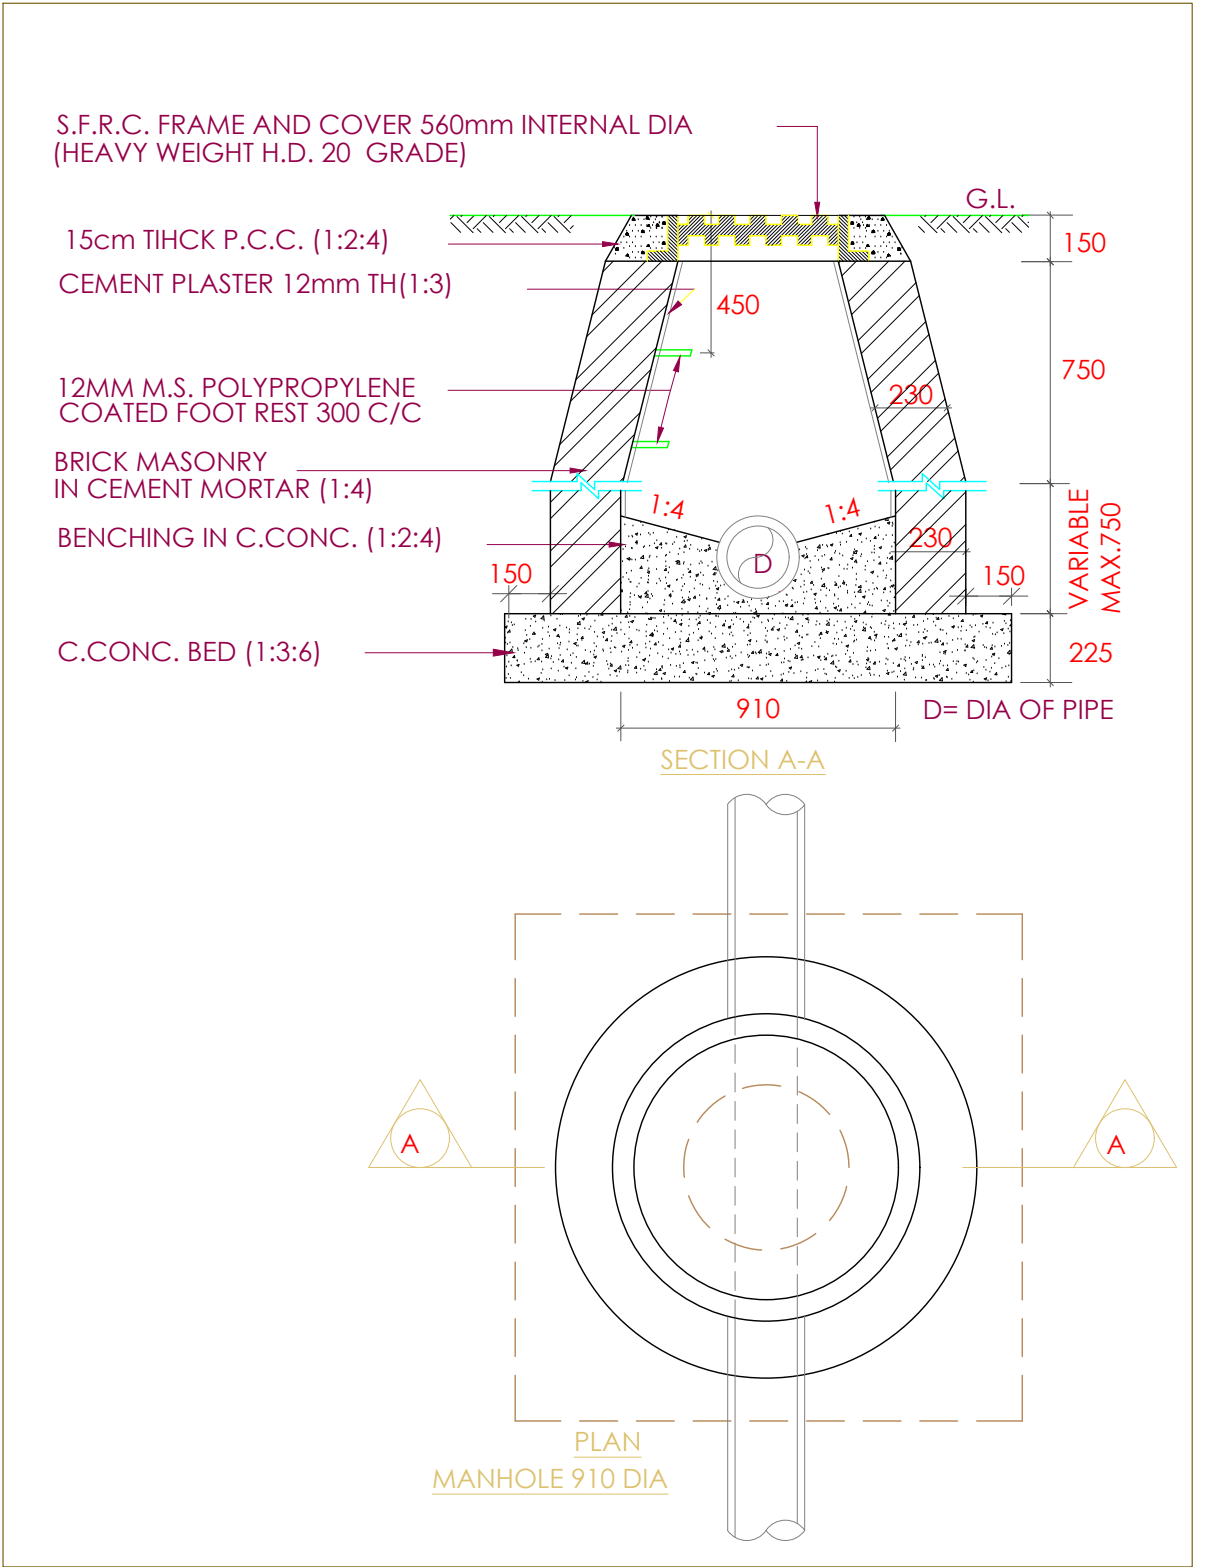
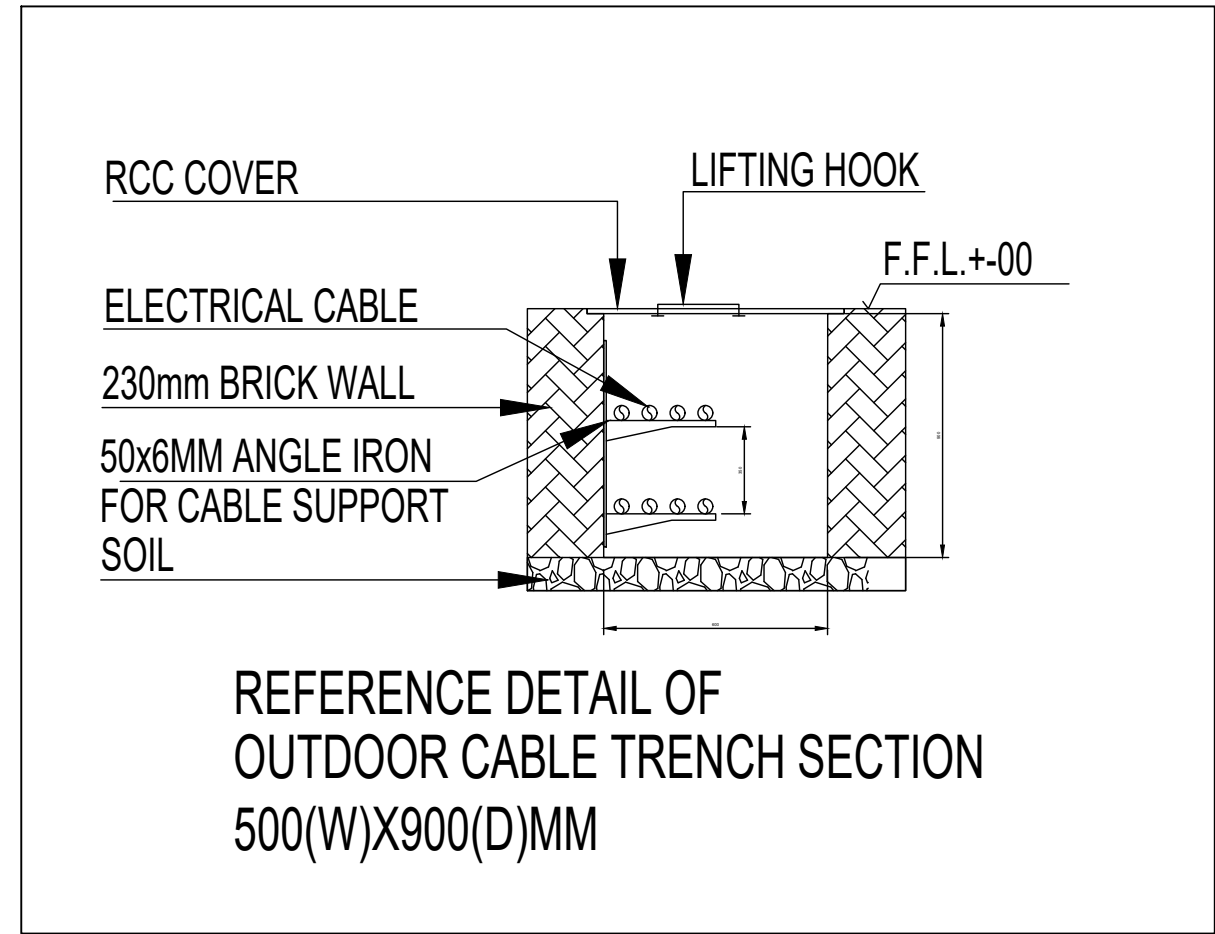
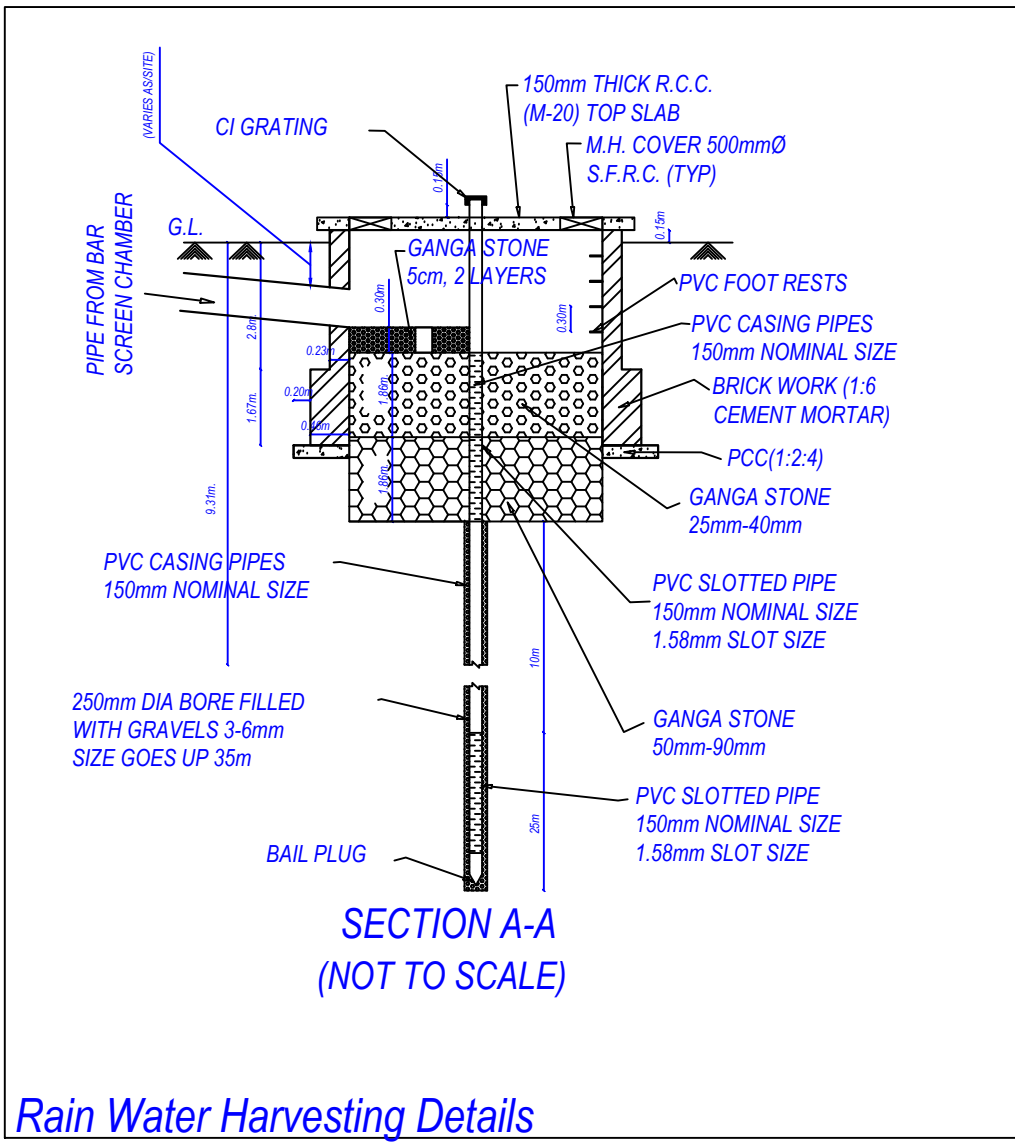
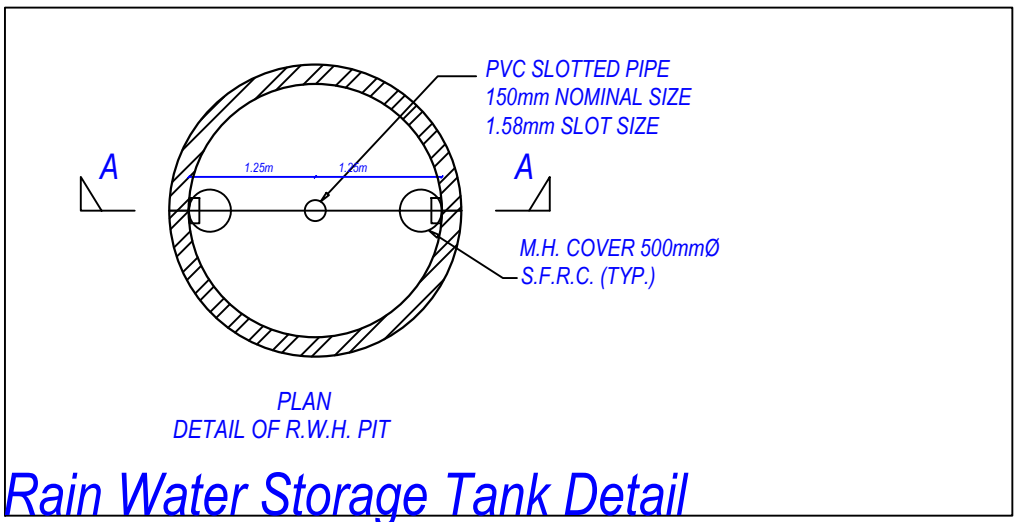


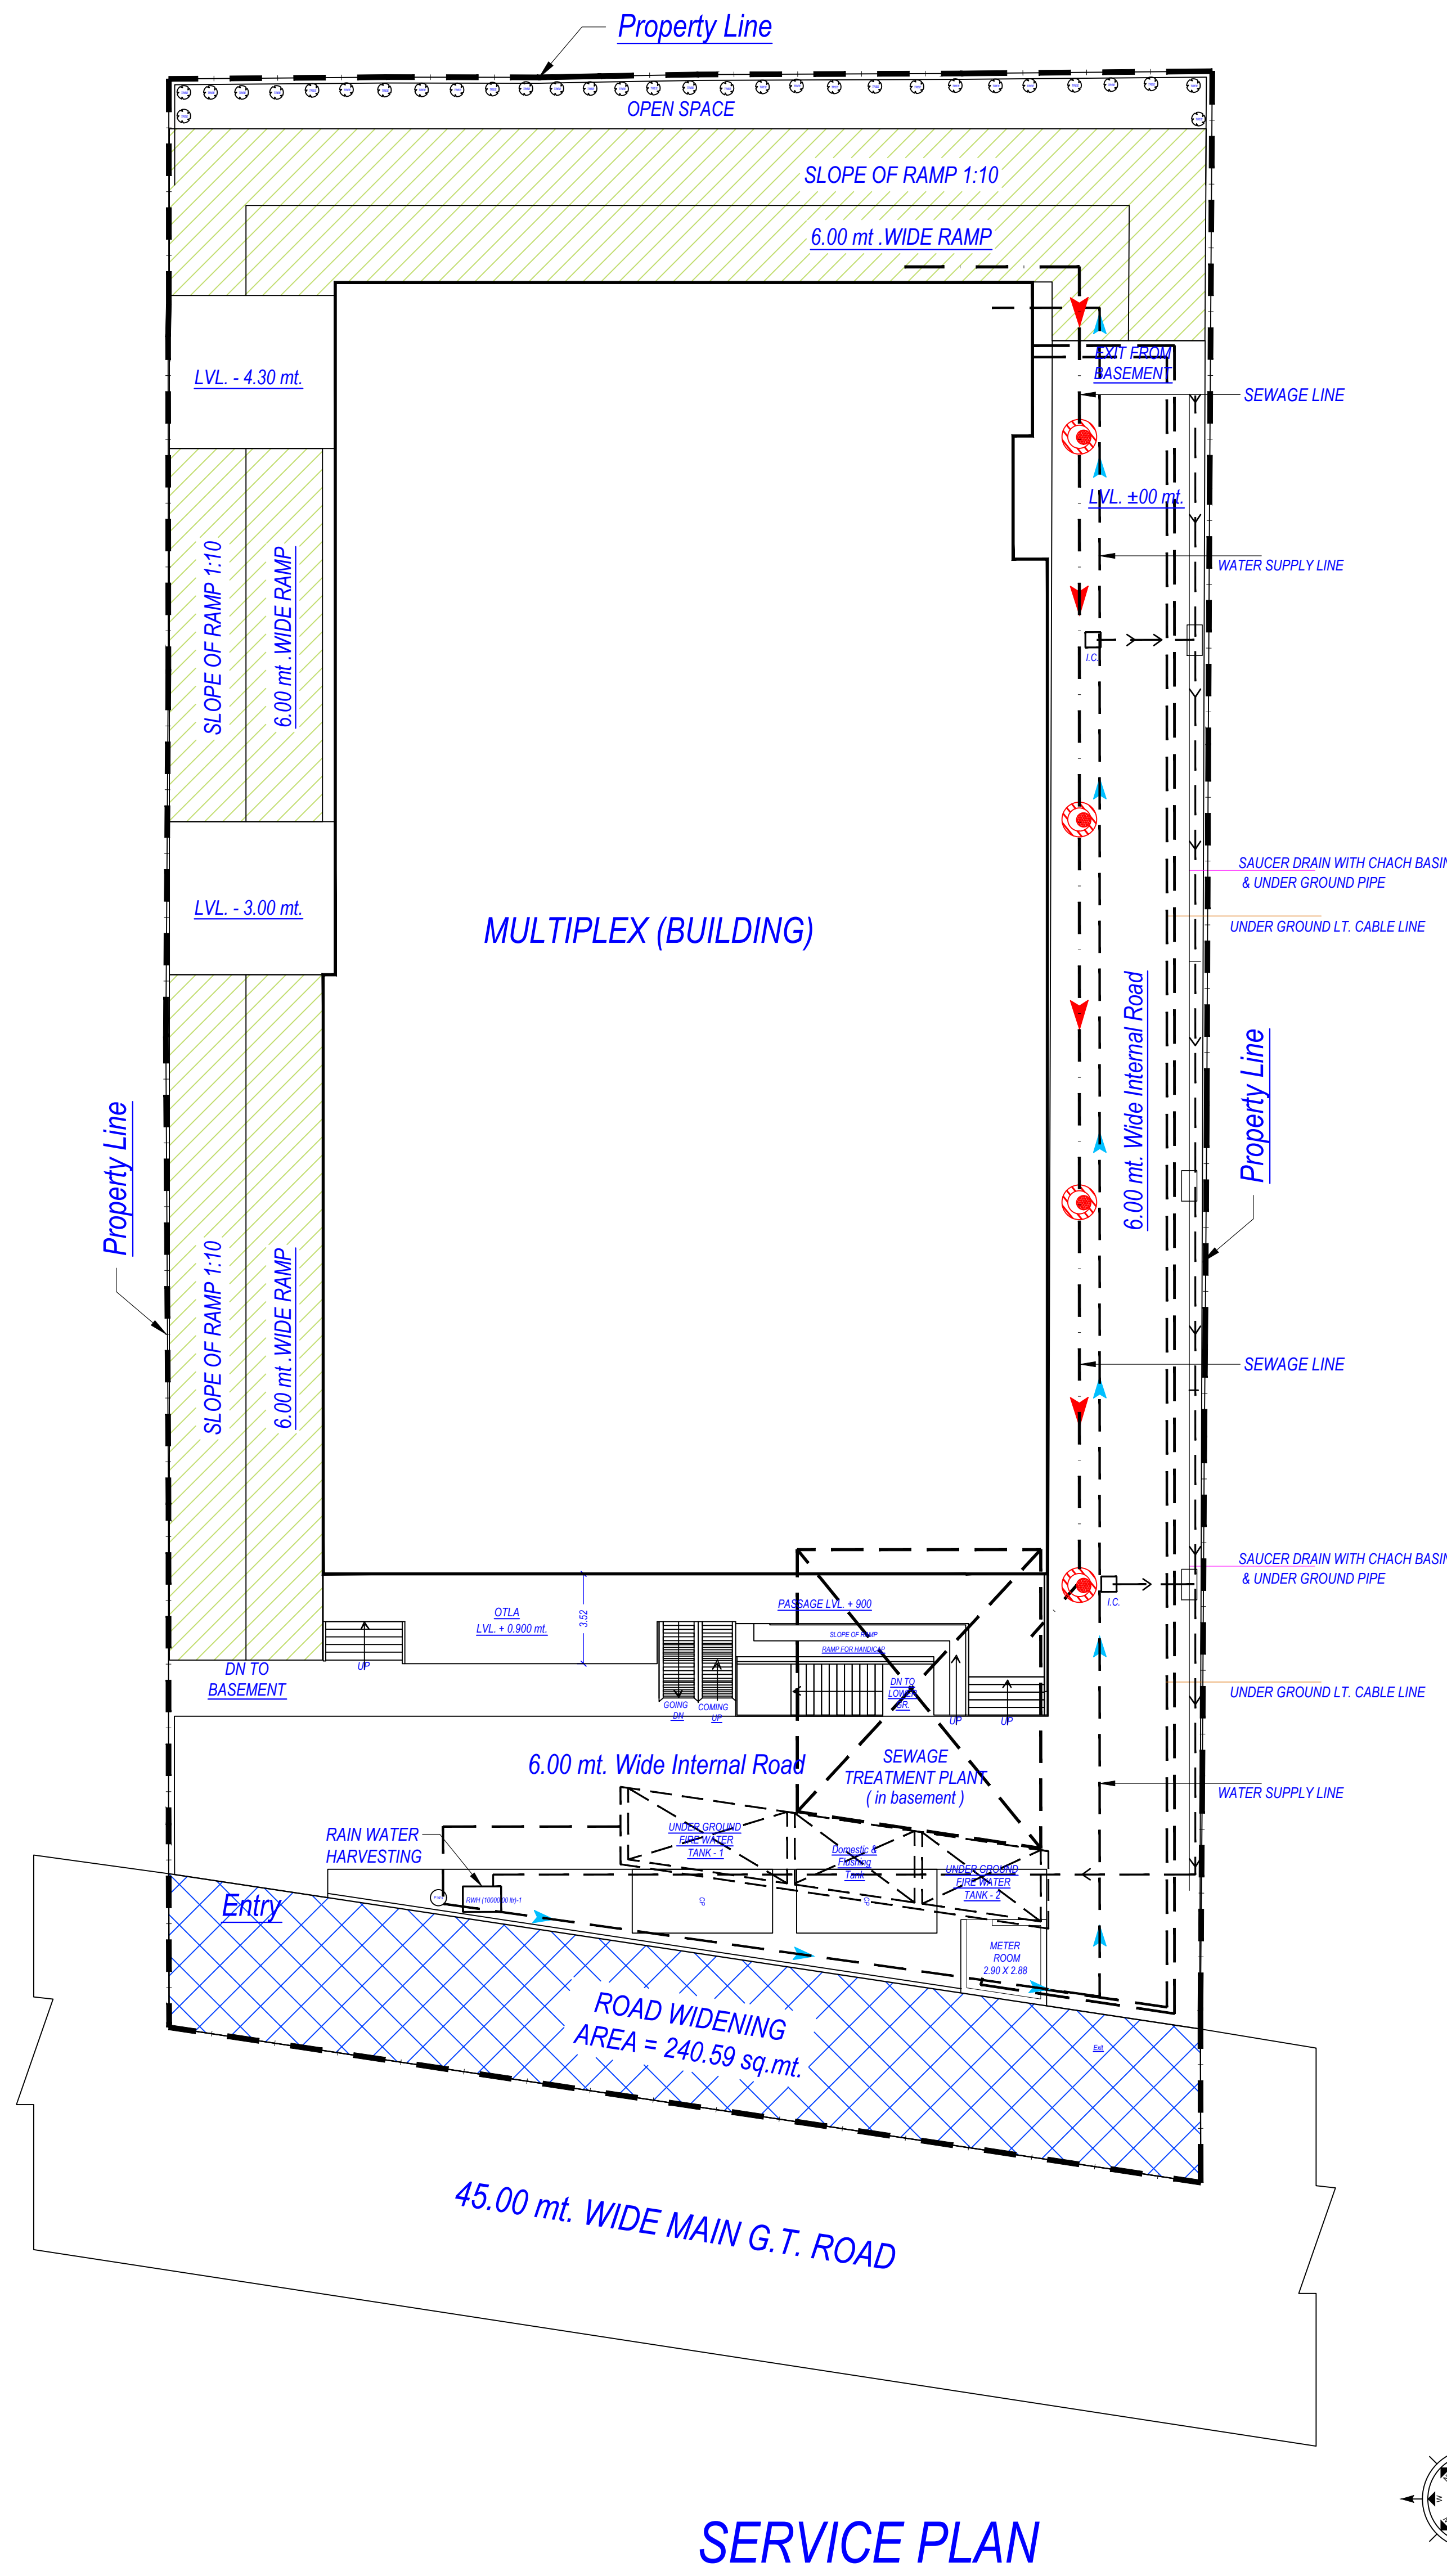


LEGEND:-		
SL.	SYMBOL	DESCRIPTION
1.	—	NP2 PIPE FOR SEWERAGE LINE
2.	G.L.	GROUND LEVEL
3.	I.L.	INVERT LEVEL
4.	C.L.	CONNECTION LEVEL
5.	L=8.0	LENGTH OF PIPE
6.		SEWER LINE MAN HOLE 900X800
7.		DRAIN LINE
8.		RAIN WATER HARVESTING PIT

LEGEND:-	
—	SEWER LINE
—	STORM WATER LINE
	SEWER MAN HOLE
	STORM WATER CATCH BASIN
	RAIN WATER HARVESTING PIT
	CABLE TRENCH
—	UNDER GROUND CABLE

OWNER'S NAME AND SIGNATURE
SARVOTTAM RETAIL INFRA PVT LTD. HR@GALACTICITY.IN.
888888975

ARCHENG'S NAME AND SIGNATURE
ANUJ AGARWAL
CA/96/19503

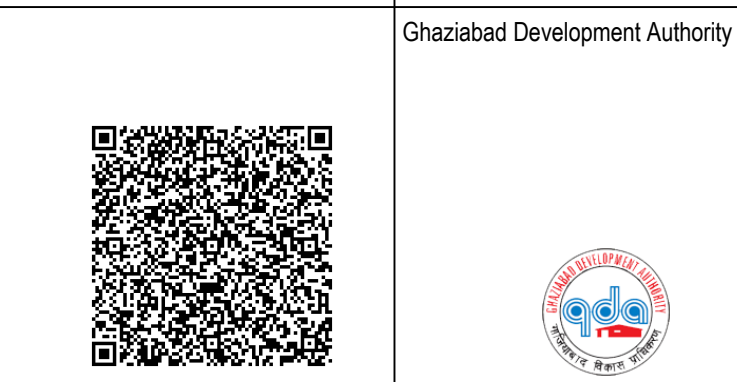

Building Plan Application Number
GDA/BP22-23/1455

Sanctioned On
19 Feb 2024

Valid Till
27 May 2029

Approved By
Ajay Kumar Singh (Chief Architect and Town Planner)

Examined By
Bhagwan Das Maurya (Junior engineer)

Dhananjay Singh (Assistant Engineer)

Bhagwan Das Maurya (Junior engineer)

Dhananjay Singh (Assistant Engineer)


Bhagwan Das Maurya (Junior engineer)

Dhananjay Singh (Assistant Engineer)

Note: - 1) This drawing is prepared as per the current prevailing Building Bye Laws.
2) If Map sanctioned is used for purpose anything other than stated in application will lead to rejection of Map.

ISO_A0_(841.00_x_1189.00_MM)

Total Plot Area: -	2996.31	Total FAR Area: -	6604.50
Total Coverage Area: -	1416.11	Total BUA Area: -	10736.93

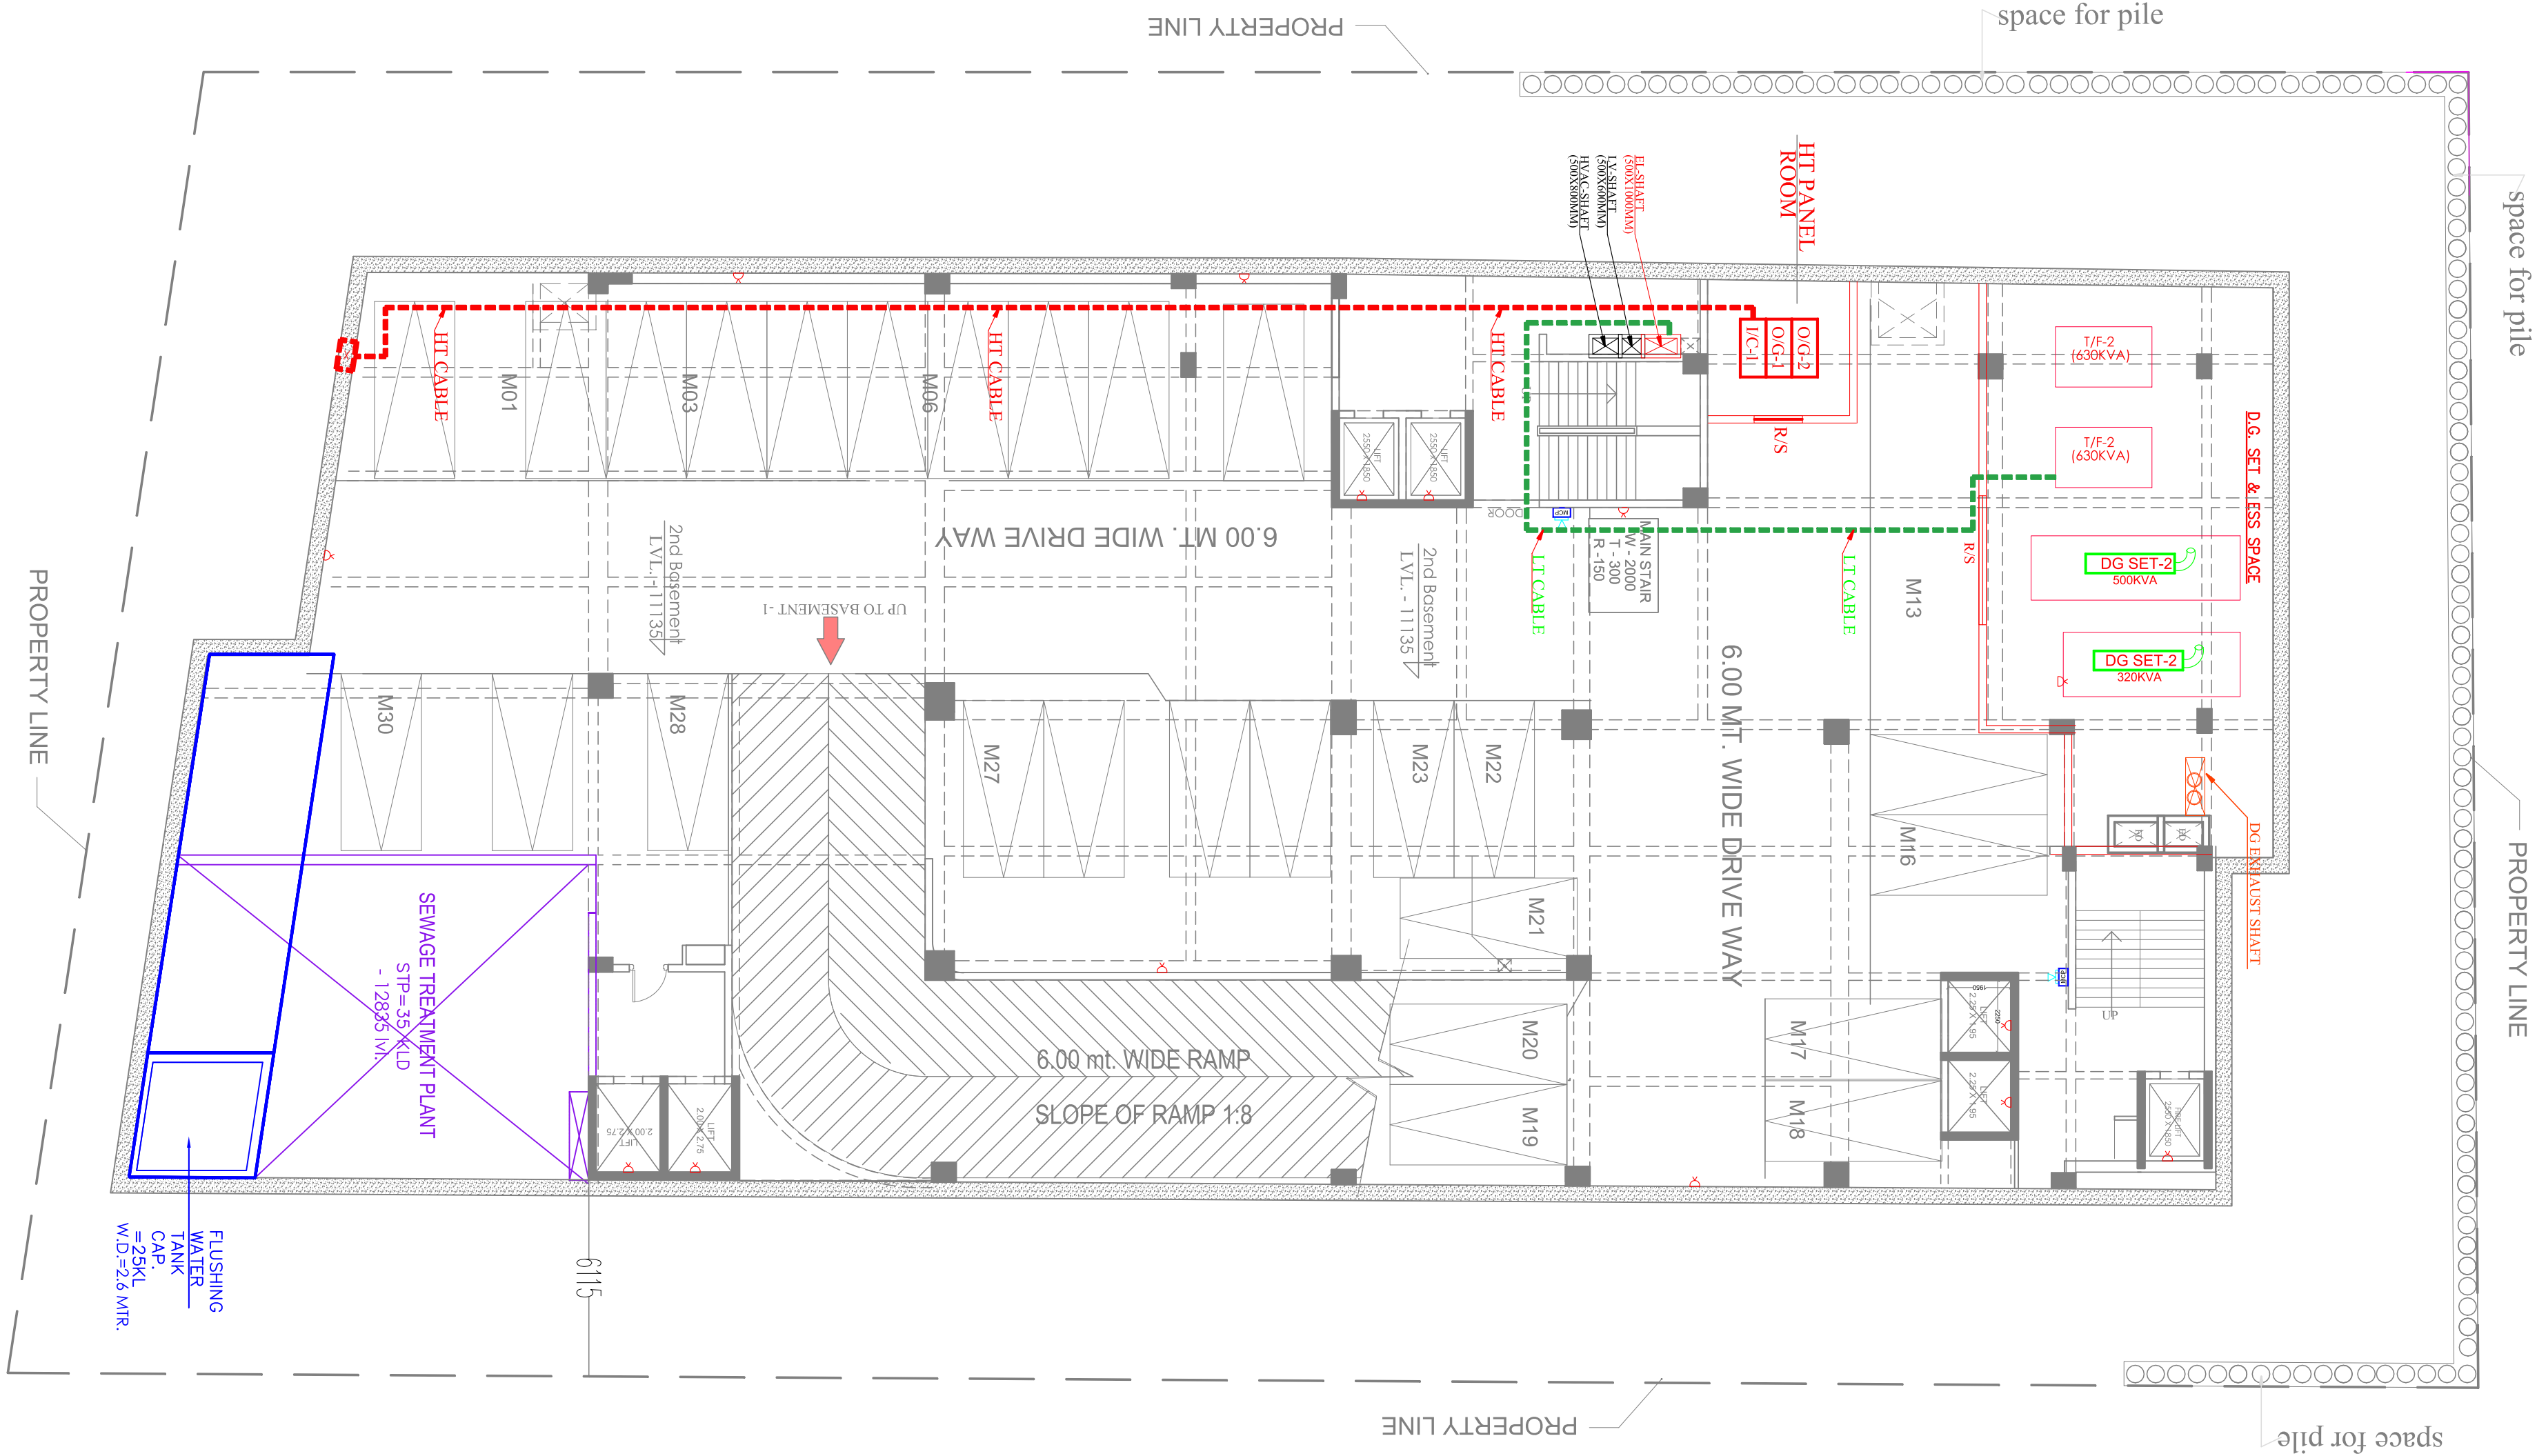

PROJECT: SUBMISSION DRAWINGS FOR COMMERCIAL / CINEMA BUILDING AT KHASRA NO. - 599, 600, 594/1 AT VILLAGE NASARPUR G.T. ROAD GHAZIABAD (U.P.)				
OWNER:- M/s. - SARVOTTAM RETAIL INFRA PVT. LTD.				
THROUGH:- Mr. - Kundl Singhal				
DRAWING TITLE : EL-LIGHT POWER LAYOUT 2ND BASEMENT PLAN				
Design Studio ANUJ AGARWAL ARCHITECTS OFFICE: A-244 KAUSHAMBI GHAZIABAD (U.P.) Ph: 0120 - 4165716, 4565716, 6454182 e-mail: anujagrawal@gmail.com				
SCALE	DEALT BY	CHECKED BY	DATE	DRG. NO. SD - 04