


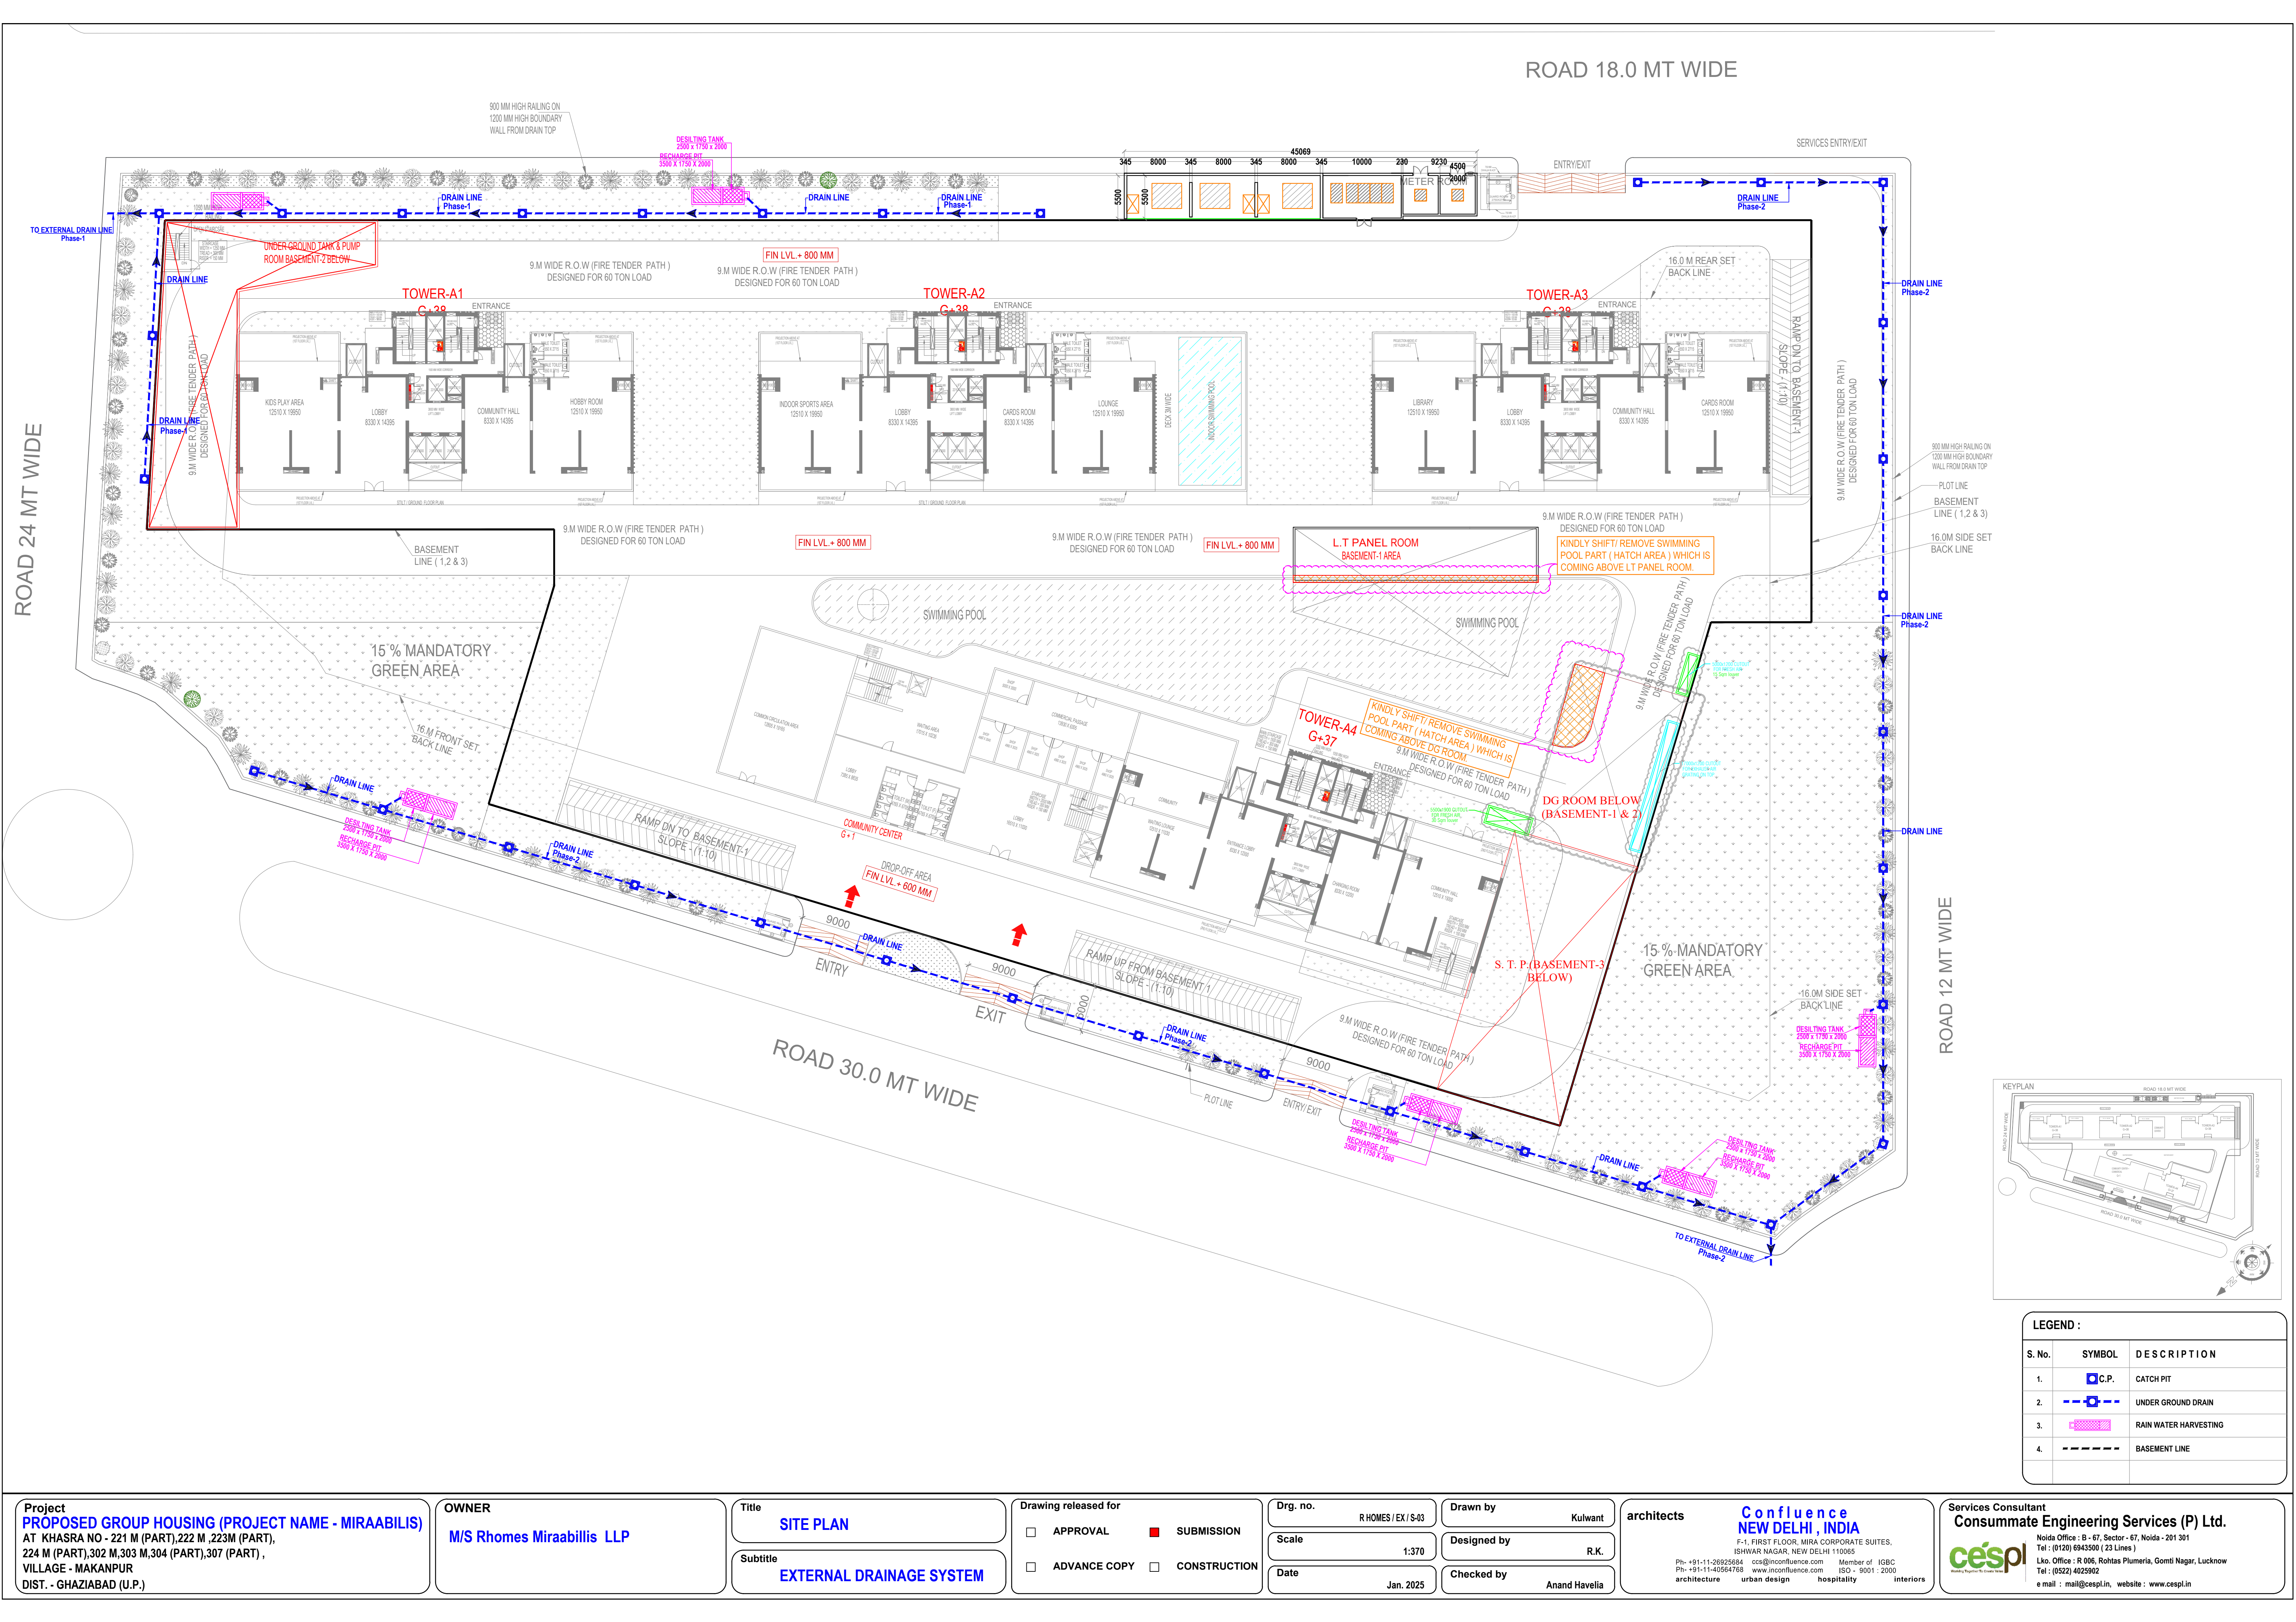

LEGEND :		
S. No.	SYMBOL	DESCRIPTION
1.		CATCH PIT
2.		UNDER GROUND DRAIN
3.		RAIN WATER HARVESTING
4.		BASEMENT LINE

Project
PROPOSED GROUP HOUSING (PROJECT NAME - MIRAABILIS)
AT KHASRA NO - 221 M (PART), 222 M, 223M (PART),
224 M (PART), 302 M, 303 M, 304 (PART), 307 (PART),
VILLAGE - MAKANPUR
DIST. - GHAZIABAD (U.P.)

OWNER
M/S Rhomes Miraabilis LLP

Title
SITE PLAN

Subtitle
EXTERNAL DRAINAGE SYSTEM

Drawing released for

☐ APPROVAL	☒ SUBMISSION
☐ ADVANCE COPY	☐ CONSTRUCTION

Drg. no.
R HOMES / EX / S-03

Scale
1:370

Date
Jan. 2025

Drawn by
Kulwant

Designed by
R.K.


Checked by
Anand Havelia

architects
Confluence
NEW DELHI, INDIA
F-1, FIRST FLOOR, MIRA CORPORATE SUITES,
ISHWAR NAGAR, NEW DELHI 110065
Ph: +91-11-269225684 cec@confluence.com Member of IBCB
Ph: +91-11-46564765 www.confluence.com ISO - 9001 : 2000
architecture urban design hospitality interiors

Services Consultant
Consummate Engineering Services (P) Ltd.
Noida Office : B - 67, Sector - 67, Noida - 201 301
Tel : (0120) 8943590 (23 Lines)
Lko. Office : R 066, Rohtas Plumeria, Gomti Nagar, Lucknow
Tel : (0522) 4025902
e mail : mail@cespl.in, website : www.cespl.in


ROAD 24 MT WIDE

ROAD 18.0 MT WIDE

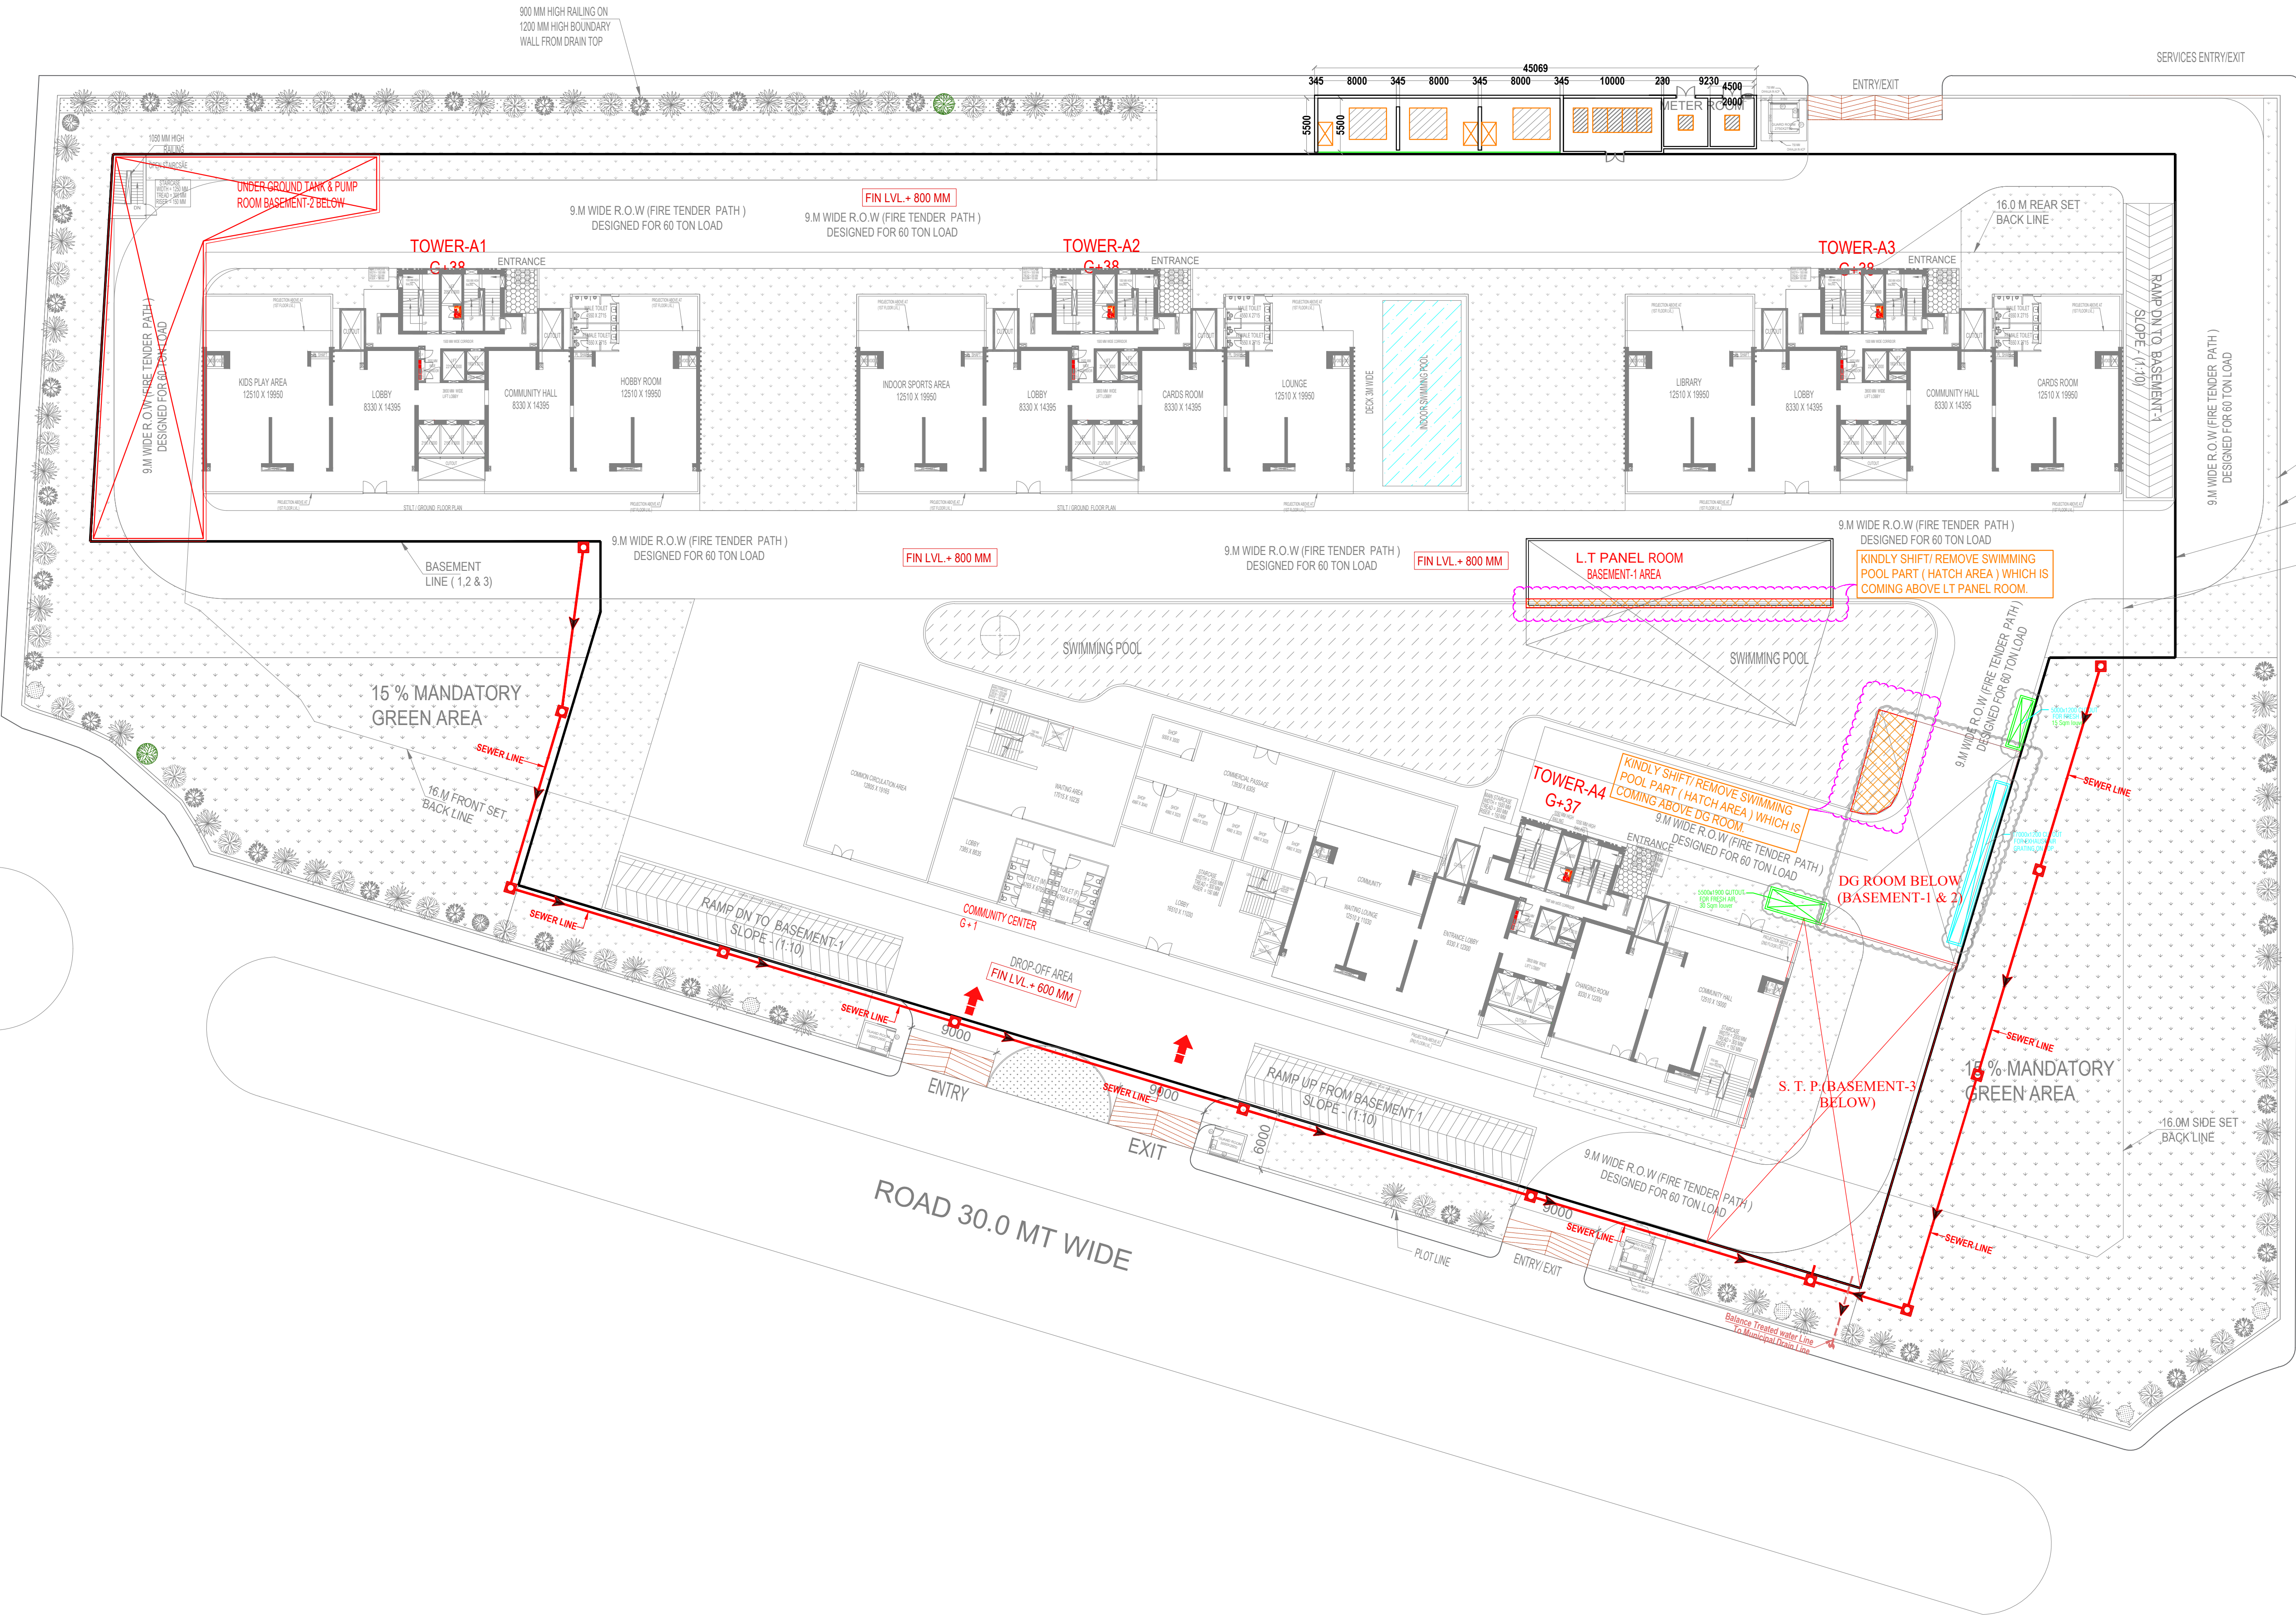

ROAD 12 MT WIDE

ROAD 30.0 MT WIDE

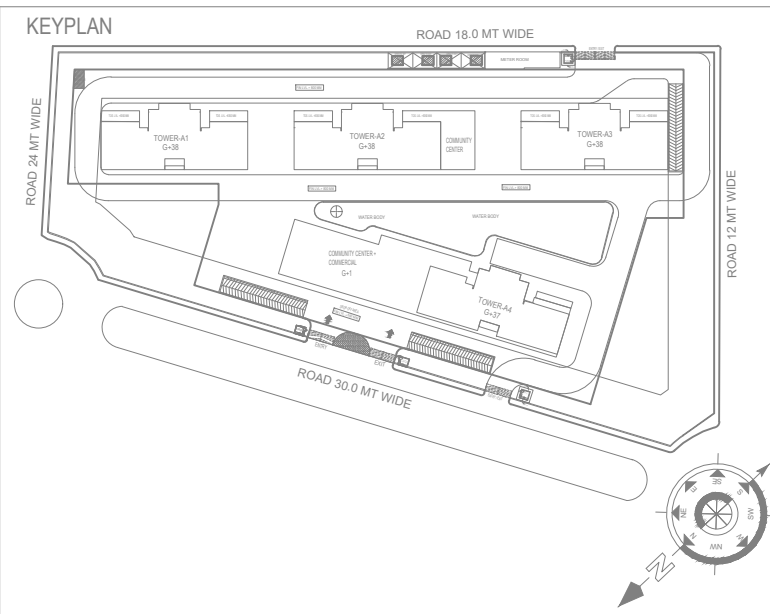

LEGEND :

S. No.	SYMBOL	DESCRIPTION
1.	M.H. □	MANHOLE
2.	—+—	SEWER LINE
3.	- - - -	BASEMENT LINE

Project
PROPOSED GROUP HOUSING (PROJECT NAME - MIRAABILIS)
AT KHASRA NO - 221 M (PART), 222 M, 223M (PART),
224 M (PART), 302 M, 303 M, 304 (PART), 307 (PART),
VILLAGE - MAKANPUR
DIST. - GHAZIABAD (U.P.)

OWNER
M/S Rhomes Miraabillis LLP

Title
SITE PLAN
Subtitle
EXTERNAL SEWERAGE SYSTEM

Drawing released for
☐ APPROVAL ☒ SUBMISSION
☐ ADVANCE COPY ☐ CONSTRUCTION

Drg. no.
R HOMES / EX / S-02
Scale
1:370
Date
Jan. 2025

Drawn by
Kulwant
Designed by
R.K.
Checked by
Anand Havelia

architects

Confluence
NEW DELHI, INDIA

F-1, FIRST FLOOR, MIRA CORPORATE SUITES,
ISHWAR NAGAR, NEW DELHI 110065
Ph: +91-11-26925684 cec@confluence.com Member of IBCB
Ph: +91-11-46564768 www.confluence.com ISO - 9001 : 2000
architecture urban design hospitality interiors

Services Consultant
Consummate Engineering Services (P) Ltd.

Wazir Office : B-67, Sector - 67, Noida - 201 301
Tel : (0120) 8943500 (23 Lines)
Lko. Office : R-066, Rohtas Plumeria, Gomti Nagar, Lucknow
Tel : (0522) 4025902
e mail : mail@cespl.in, website : www.cespl.in