
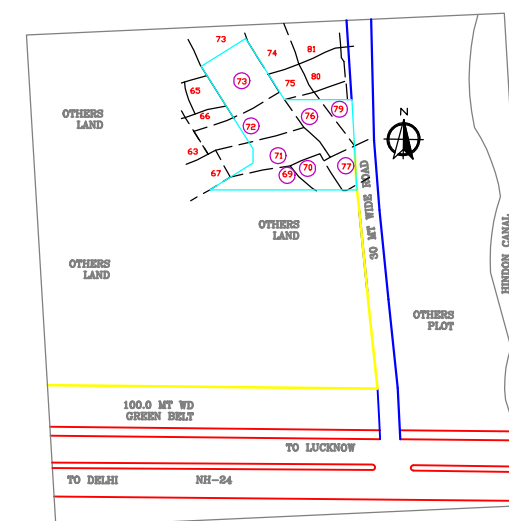


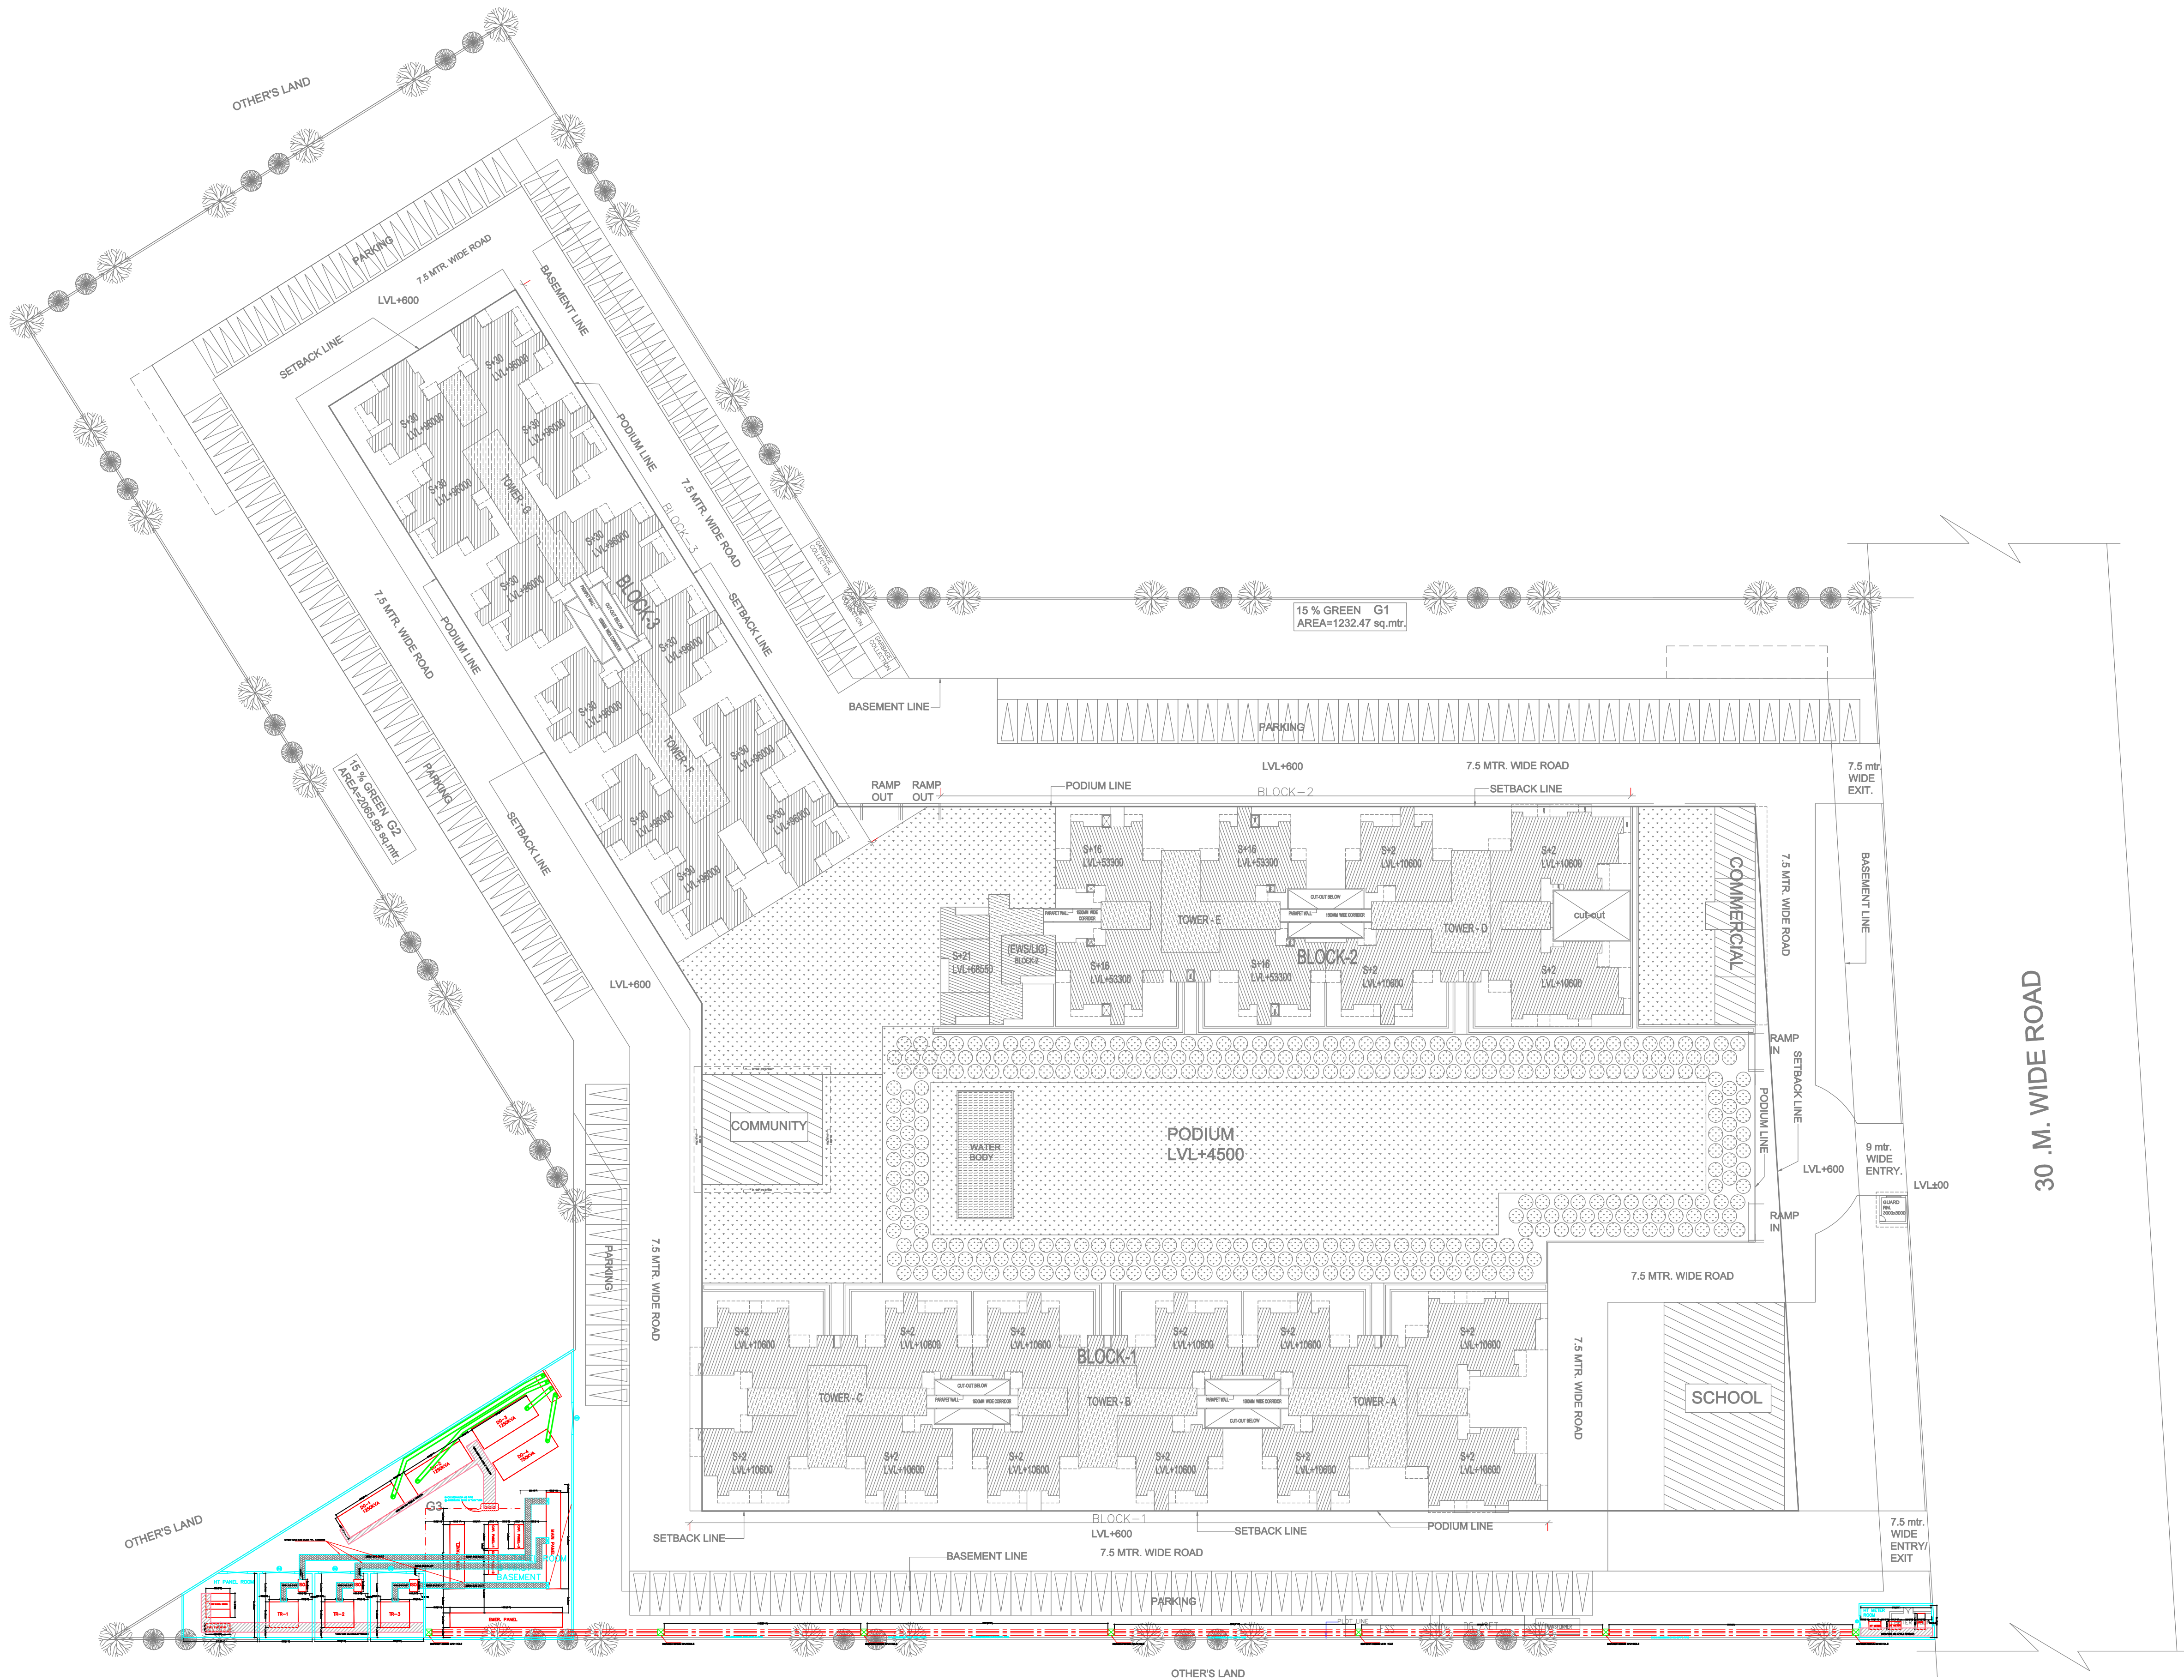

DEVELOPER :- M/S Ramprastha Urban Development Pvt. Ltd.		TITLE:- ELECTRICAL SITE LAYOUT PLAN		Owner :- ANJU YADAV KANTA YADAV SURAT SINGH, M/S HARJAS PICTURES PVT. LTD. M/S MAHAMAYA ISPAT UDYOG PVT. LTD. M/S RAMPRASTHA PROPERTIES PVT. LTD.	Owner Sign:-	Architect Sign:-	Architect:- RD DESIGN ATRIUM ARCHITECTS & URBAN PLANNERS 1st FLOOR, D-1, SECTOR-7 NOIDA-201301 Ph: 0120-4220363, 4323408 e-mail:- office@rddesign.in	North:-
Project:- PROPOSED GROUP HOUSING ON KH.NO. 69m,70m,70mi,71m,71mi,72m,72mi,73m,73mi,76m,76mi,77/2 ,79mi AT VILLAGE CHHAJARS, TEHSIL - DADRI, DIST - GAUTAM BUDDHA NAGAR, U.P.		SCALE =	Drg. No					
		Drawn -	SUB-EL-03					