


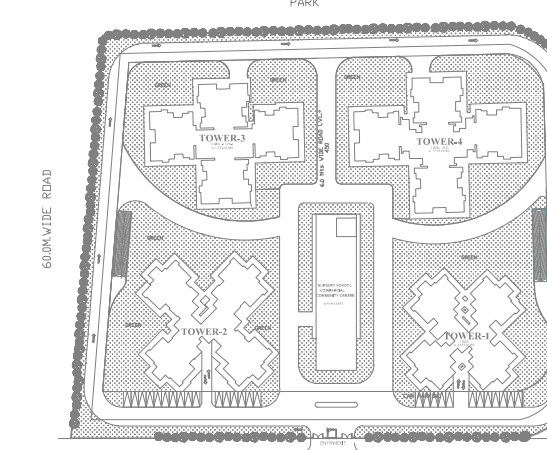

KEY PLAN

No.	DISCRPTION	DATE

SERVICE CONSULTANT

PEE CONSULTANTS
815-C, DDA FLATS, EAST OF LONI ROAD.
SHAHNARA, DELHI-93 PH. & FAX: 22816297
email :- pdss in@yahoo.com

	SERVICE CONSULTANT
--	--------------------

DESIGN CENTRE CONSULTING ENGINEERS
ELECTRICAL & MECHANICAL CONSULTANTS

OFFICE NO 44 TO 47, 4TH FLOOR
ANSAAL PLAZA, DABUR CHOWK
GHAZIABAD U.P.-201005
PHONE: 0120-4333451, 4333452
E-MAIL: info@dcce-engineers.com



STRUCTURE CONSULTANT

NNC DESIGN INTERNATIONAL
CONSULTING STRUCTURAL ENGINEERS
G-70, 2nd FLOOR, JASWANT PLAZA, NEAR KALINDI KUNJ
MAIN SARITA VIHAR ROAD, OKHLA, NEW DELHI-110025
PHONE NO.: +91-11-26940734/5/6/7/8 FAX: 26940738
E-Mail : nnc_consultants@hotmail.com
Web : www.nncdesigninternational.com

PROJECT

PROPOSED GROUP HOUSING
AT PLOT NO- 03,
GH-04,SECTOR-4 (G.NOIDA)

CLIENT

Aastha Infracity Ltd.




C - 10, SEC - 3 ,
NOIDA U.P. 201301
TEL : 120 - 4601000, 120 - 4601010
E-MAIL : info@dfa.in

SCALE SCALE- 1: 100@A1	DATE 16.04.2018	SHEET NO.	NORTH 
DRAWN BY PARVEEN	CHECKED BY MONU		

TYPICAL FLOOR FIRE FIGHTING
LAYOUT PLAN(TOWER-1)

DRG.NO	REVISION
AS/AG/1/A-FF-102	R3

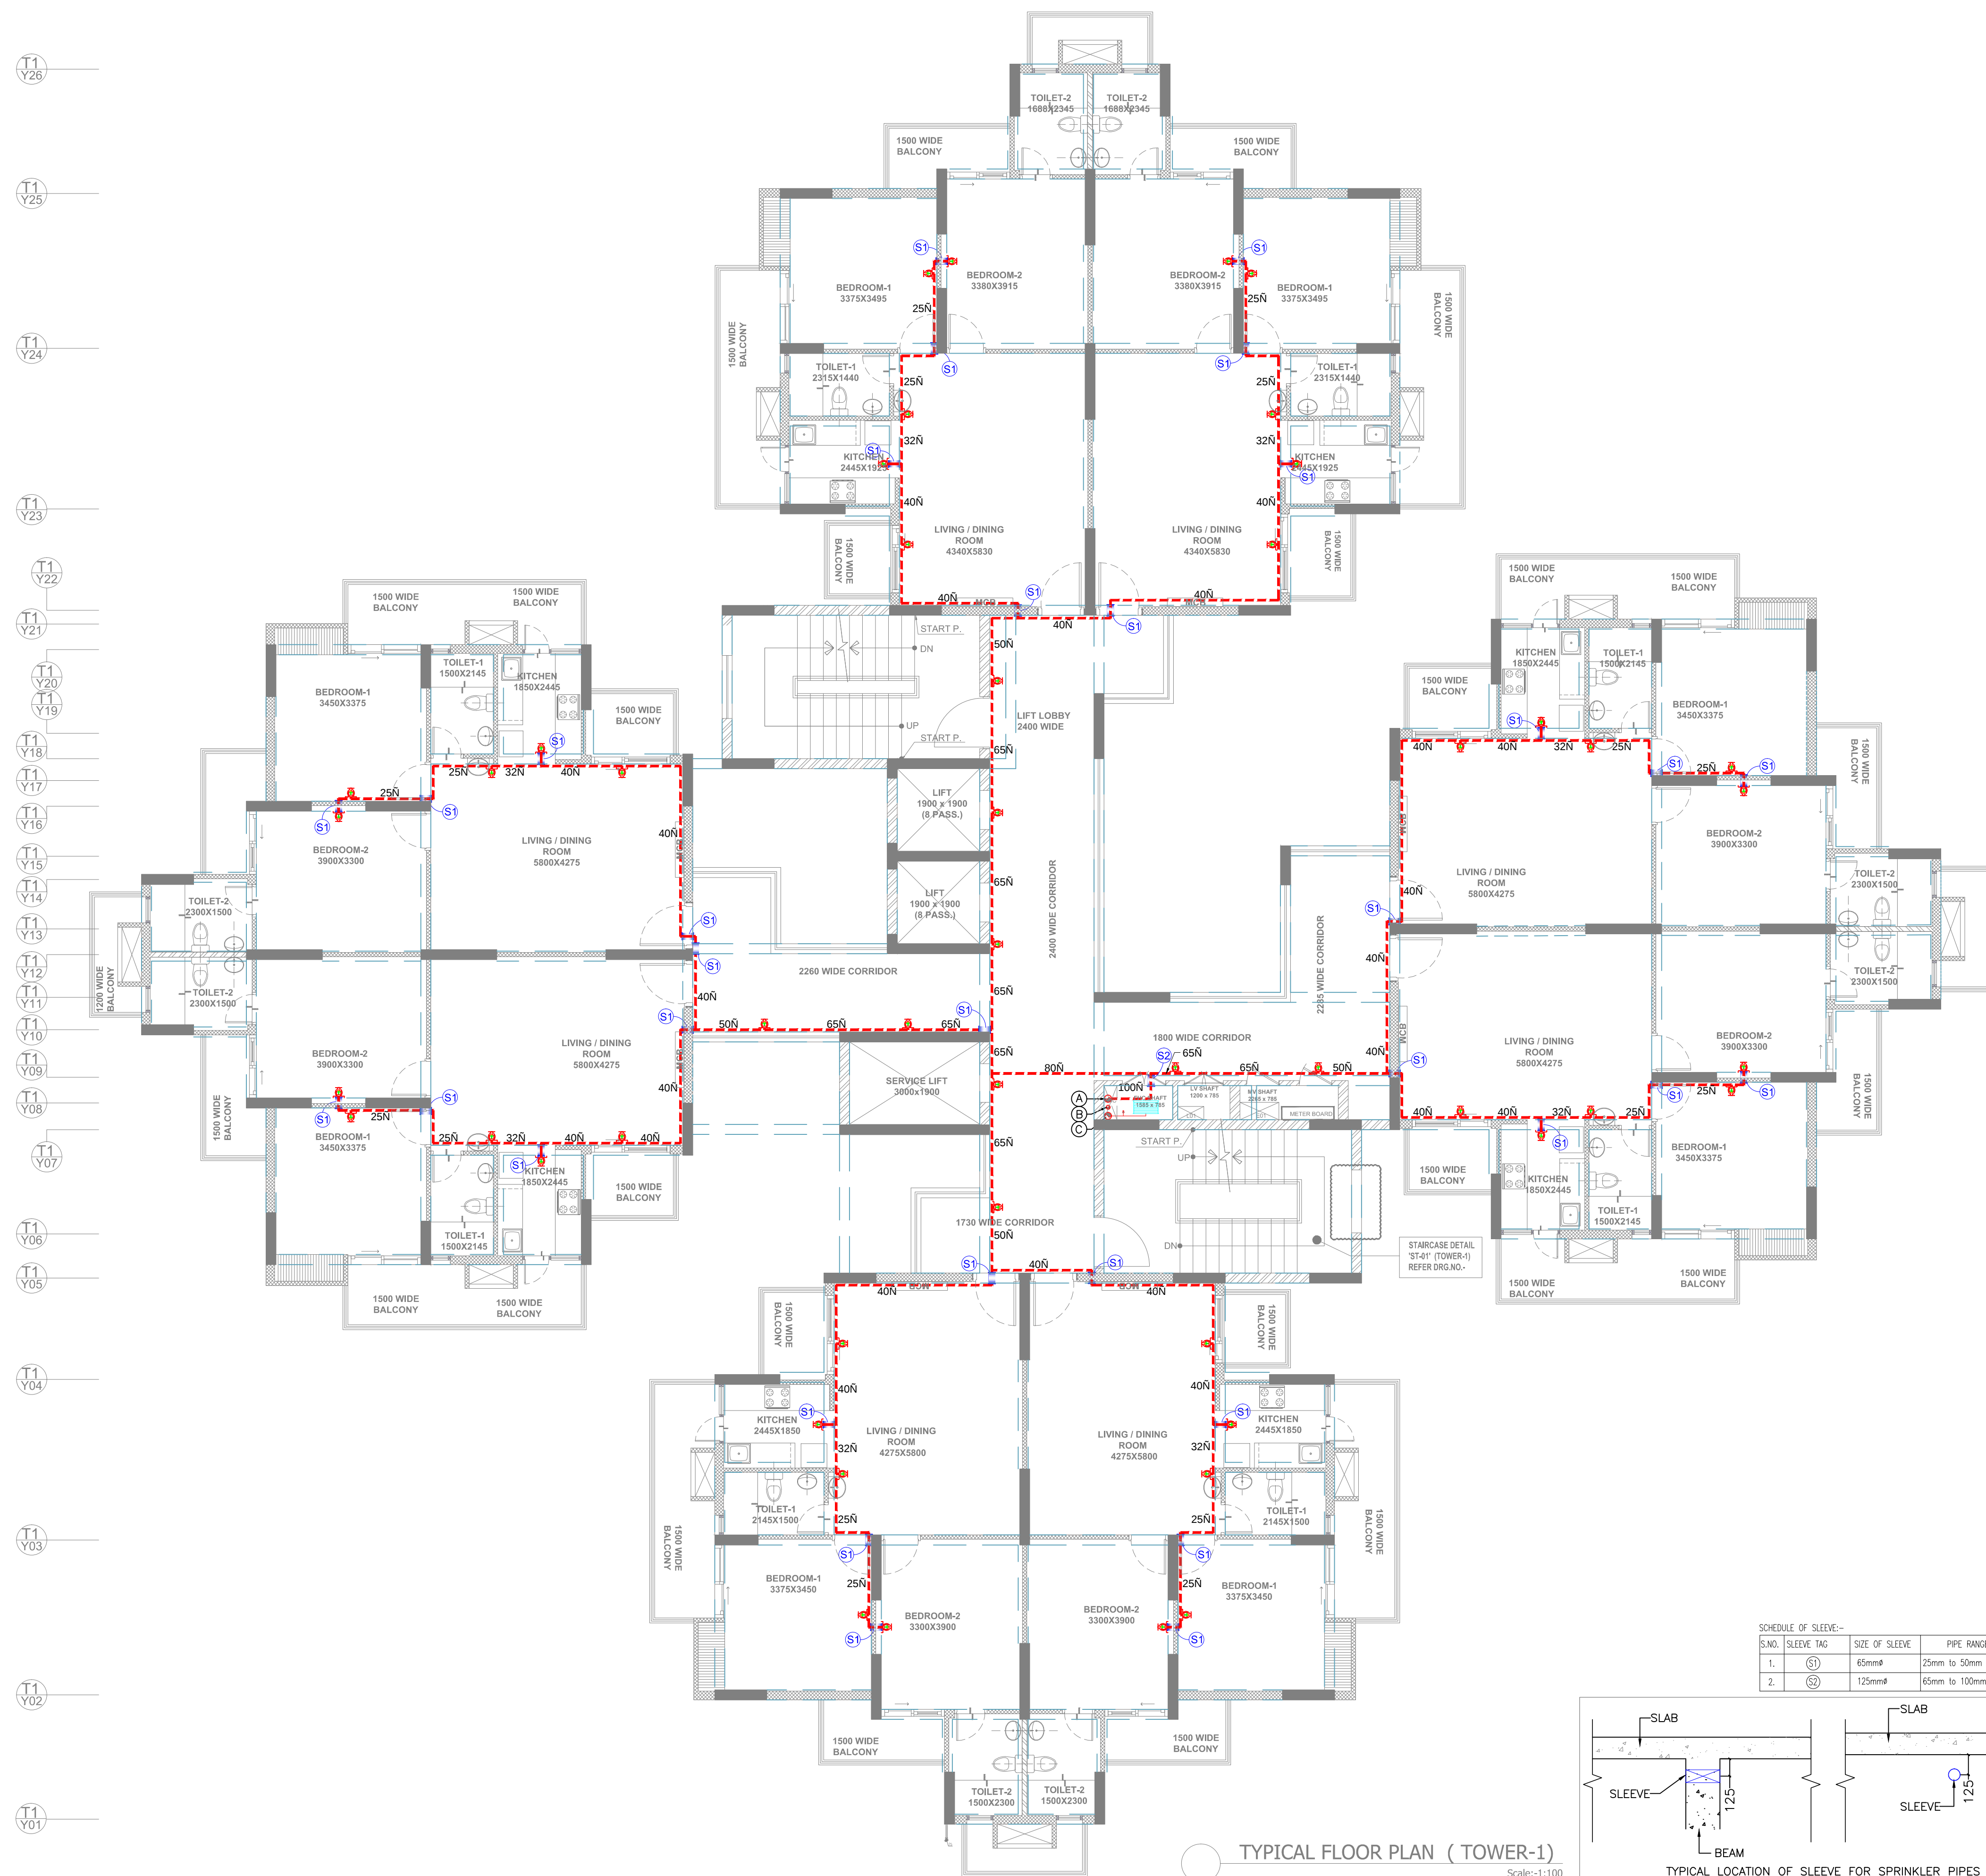

TYPICAL FLOOR PLAN (TOWER-1)

Scale:-1:100

