

PROJECT
PROPOSED
CHANDRA SHILA
GROUP HOUSING AT NEHRU NAGAR II
ELECTRICAL

DEVELOPED BY
GHAZIABAD DEVELOPMENT AUTHORITY


PROJECT MANAGER:
SCALE:
DRN BY:
DATE:

DRG. NO.:
CH. CO. HO./SEE-03
JITENDRA
APR.-2015


ARCHITECTURAL CONSULTANTS -
ATUL GUPTA
H - 131, SECTOR 63, NOIDA

Services Consultant:
SHAH & PRNT
CONSULTING ENGINEERS (P) LTD
1, 4th Floor, HALVASYA COURT, HAZRA NAGAR, DELHI
Toll No. 0522-230033, Fax: 0522-230033, Cell: 9890171111

TYPICAL FLOOR PLAN

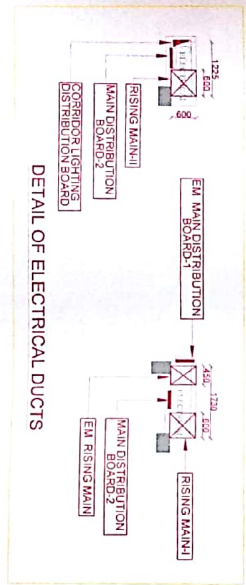

NOTE :- Please provide sleeves in beam and lintel at the time of construction as per electrical and plumbing drawings.

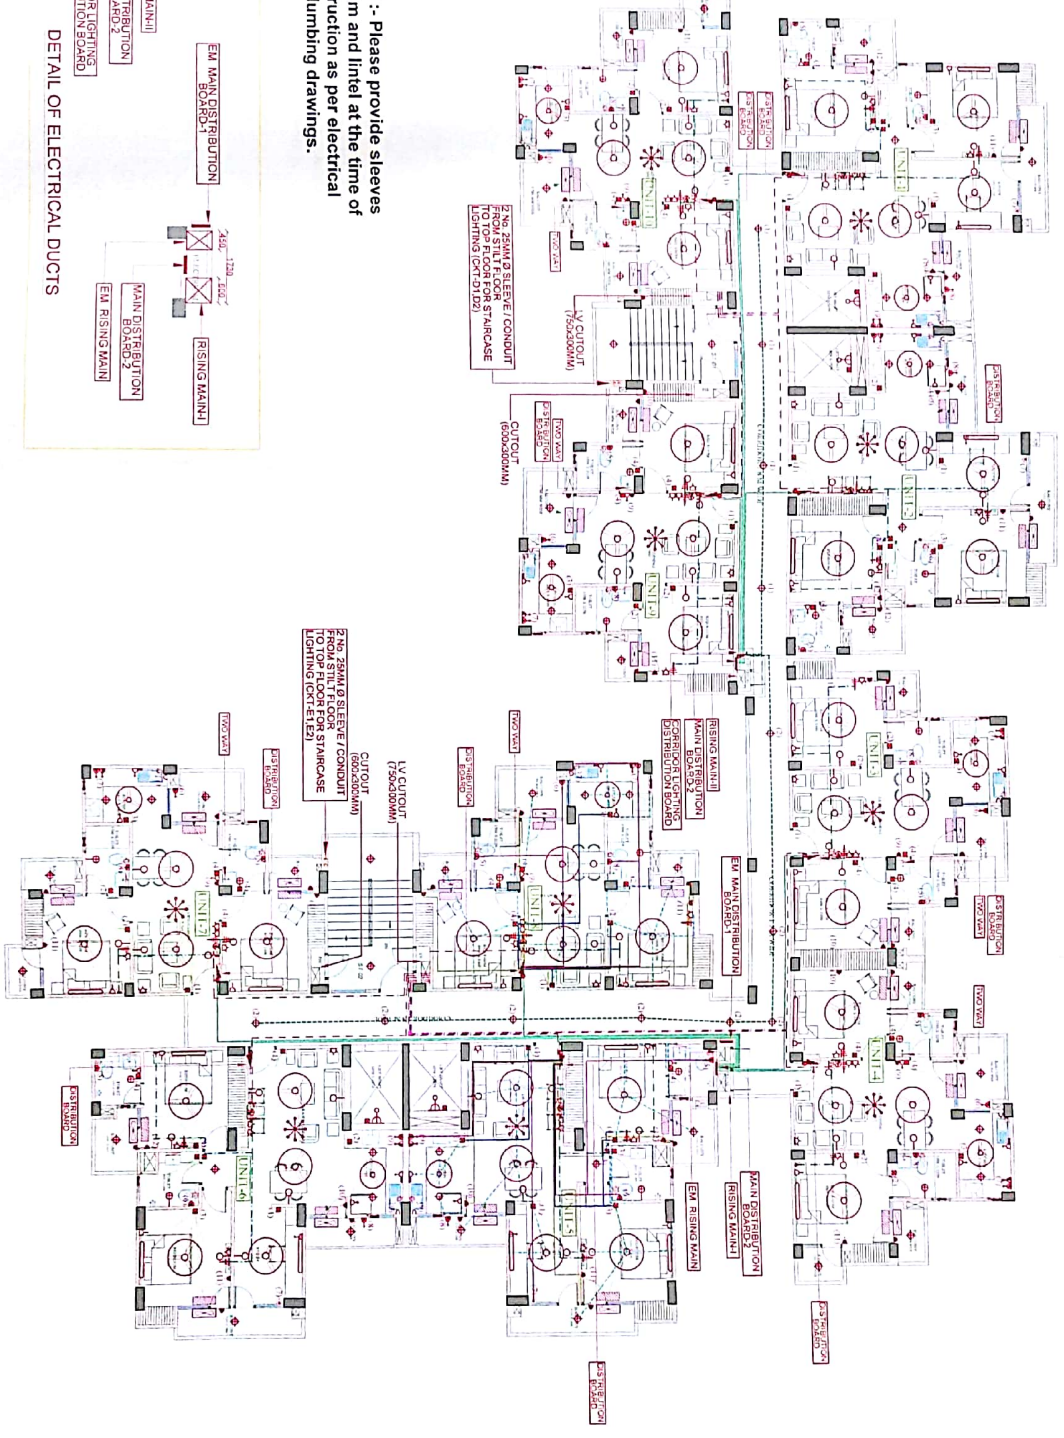

LEGEND:- (electrical)

1	LOAF POINT WALL BRACKET	2250
2	LOAF POINT WALL BRACKET	2200
3	CEILING LIGHT (SURFACE)	2000
4	11 KWP TUBE LIGHT (SURFACE)	
5	WIRELESS LIGHT	
6	CANDLER	2000
7	CEILING FAN	2250
8	WALL MOUNTING PERCUSSION FAN	200
9	6 AMP FUSE POINT	500
10	6 AMP FUSE POINT (BED ROOM)	1200
11	6 AMP FUSE POINT (BED ROOM)	2100
12	6 AMP SOCKET OUTLET (BED ROOM)	200
13	6 AMP SOCKET OUTLET (BED ROOM)	
14	6 AMP FUSE POINT	1000
15	6 AMP FUSE POINT (BED ROOM)	1000
16	6 AMP FUSE POINT (BED ROOM)	1000
17	6 AMP FUSE POINT (BED ROOM)	1000
18	6 AMP FUSE POINT (BED ROOM)	1000
19	6 AMP FUSE POINT (BED ROOM)	1000
20	6 AMP FUSE POINT (BED ROOM)	1000
21	6 AMP FUSE POINT (BED ROOM)	1000
22	6 AMP FUSE POINT (BED ROOM)	1000
23	6 AMP FUSE POINT (BED ROOM)	1000
24	6 AMP FUSE POINT (BED ROOM)	1000
25	6 AMP FUSE POINT (BED ROOM)	1000
26	6 AMP FUSE POINT (BED ROOM)	1000
27	6 AMP FUSE POINT (BED ROOM)	1000
28	6 AMP FUSE POINT (BED ROOM)	1000
29	6 AMP FUSE POINT (BED ROOM)	1000
30	6 AMP FUSE POINT (BED ROOM)	1000
31	6 AMP FUSE POINT (BED ROOM)	1000
32	6 AMP FUSE POINT (BED ROOM)	1000
33	6 AMP FUSE POINT (BED ROOM)	1000
34	6 AMP FUSE POINT (BED ROOM)	1000
35	6 AMP FUSE POINT (BED ROOM)	1000
36	6 AMP FUSE POINT (BED ROOM)	1000
37	6 AMP FUSE POINT (BED ROOM)	1000
38	6 AMP FUSE POINT (BED ROOM)	1000
39	6 AMP FUSE POINT (BED ROOM)	1000
40	6 AMP FUSE POINT (BED ROOM)	1000