
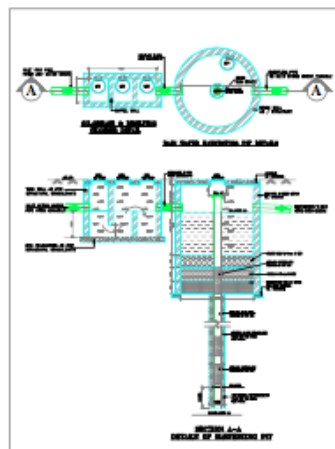


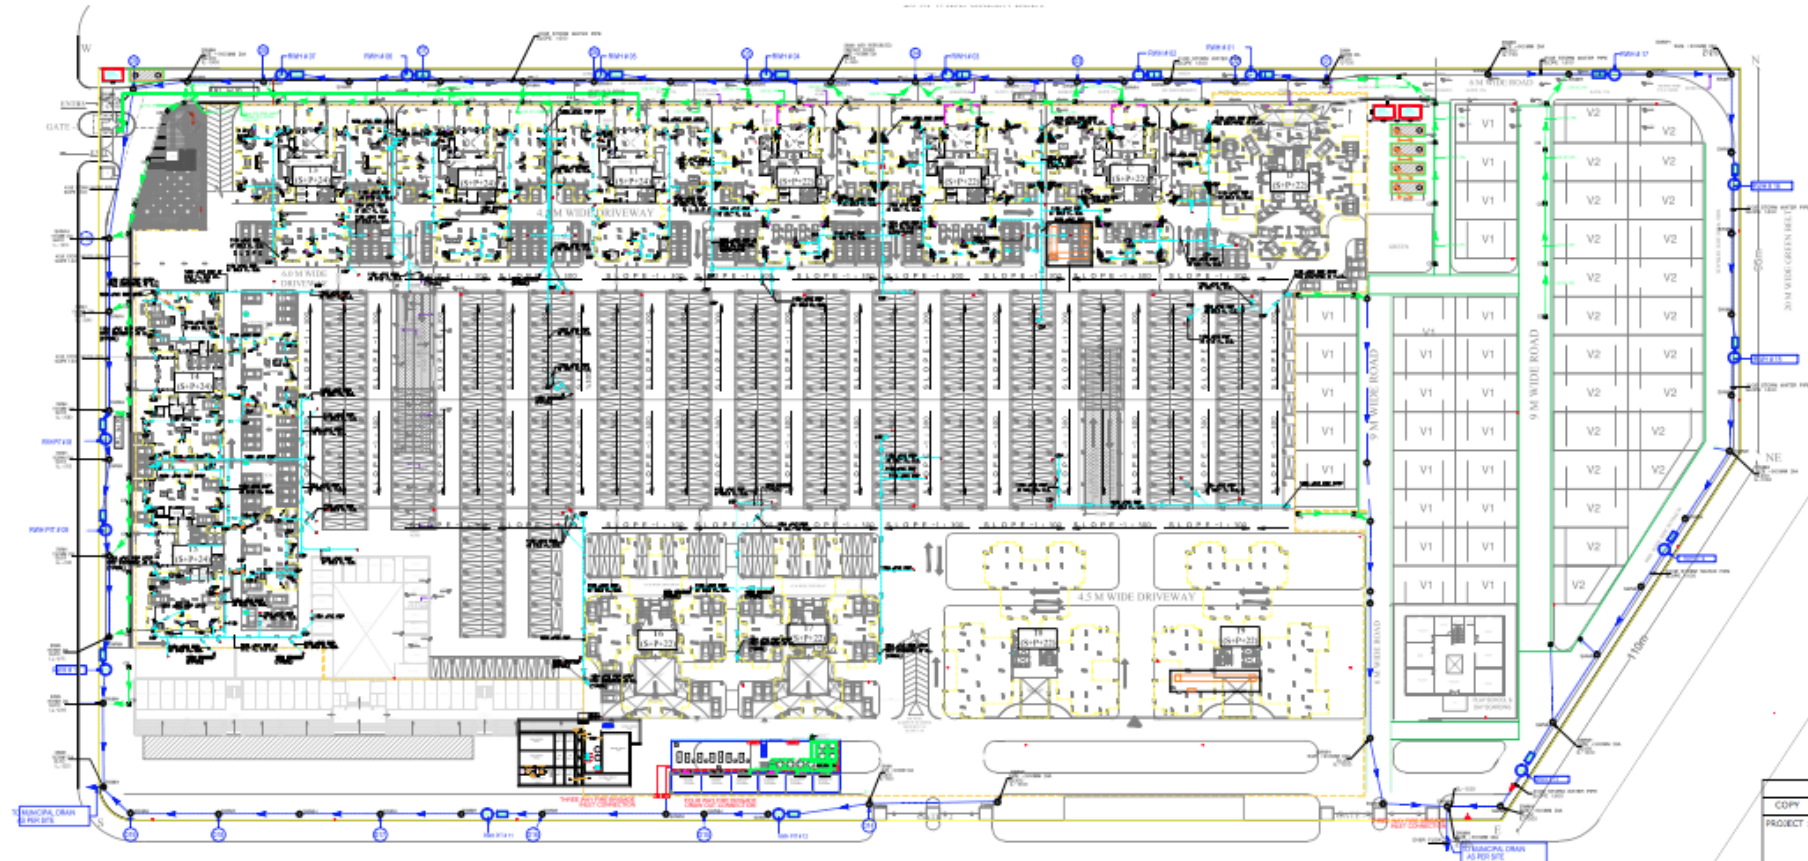

LEGEND-		
S.NO.	DESCRIPTION	SYMBOL
1	TOP SOIL & VENT PIPE	(1)
2	TOP WASTE & VENT PIPE	(2)
3	TOP RAIN WATER PIPE	(3)
4	TOP RAIN WATER PIPE FOR BALCONY	(4)
5	DOMES 'K' WATER SUPPLY PIPE	(5)
6	FLUSHING WATER SUPPLY PIPE	(6)
7	HOT WATER SUPPLY PIPE	(7)
8	DOMES 'K' WATER RESEV PIPE	(8)
9	DOWN-SIDE WATER DRAIN	(9)
10	FLOOR TRAP	(10)
11	FLOOR DRAIN	(11)
12	BALL VALVE	(12)
13	SOIL PIPE LINE	(13)
14	WASTE PIPE LINE	(14)
15	CLEAN OUT PLUG	(15)
16	PRESSURE REDUCING VALVE	(16)

COPY	REV	DATE	REVISION/ISSUED TO
PROJECT :-		"THE ARANYA"	
		SECTOR-119, NOIDA	
BUILDERS & PROMOTER :-			
UNNATI FORTUNE GROUP			
DRAWING TITLE:			
STILT FLOOR PLAN			
STORM WATER DRAINAGE LAYOUT			
MEP CONSULTANTS :-			
KKSC			
KISHOR KUMAR SERVICES CONSULTANTS			
SVP-PINNACLE TOWER, 24/F		PHONE: +91 120 4120558	
APRIMA WINDOZ 2, 2ND FLOOR		MOBILE: +91 9810877555	
GHANASHYAM, UP-201014		www.kksc.com	
ARCHITECTS:			
DIMENSIONS & DESIGNS			
architects, engineers & interior designers			
D-88B, Chaitanyan Park			
NEW DELHI-110019 (INDIA)			
PH: 011-26274473, 011-26274474			
DRAWN BY :-		CHECKED BY :-	
A.S.		K.K.	
DATED :-		DATE :-	
1:600		06.02.2018	
SCALE :-		S.D. NO. :-	
1:600		KKSC-SITE-DR-01	
		S.D.	

D&D