

DRG. NO.


FILE. NO.

NOTES:-

- 1) All Dimensions are in MM.
- 2) The site staff should coordinate this Arch. drwg. with the relevant Str. & Services drwg. before the start of the work.
- 3) In case any discrepancy is found in the drwg. the same shall be brought to the notice of the E.I. Charge / consultant. The work shall not be carried out without clarification from the consultant.

SCHEDULE OF PIPES

PIPE NO.	DESCRIPTION
①	100mm SWR PVC SOIL VENT PIPE
②	100mm SWR PVC WASTE VENT PIPE
③	75mm SWR PVC ANTISYPHONAGE PIPE
④	100mm SWR PVC KITCHEN WASTE PIPE
⑤	100mm SWR PVC RAIN WATER PIPE
⑥	100mm SWR PVC RAIN BALCONY DRAINAGE PIPE
⑦	DOMESTIC WATER RISER PIPE
⑧	DOMESTIC WATER SUPPLY PIPE
FD	FLOOR DRAIN
FT	FLOOR TRAP
NT	NAHANI TRAP
CUTOUT	CUTOUT
300mmx300mm	GULLY TRAP
900mm.DIA	MANHOLE(SEWERAGE)
900X800mm	MANHOLE(DRAINAGE)
600mm.x600mm.x600mm	CHAMBER
450mm.x450mm	CATCH BASIN
E.S.P.	EXTERNAL SEWERAGE PIPE
R.W.P.	EXTERNAL DRAINAGE PIPE
	INTERNAL
SEWERAGE	U.P.V.C SWR PIPE
WATER SUPPLY	C.P.V.C PIPE
	EXTERNAL
	U.P.V.C SWR PIPE
	C.P.V.C PIPE/D.I.

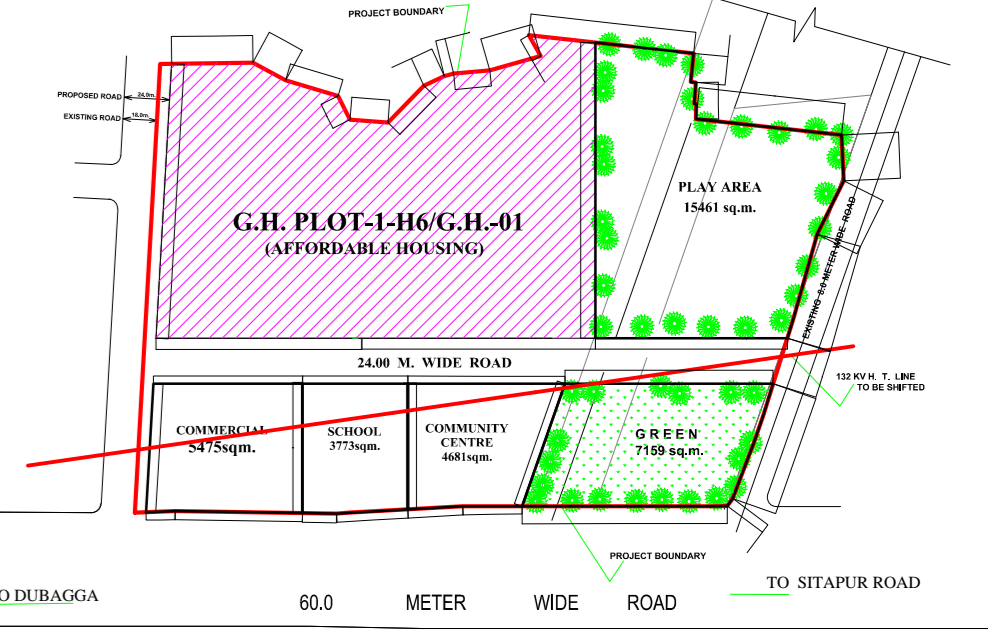

DATE	NO.	ISSUED TO	INITIAL
08.09.16	R1	SITE PLAN REVISED A/P REVISION IN DIMENSION OF THE PLOT.	
		BRIEF RECORD	

REVISION			

CONSULTANTS:
SAJAG CONSULTANTS
C-146 KILOKRI
NEAR MAHARANI BAGH CROSSING
NEW DELHI-110014
TELEPHONE-26343059,9868848054

DIVISION	DRAWN	CHECKED	APPED	UNIT
PL_	VIKRAM	VIJAY	R.B.	M.M.


DRG. NO. : 211.ES.00.01
SCHEME:
AMRAPALI YOJNA, HARDOI ROAD,
LUCKNOW.

DRG. TITLE:
EXTERNAL SEWERAGE LAYOUT PLAN

PROJECT:
GROUP HOUSING ON
PLOT NO. H6/G.H.-1

DATE: 21-04-2017

SCALE: 1:250

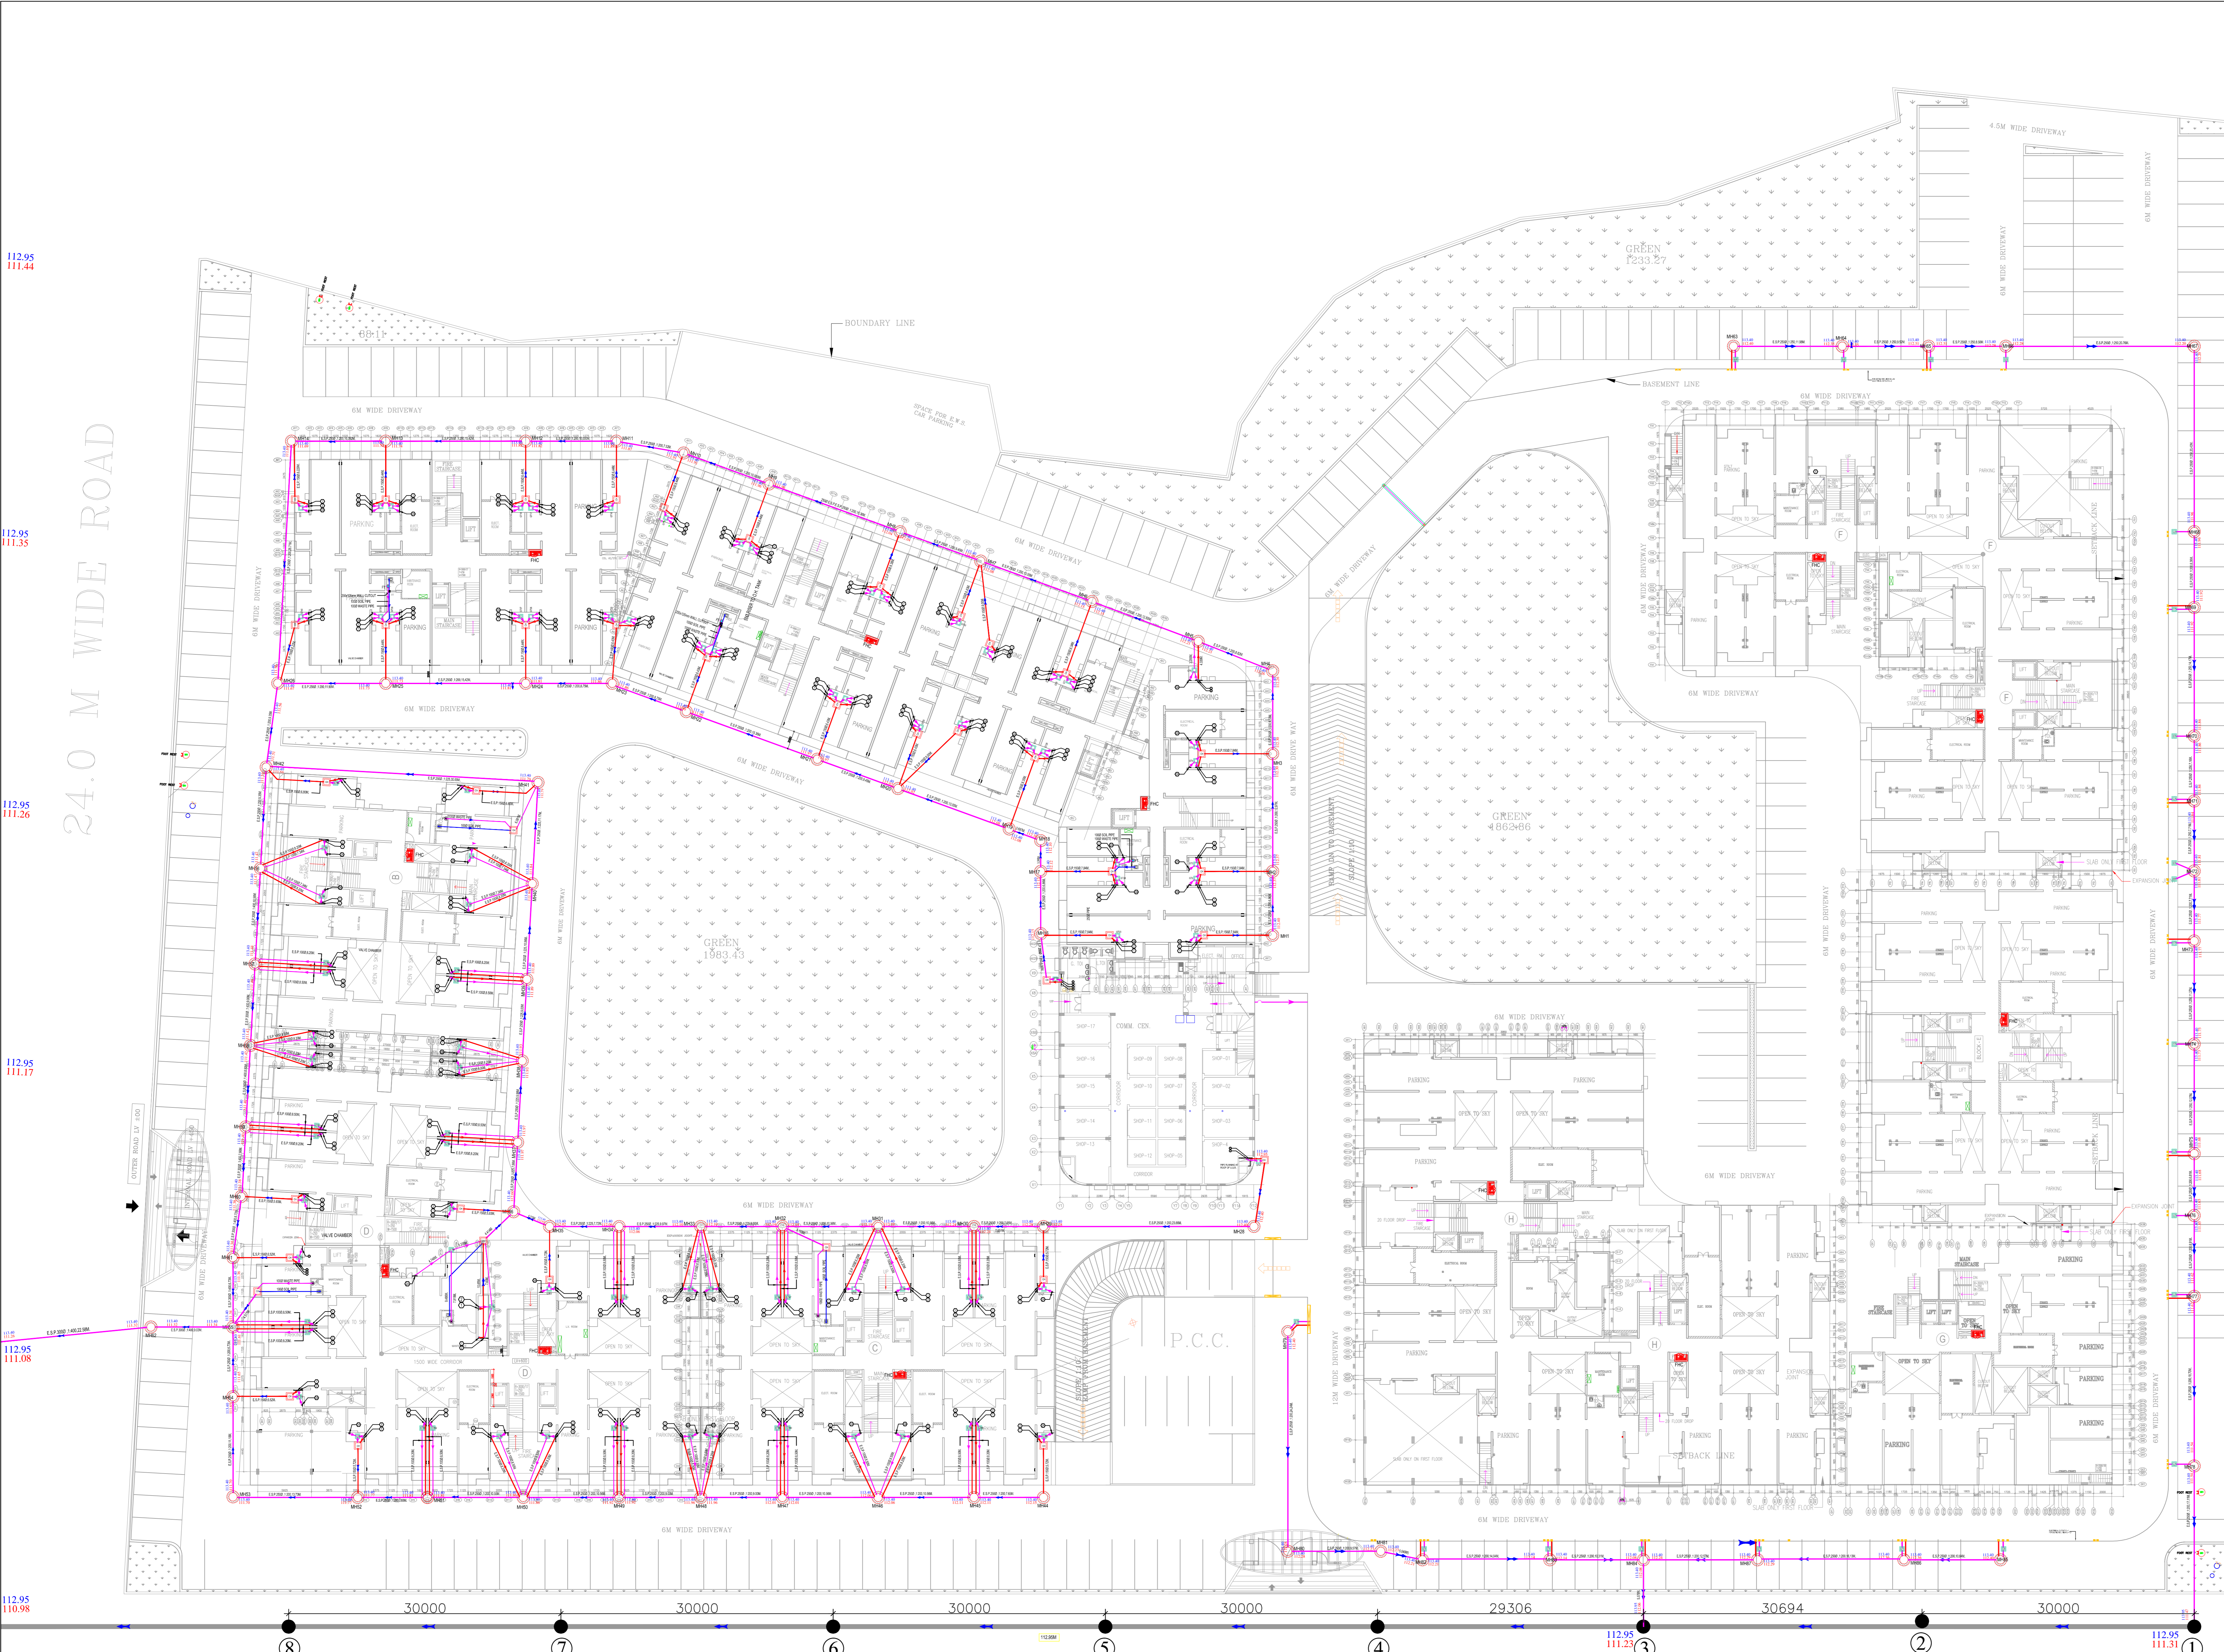

112.95
111.42

112.95
111.35

112.95
111.26

112.95
111.17

112.95
111.08

112.95
110.98

112.95
110.98

24.0 M WIDE ROAD

24.0 M WIDE ROAD

PLAY AREA

BENCH MARK
TOP OF CULVERT
99.117 R. (113.167)