
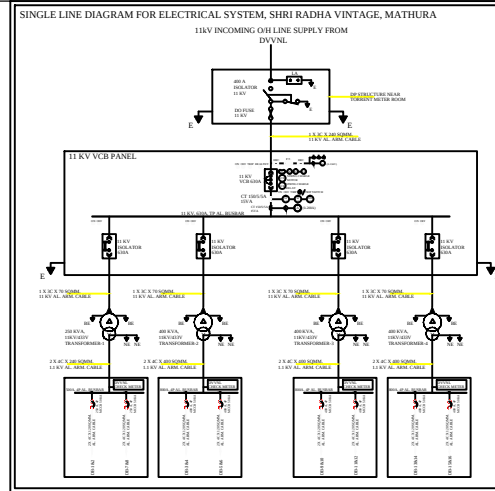


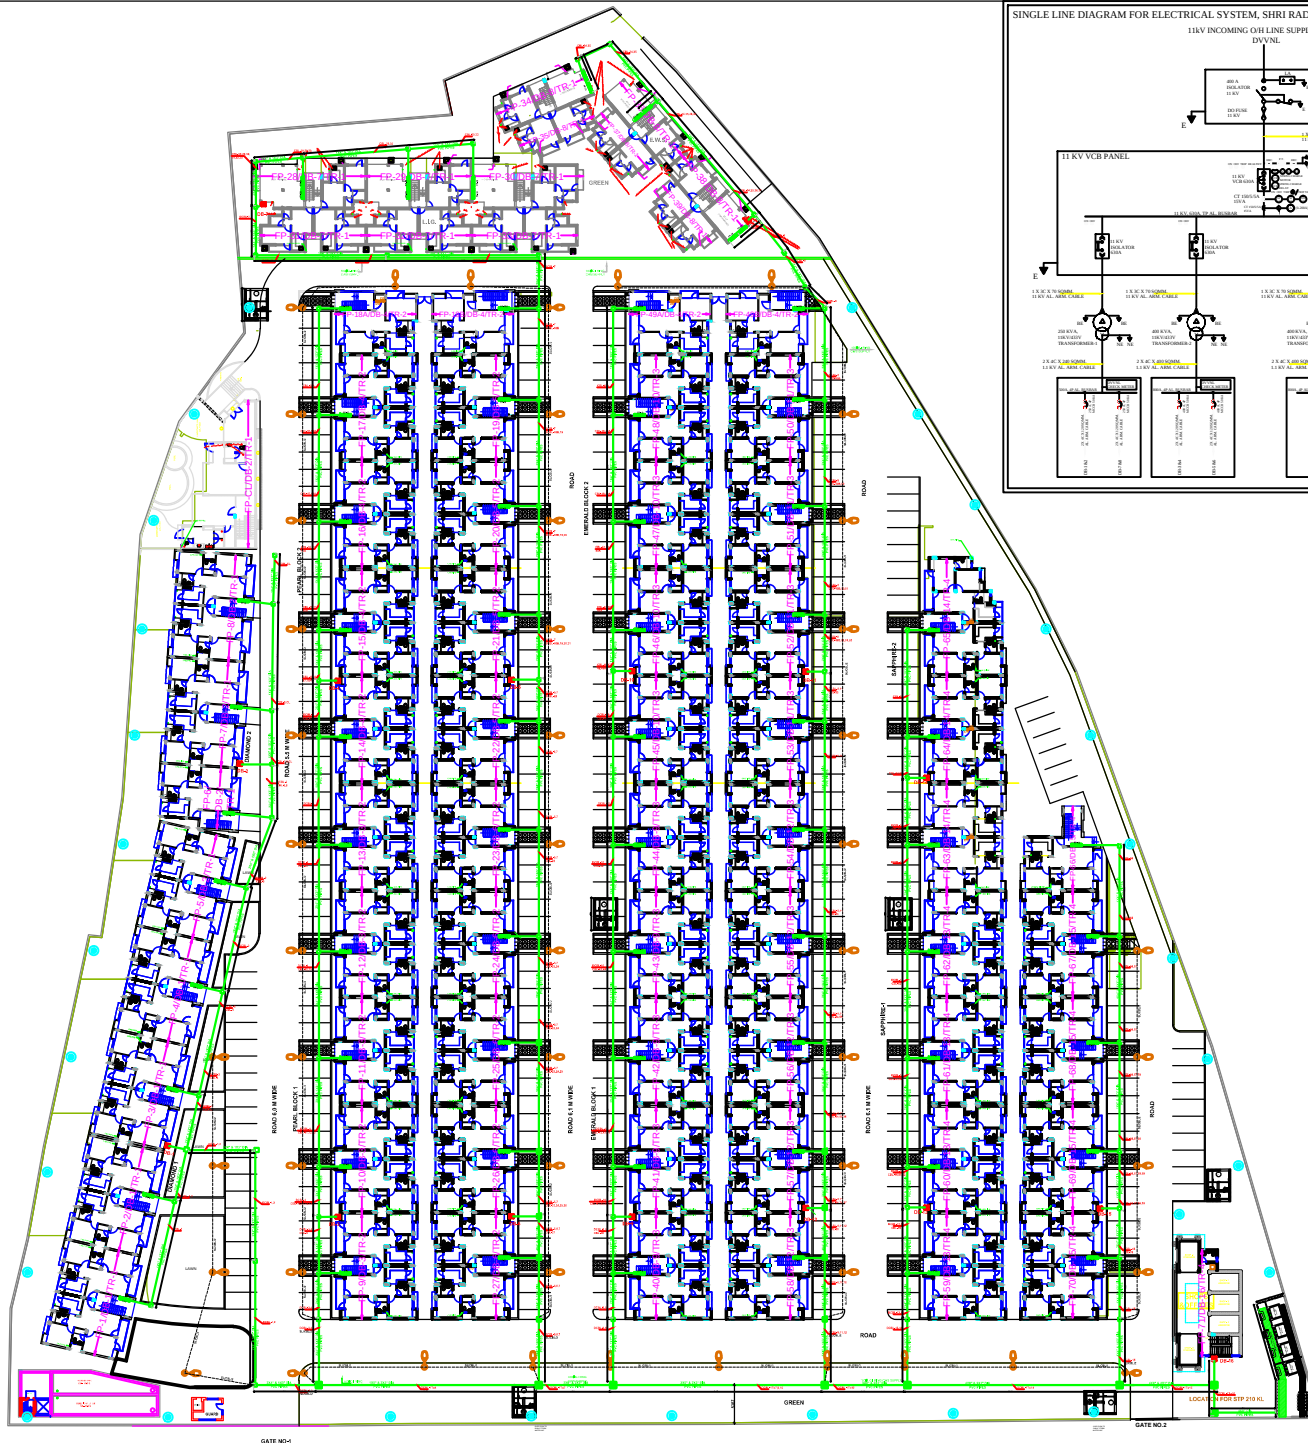

DB NO.	FEEDER PILLAR NO.
DB-1	FP-1 TO FP-4
DB-2	FP-5 TO FP-8 & CL
DB-3	FP-9 TO FP-13
DB-4	FP-14 TO FP-18A
DB-5	FP-18B TO FP-22
DB-6	FP-23 TO FP-27
DB-7	FP-28 TO FP-33
DB-8	FP-34 TO FP-39
DB-9	FP-40 TO FP-44
DB-10	FP-45 TO FP-49A
DB-11	FP-49B TO FP-53
DB-12	FP-54 TO FP-58
DB-13	FP-59 TO FP-62
DB-14	FP-63 TO FP-65
DB-15	FP-66 TO FP-70
DB-16	FP-71 & SERVICES

REVISION NO.	REVISION
1	
2	
3	
100	

REVISION NOTES

SHEET NO. 1

PROJECT: SHRI RADHA VINTAGE, MATHURA

DRAWING TITLE: ELECTRICAL SINGLE LINE DIAGRAM

DATE: 19.10.2025

REVISION: 1

DATE: 19.10.2025

REMARKS:

LEGENDS :-

	STREET LIGHT 40W
	AREA DISTRIBUTION BOARD
	FEEDER PILLAR
	PVC PIPES
	STREET LIGHT CABLE
	MANHOLE (900 X 900 MM)
	MANHOLE (600 X 600 MM)
	MANHOLE (450 X 450 MM)
	STREET LIGHT CABLE 3C X 16 SQMM AL. ARM.
	STREET LIGHT CABLE 3C X 10 SQMM AL. ARM.

SL/CBL/1	STREET LIGHT CABLE 3C X 16 SQMM AL. ARM.
SL/CBL/2	STREET LIGHT CABLE 3C X 10 SQMM AL. ARM.

CLIENT :	SHRI GROUP
PROJECT :	SHRI RADHA VINTAGE, OPP. SHRI RADHA CITY, GOVERDHAN ROAD, MATHURA
DRAWING TITLE :	EXTERNAL ELECTRICAL LAYOUT PLAN
DRAWING NO :	VA / SRV / EL-01
REVISIONS :	

C.E.M.G.
ENGINEERS & CONSULTANTS
PVT. LIMITED
1, Ellora Complex, Khandari Crossing
Surge Nagar, Agra
E-mail: enah13579@gmail.com

ELECTRICAL CONSULTANT:
ANIL K. GOYAL
B.TECH (ELECT.), MIE, FIE, MIPHEMICA
BEE CERTIFIED ENERGY AUDITOR
CHARTERED ENGINEER

VIRENDER ASSOCIATES
ARCHITECTURE PLANNING INTERIORS PVT
11, GREY PARK MAIN, NEW DELHI 110016
PH: 011-265651479624, E-MAIL: virender.associates@gmail.com