

[illegible]

LEGEND	DESCRIPTION	REF. IN PLAN AREA/Quantity
	BAMP ONE WAY SWITCH	+1200
	BAMP TWO WAY SWITCH	+1200
	12W LED CEILING LIGHT FOR TOILET AREA	CEILING
	25W ROUND TYPE LED CEILING LIGHT	CEILING
	10W MIRROR LED LIGHT	MIRROR
	1200 DIA. CEILING FAN	CEILING
	TELEPHONE OUTLET	45 PER SITE
	DATA/COMPUTER OUTLET	45 PER SITE
	TV OUTLET	45 PER SITE
	DISTRIBUTION BOARD	+1500

CONDUIT RECESSED IN SLAB

CEILING SLAB

CONDUIT RECESSED IN WALL

SWITCH BOX

FINISHED FLOOR LEVEL

SWITCH BOX FIXING DETAIL

DBT + POWER SUB DISTRIBUTION BOARD

SDB - NO.(ONE) PHASE (RED)

CIRCUIT NO. (ONE)

CIRCUIT PHASE DISTRIBUTION LEGEND

SLAB

JUNCTION BOX 450X200mm

CONDUITS RECESSED IN WALL AS REQUIRED

DB AS DETAIL

AS REQUIRED

1500

FINISHED FLOOR LEVEL

WALL

ASTERISK

TYPICAL DETAIL OF DB FIXING

MEP Consultant:-

M.S ASSOCIATES

MEP CONSULTANT/ENGINEERS

Plot: 24/16-17-18, Sector: 68, Phase: I, Gurgaon

24/16-17-18, Sector: 68, Phase: I, Gurgaon

Phone: 9999999999, 9999999999, 9999999999

9999999999, 9999999999, 9999999999

9999999999, 9999999999, 9999999999

DRAWING TITLE:-

SECOND FLOOR PLAN

ELECTRICAL DIMENSION LAYOUT PLAN

CUSTOMER:-

DATE	02/02/2024	STAMP:
DRN	ADSH	
CHKD	KARTHIK	
SCALE	AS SHOWN	
ISSUED BY	RAHMANULFAR	

DRAWING NO :- 4/3

SHEET NO :-

PROJECT :- TRANSPORT NAGAR, SHOPPING COMPLEX, BDA

STUDIO

EUPHORANT LLP


SITE PLAN

Lighting Legend

	Plant Dim Uplight
	Wall Security Light
	Wall Uplight
	Pole Lights
	Low Height Planter
	Bollard Light


[illegible]

SITE PLAN

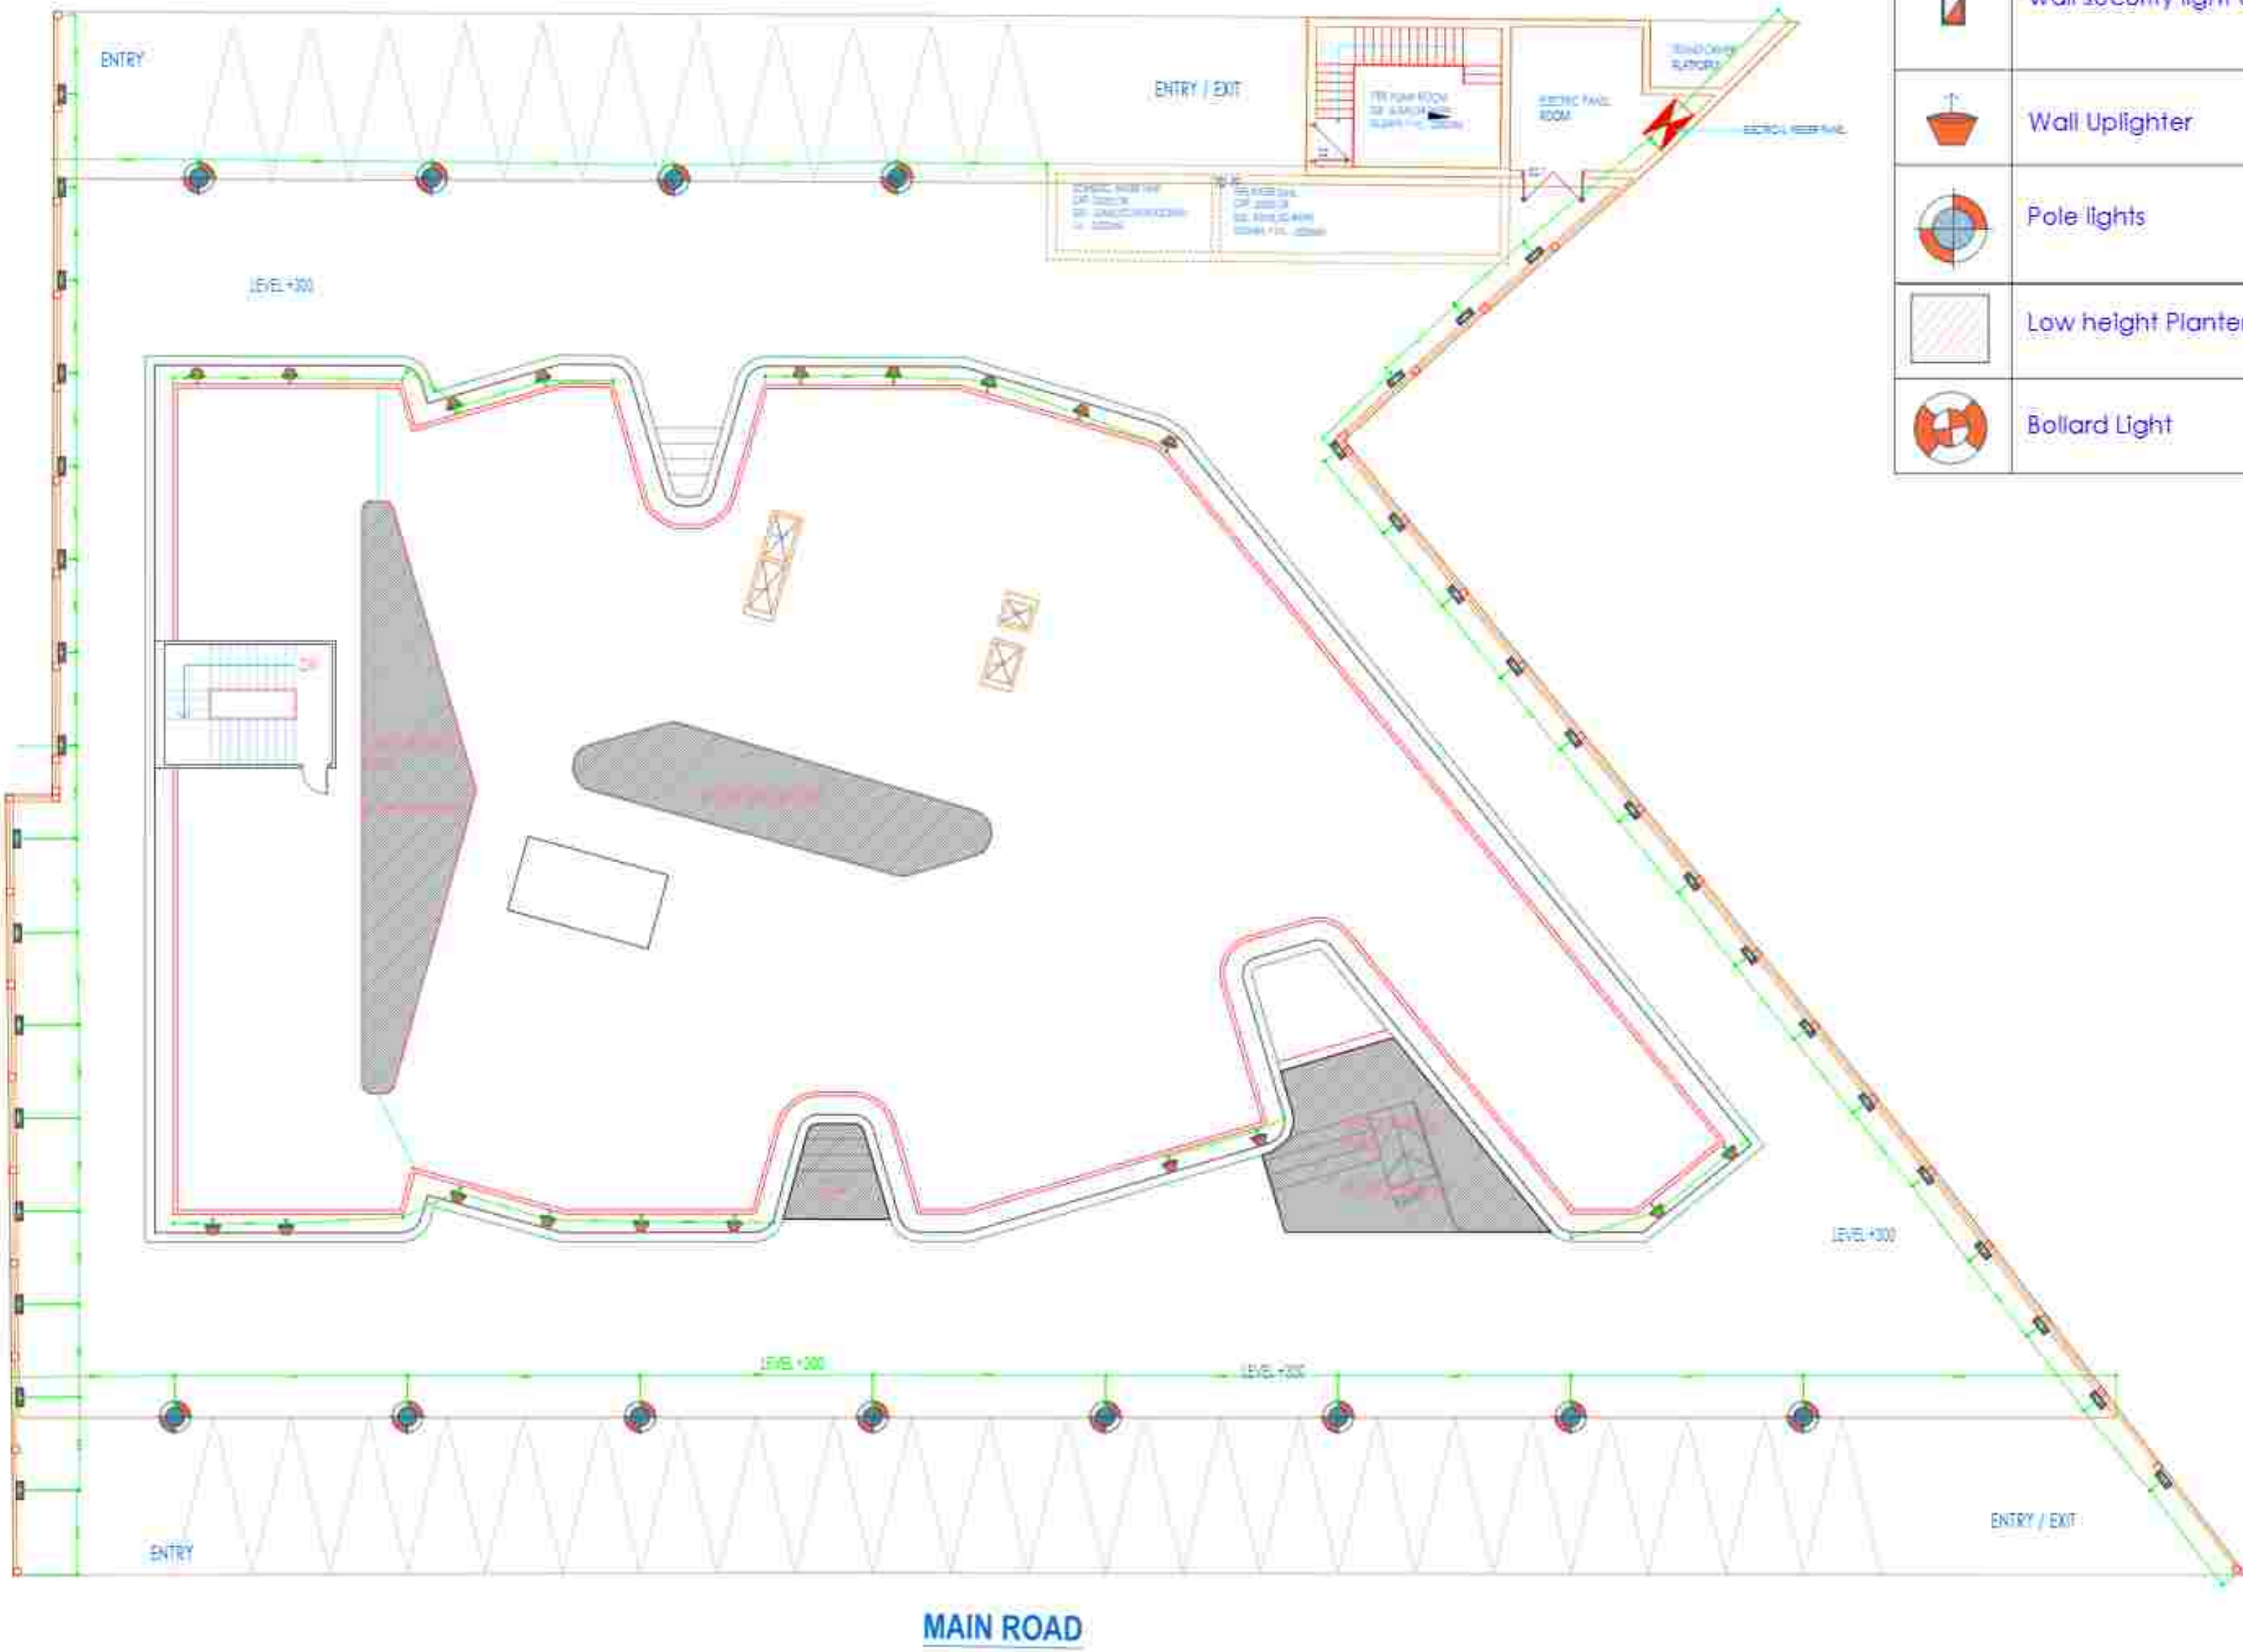

Lighting Legend

	Plant Dim Uplighter
	wall security light along b/wall
	Wall Uplighter
	Pole lights
	Low height Planter bed
	Bollard Light

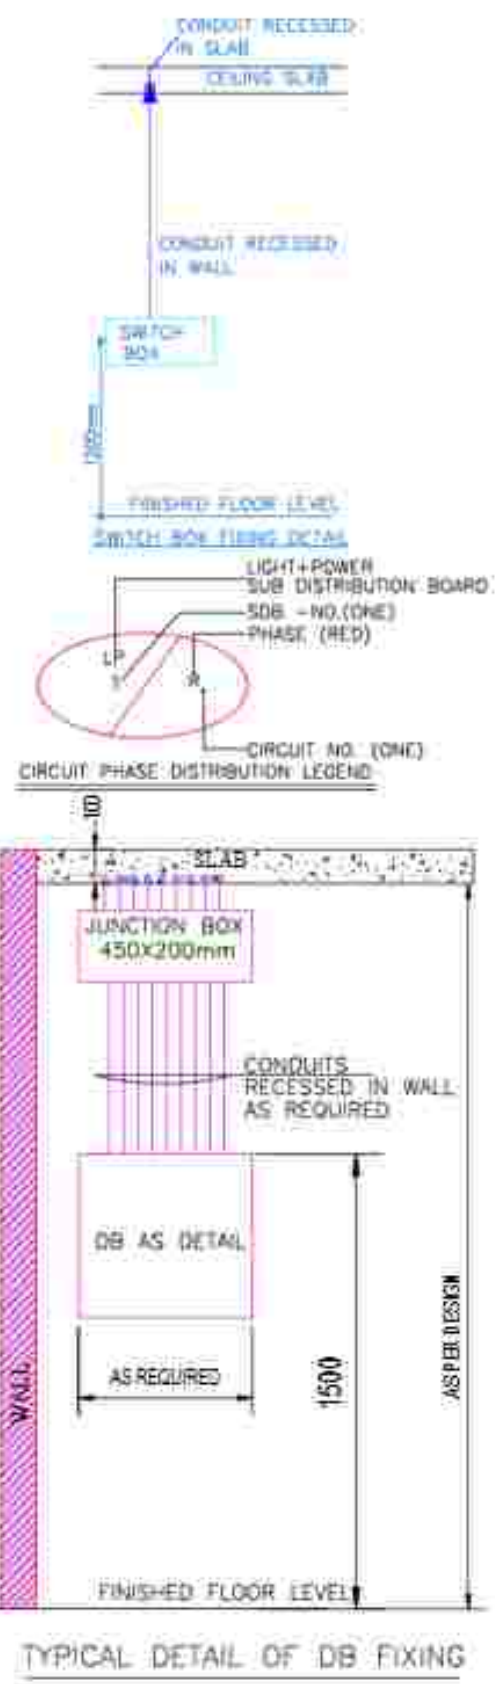

MEP Consultant:-
M.S ASSOCIATES
MEP CONSULTANT ENGINEERS
Plot No. 14/1, Transport Nagar Shopping Complex, BDA
Bhopal, Madhya Pradesh 462010
Phone: 0755-2555555, 0755-2555556
Email: msassociates@msassociates.com, msassociates@msassociates.com

DATE: 08/12/2024
DRN: MS/2024/001
CHKD: MS/2024/001
SCALE: 1/100
ISSUED BY: MS/2024/001
DRAWING NO: 01
SHEET NO: 01

PROJECT: TRANSPORT NAGAR, SHOPPING COMPLEX, BDA

STUDIO
EUPHORANT LLP

FIRST FLOOR PLAN



LEGEND	DESCRIPTION	AMP (in mm)
	RAMP ONE WAY SWITCH	+1200
	RAMP TWO WAY SWITCH	+1200
	12W LED CEILING LIGHT FOR TOILET AREA	CEILING
	25W ROUND TYPE LED CEILING LIGHT	CEILING
	10W ARROW TYPE LED CEILING LIGHT	WIDE AREA
	1200 DIA. CEILING FAN	CEILING
	TELEPHONE OUTLET	AS PER SITE
	DATA/COMPUTER OUTLET	AS PER SITE
	TV OUTLET	AS PER SITE
	DISTRIBUTION BOARD	+1500

CONDUIT RECESSED ON SLAB
CEILING SLAB

CONDUIT RECESSED IN WALL

SWITCH BOX

FINISHED FLOOR LEVEL

SWITCH BOX FIXING DETAIL

LIGHT+POWER SUB DISTRIBUTION BOARD
SDB - NO (ONE)
PHASE (RED)

CIRCUIT NO. (ONE)

CIRCUIT PHASE DISTRIBUTION LOGGING

SLAB

JUNCTION BOX 450x200mm

CONDUITS RECESSED IN WALL AS REQUIRED

DB AS DETAIL

AS REQUIRED

1500

FINISHED FLOOR LEVEL

WALL

ASTEP BEDIA

TYPICAL DETAIL OF DB FIXING

MEP Consultant:-
M.S ASSOCIATES
MEP CONSULTANT ENGINEERS
K-102, 2nd Floor, 12, Industrial Estate, New Delhi
Gurgaon, Haryana, India. Phone: +91 98100 12345
Email: msassociates@gmail.com, msassociates.com
Tel: 011-27123456, 011-27123457

DRAWING TITLE: FIRST FLOOR PLAN
ELECTRICAL LOOPING LAYOUT PLAN

CHECKED BY:

DATE: 08/10/2024 STAMP:

DRN: EUBM

CHKD: A.J.Y. SINGH

SCALE: EUPHORIANT LLP

ISSUED BY: EUPHORIANT LLP

DRAWING NO: 1512 SHEET NO: 1

PROJECT: TRANSPORT NAGAR, SHOPPING COMPLEX, BDA

S T U D I O

EUPHORIANT LLP

FIRST FLOOR PLAN



LEGEND	DESCRIPTION	REF. IN WALL
SW	SWAMP ONE WAY SWITCH	+1200
SW	SWAMP TWO WAY SWITCH	+1200
TL	12W LED CEILING LIGHT FOR TOILET AREA	+1200
TL	12W ROUND TYPE LED CEILING LIGHT	CEILING
TL	10W MINOR LED LIGHT	CEILING
TL	1200 DIA. CEILING FAN	CEILING
TL	TELEPHONE OUTLET	AS PER SITE
TL	DATA/COMPUTER OUTLET	AS PER SITE
TL	TV OUTLET	AS PER SITE
TL	DISTRIBUTION BOARD	+1500

CONDUIT RECESSED IN SLAB
CONDUIT RECESSED IN WALL
SWITCH BOX
FINISHED FLOOR LEVEL
SWITCH BOX STANDING DETAIL
LIGHT+POWER SUB DISTRIBUTION BOARD
DB - (NO. LINES)
PHASE (RED)
CIRCUIT NO. (ONE)
CIRCUIT PHASE DISTRIBUTION LEGEND

SLAB
JUNCTION BOX 450x200mm
CONDUITS RECESSED IN WALL AS REQUIRED
DB AS DETAIL
AS REQUIRED
1500
FINISHED FLOOR LEVEL
TYPICAL DETAIL OF DB FIXING

MEP Consultant:-
M.S ASSOCIATES
ELECTRICAL ENGINEERS
B-10, Sector-10, Transport Nagar, Gurgaon, Haryana
Ph: 9999999999, 9999999999, 9999999999
Email: msassociates@gmail.com, msassociates@yahoo.co.in

DRAWING TITLE: FIRST FLOOR PLAN
SUBJECT: ELECTRICAL DIMENSION LAYOUT PLAN


DATE	08.10.2023	STAMP
DRN	MSA/DRN	
CHKD	MSA/CHKD	
SCALE	AS SHOWN	
ISSUED BY	MSA/ISSUED BY	
DRAWING NO. :-	ELD	SHEET NO. :-
PROJECT:- TRANSPORT NAGAR, SHOPPING COMPLEX, BDA		
STUDIO EUPHORIANT LLP		

GROUND FLOOR PLAN



MAIN ROAD

LEGEND	DESCRIPTION	AMP
○	SWAMP ONE WAY SWITCH	+1200
○	SWAMP TWO WAY SWITCH	+1200
○	12W LED CEILING LIGHT FOR TOILET AREA	+1200
○	25W ROUND TYPE LED CEILING LIGHT	CEILING
○	70W MINOR LED LIGHT	CEILING
○	1200 DIA. CEILING FAN	CEILING
○	TELEPHONE OUTLET	AS PER SITE
○	DATA/COMPUTER OUTLET	AS PER SITE
○	TV OUTLET	AS PER SITE
○	DISTRIBUTION BOARD	+1500

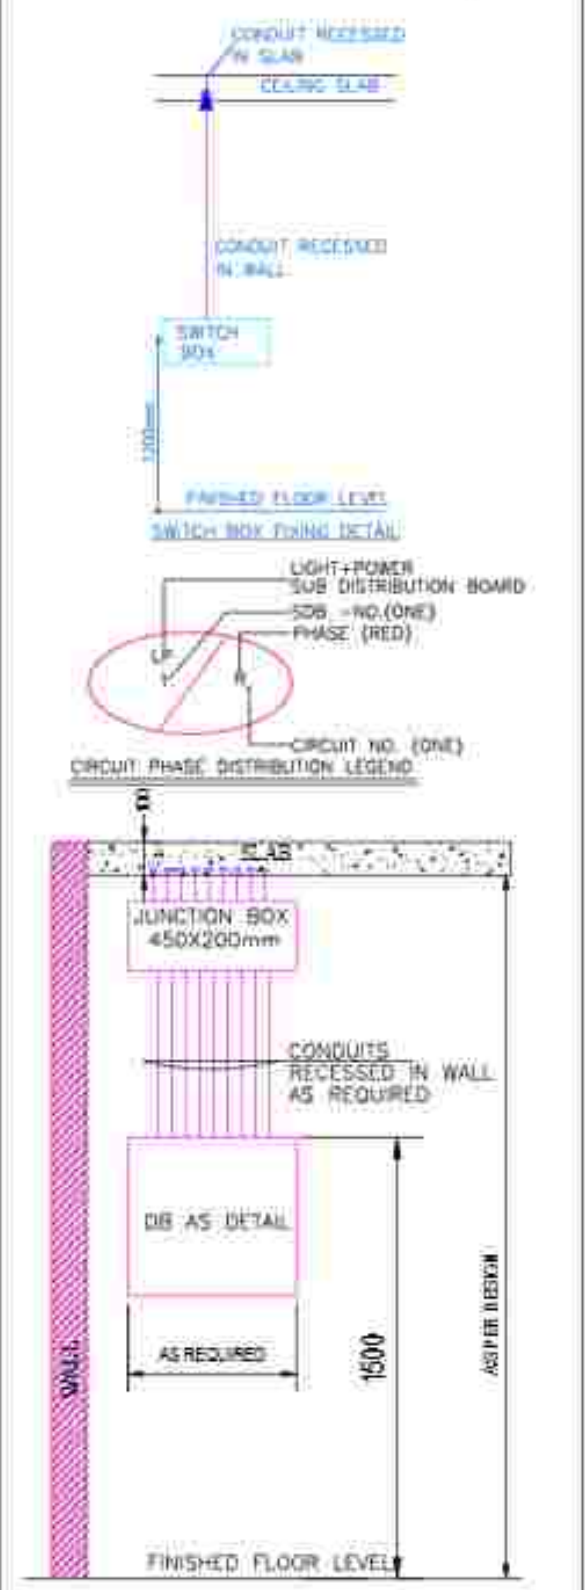

MEP Consultant:-
M.S. ASSOCIATES
MEP CONSULTANT ENGINEERS
B-102, 2nd Floor, 1st Cross, 1st Stage, 1st Main Road, Transport Nagar, Bangalore-560075
Phone: 9845678901, 9845678902, 9845678903, 9845678904, 9845678905, 9845678906, 9845678907, 9845678908, 9845678909, 9845678910

DRAWING NO:- **GROUND FLOOR PLAN**
ELECTRICAL LOOPING LAYOUT PLAN


DATE: 18/12/2024 STAMP: [Stamp]

DRN: [Signature] CHD: [Signature] SCALE: 1:100 ISSUED BY: EUPHORANT LLP DRAWING NO: 501 SHEET NO: 1

PROJECT: TRANSPORT NAGAR, SHOPPING COMPLEX, BDA

S.T.O.D.I.O.
EUPHORANT LLP

LEGEND	DESCRIPTION	EST. NO. and MFA Number
		=1200
	4-WAY ONE-WAY SWITCH	=1200
	4-WAY TWO-WAY SWITCH	=1200
	12W LED CEILING LIGHT FOR TOILET AREA	CEILING
	25W ROUND TUBE LED CEILING LIGHT	CEILING
	10W MIRROR LED LIGHT	CEILING
	1500 DIA. CEILING FAN	CEILING
	TELEPHONE OUTLET	42 PER SITE
	DATA/COMPUTER OUTLET	40 PER SITE
	TV OUTLET	40 PER SITE
	DISTRIBUTION BOARD	=1300

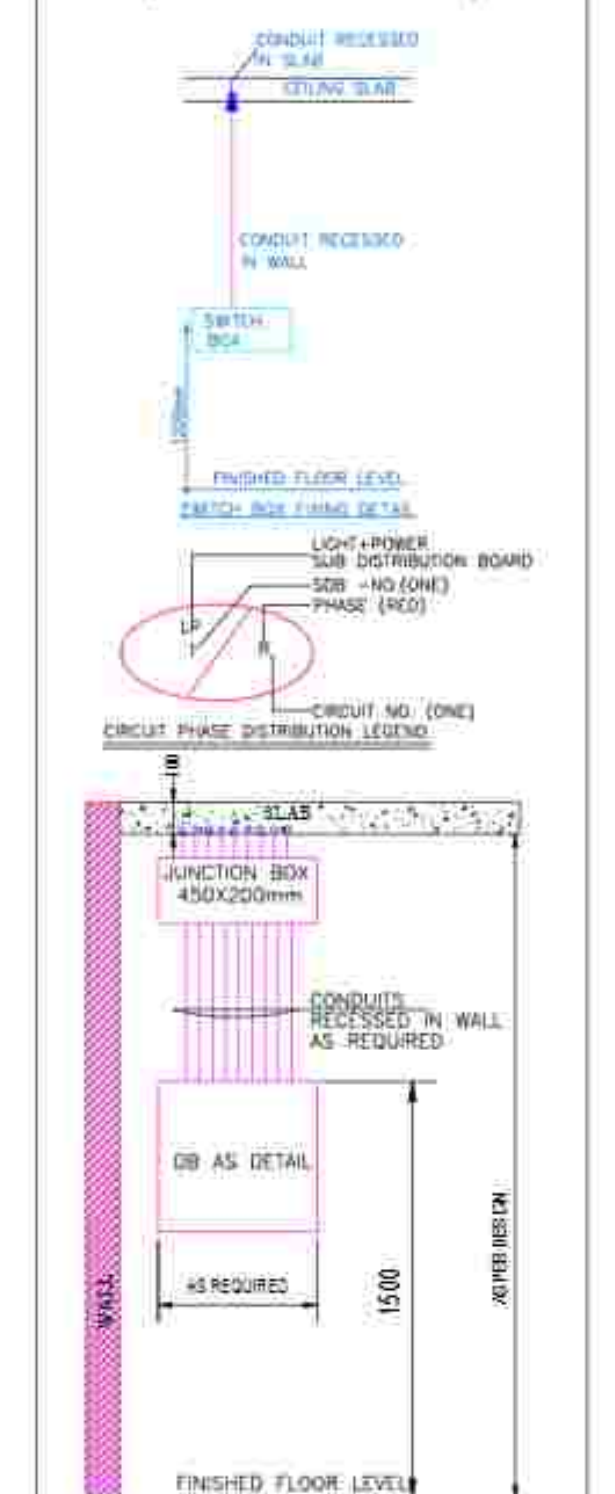

TYPICAL DETAIL OF DB FIXING

MEP Consultant:-

M.S. ASSOCIATES

MS ASSOCIATES
 365 CONSULTANT & ENGINEERS
 3-4000 Glenview Rd., Glenview, Illinois 60025
 (708) 941-1000
 3-4000 Glenview Rd., Glenview, Illinois 60025
 (708) 941-1000
 3-4000 Glenview Rd., Glenview, Illinois 60025
 (708) 941-1000

DRAWING TITLE: GROUND FLOOR PLAN
ELECTRICAL DIMENSION LAYOUT PLAN

DATE	12-10-2011	STAMP
DRN	123456	
CHKD	123456789	
SCALE		
ISSUED BY	123456789	


DRAWING NO. - E-1	SHEET NO. -
PROJECT -	TRANSPORT NAGAR, SHOPPING COMPLEX, BDA

21000

EUPHORANT LLP

[illegible][illegible]

SECOND FLOOR PLAN

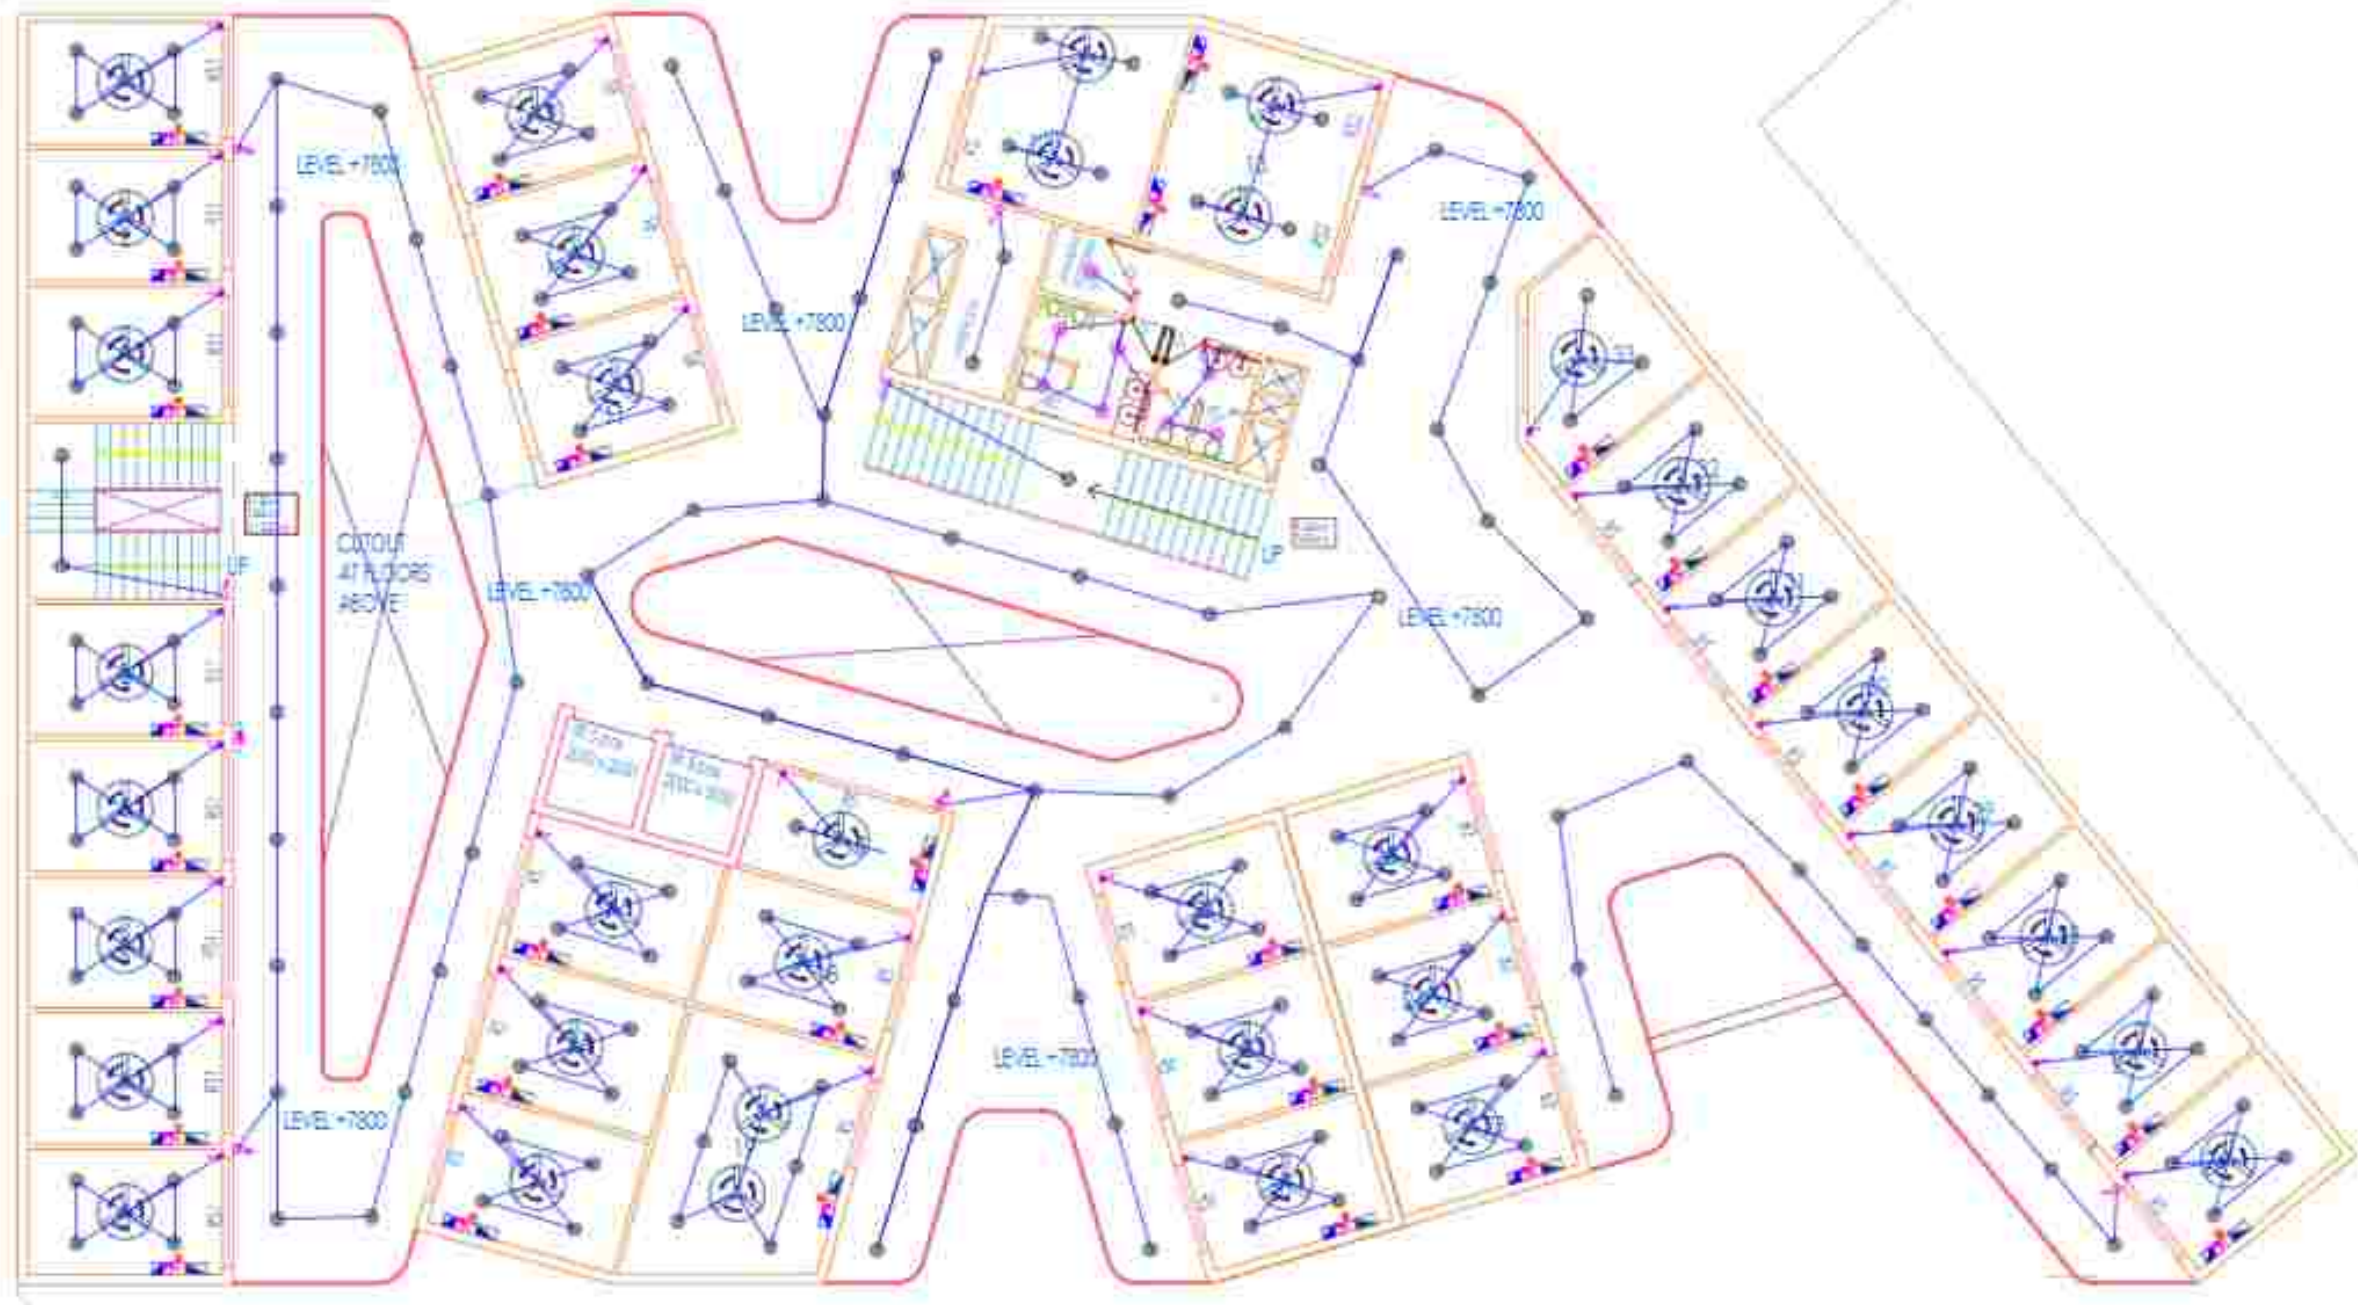

LEGEND	DESCRIPTION	REF. IN WALL LAYOUT
6AMP ONE WAY SWITCH		+1200
6AMP TWO WAY SWITCH		+1200
12W LED CEILING LIGHT FOR TOILET AREA		+1200
25W ROUND TYPE LED CEILING LIGHT		CEILING
10W MIRROR LED LIGHT		MIRROR
1200 DIA. CEILING FAN		CEILING
TELEPHONE OUTLET		45 PER SITE
DATA/COMPUTER OUTLET		45 PER SITE
TV OUTLET		45 PER SITE
DISTRIBUTION BOARD		+1500

CONDUIT RECESSED IN SLAB
CEILING SLAB

CONDUIT RECESSED IN WALL

SWITCH BOX

FINISHED FLOOR LEVEL

SWITCH BOX FIXING DETAIL

LIGHT+POWER SUB DISTRIBUTION BOARD
SDB - NO.(ONE)
PHASE (RED)

CIRCUIT NO. (ONE)

CIRCUIT PHASE DISTRIBUTION LEGEND

SLAB

JUNCTION BOX 450X200mm

CONDUITS RECESSED IN WALL AS REQUIRED

DB AS DETAIL

AS REQUIRED

1500

FINISHED FLOOR LEVEL

WALL

ASTER BECH

TYPICAL DETAIL OF DB FIXING

MEP Consultant:-
M.S ASSOCIATES
MEP CONSULTANT ENGINEERS
PLOT NO. 10, 11, 12, 999, 1000

SECOND FLOOR PLAN



LEGEND	DESCRIPTION	REF (in mm)
SW	SWAMP ONE WAY SWITCH	+1200
SW	SWAMP TWO WAY SWITCH	+1200
SW	12W LED CEILING LIGHT FOR 100FT ² AREA	CEILING
SW	25W ROUND TYPE LED CEILING LIGHT	CEILING
SW	10W MIRROR LED LIGHT	SWAMP
SW	1200 DIA. CEILING FAN	CEILING
SW	TELEPHONE OUTLET	AS PER SITE
SW	DATA/COMPUTER OUTLET	AS PER SITE
SW	TV OUTLET	AS PER SITE
SW	DISTRIBUTION BOARD	+1500

CONDUIT RECESSED IN SLAB
CEILING SCAB

CONDUIT RECESSED IN WALL

SWITCH BOX

FINISHED FLOOR LEVEL

SWITCH BOX FIXING DETAIL

LIGHT+POWER
SUB DISTRIBUTION BOARD
SWB - NO (ONE)
PHASE (RED)

CIRCUIT NO. (ONE)

CIRCUIT PHASE DISTRIBUTION LEGEND

SLAB

JUNCTION BOX 450X200mm

CONDUITS RECESSED IN WALL

DB AS DETAIL

AS REQUIRED

1500

FINISHED FLOOR LEVEL

TYPICAL DETAIL OF DB FIXING

MEP Consultant:-
M.S ASSOCIATES
MEP CONSULTANT ENGINEERS
Plot No. 10, 11, 12, 2126, 2127

The image is a detailed architectural floor plan of a building. The plan is irregular in shape, with several rooms and corridors. Key features include:

- Rooms and Spaces:** There are several rooms of varying sizes, some with internal partitions. A large, dark grey area in the center-left is labeled "LEVEL +1.250". A smaller, dark grey area in the bottom-right is labeled "LEVEL +1.220".
- Corridors and Stairs:** A network of corridors connects the rooms. A staircase is located in the bottom-right corner, labeled "STAIRS".
- Structural Elements:** The plan shows walls, doors, and structural columns. Some areas are labeled "BUILDING LINE" and "ELEVATION".
- Level Markings:** The plan is divided into sections by level markings: "LEVEL +1.250" and "LEVEL +1.220".
- Other Labels:** There are various other labels, including "ELEVATION", "BUILDING LINE", "STAIRS", and "LEVEL +1.250".

The plan is drawn with black lines on a white background, with some areas shaded in grey. The overall layout is complex, with many rooms and corridors, suggesting a large building or a multi-story structure.


M.S ASSOCIATES
MER CONSULTANTS:-
M.S ASSOCIATES
MER CONSULTANT ENGINEERS
100, Galle Rd., Colombo 10, Sri Lanka
Tel: 011-25511111, 25511112, 25511113, 25511114, 25511513, 25511514

1000


DRAWING NO :- E-1	SHEET NO :-
PROJECT :- TRANSPORT NAGAR, SHOPPING COMPLEX, BDA	

STUDIO
EUPHORANT LLP

TERRACE FLOOR PLAN

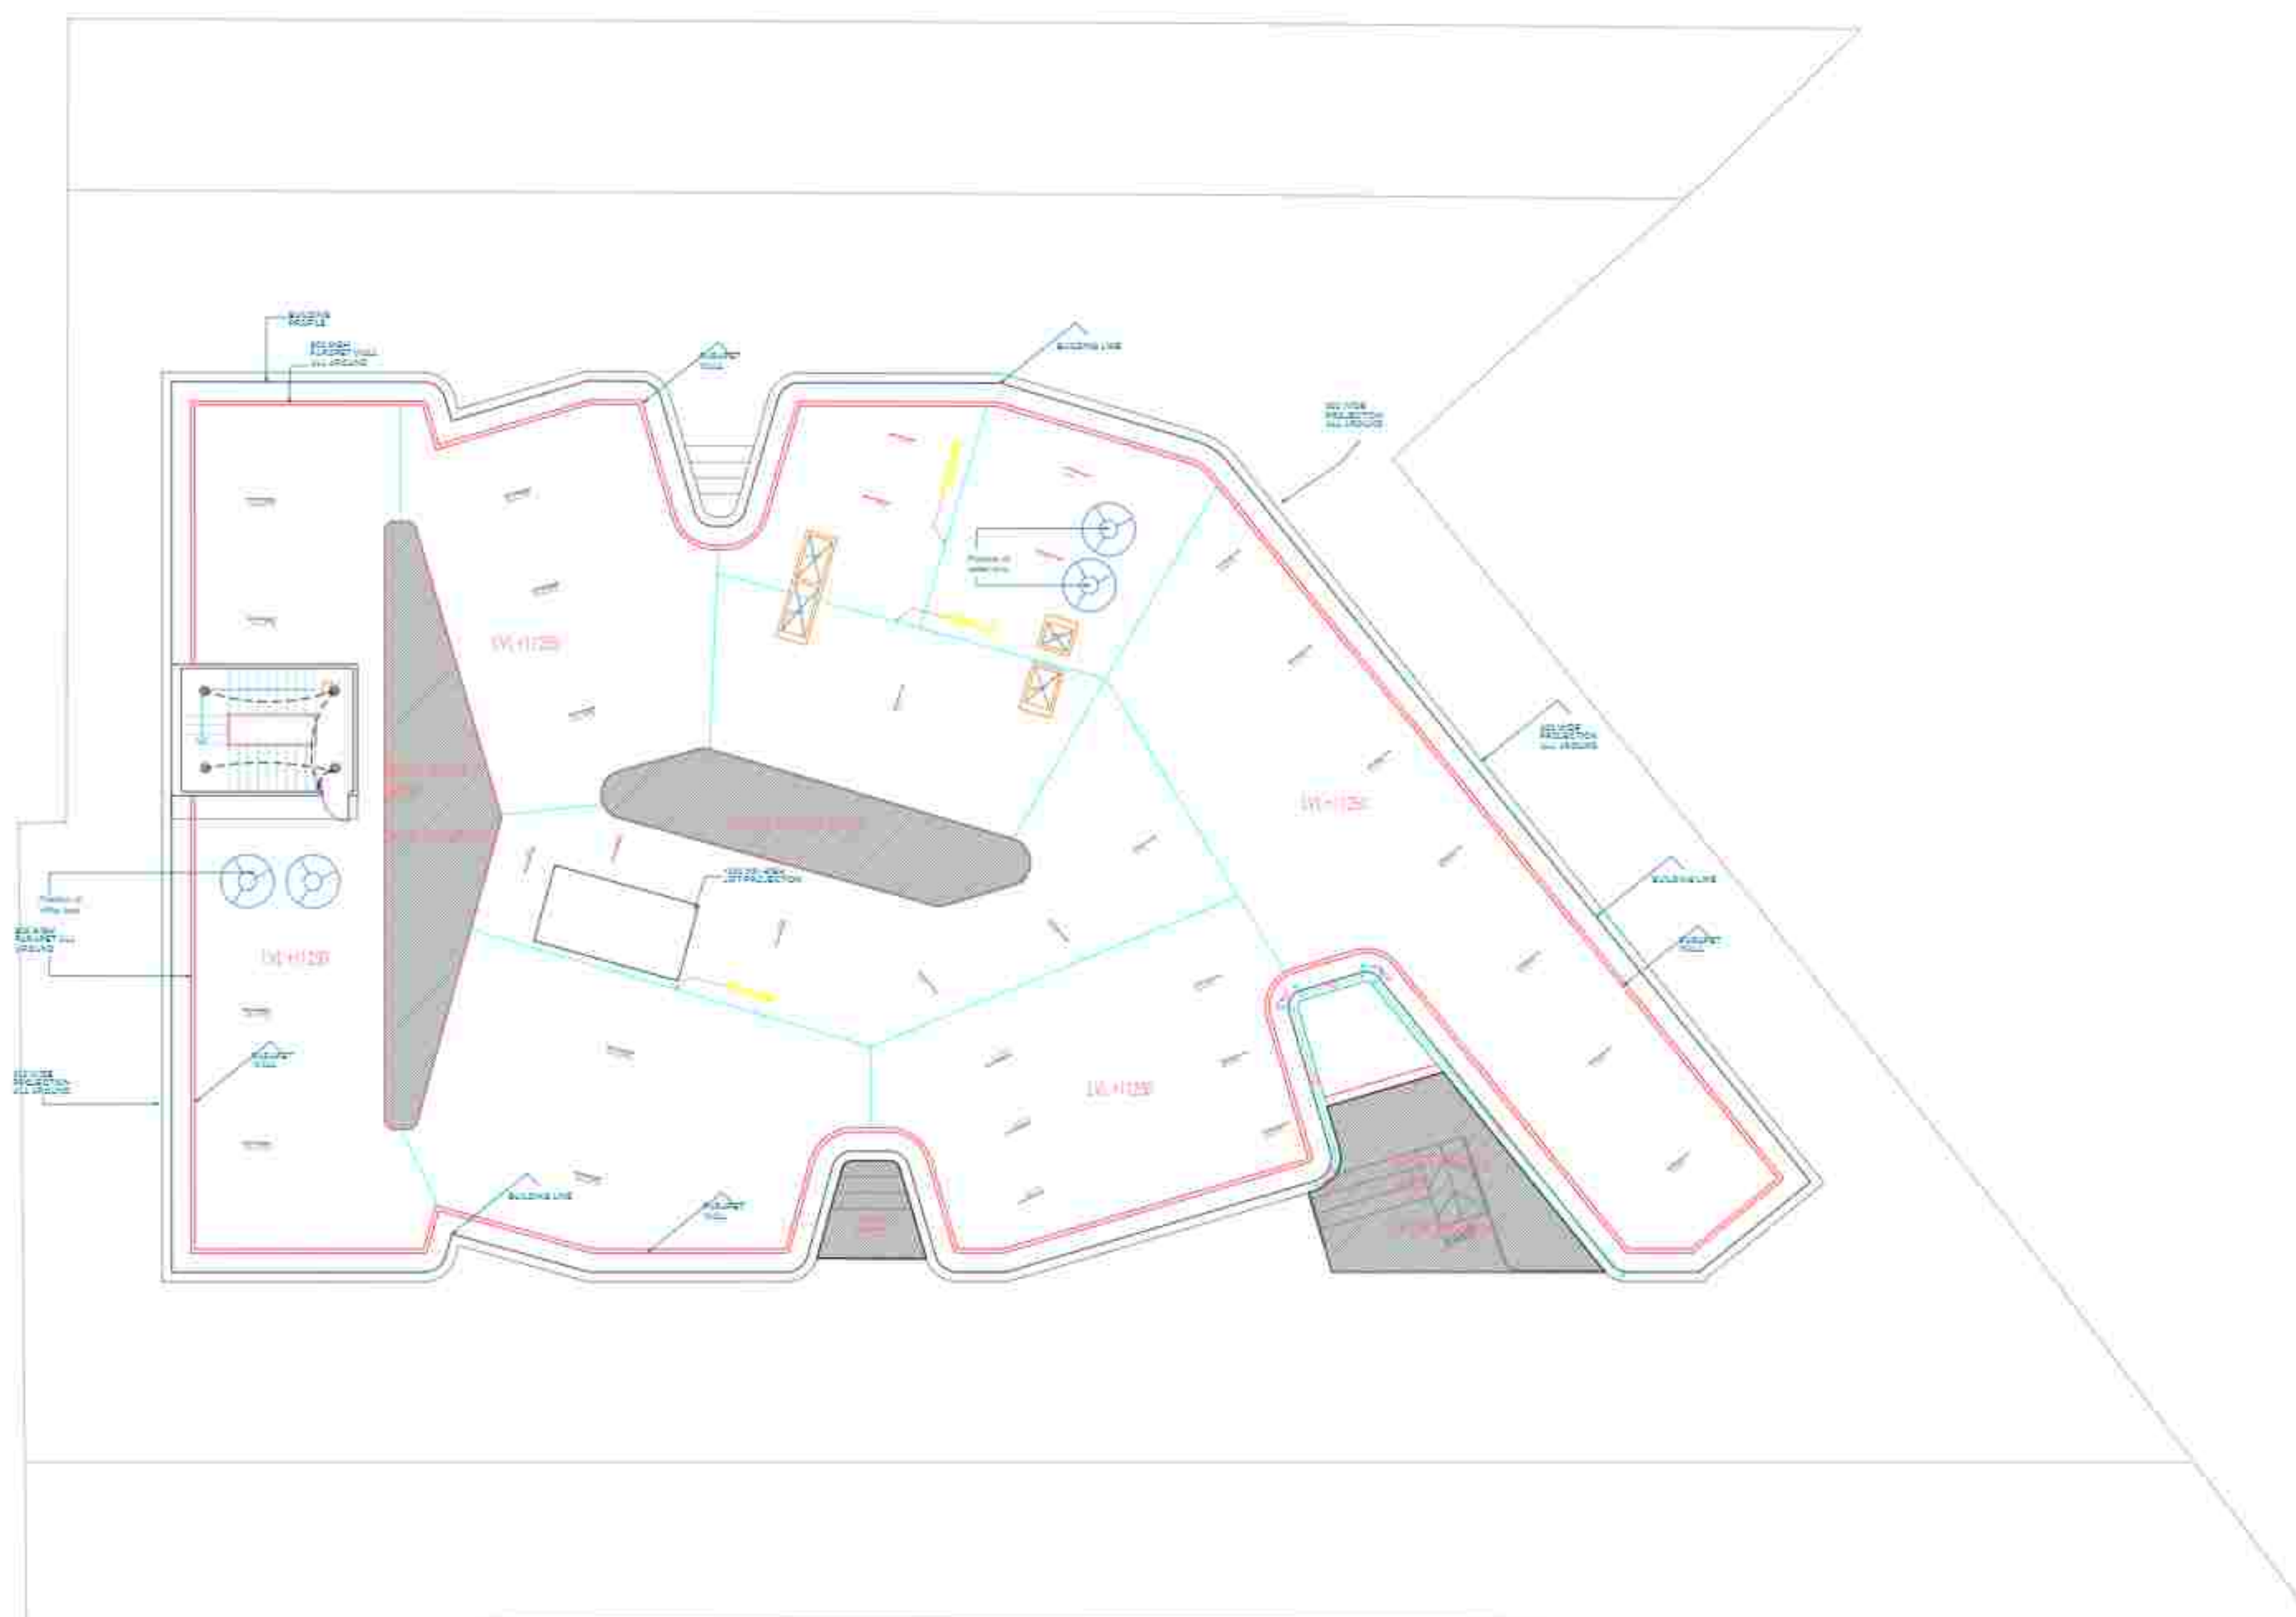

LEGEND	DESCRIPTION	REF. NO. & EST./LOCATION
	1WAMP ONE WAY SWITCH	+1200
	2WAMP TWO WAY SWITCH	+1200
	12W LED CEILING LIGHT FOR TOILET AREA	CEILING
	25W ROUND TYPE LED CEILING LIGHT	CEILING
	12W MIRROR LED LIGHT	MIRROR
	1200 DIA. CEILING FAN	CEILING
	TELEPHONE OUTLET	43 PER SITE
	DATA/COMPUTER OUTLET	43 PER SITE
	TV OUTLET	43 PER SITE
	DISTRIBUTION BOARD	+1500

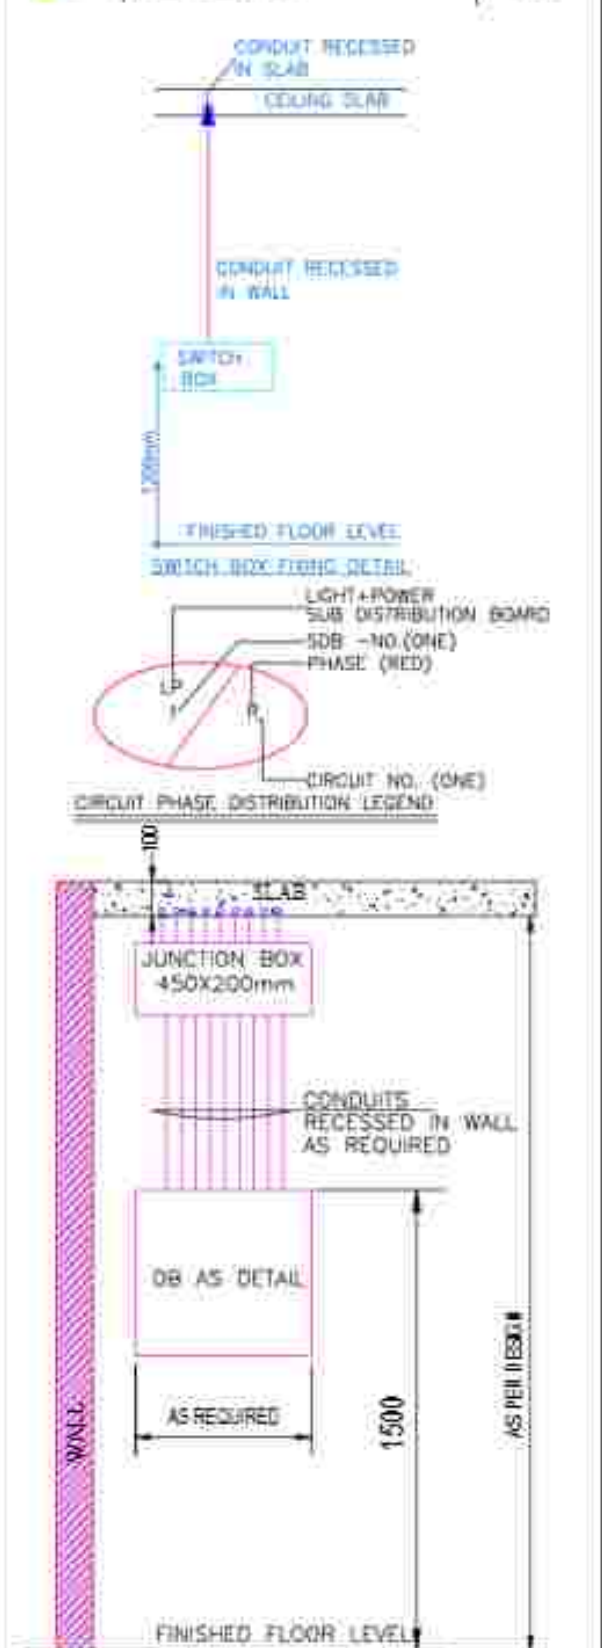

TYPICAL DETAIL OF DB FIXING

M.S ASSOCIATES
MER CONSULTANT ENGINEERS
8000 DeSoto Ave., Suite 200, Fort Worth, Texas 76120
Tel: 817-339-1100 Fax: 817-339-1101
E-Mail: msaassociates@yahoo.com msaassociates@earthlink.net
Web: www.msaassociates.com

DRAWING TITLE: TERRACE FLOOR PLAN
ELECTRICAL LIGHTING LAYOUT PLAN

DATE	08/11/2004	STAMP
DRN	4234	
CHRD	ALAT 1446	
SCALE		
ISSUED BY	ELKHORST 123	

DRAWING NO :- 2	SHEET NO :-
-----------------	-------------

PROJECT :- TRANSPORT NAGAR, SHOPPING
COMPLEX, BDA

S T U D I O

The diagram illustrates a two-stage experimental design. Stage 1 consists of a Pre-Test and a Post-Test. Stage 2 also consists of a Pre-Test and a Post-Test. Arrows show the progression from Stage 1 to Stage 2, and from the Pre-Test to the Post-Test within each stage.

EUPHORANT IIP

LEGEND	DESCRIPTION	HT (in mm) L/F/F/F/F/F/F/F/F
	SWAMP ONE WAY SWITCH	+1200
	SWAMP TWO WAY SWITCH	+1300
	12W LED CEILING LIGHT FOR TOILET AREA	+1500
	20W ROUND TYPE LED CEILING LIGHT	CEILING
	10W MIRROR LED LIGHT	300W VENTUR
	1200 DIA CEILING FAN	CEILING
	TELEPHONE OUTLET	AS PER SITE
	DATA/COMPUTER OUTLET	AS PER SITE
	TV OUTLET	AS PER SITE
	DISTRIBUTION BOARD	+1500

CONDUIT RECESSED IN SLAB

CONDUIT RECESSED IN WALL

SWITCH BOX

FINISHED FLOOR LEVEL

SWITCH BOX FIXING DETAIL

LIGHT+POWER SLAB DISTRIBUTION BOARD

SDB - NO (ONE) PHASE (RED)

CIRCUIT NO. (ONE)

CIRCUIT PHASE DISTRIBUTION LEGEND

SLAB

JUNCTION BOX 450X200MM

CONDUITS RECESSED IN WALL AS REQUIRED

DB AS DETAIL

AS REQUIRED

1500

FINISHED FLOOR LEVEL

TYPICAL DETAIL OF DB FIXING


MEP Consultant:-

M.S ASSOCIATES

MEP CONSULTANT ENGINEERS

3-35, Gaur Ganga, 1st Floor, Sector 10, Gurgaon, Haryana

Phone: +91-122-4000000, +91-122-4000001, +91-122-4000002, +91-122-4000202, +

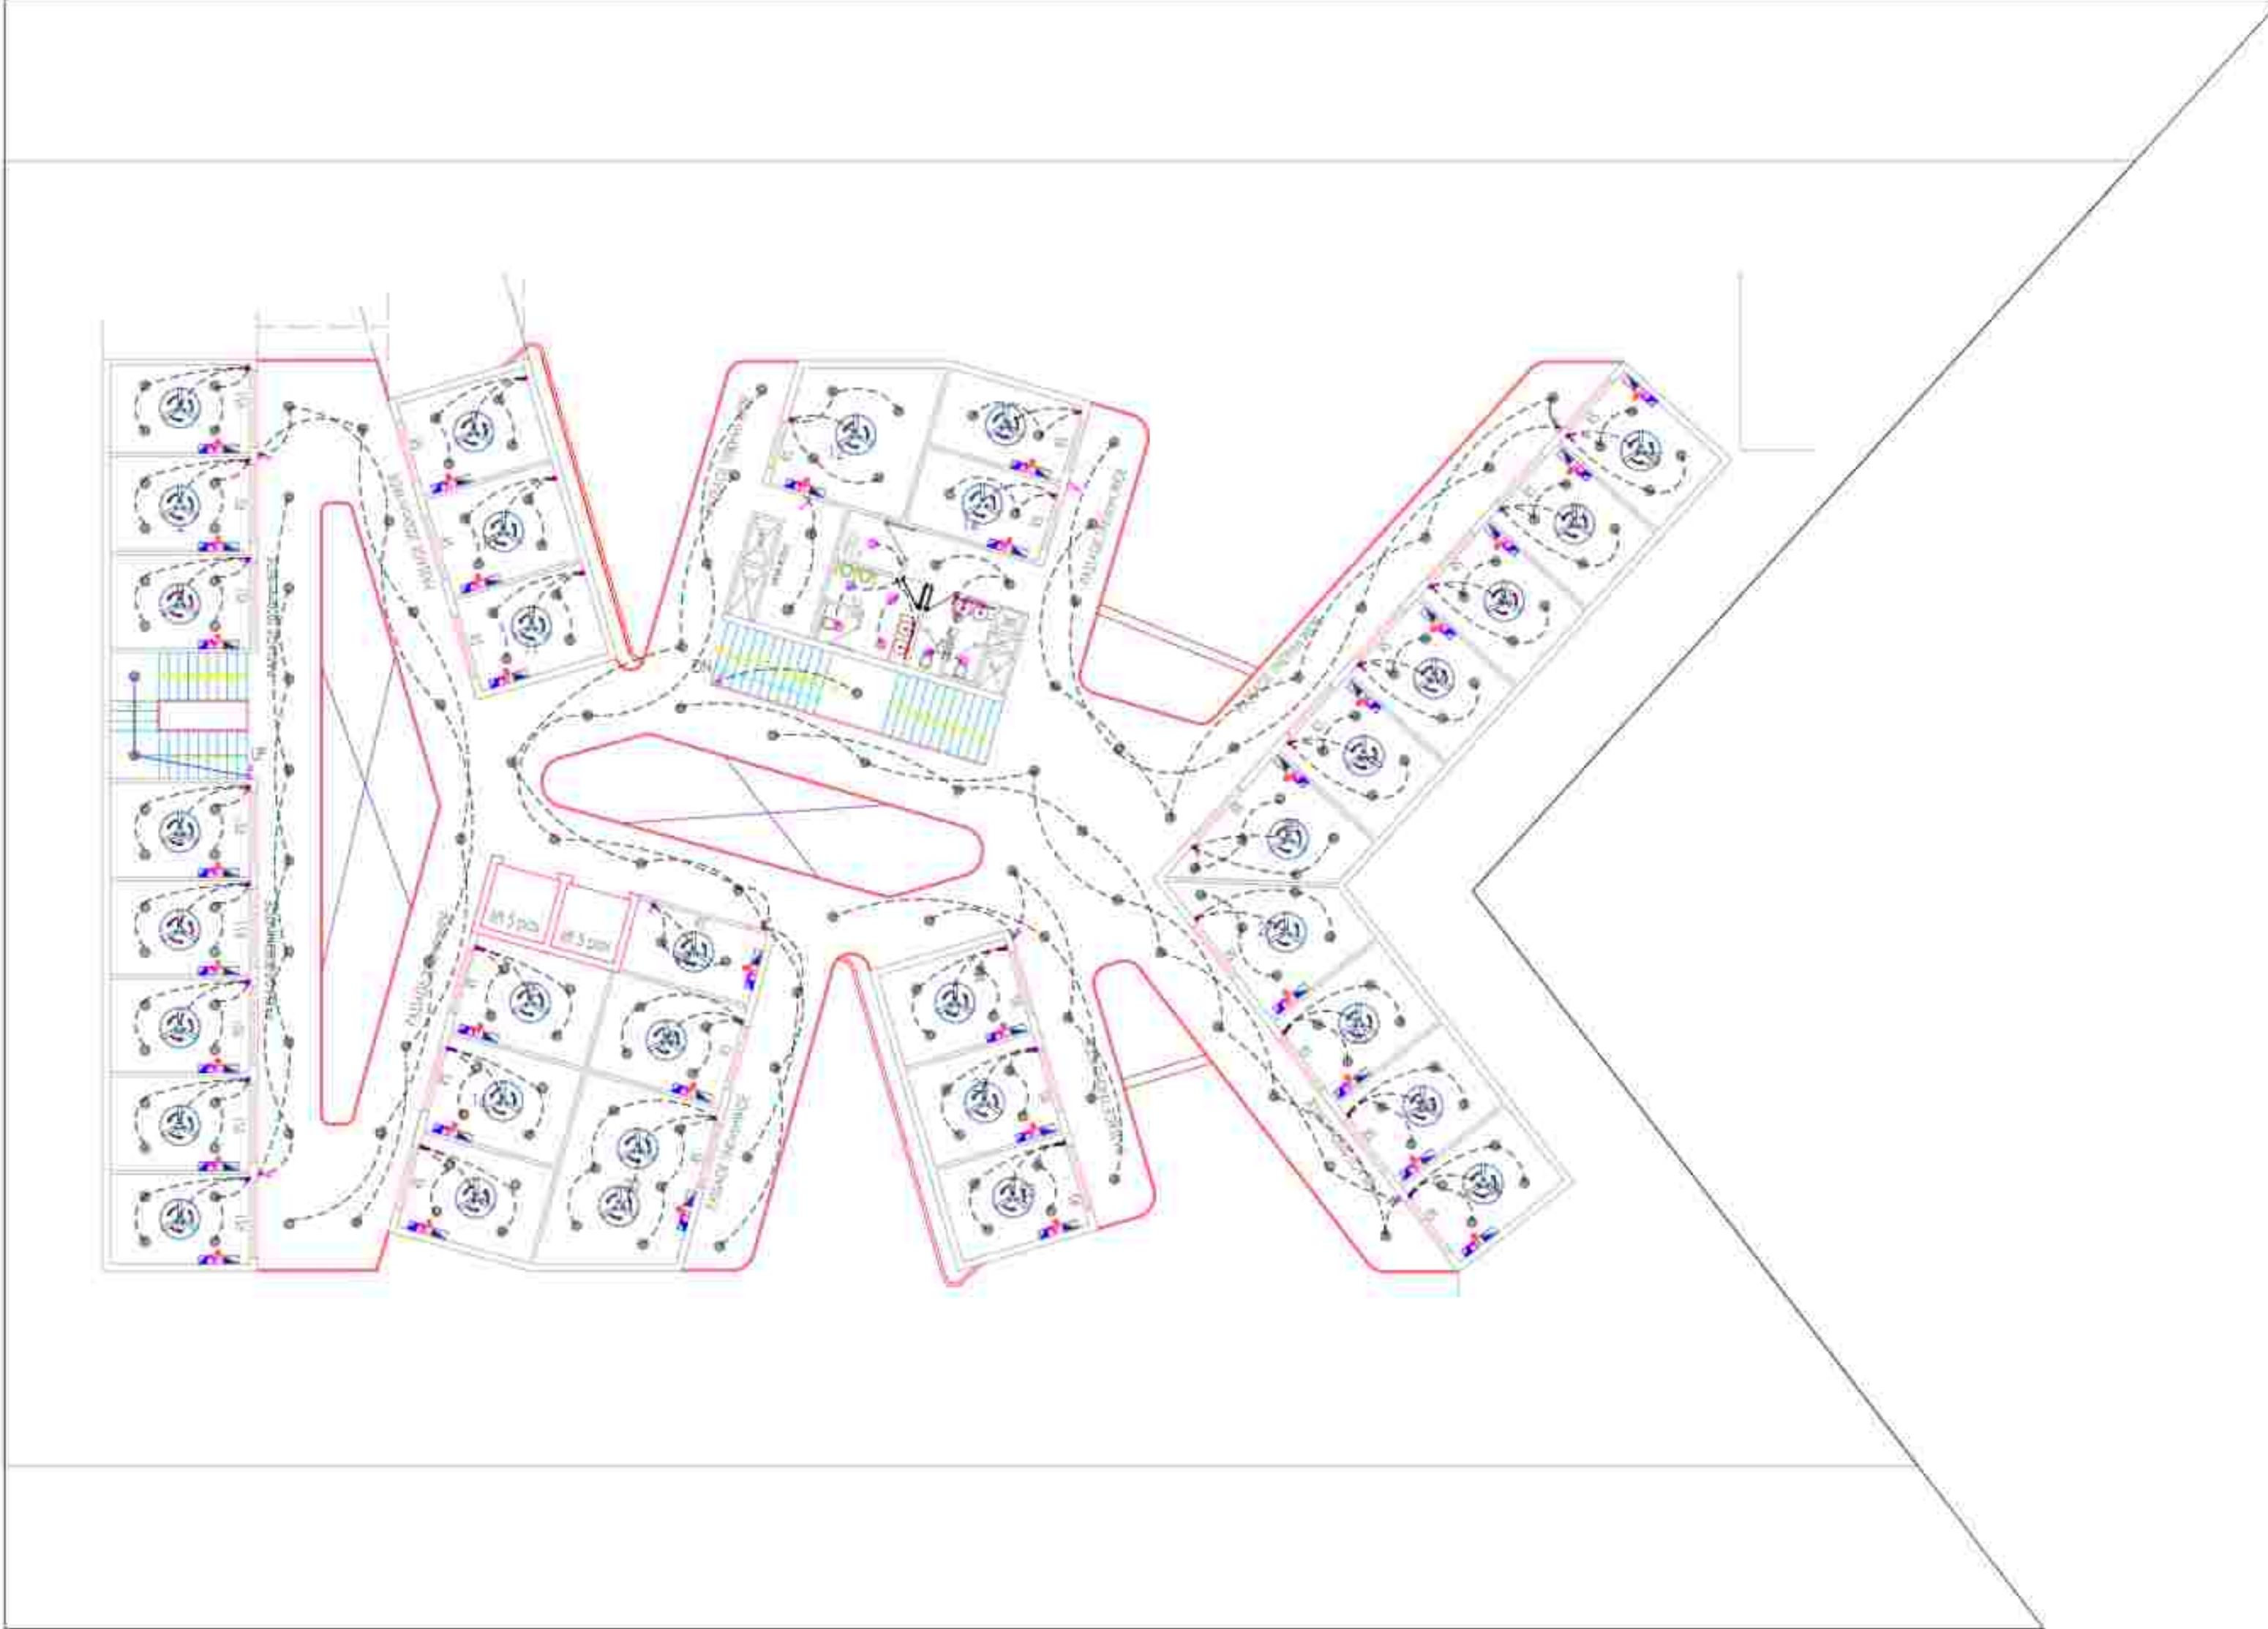

LEGEND	DESCRIPTION	REF TO WALL OFF POSITION
[Symbol]	RAMP ONE WAY SWITCH	+1200
[Symbol]	RAMP TWO WAY SWITCH	+1200
[Symbol]	12W LED CEILING LIGHT FOR TOILET AREA	+1200
[Symbol]	25W ROUND TYPE LED CEILING LIGHT	CEILING
[Symbol]	10W MIRROR LED LIGHT	2800mm
[Symbol]	1200 DIA. CEILING FAN	CEILING
[Symbol]	TELEPHONE OUTLET	AS PER SITE
[Symbol]	DATA/COMPUTER OUTLET	AS PER SITE
[Symbol]	TV OUTLET	AS PER SITE
[Symbol]	DISTRIBUTION BOARD	+1500

CONDUIT RECESSED IN SLAB
CONDUIT RECESSED IN WALL
SWITCH BOX
FINISHED FLOOR LEVEL
SWITCH BOX FIXING DETAIL
LIGHT+POWER SUB DISTRIBUTION BOARD
SDB - NO (ONE)
PHASE (RED)
CIRCUIT NO. (ONE)
CIRCUIT PHASE DISTRIBUTION LEGEND


TYPICAL DETAIL OF DB FIXING

MEP Consultant:-
M.S ASSOCIATES
VESI CONSULTANT ENGINEERS
4000, 2nd Floor, 1st Stage, Sector 10, Gurgaon, Haryana
Phone: 9999999999, 9999999999, 9999999999
Email: msassociates@gmail.com, msassociates@gmail.com
Website: www.msassociates.com



DRAWING TITLE: **SECOND FLOOR PLAN ELECTRICAL LOOPING LAYOUT PLAN**

DATE: 22/05/2024
DRN: [Signature]
CHKD: 22/05/2024
SCALE: [Blank]
ISSUED BY: EUPHORANT LLP
DRAWING NO: E-02
SHEET NO: 1
PROJECT: [Blank]

STUDIO
EUPHORANT LLP

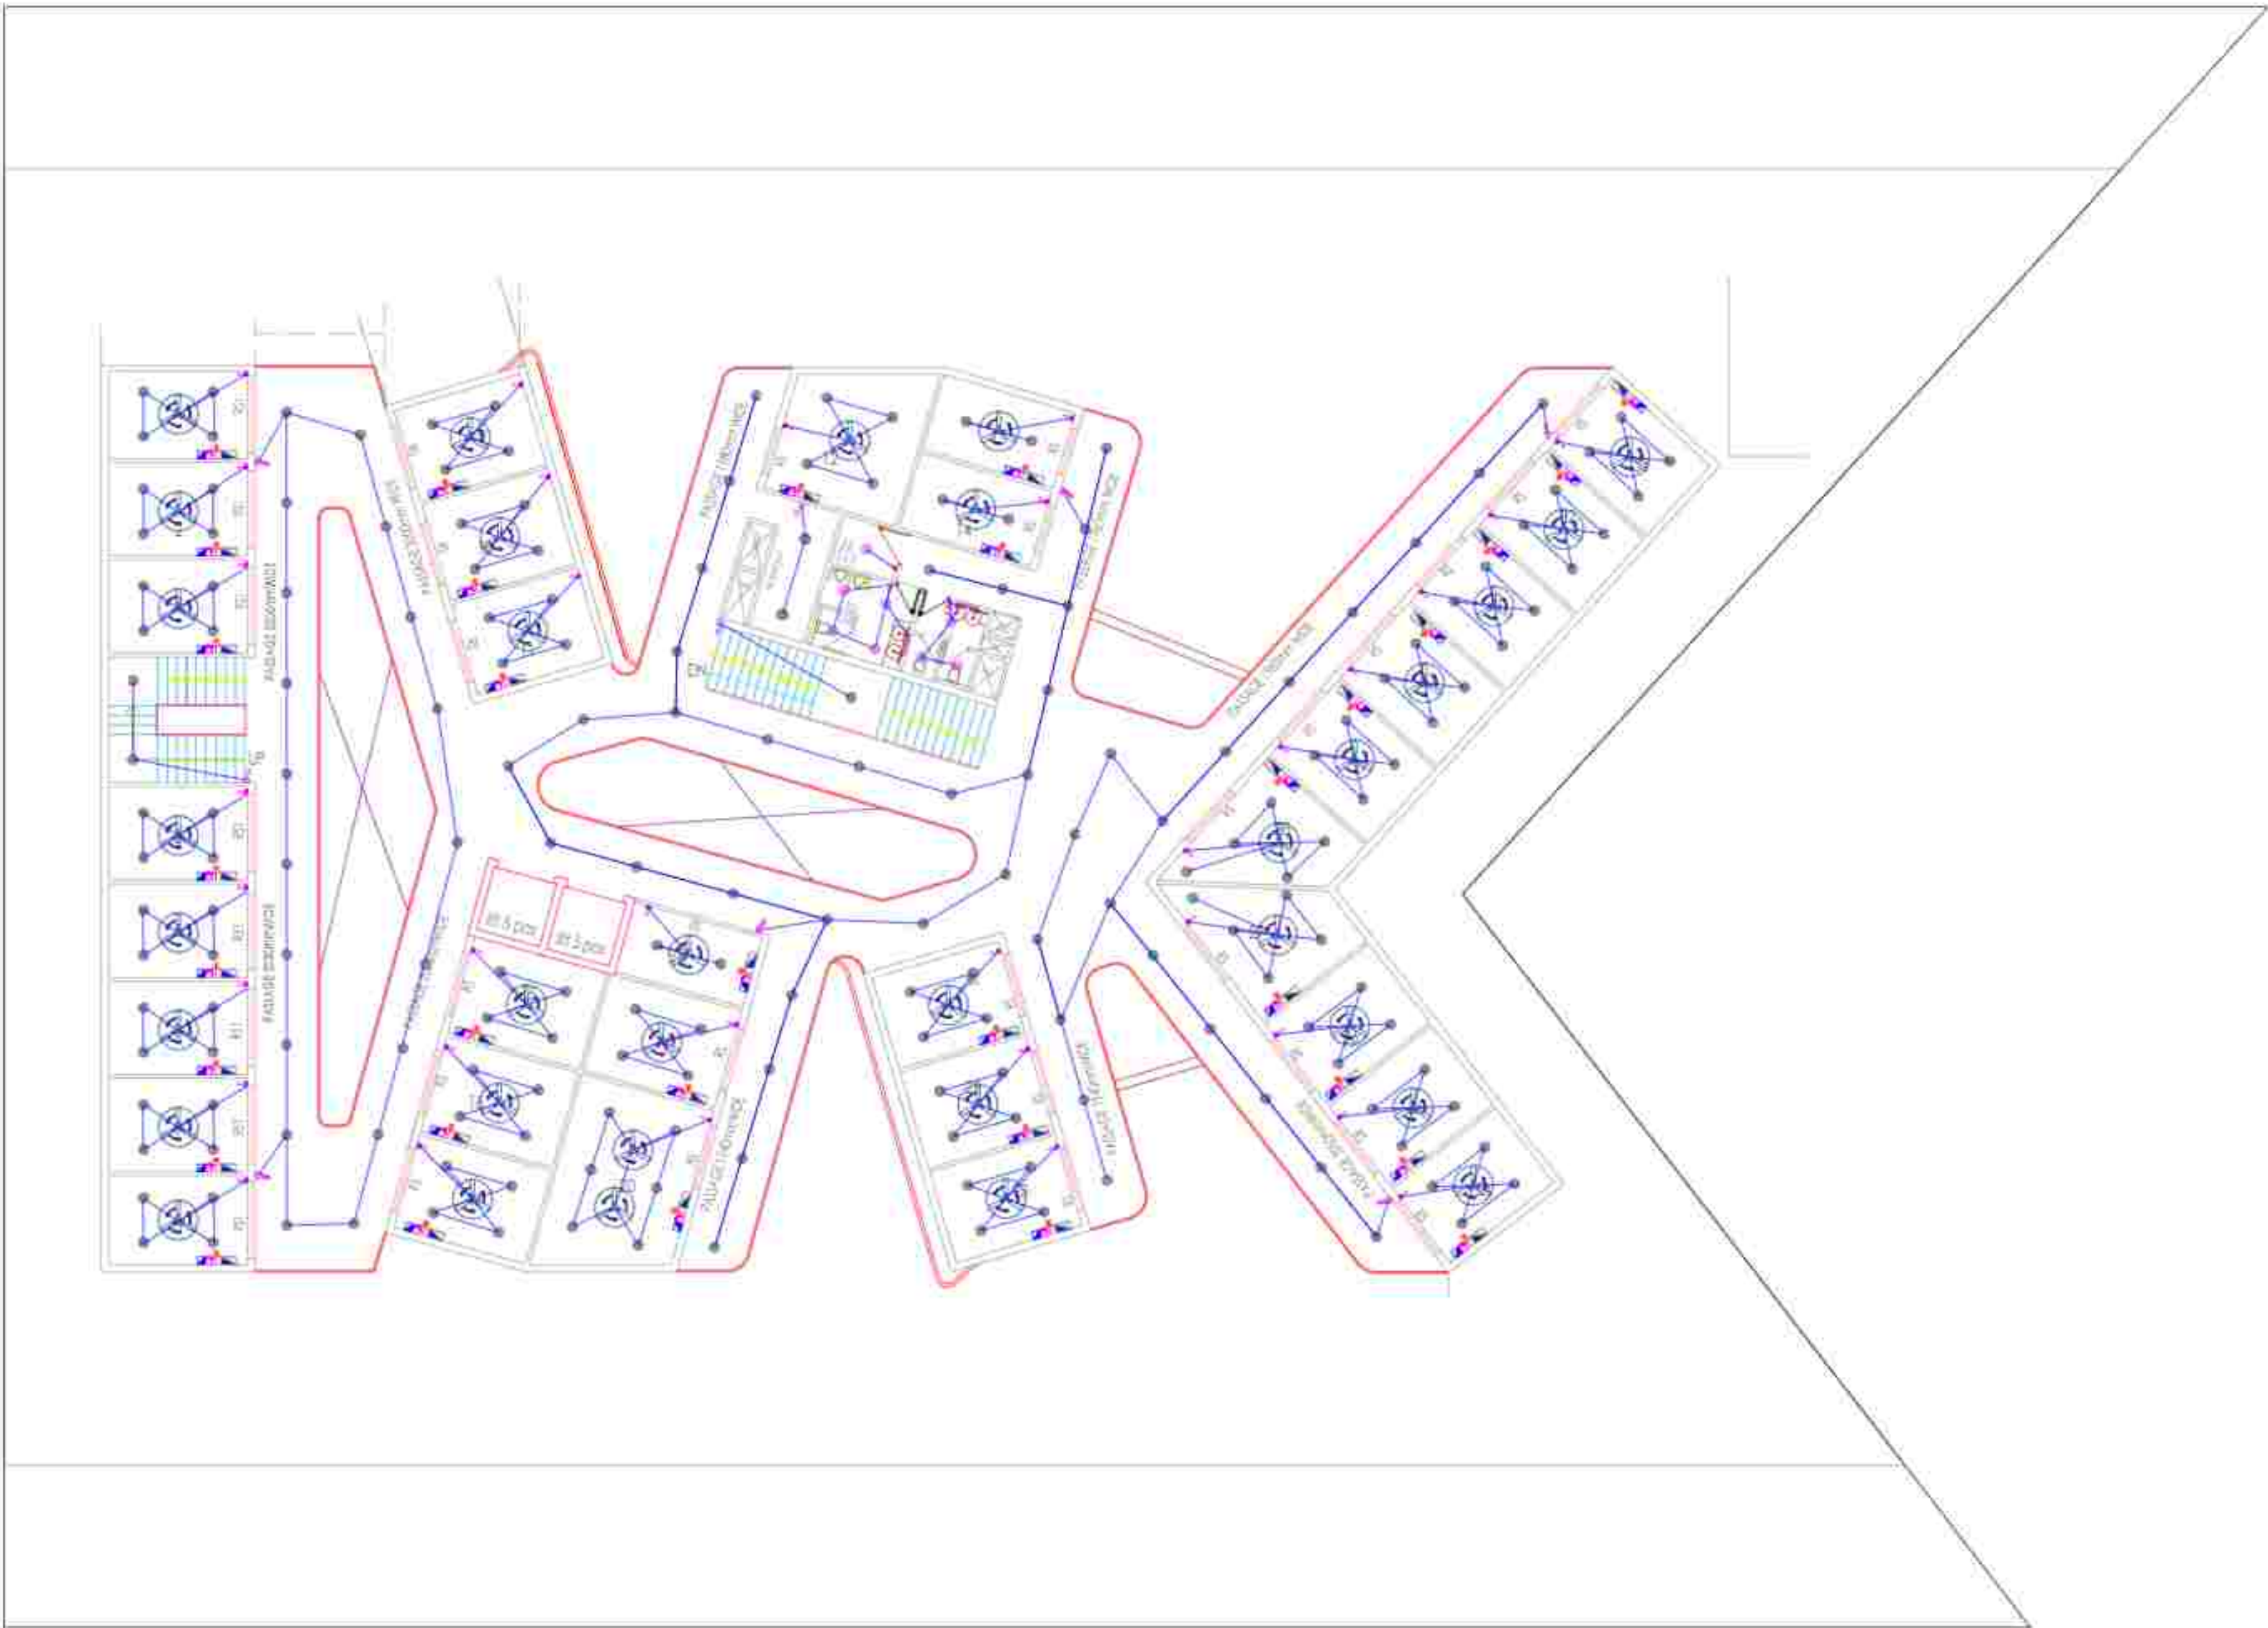

LEGEND	DESCRIPTION	REF TO AND LAYOUT
[Symbol]	6AMP ONE WAY SWITCH	+1200
[Symbol]	6AMP TWO WAY SWITCH	+1200
[Symbol]	12W LED CEILING LIGHT FOR TOILET AREA	+1200
[Symbol]	25W ROUND TYPE LED CEILING LIGHT	CEILING
[Symbol]	10W MIRROR LED LIGHT	WALL
[Symbol]	1200 DIA. CEILING FAN	CEILING
[Symbol]	TELEPHONE OUTLET	AS PER SITE
[Symbol]	DATA/COMPUTER OUTLET	AS PER SITE
[Symbol]	TV OUTLET	AS PER SITE
[Symbol]	DISTRIBUTION BOARD	+1500

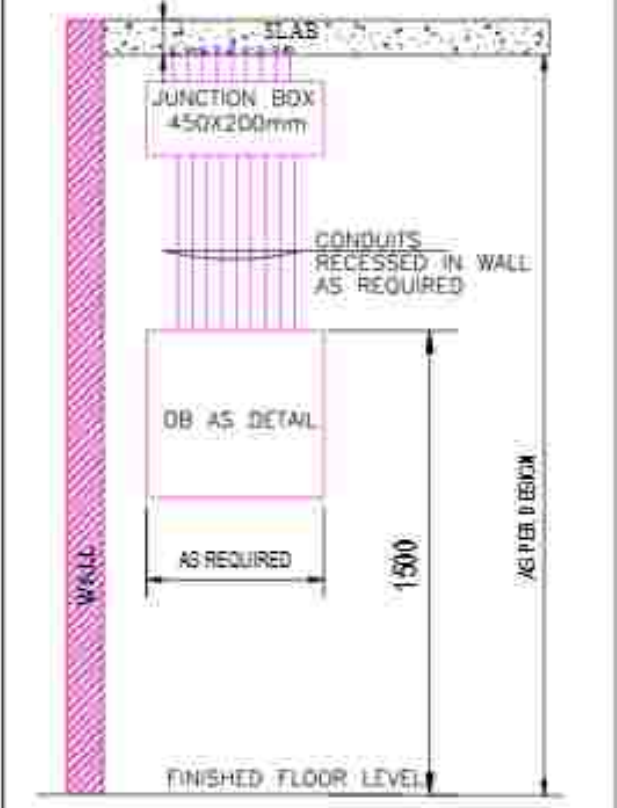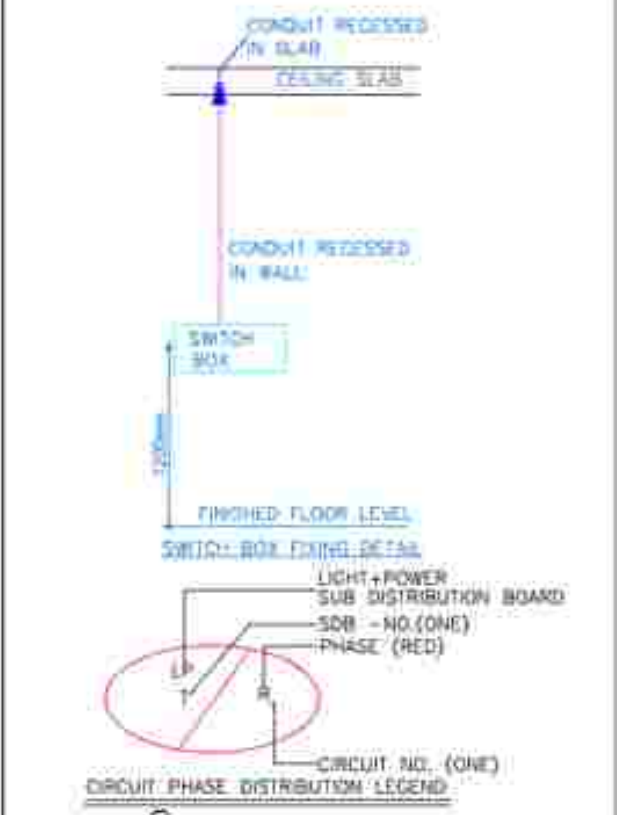

TYPICAL DETAIL OF DB FIXING

MEP Consultant:-
M.S ASSOCIATES
MEP CONSULTANT ENGINEERS
S-105, Sector-10, Industrial Area Phase-III, Gurgaon, Haryana
Phone: 9868888888, 9868888888, 9868888888
Fax: 9868888888

DRAWING NO:- **SECOND FLOOR PLAN**
ELECTRICAL LIGHTING LAYOUT PLAN

CLIENT :-

DATE	24/07/2024	STAMP:
DRN	6/2024	
CHKD	Asst. Engg.	
SCALE	As per detail	
ISSUED BY:	Asst. Engg.	
DRAWING NO	02-05/ARCH/TP-3	SHEET NO :-
PROJECT		

S T U D I O
EUPHORANT LLP

