

THIS DRAWING IS THE PROPERTY OF M/S ANUJ AGARWAL ARCHITECTS (P) LTD. AND SHALL NOT BE REPRODUCED OR USED FOR ANY OTHER PURPOSE THAN SPECIFIED WITHOUT WRITTEN PERMISSION

- NOTES:
1. ALL DIMENSION ARE IN MM.
 2. THIS DRAWING IS NOT TO BE SCALED.
 3. THIS DRAWING SHOULD BE READ IN CONJUNCTION WITH OTHER RELEVANT DRAWINGS.
 4. ALL THE LEVELS WILL BE CHECKED BY SITE ENGINEER ACCORDING TO SECTION DRAWING.
 5. RAFT THICKNESS AS/STRUCTURE DRAWING
 6. WORKING DISTANCE WILL BE DECIDE BY SITE INCHARGE FOR SUITABLE WORKING CONDITION AT SITE.
 7. IF ANY AMBIGUITY FOUND SHOULD BE REFERRED TO THE ARCHITECT BEFORE EXECUTION.

PRINT DATA:


S.NO.	DATE	NO. (PRINTS)	ISSUED TO

REVISIONS:

S.NO.	REV.NO./DATE	PARTICULARS
01	R1/02/05/2019	REVISED GRID LAY-OUT PLAN ACCORDING TO THE ER.S.P THAKUR & ER.A.K.SINGH JI

drawing released for

- ☐ APPROVAL ☐ SUBMISSION
☐ ADVANCE COPY ☒ CONSTRUCTION

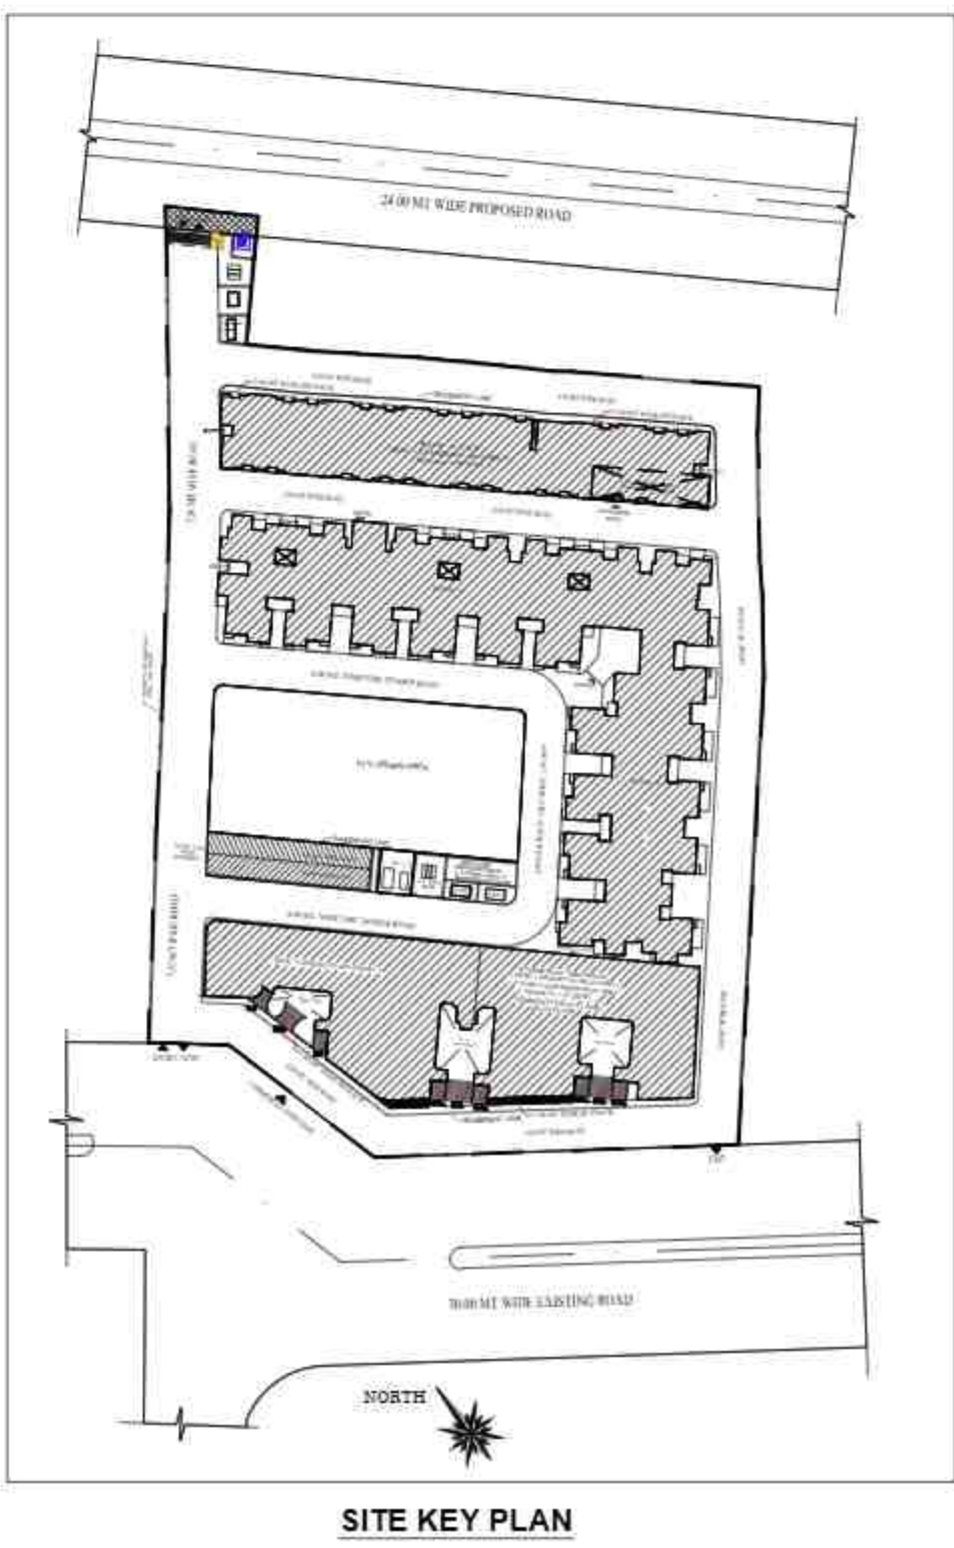

NAME OF PROJECT:

JAY AMBAY ESTATE JAGDISHPURAM

PROJECT:
WORKING DRAWING FOR THE PROPOSED AFFORDABLE HOUSING (PMAY) PROJECT "JAGDISHPURAM" AT KHASRA NO. - 1207M VILLAGE NOOR NAGAR GHAZIABAD (U.P.)

DRG. TITLE:

SITE PLAN
WATER SUPPLY LAYOUT

DEALT BY:	A.B	SCALE:	N.T.S
CHECKED BY:	K.S	DRG. NO:	PL-102
CHECKED BY:	KB	NORTH:	N
DATE:	27.09.2025		

ARCHITECT:



Design Studio

ANUJ AGARWAL ARCHITECTS
OFFICE:- A-244 KAUSHAMBI GHAZIABAD (U.P.)
Ph:-0120 - 4165716 , 4563716 , 4157506
e-mail : arch.anujagarwal@gmail.com

