


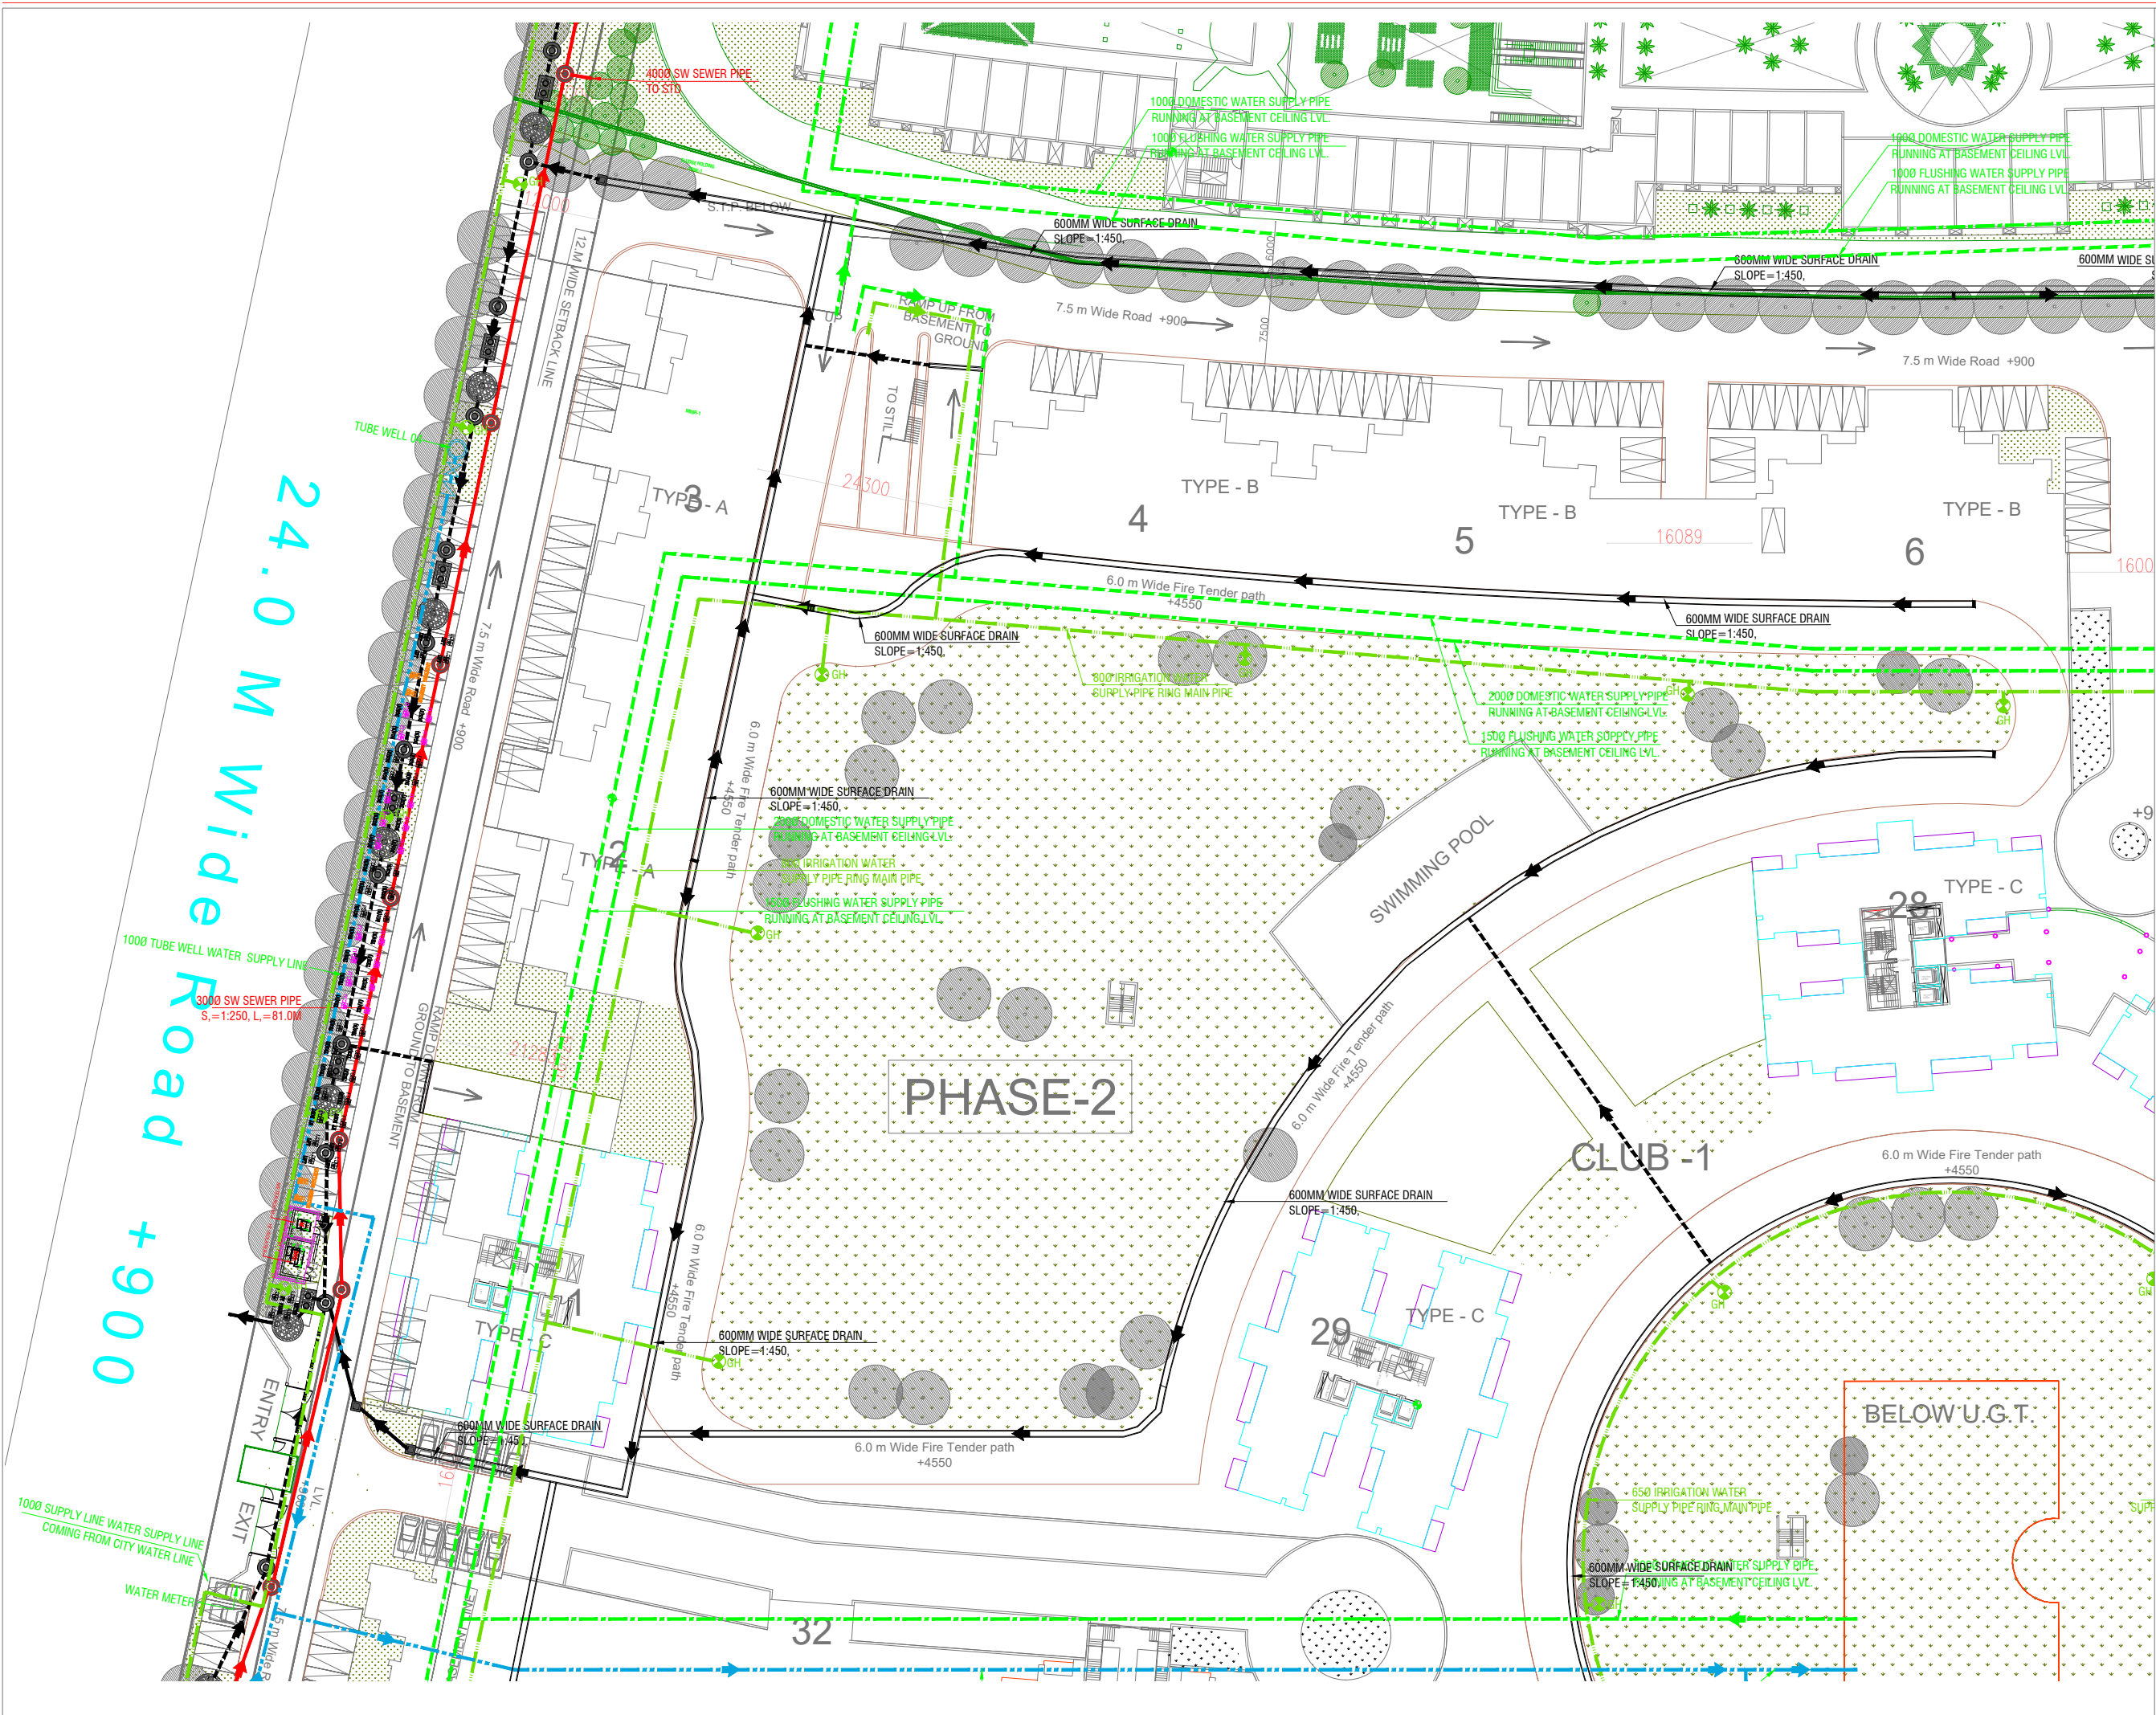

- SPECIAL NOTES :**
1. ALL DIMENSIONS ON THIS DRAWING ARE IN MM.
 2. ONLY WRITTEN DIMENSIONS ARE TO BE FOLLOWED. DRAWINGS SHOULD NOT BE SCALED UNDER ANY CIRCUMSTANCES.
 3. ALL MEASUREMENTS MUST BE CHECKED AND VERIFIED BY THE CONTRACTORS PRIOR TO EXECUTION OF WORK AT THE SITE.
 4. THIS DRAWING IS TO BE READ IN CONJUNCTION WITH ALL RELEVANT STRUCTURAL, SERVICES & FACILITY PLANNING DRAWINGS.
 5. ARCHITECTURAL DRAWINGS ARE TO BE FOLLOWED FOR THE LOCATION OF ALL STRUCTURAL MEMBERS & MASONRY WALLS. FOR SIZES & REINFORCEMENT DETAILS OF STRUCTURAL MEMBERS RELEVANT STRUCTURAL DRAWINGS ARE TO BE REFERRED.
 6. ANY DISCREPANCIES BETWEEN ARCHITECTURAL, STRUCTURAL AND SERVICES DRAWINGS MUST BE BROUGHT TO THE NOTICE OF THE ARCHITECTS IMMEDIATELY & PRIOR TO EXECUTION AT SITE.
 7. CO-ORDINATION WITH THE SERVICES SUCH AS HVAC, PLUMBING & ELECTRICAL ETC. IS THE RESPONSIBILITY OF THE CONTRACTORS.
 8. ALL MASONRY WALLS SHOULD BE ALIGNED WITH THE COLUMNS AS INDICATED ON THE PLAN IRRESPECTIVE OF THE POSITION AS CALCULATED WITH THE DIMENSIONING.
 9. FOR DETAILS, REFER RELEVANT LARGE SCALE DETAIL DRGS. AS INDICATED.

NEW SERVICES LEGEND:	
	SEWER MANHOLE WITH 500MM MANHOLE COVER
	CATCH BASIN 600 X 600
	STORM WATER MANHOLE WITH 500MM PERFORATED MANHOLE COVER
GH	GARDEN HYDRANT
EFH	EXTERNAL FIRE HYDRANT (750x600x250) MM
	EXTERNAL SEWER LINE
	EXTERNAL STORM WATER LINE (DIA AS / DESIGN CHART)
	GARDEN IRRIGATION WATER SUPPLY LINE (DIA MENTION IN LAYOUT)
	EXTERNAL FIRE HYDRANT LINE (DIA MENTION IN LAYOUT)
	DOMESTIC WATER SUPPLY
	FLUSHING LINE WATER SUPPLY
	MUNICIPAL LINE WATER SUPPLY
	TUBE WELL WATER SUPPLY LINE
R.P.	RECHARGE PIT (2000) MM
D.C.	DESILTING CHAMBER (1000 X 2000)MM

NCH Services Consultants
PARADISE CONSULTANTS
Plot No. 103, Basement,
Near Living Style Mall, Jasola Vihar
New Delhi - 110025
E-mail: paradiseconsultants@gmail.com
website: www.paradiseconsultants.com

**EXTERNAL SITE PLAN
WATER SUPPLY LAYOUT**

SCALE - 1:500@A0	DATE - 16.09.16	DRG NO.
DRAWN BY T.S. RAJAT	CHECKED BY ANL	

N
S