
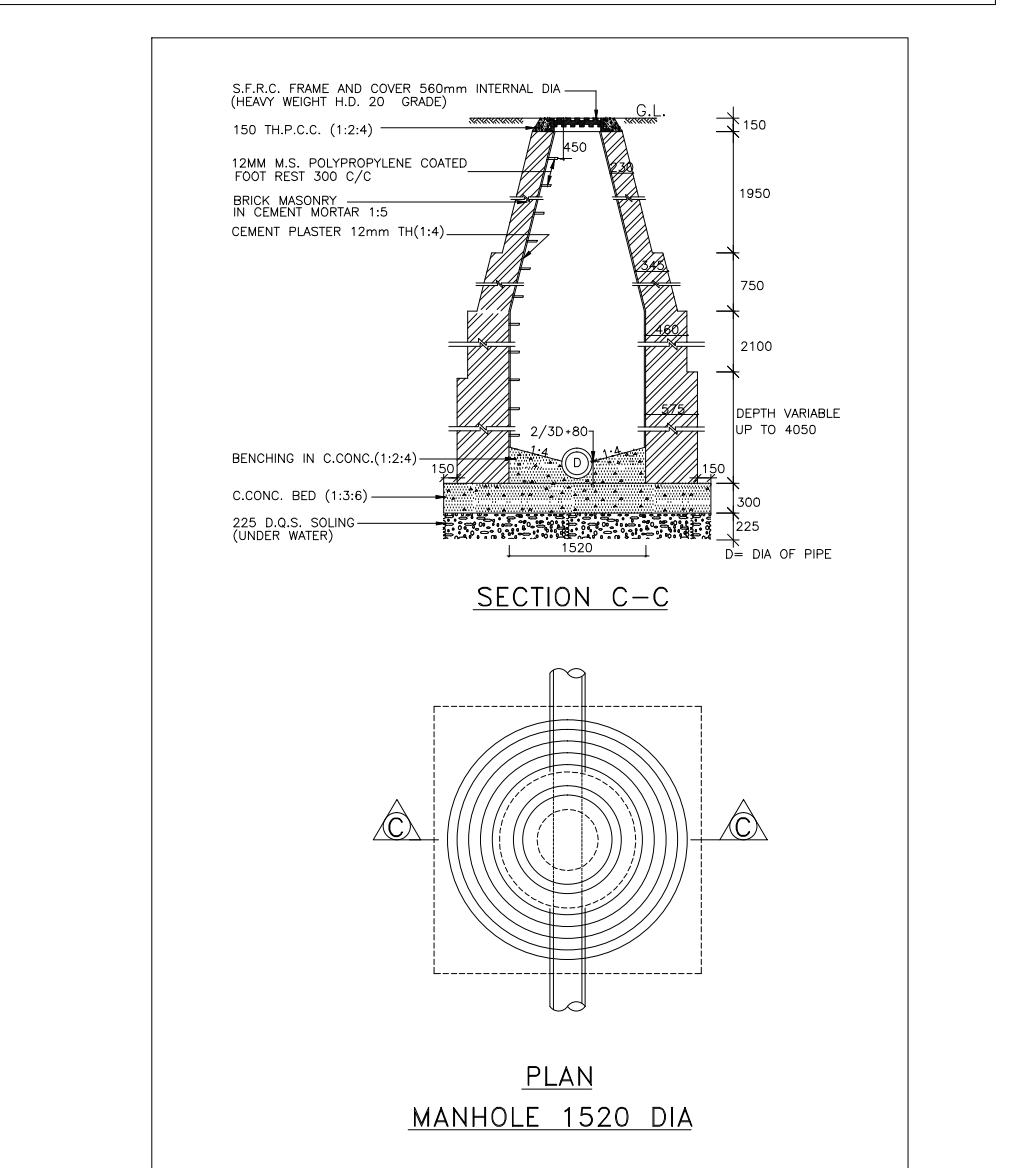


LEGEND	
SYMBOL	DESCRIPTION
	EXTERNAL SEWER LINE
	EXTERNAL STROM LINE
	ESTERNAL FIRE HYDRANT RING
	GARDEN HYDRANT RING
	EXTERNAL SEWER LINE MANHOLE
	EXTERNAL STROM LINE MANHOLE
	FIRE HYDRANT (80ø TO FH)
	GARDENT HYDRANT (25ø TO GH)



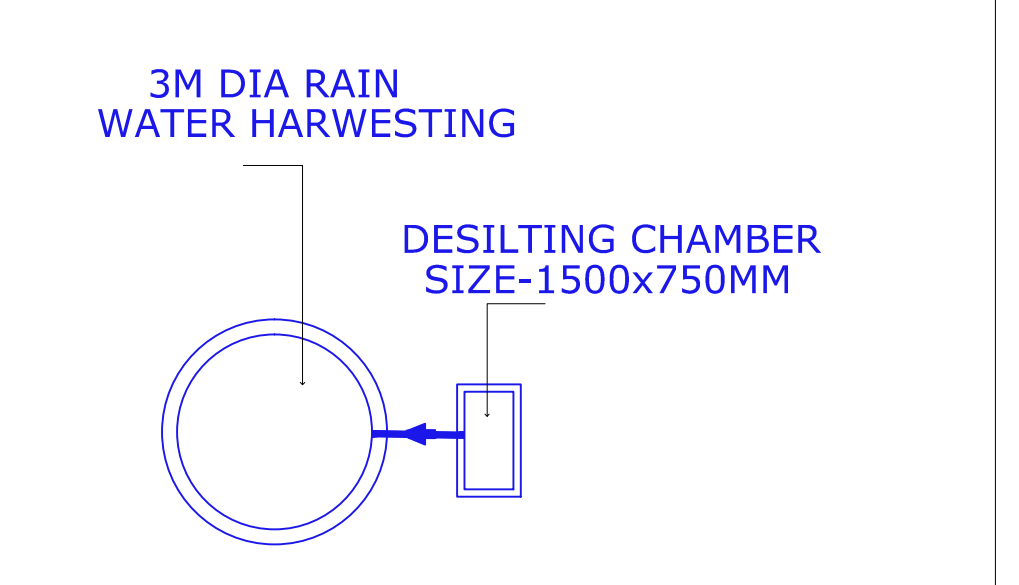


PROJECT:
DRAWING FOR THE PROPOSED
GROUP HOUSING PROJECT NEAR KHASRA NO.-659,
SEC-2C, VASUNDHARA ,GHAZIABAD (U.P.)

OWNER :-
MR. RANN SINGH

THROUGH P.O.A:-
M/s. METRO SUITES HOMES LLP
MR. SUDHIR KUMAR RAI

DRAWING TITLE :
SITE PLAN

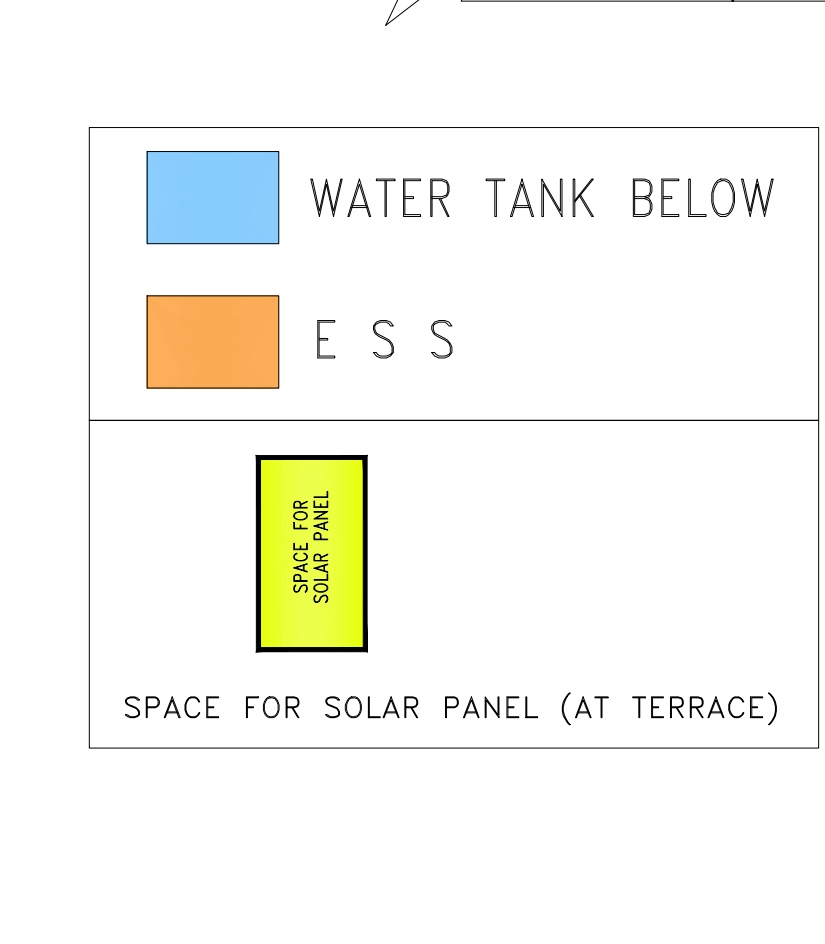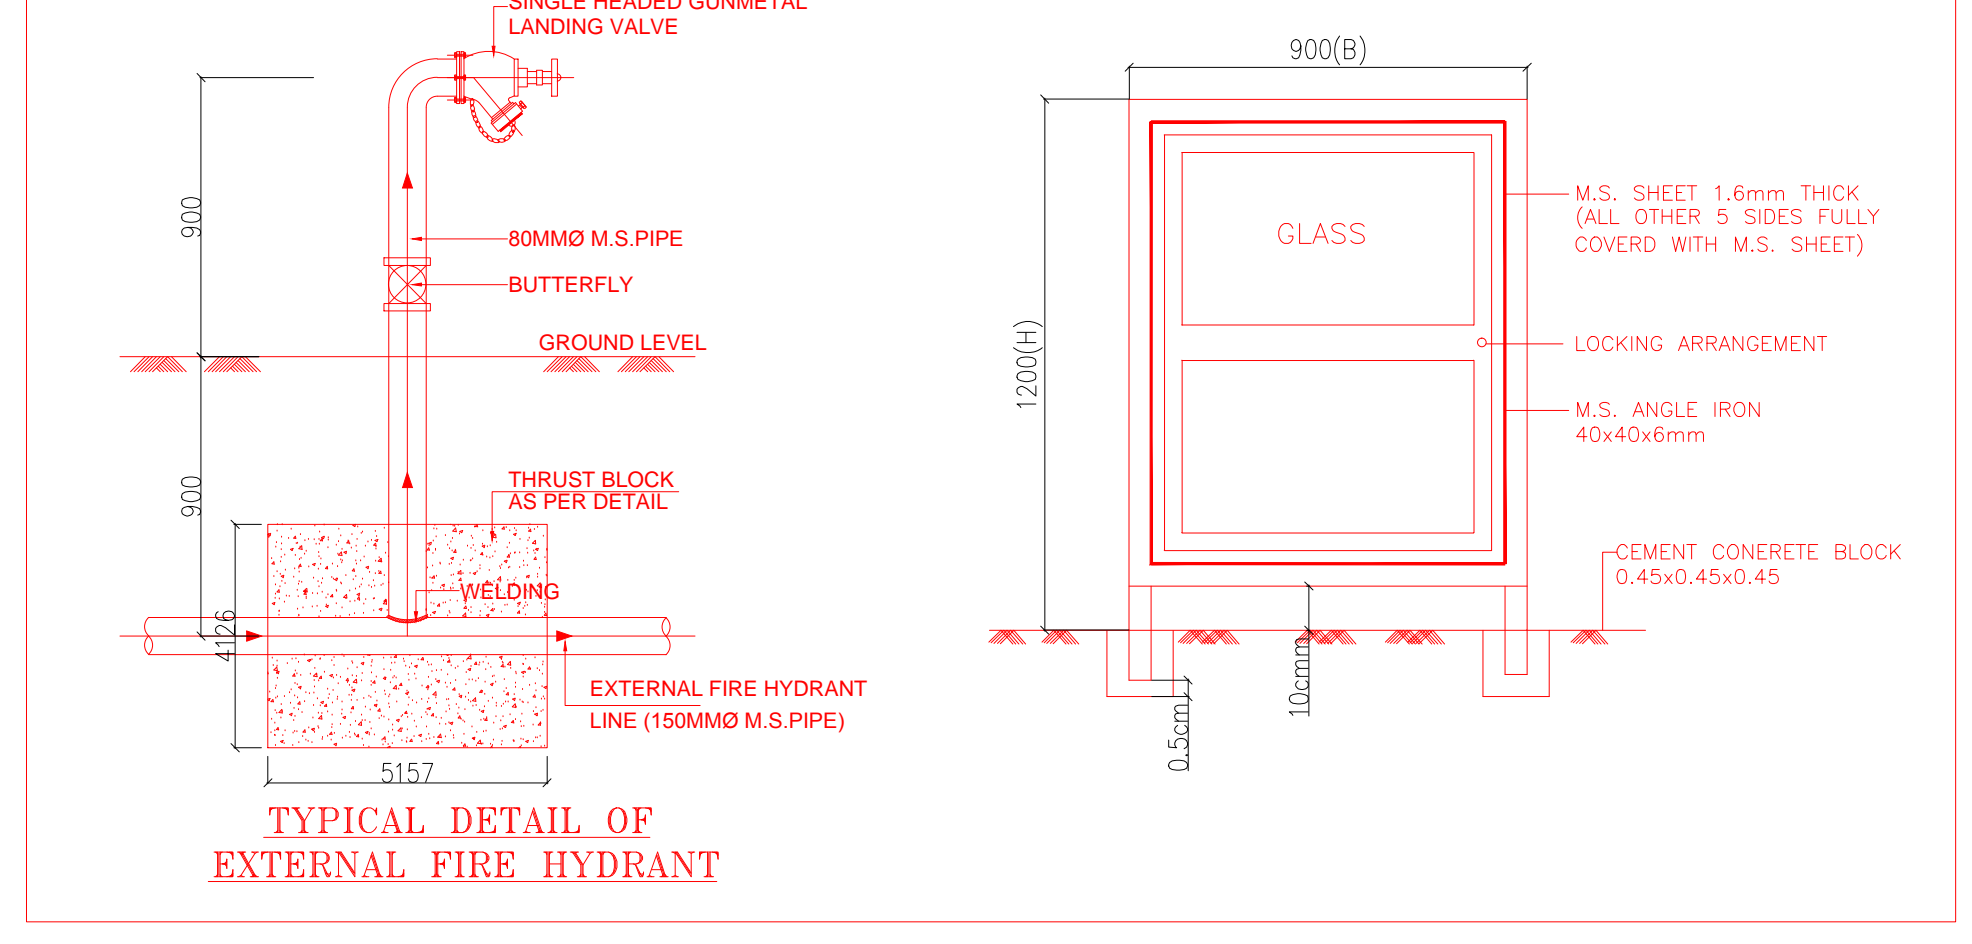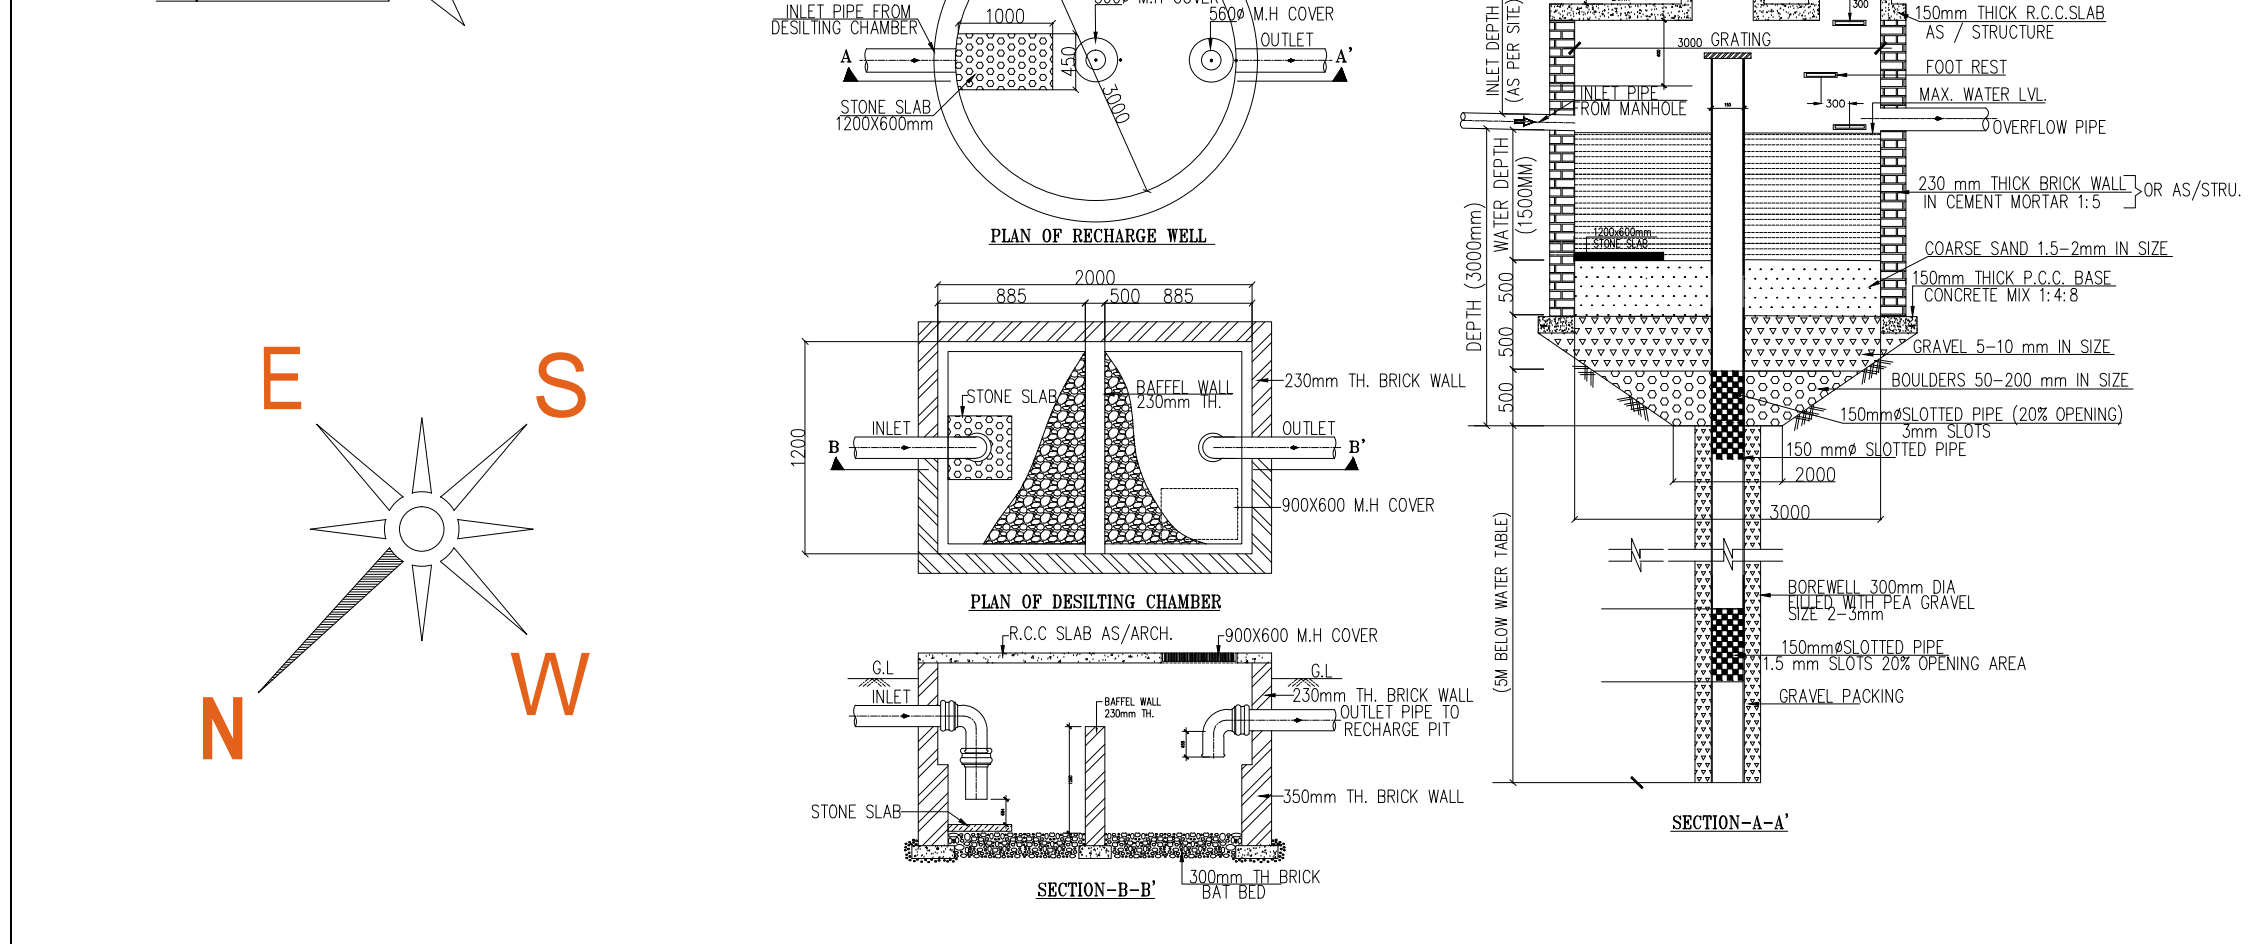

DEVELOPER'S

ARCHITECT'S SIGN.

ANUJ AGARWAL ARCHITECTS
OFFICE:- A-244 KAUSHAMBI GHAZIABAD (U.P.)
Ph:-0120 - 4165716 , 4563716 , 6454182
e-mail : arch.anujagarwal@gmail.com

SCALE	DEALT BY	DATE
DESIGN BY	CHECKED BY	DRG. NO.

DG - 02