


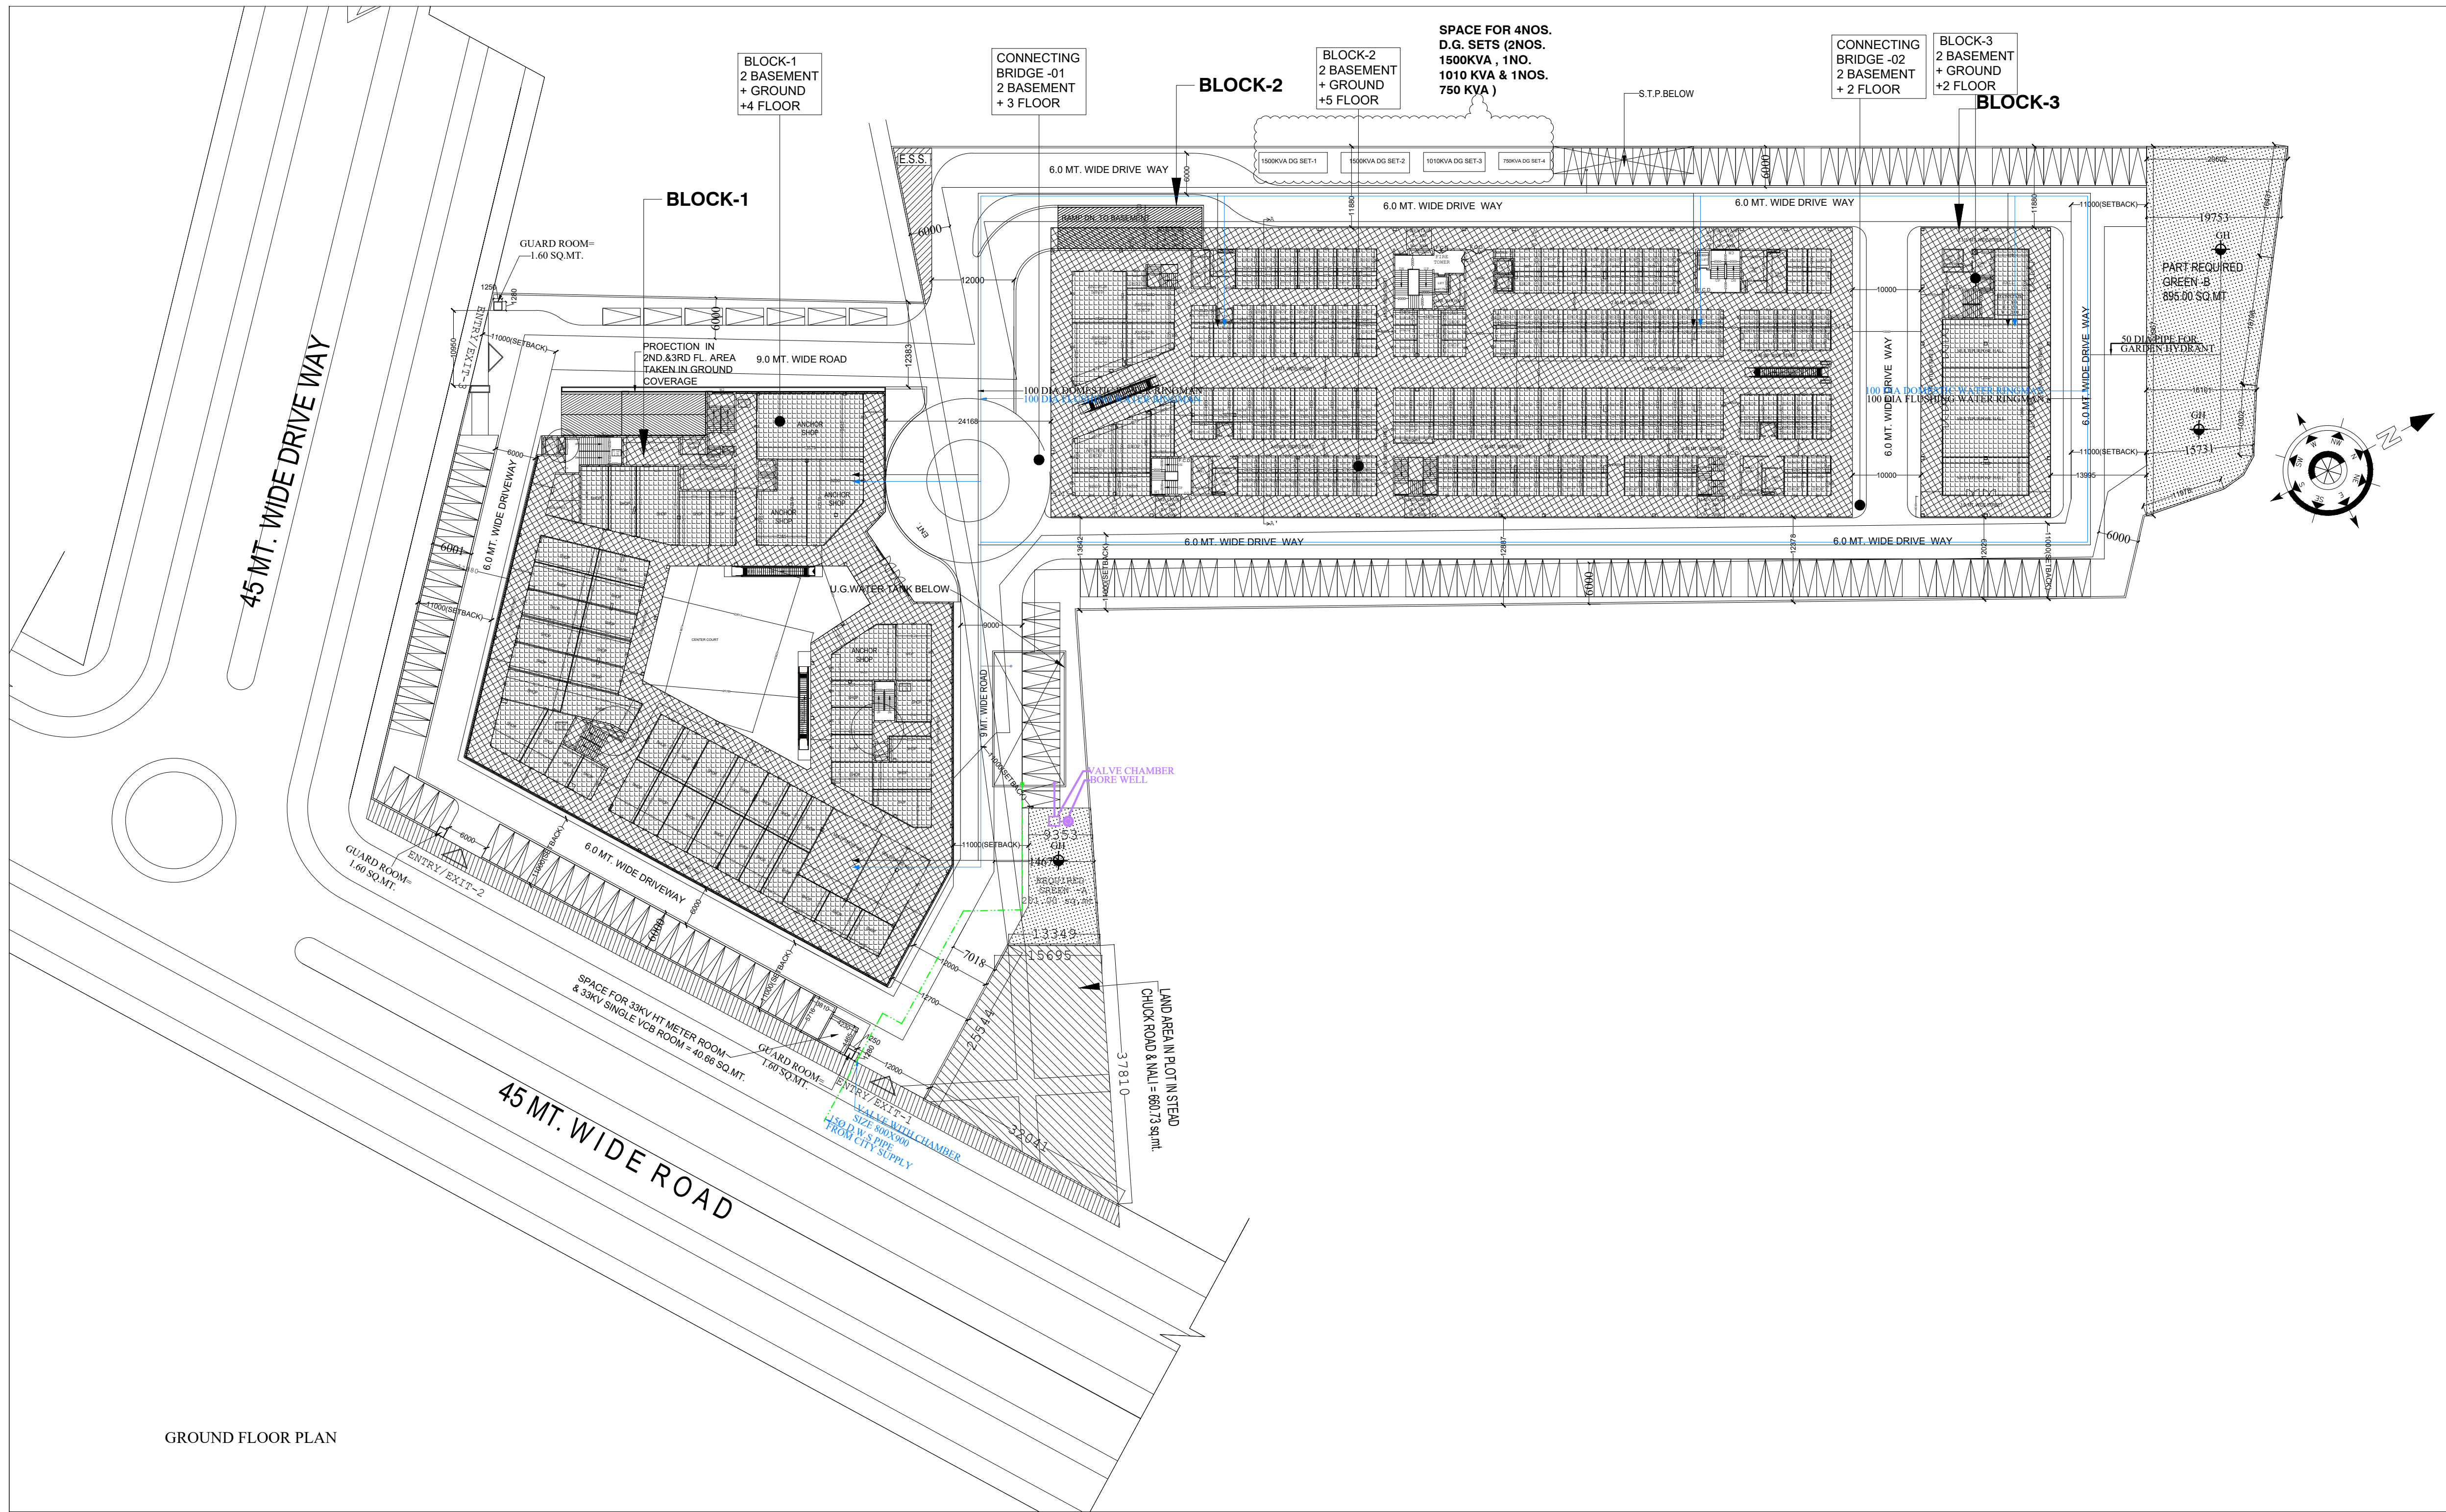

GROUND FLOOR PLAN

DOMESTIC WATER PIPE LINE	
FLUSHING WATER PIPE LINE	
(GH) GARDEN HYDRANT	

PROJECT :-
PROPOSED MULTIPLEX AT KHASRA No.
524,540,544,
537,538 VILLAGE :- NOORNAGAR
GHAZIABAD U.P.

BUILDERS & PROMOTER :-
R.B.Infraestate Pvt. Ltd.
7365 Prame Nagar
Shakti Nagar Delhi - 7

DRAWING TITLE :-
DUAL PLUMBING PLAN

DRAWN BY :- DINESH	CHECKED BY :- PKS	SCALE NTS	DATED :- 07.08.20
-----------------------	----------------------	--------------	----------------------

ARCHITECT'S SIGN.
DRG.NO. - 03

CONSULTANT :-
PEE CONSULTANT
EAST OF LONI ROAD DELHI-110093
815-C, DDA FLATES
PH. & FAX:-011-22816297
email:-pramod@pkv.co.in