


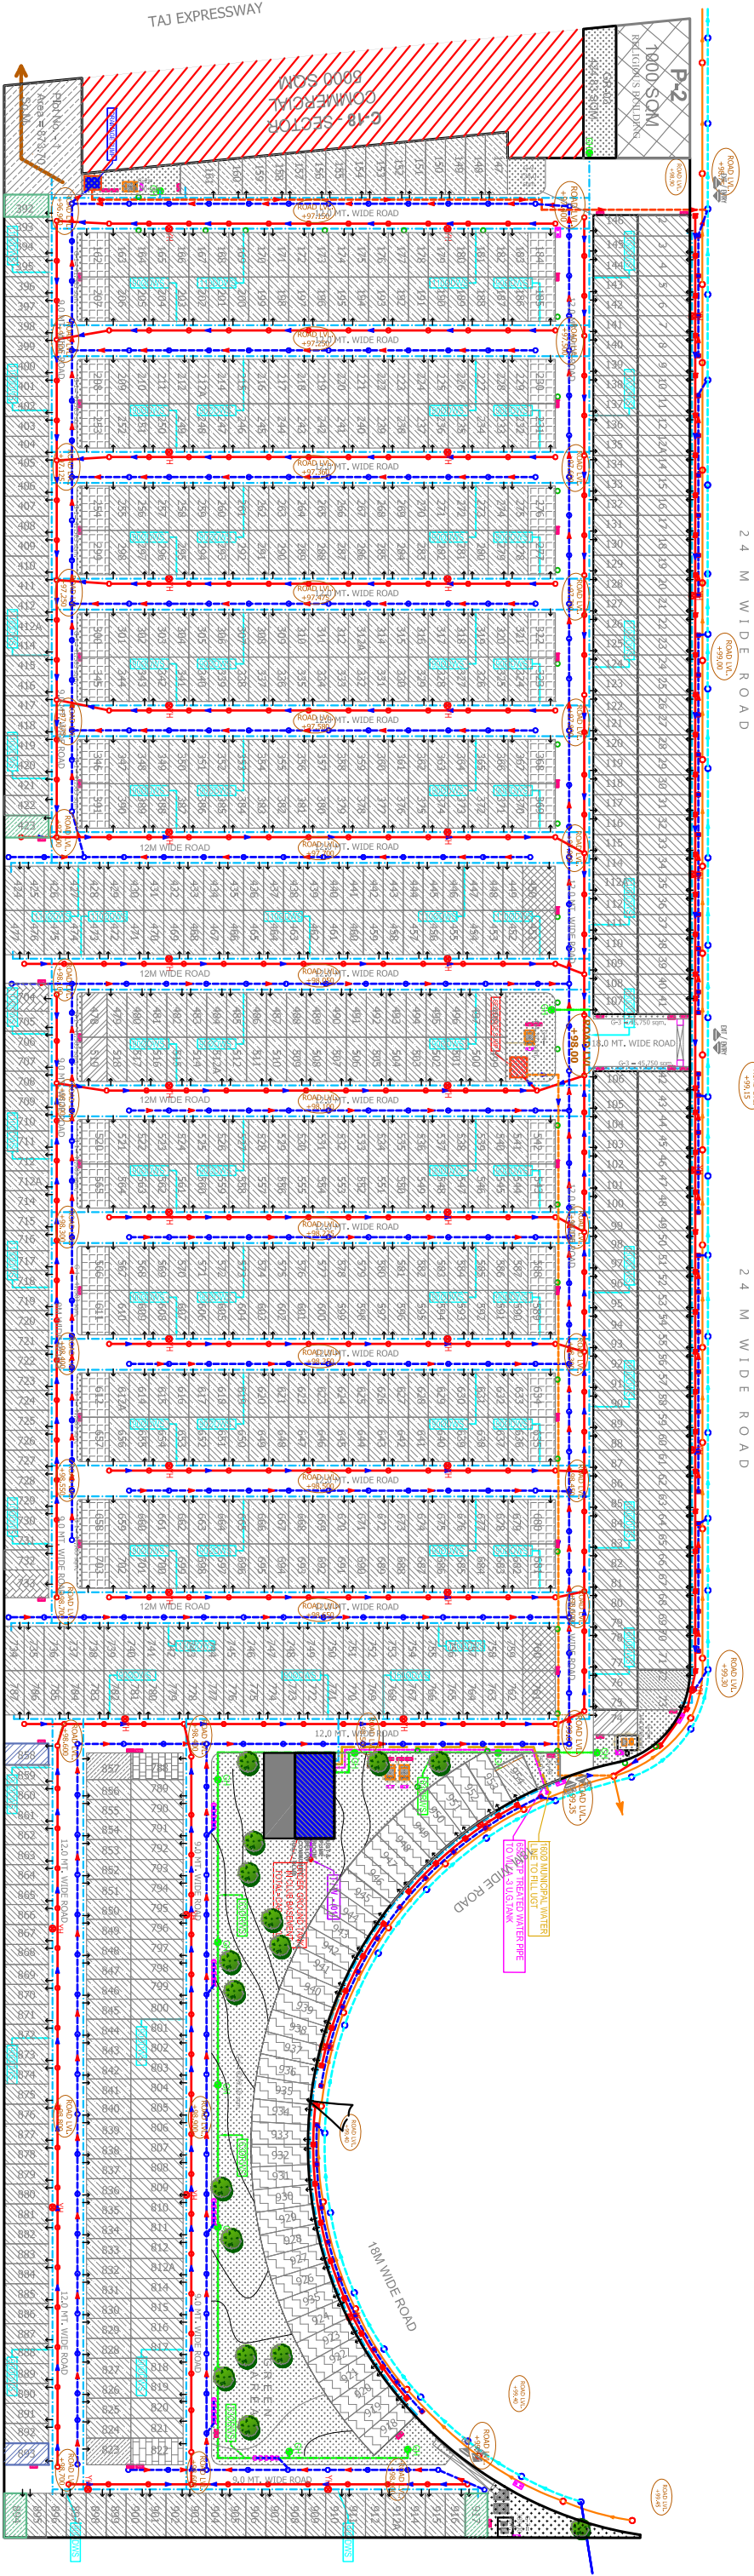

OTHER PROPERTY

LEGEND :	
S.No.	SYMBOL DESCRIPTION
1.	MANHOLE
2.	SEWER LINE
3.	EXISTING SEWER MANHOLE
4.	CATCH PIT
5.	UNDER GROUND PIPE DRAIN
6.	EXISTING DRAINAGE CATCH PIT
7.	RAIN WATER HARVESTING
8.	EXISTING MAIN LINE (FROM TOWN TO LOCALTY)
9.	PROPOSED TIEE WELL
10.	MUNICIPAL WATER SUPPLY PIPE LINE
11.	MASONRY CHAMBER FOR ISOLATING VALVE
12.	YARD HYDRANT
13.	RECICLED WATER SUPPLY LINE FOR HORTICULTURE ROWS
14.	GARDEN HYDRANT
15.	DOMESTIC WATER SUPPLY (PEE DOWS)

PROPOSED
VICTORIAN VILLAS
7TH PARK VIEW- GAUR
YAMUNA CITY-
GREATER NOIDA

Title :
SITE PLAN
Subtile :
EXTERNAL CO-ODINATED LAYOUT

Drawing Released For :
☐ APPROVAL
☐ ADVANCE COPY
☒ SUBMISSION
☐ CONSTRUCTION

Drg. No : GYC / 7th / SP - 04
Date : 27.07.2020
Scale : A1@1:1050
Drawn By : S.Bhandari
Design By : Shakir Shabbir
Ckd By : Anand Havelia

architects
BRU (INDIA) ARCHITECTS
F-89, GREEN PARK, NEW DELHI -16.
Ph. +91-11-26853815, 26858307/Fax : +91-11-26850788
E-mail : bharth.atwln@gmail.com
WebSite: www.atwln.in

services consultant
Consummate Engineering Services (P) Ltd.
Noida Office : B - 67, Sector - 67, Noida - 201 301
Tel : (0120) 26943500 (24 Lines)
Lko. Office : R 006, Rohitas Plumeira, Gontti Nagar, Lucknow
e mail : mail@cespln, website : www.cespln

Drg.No:- 7th-PP- 05