


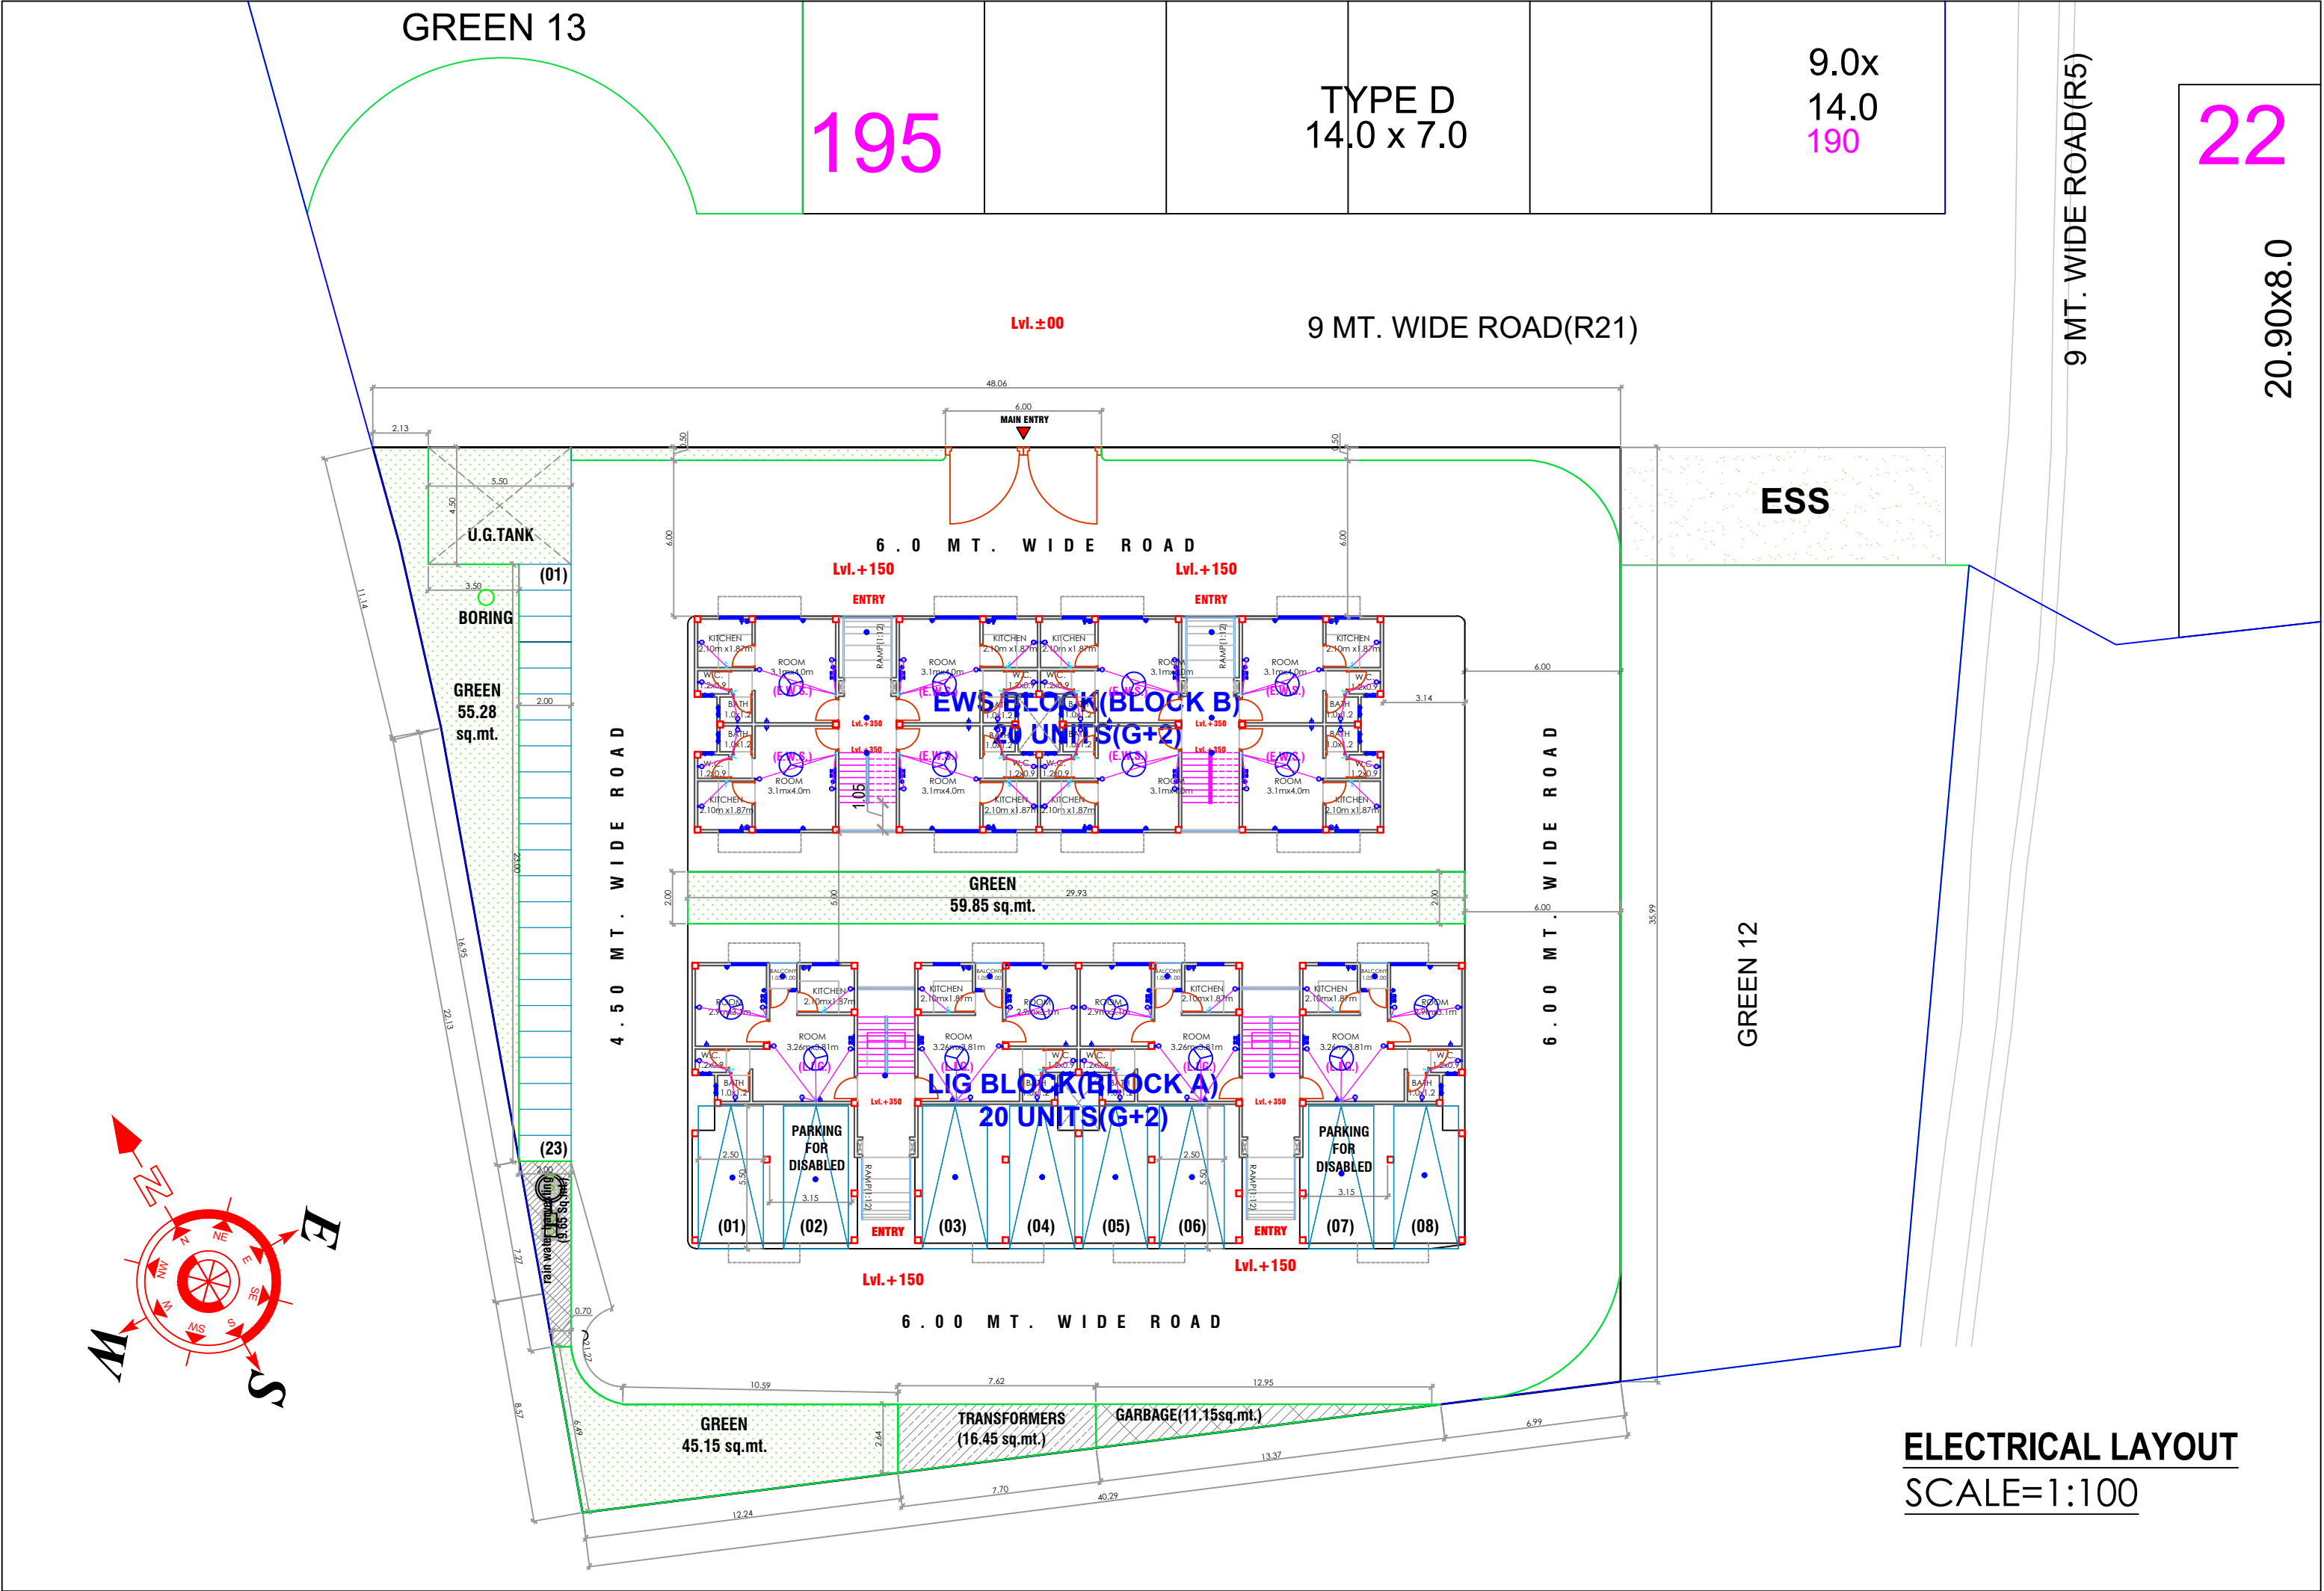

SYMBOL	DESCRIPTION
	6A ONE WAY SWITCH BOARD
	1x18W PL WALL BRACKET FIXTURE
	1x18W PL CEILING LIGHT FIXTURE
	250mm DIA. EXHAUST FAN
	15A SWITCH SOCKET OUTLET
	5/15A SWITCH SOCKET OUTLET
	5/15A SWITCH SOCKET OUTLET
	1.No-T.V. OUTLET
	TELEPHONE OUTLET
	CEILING FAN
	BOLLARD LIGHT
	POLE LIGHT

ELECTRICAL LAYOUT
SCALE=1:100

ELECTRICAL LAYOUT

PROPOSED HOUSING SCHEME AT VILLAGE- JAITYKHERA, PARGANA-BIJNAUR, TEHSIL-SAROJINI NAGAR, LUCKNOW INDUSTRIAL DEVELOPMENT AUTHORITY AREA, LUCKNOW	PROMOTER: <i>Eldeco Housing & Industries Ltd.</i>		 Ar. Sanjay Kumar Gupta 108.F. Floor, Corporate Chamber-1, Vibhuti Khand, Gomti Nagar, Lucknow-226010 Ph. No. +905958, 9415114589 email-espaces.arch@gmail.com
	DRG.NO.: services/04	SCALE: 1:100	DEVELOPER:
	NOTES: 1. Architect shall not be responsible for any deviation at site by the developer. 2. DEVELOPER SHALL ENSURE LEGAL POSSESSION OF PLOT BEFORE U.P.S.I.D.A. SUBMISSION. 3. Layout approved vide permit no.2095, dated 16.03.2021.		

NOT FOR CONSTRUCTION