


2 4 M W I D E R O A D

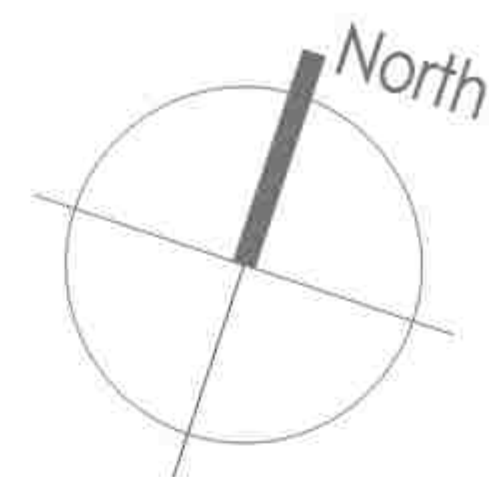

PLUMBING SERVICES LEGEND	
	STORM WATER MANHOLE (800 x 800) MM
	SEWER MANHOLE (800 x 800) MM
	EXTERNAL SEWER LINE
	EXTERNAL STORM WATER LINE
	DOMESTIC WATER SUPPLY LINE
	FLUSHING WATER SUPPLY LINE
	EXTERNAL FIRE HYDRANT LINE
	MUNICIPAL LINE WATER SUPPLY
	GARDEN IRRIGATION WATER SUPPLY LINE
	EXTERNAL FIRE HYDRANT (750x800x250) MM
	GARDEN HYDRANT
	D.T. (DISPERSION TRENCH SIZE) (5000X2300) MM
	D.C. (DESLEUDGING CHAMBER) (2500 X 1500) MM
	VALVE WITH CHAMBER
	NON RETURN VALVE WITH CHAMBER (N.R.V.)

SUBMISSION DRAWING



SITE PLAN
SEWER LAYOUT



No	Date	Description
Revisions		

PLUMBING SERVICES LEGEND:	
	STORM WATER MANHOLE (800 x 800) MM
	STORM WATER MANHOLE (800 x 800) MM
	SEWER MANHOLE (800 x 900) MM
	SEWER MANHOLE (800 x 800) MM
	EXTERNAL SEWER LINE
	EXTERNAL STORM WATER LINE
	DOMESTIC WATER SUPPLY LINE
	FLUSHING WATER SUPPLY LINE
	EXTERNAL FIRE HYDRANT LINE
	MUNICIPAL LINE WATER SUPPLY
	MUNICIPAL LINE WATER SUPPLY
	GARDEN IRRIGATION WATER SUPPLY LINE
	EXTERNAL FIRE HYDRANT (750X900X250) MM
	GARDEN HYDRANT
	DISPERSION TRENCH SIZE: (500X1250) MM.
	DISINFECTION CHAMBER (2500 X 1500) MM
	VALVE WITH CHAMBER
	NON RETURN VALVE WITH CHAMBER (N.R.V.)

No	Date	Description
Revisions		

Drawing Status

SUBMISSION DRAWING

Key Plan

The Key Plan shows the overall layout of the site. It includes the proposed road, existing roads, and surrounding areas. The plan is color-coded to show different types of land use and infrastructure. A north arrow is located in the bottom right corner of the plan.

Project Name
ELDECO WHISPERS OF WONDER

Project Address
PLOT NO. GH-1A/2, SEC. 22D, YAMUNA EXPRESS WAY
INDUSTRIAL DEVELOPMENT AUTHORITY, GAUTAM BUD
NAGAR, U.P. -203201

Drawing Title

**SITE PLAN
STORM WATER LAYOUT**

Project No	24.ED2.GN
------------	-----------


Scale 1:300


Date MAY 07, 2025

Drawing No PL-PC-EWOW-SITE-STORM-102


XX	XX	X	XXX	
----	----	---	-----	--

SHEET SIZE A1 : 841 X 594

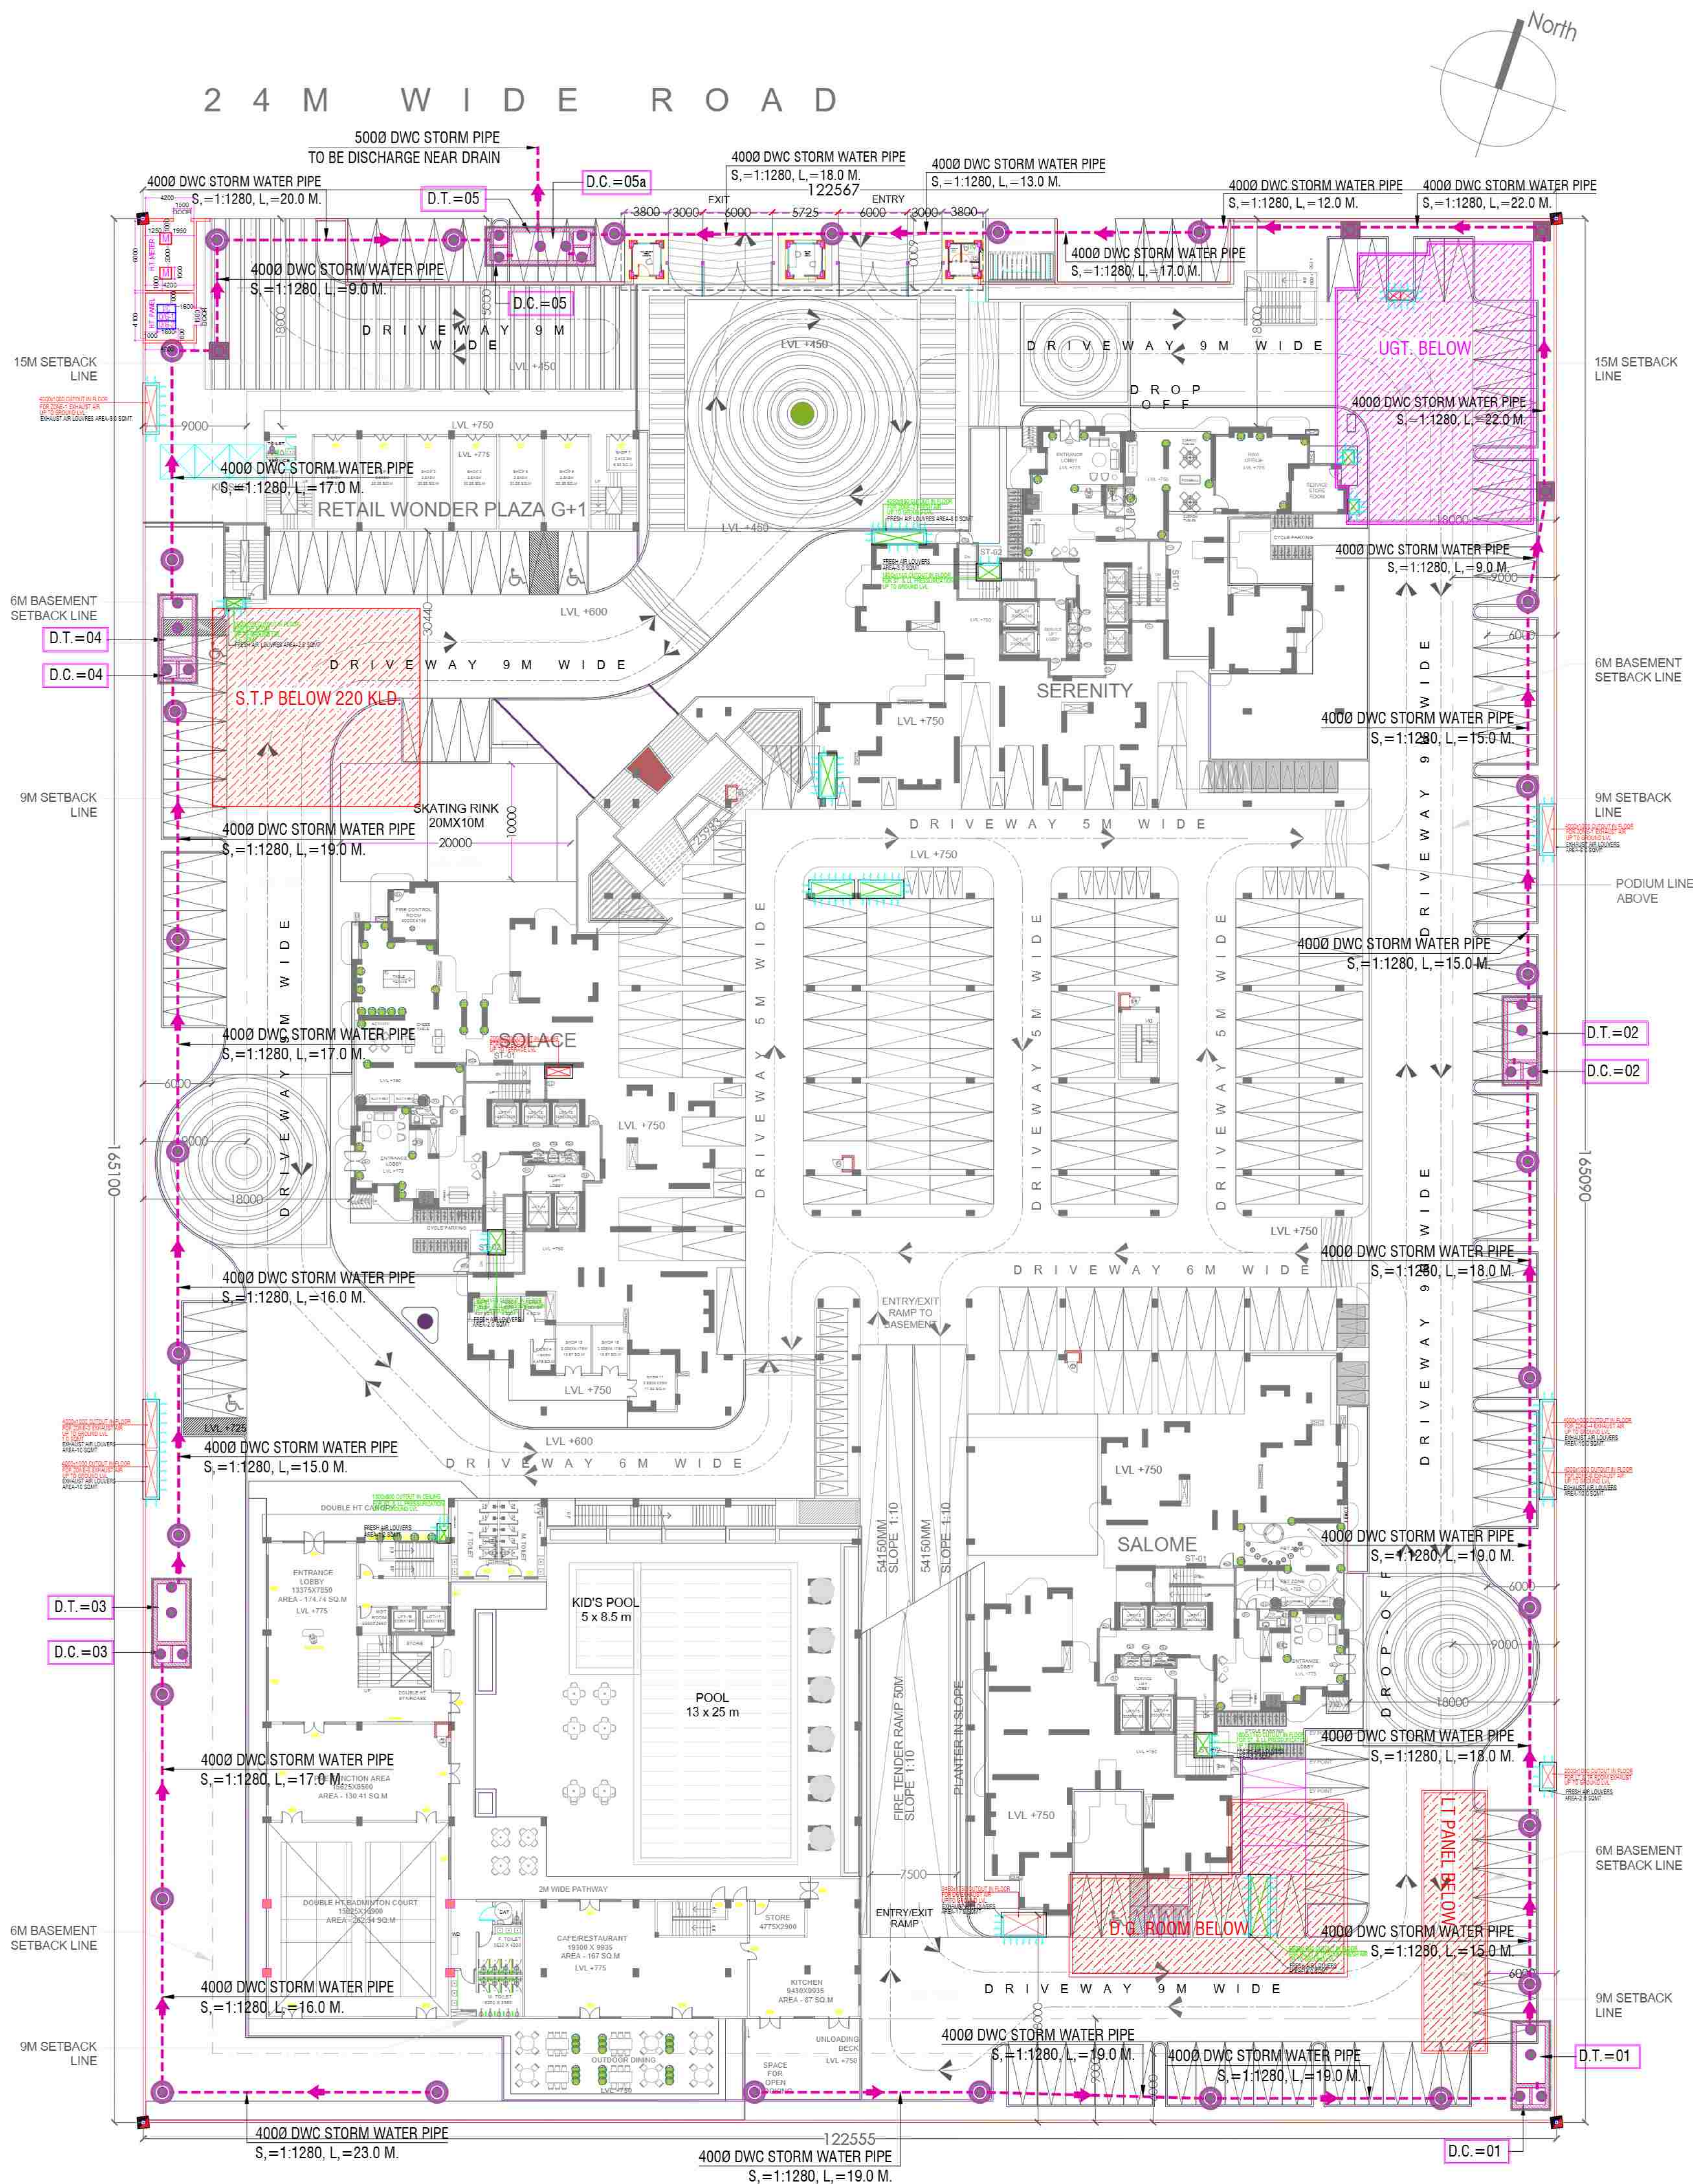


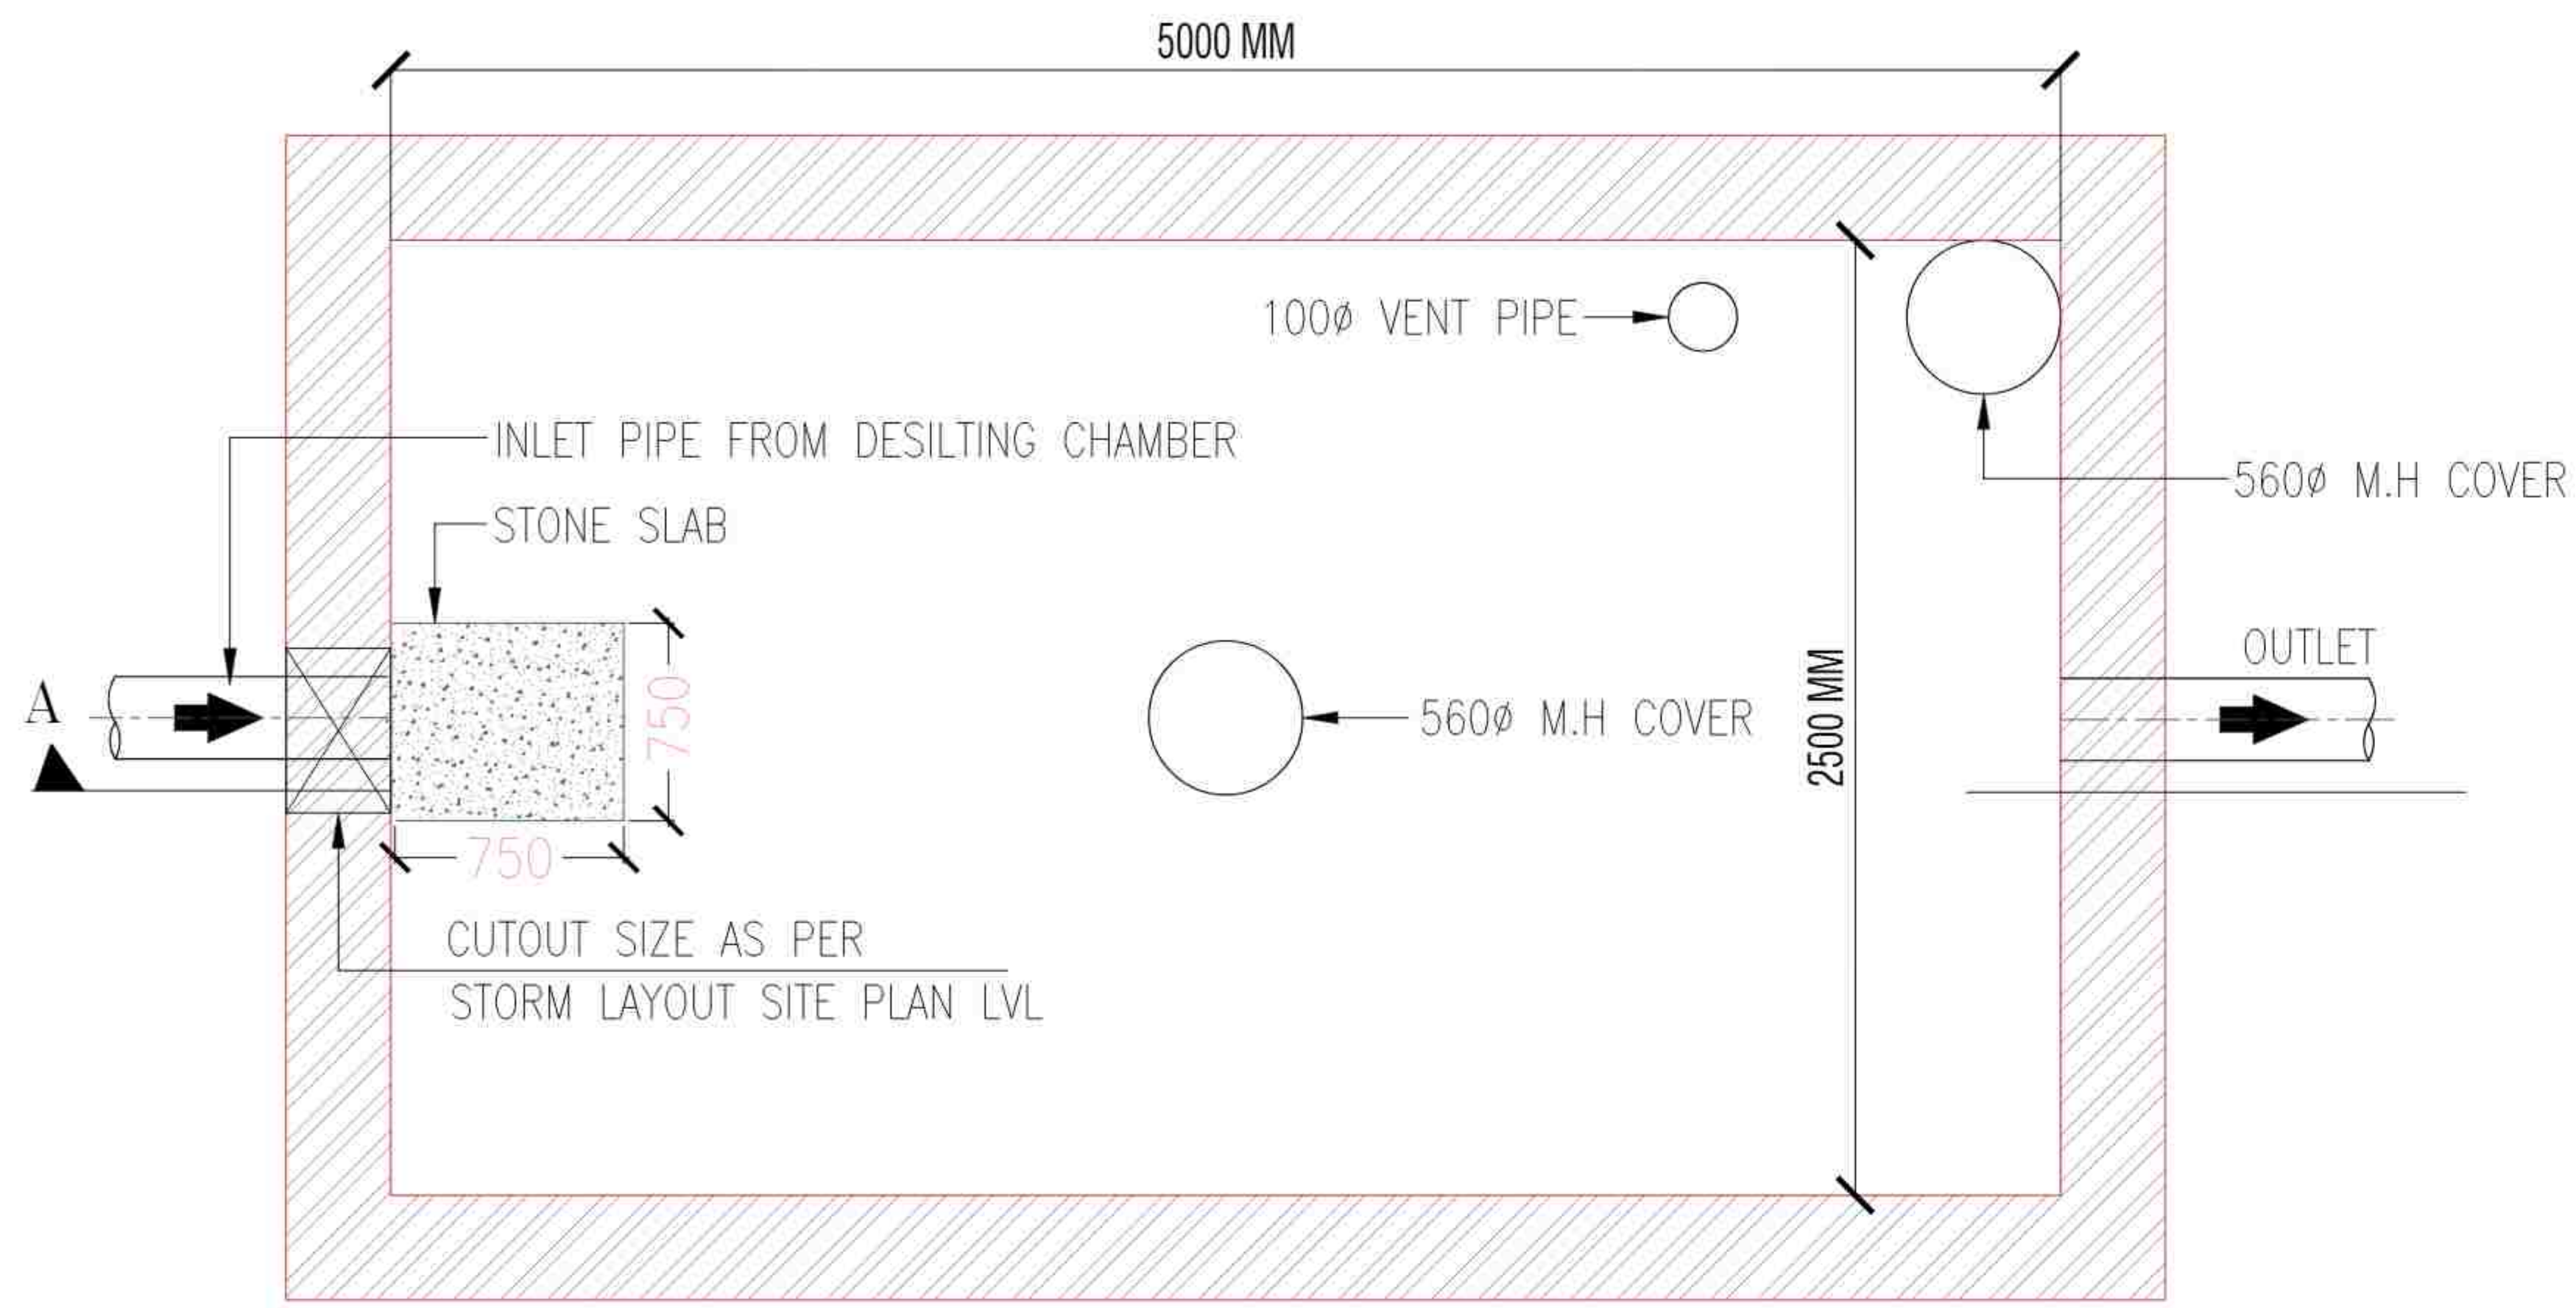


PLAN OF RECHARGE WELL

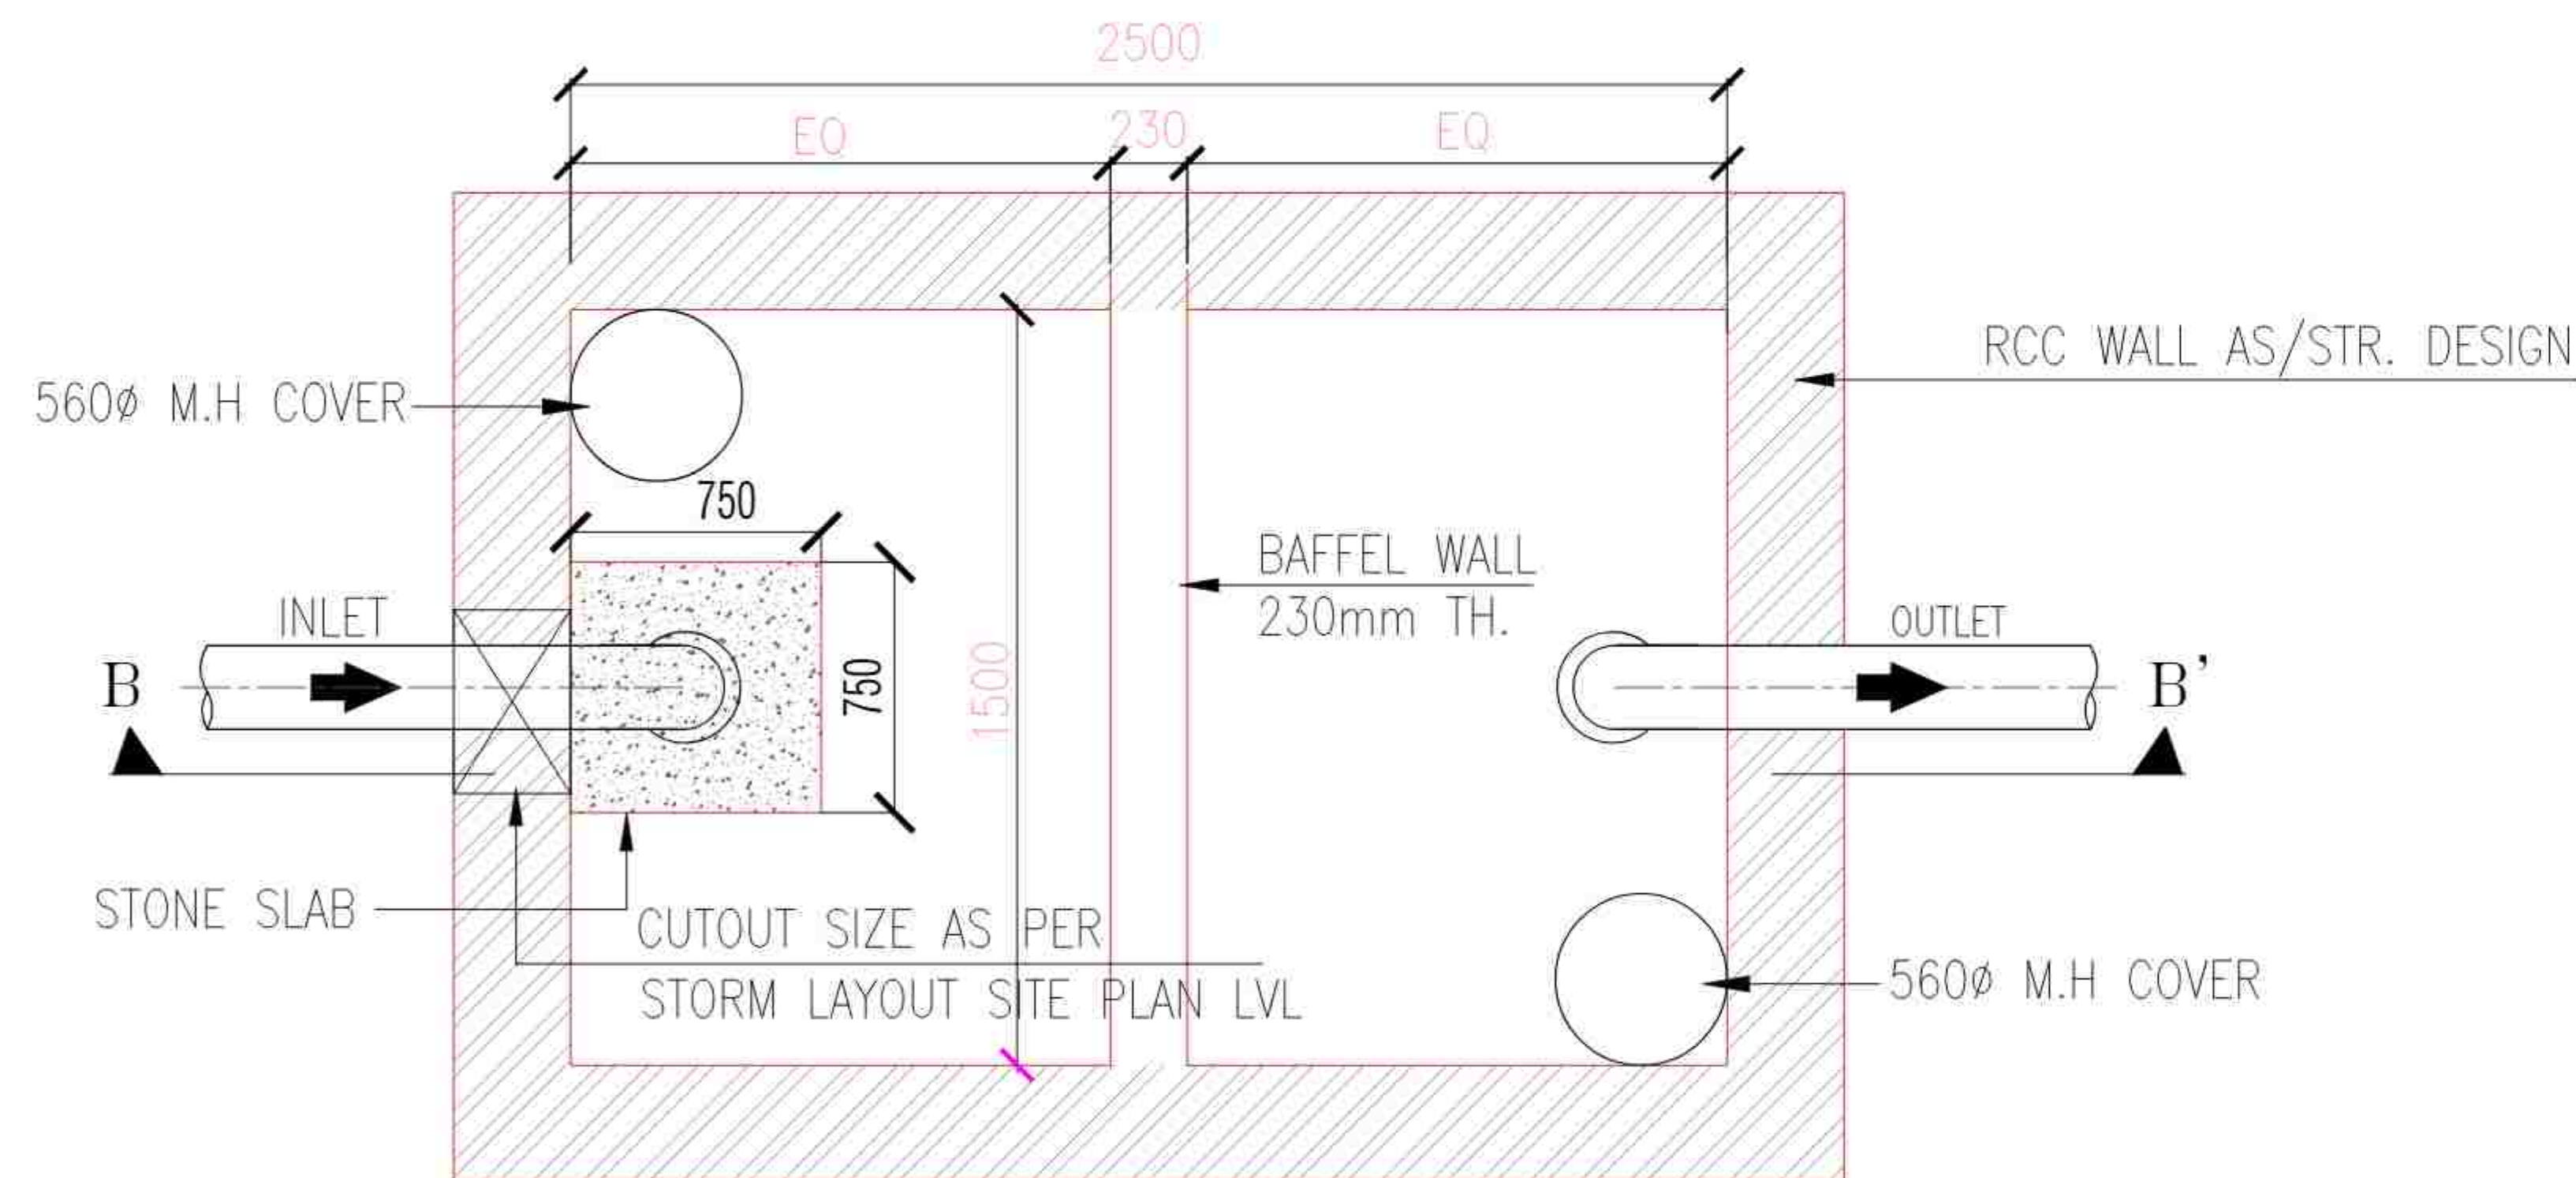

PLAN OF DESILTING CHAMBER

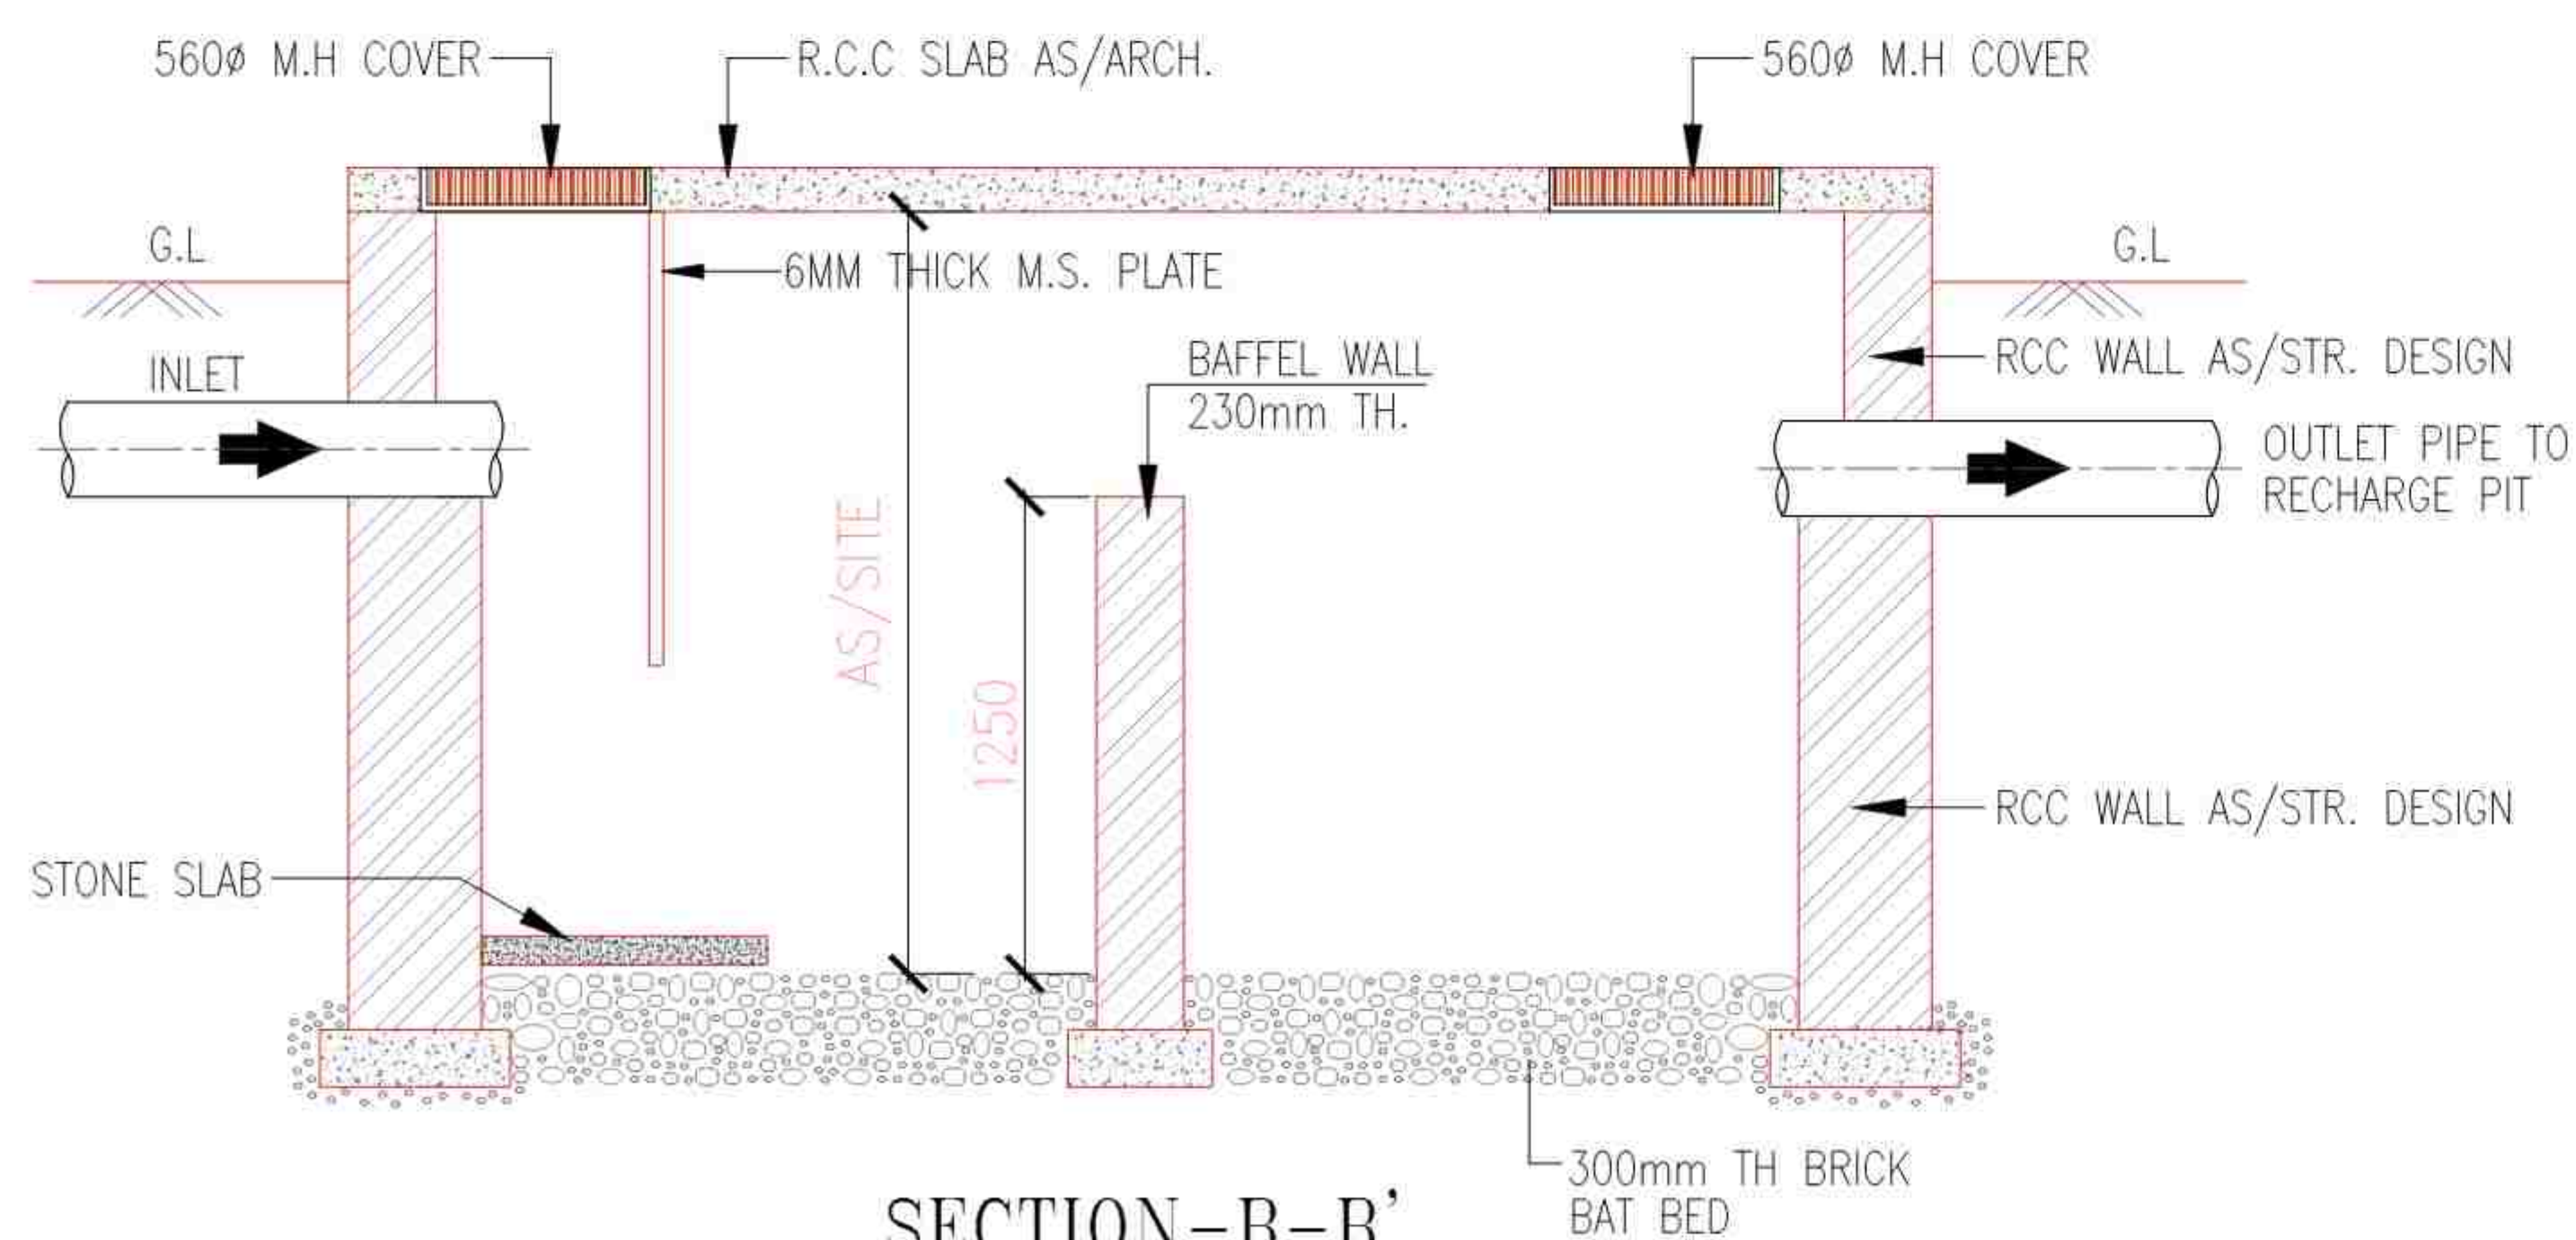

SECTION-B-B'

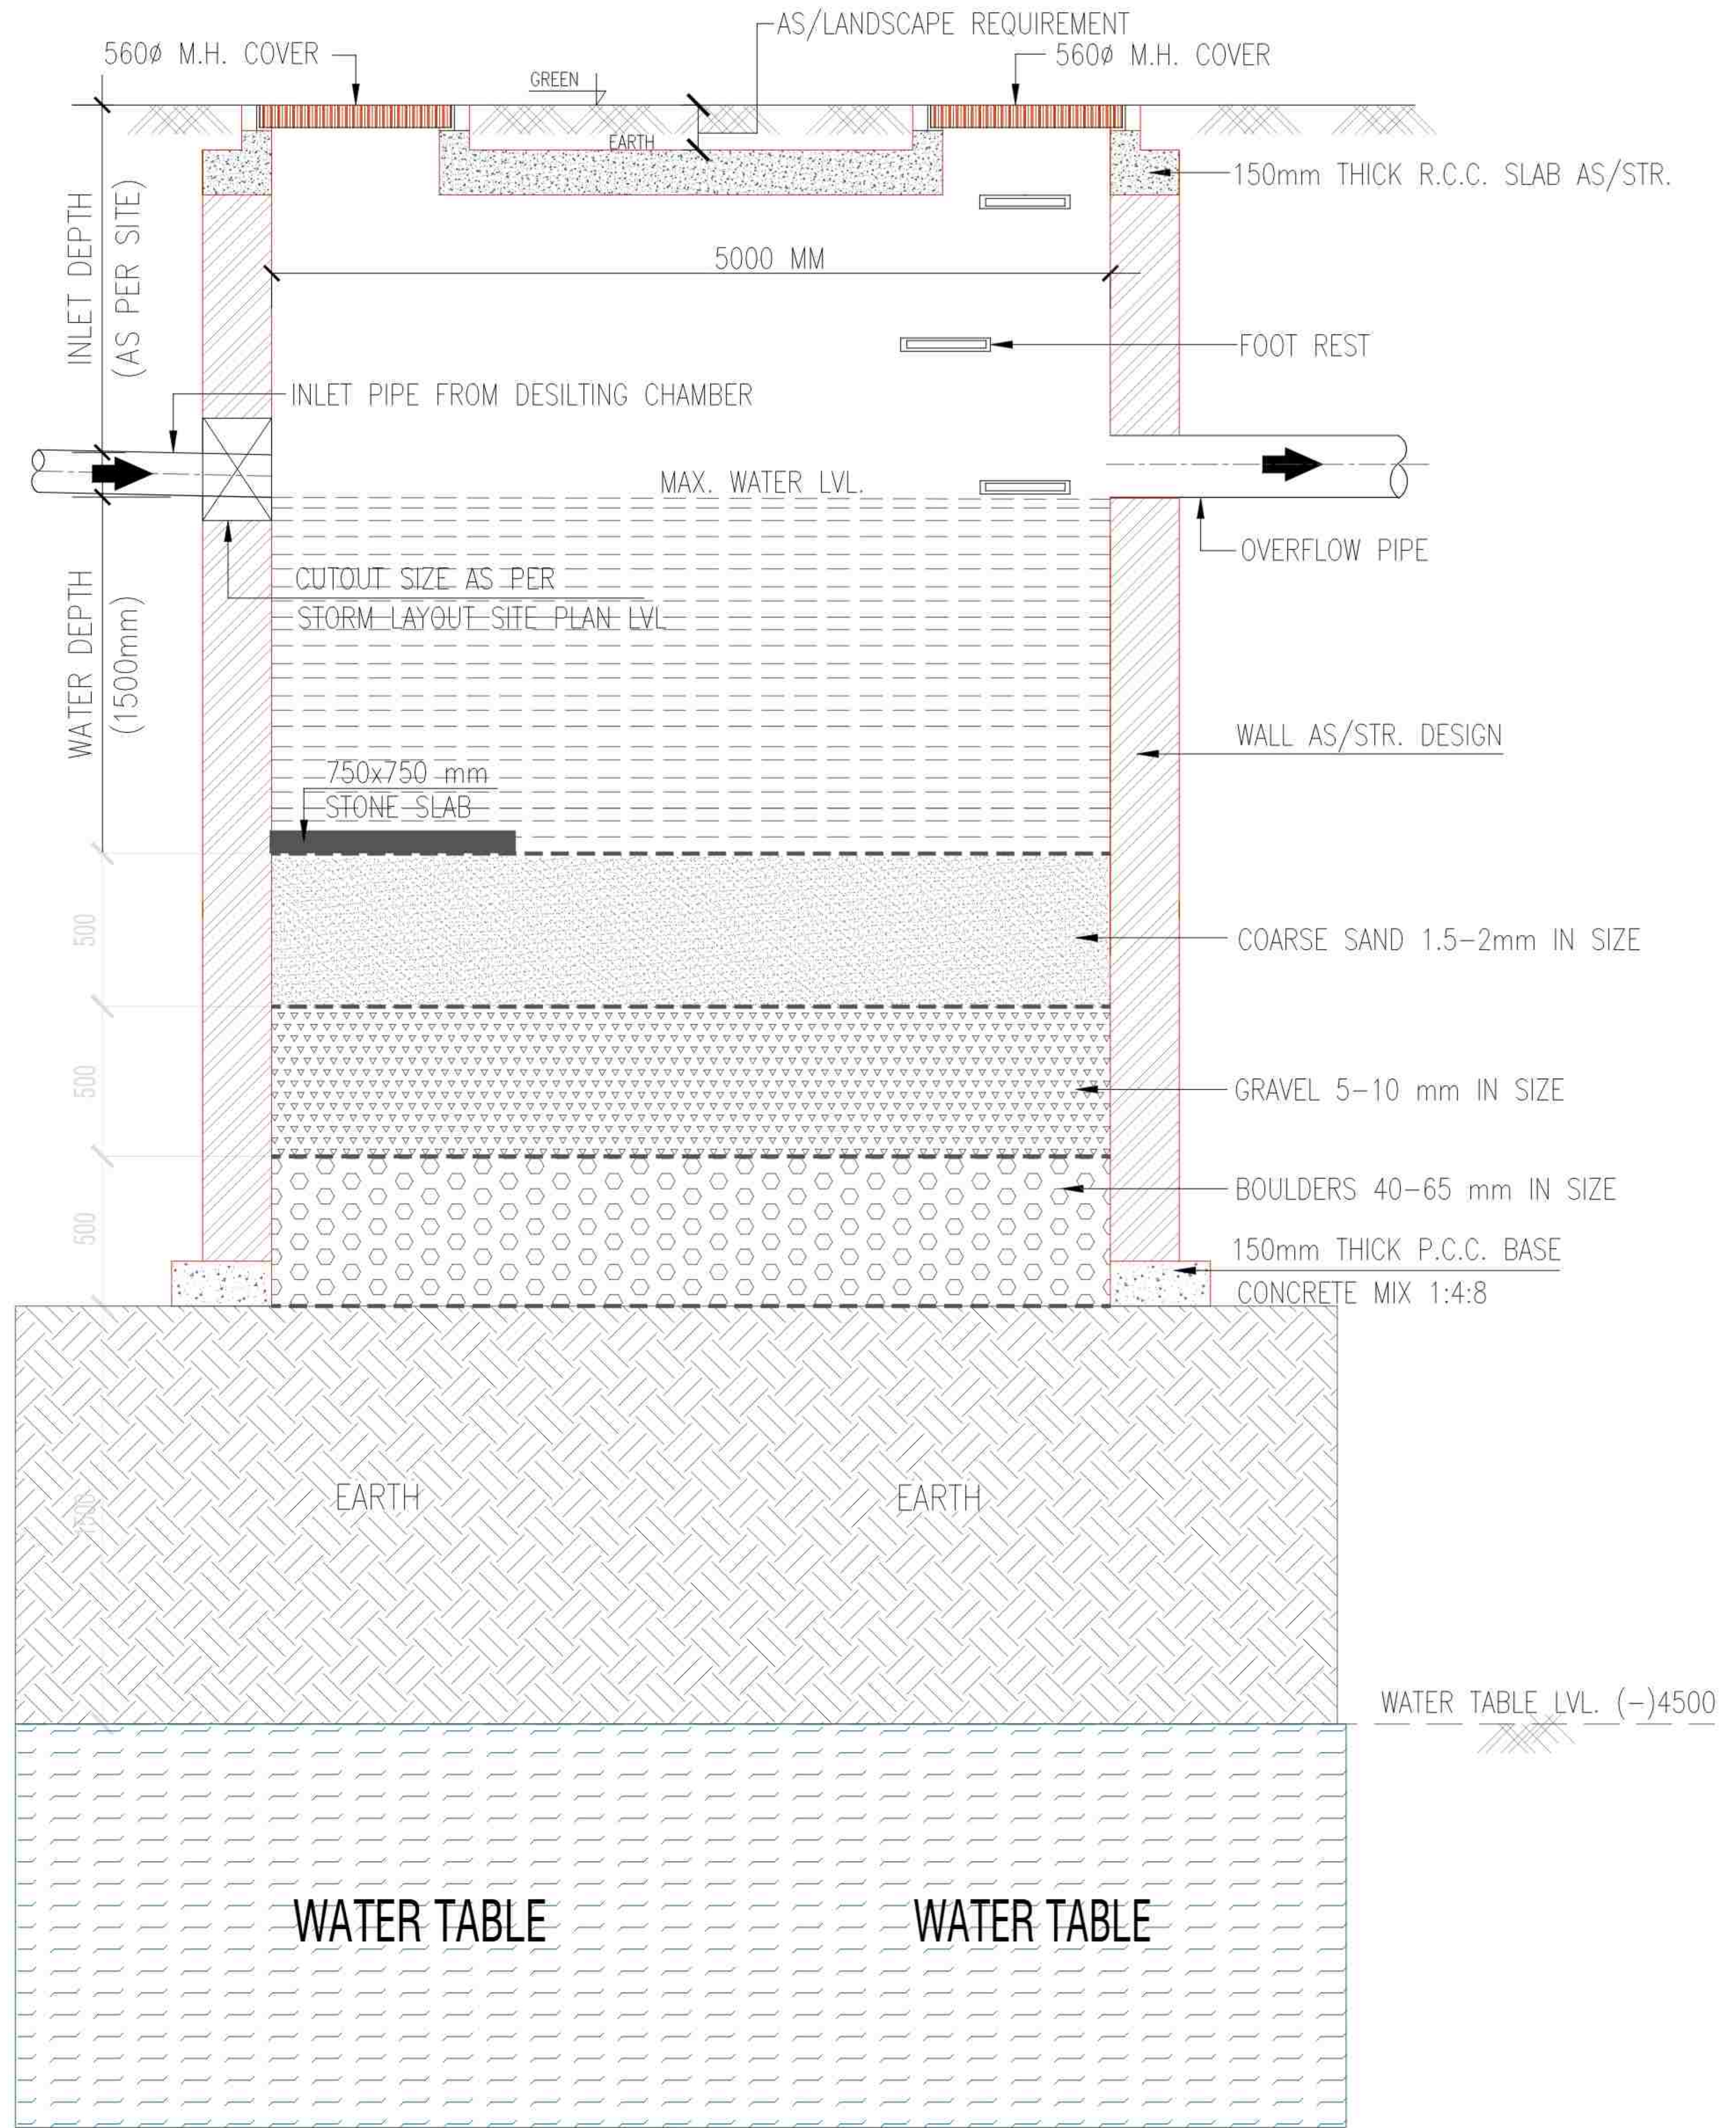

SECTION-A-A'



ELDECO SONNA PROJECTS LTD.
201-212-2nd Floor, Splendor Forum,
Jasola District Centre, New Delhi - 110 025

Architect
ARCOP

ARCOP ASSOCIATES PVT LTD
Plot No. 368, Sector-32, Institutional Area, Gurugram, Haryana
122001, India
Tel: 91-124-4595500
91-124-4595550
Fax: 91-124-4595550

MEP Consultant
PARADISE CONSULTANTS
PLOT NO. 129, POCHE-2, BASEMENT
JASOLA VILLAGE, NEW DELHI-110025
PH: 011-45132800, 41030619
E-mail: mep@paradisiconsultants.com


Disclaimer
Drawings and written material appearing herein constitute original and unpublished work of the Consultant and may not be duplicated, used or disclosed without written consent of the Consultant.

Notes
1. Unless otherwise mentioned all dimensions are in Millimeters.
2. Unless otherwise mentioned all levels including finished floor levels are in Meters.
3. Unless otherwise mentioned all dimensions are shown exclusive of finishes & frames.
4. Dimensions are not to be scaled from the drawing.
5. Any discrepancies, either between written dimensions and the dimensions or within these drawings should be brought to the immediate attention of the consultant before executing the works.
6. This drawing is to be read in conjunction with all other documentation forming the construction document.

No	Date	Description

Revisions

Drawing Status
SUBMISSION DRAWING

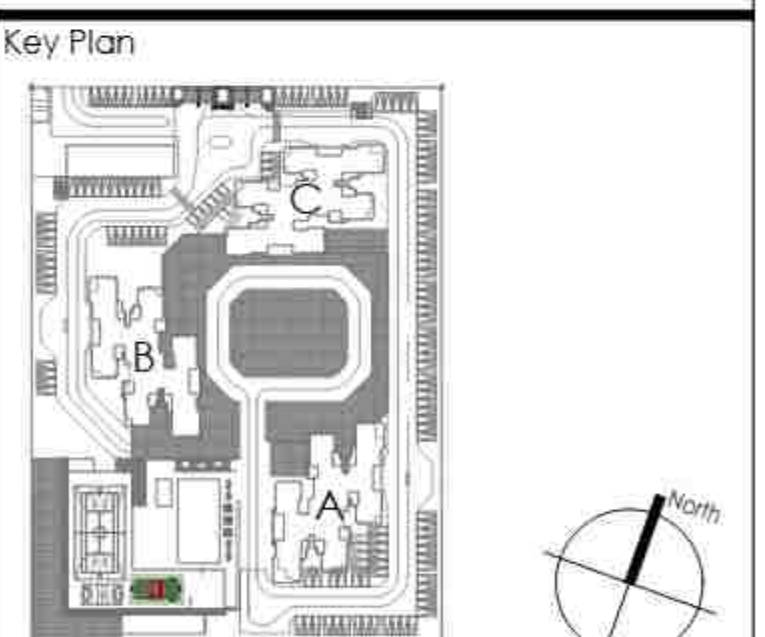

Project Name
ELDECO WHISPERS OF WONDER

Project Address
PLOT NO. GH-01C/1 SECTOR-22D, YEIDA, GAUTAM
BUDDHA NAGAR, UTTAR PRADESH-201308

Drawing Title
**DISPERSION TRENCH & DESILTING
CHAMBER DETAIL**

Project No. 24.ED2.GN
Scale 1:100
Date MAY 06, 2025
Drawing No. PL-PC-EH-STD-101

XX XX X XXX

SHEET SIZE A1 : 841 X 594