

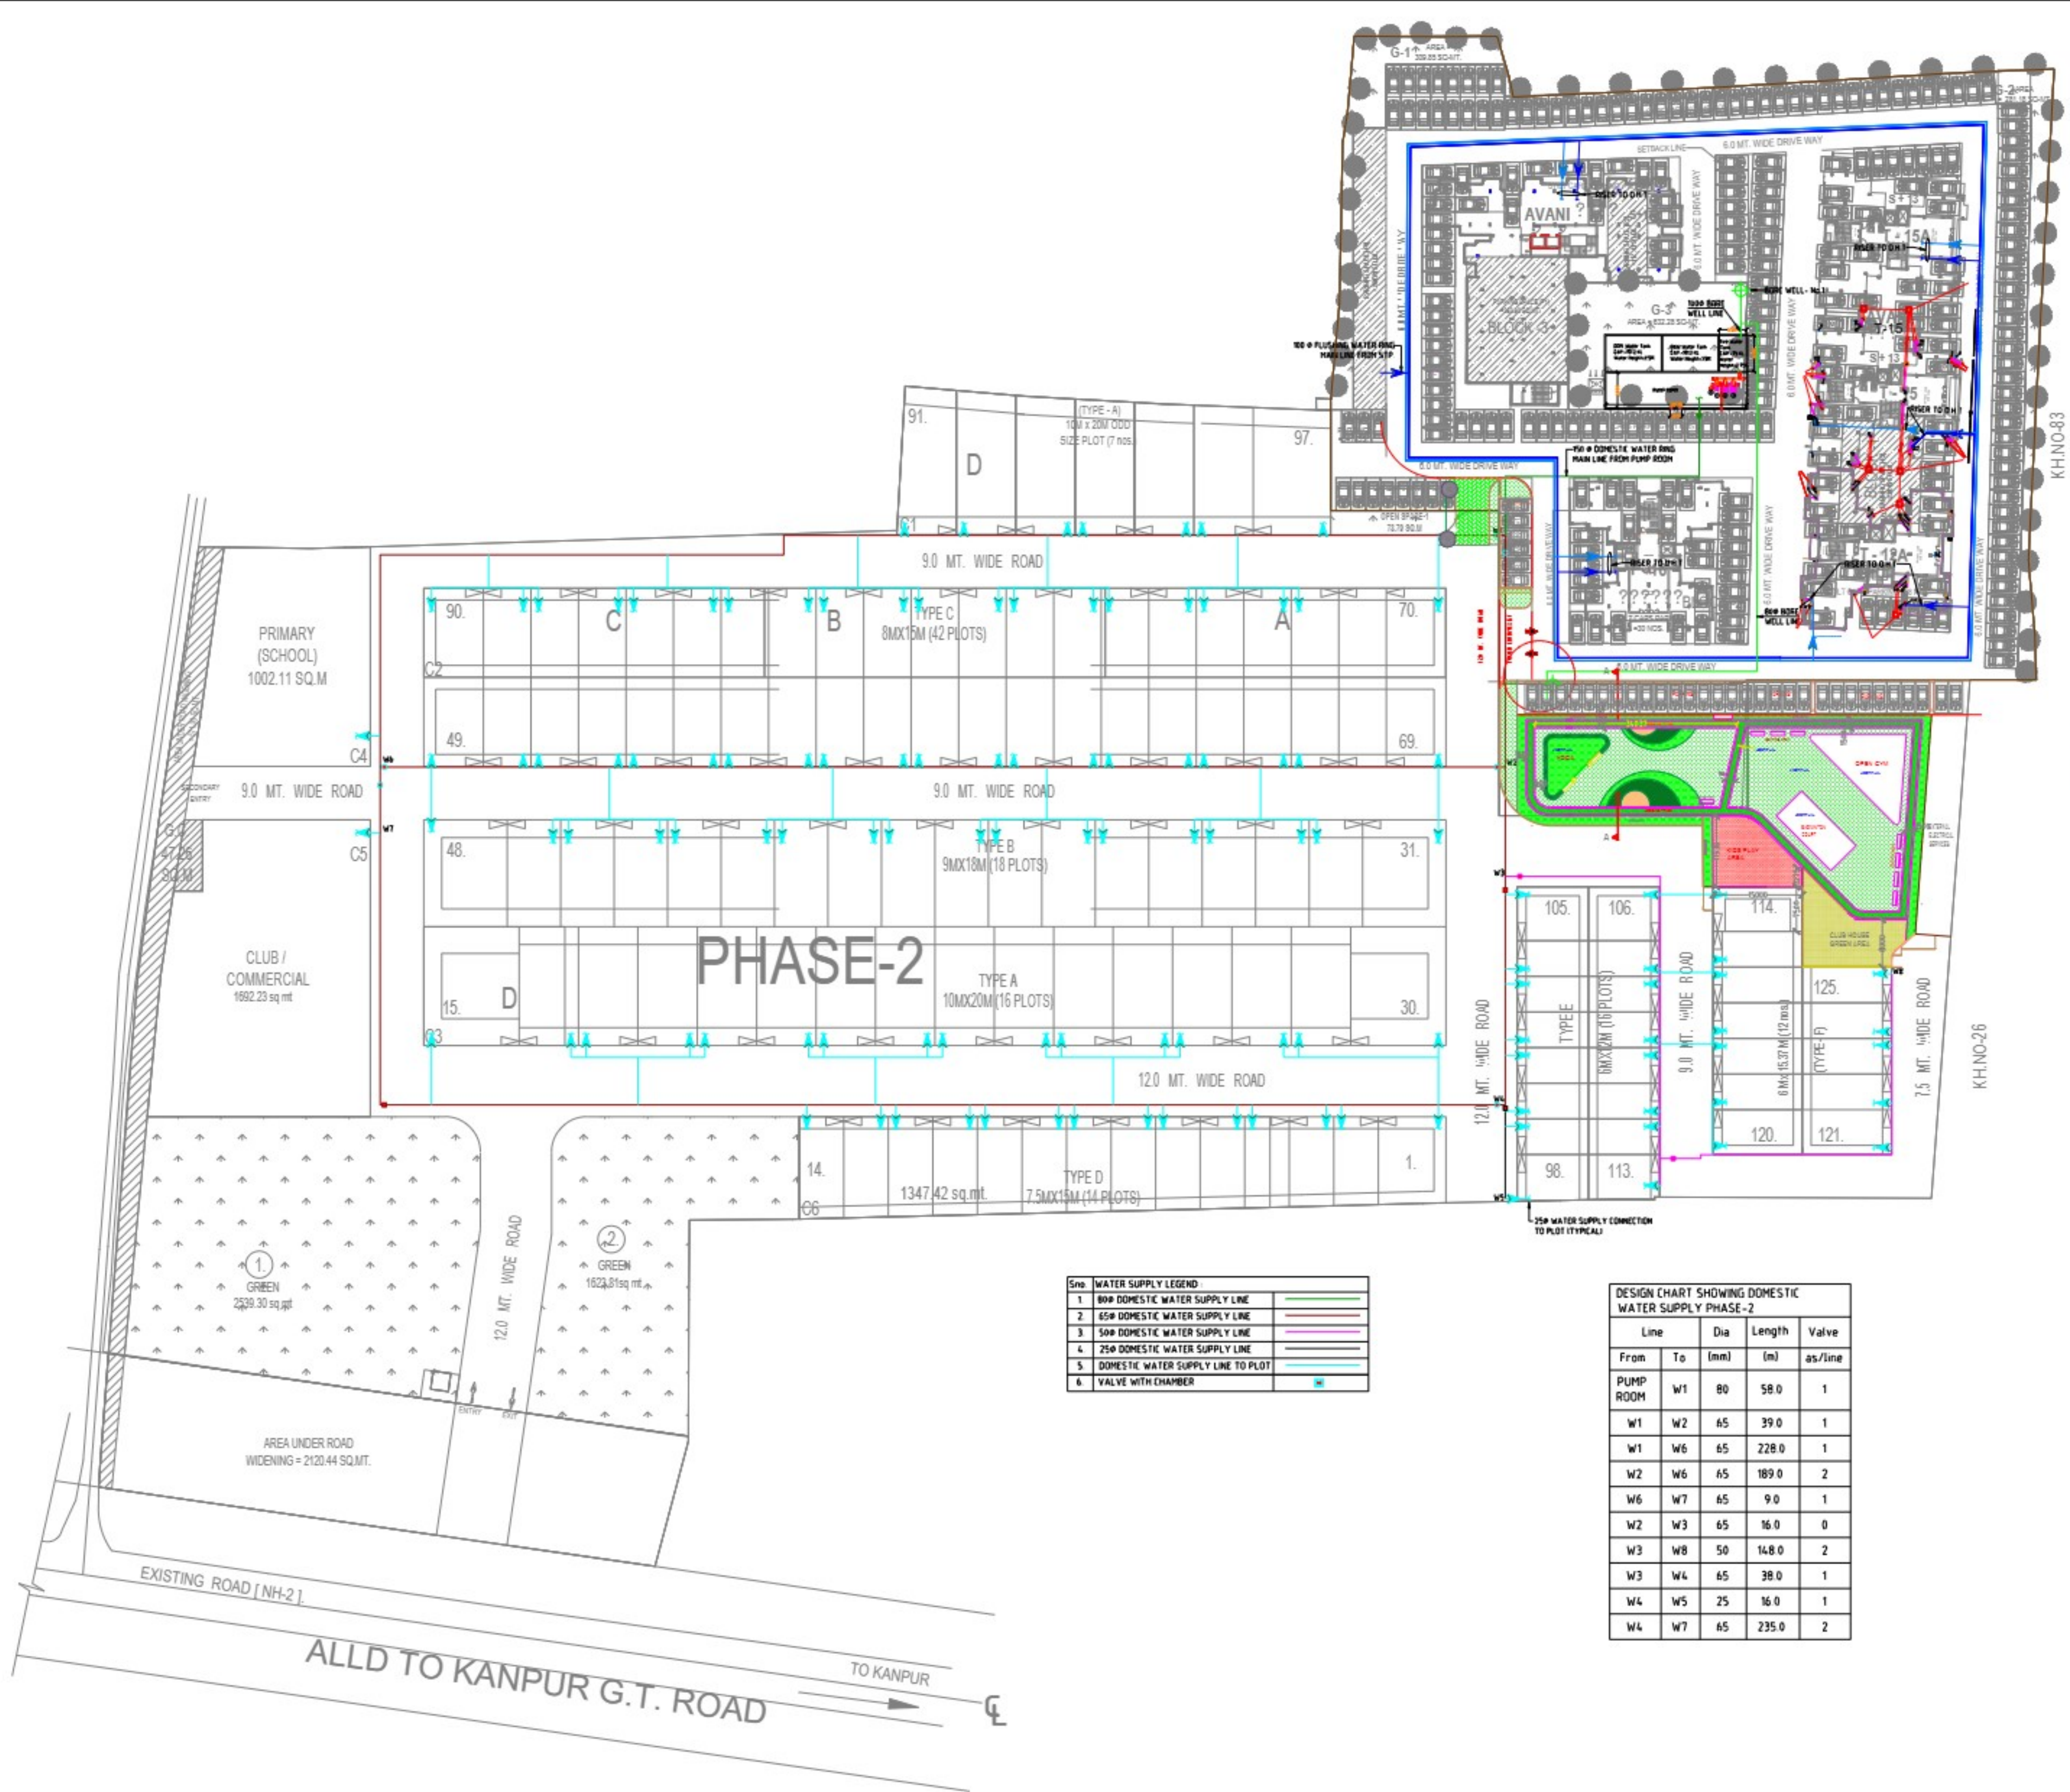


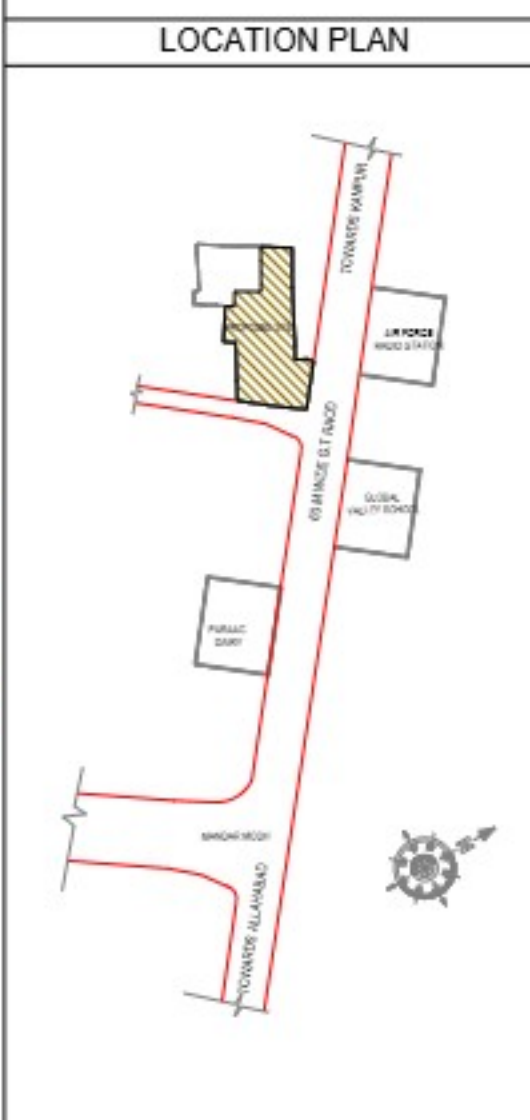

Sno	WATER SUPPLY LEGEND
1	800 DOMESTIC WATER SUPPLY LINE
2	650 DOMESTIC WATER SUPPLY LINE
3	500 DOMESTIC WATER SUPPLY LINE
4	250 DOMESTIC WATER SUPPLY LINE
5	DOMESTIC WATER SUPPLY LINE TO PLOT
6	VALVE WITH CHAMBER

DESIGN CHART SHOWING DOMESTIC WATER SUPPLY PHASE-2				
Line	Dia	Length	Valve	
From	To	(mm)	(m)	as/line
PUMP ROOM	W1	80	58.0	1
W1	W2	65	39.0	1
W1	W6	65	228.0	1
W2	W6	65	189.0	2
W6	W7	65	9.0	1
W2	W3	65	16.0	0
W3	W8	50	148.0	2
W3	W4	65	38.0	1
W4	W5	25	16.0	1
W4	W7	65	235.0	2

NOTES
This drawing is a "COPYRIGHT" contents of this drawing or part thereof may not be used or reproduced without the permission of the Architect.

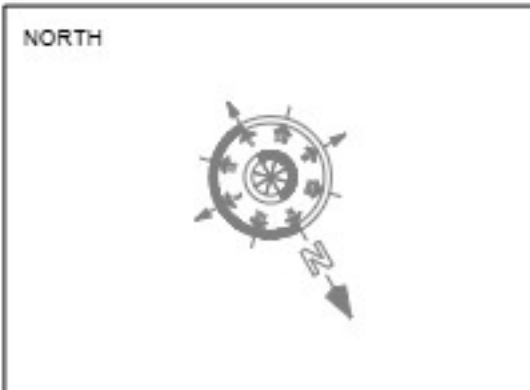

SUBMISSION DRAWING
;g ekulp= bykgckn egk;kstuk 2021 rfkk
Hkou mifot/k 2008 rfkk IE;d 'kklukns'kkso
ds vuqi rS;kj fd;k x;k gSA

DEVELOPER NEW MODERN BUILDWELL PVT. LTD. B-65, FIRST FLOOR, ARCADE PLAZA, BANGALURU, INDIA-560002	SIGNATURES
ARCHITECT	SIGNATURES


CONSULTANT REPL Rudrabhishik Enterprises Ltd. A - 8, SECTOR - 58 NOIDA - 201301, U. P. PH 0120 - 4022332 FAX 0120 - 4022301	SIGNATURES
--	------------

PROJECT
PROPOSED LAYOUT PLAN ON KHA 8RA NO. 23, 24, 25 & 84 IN VILLAGE WAJIDPUR & KHA 8RA NO. 48 P & 47 IN VILLAGE MUIDINPUR AT ALLAHABAD-KANPUR ROAD(NH-2), ALLAHABAD.

DRAWING TITLE
DOMESTIC WATER SUPPLY SERVICES LAYOUT PLAN

SCALE NTS.	DATE 27.08.2020
---------------	--------------------

DRAWING NUMBER
NAVYUG/SUB/PL/103

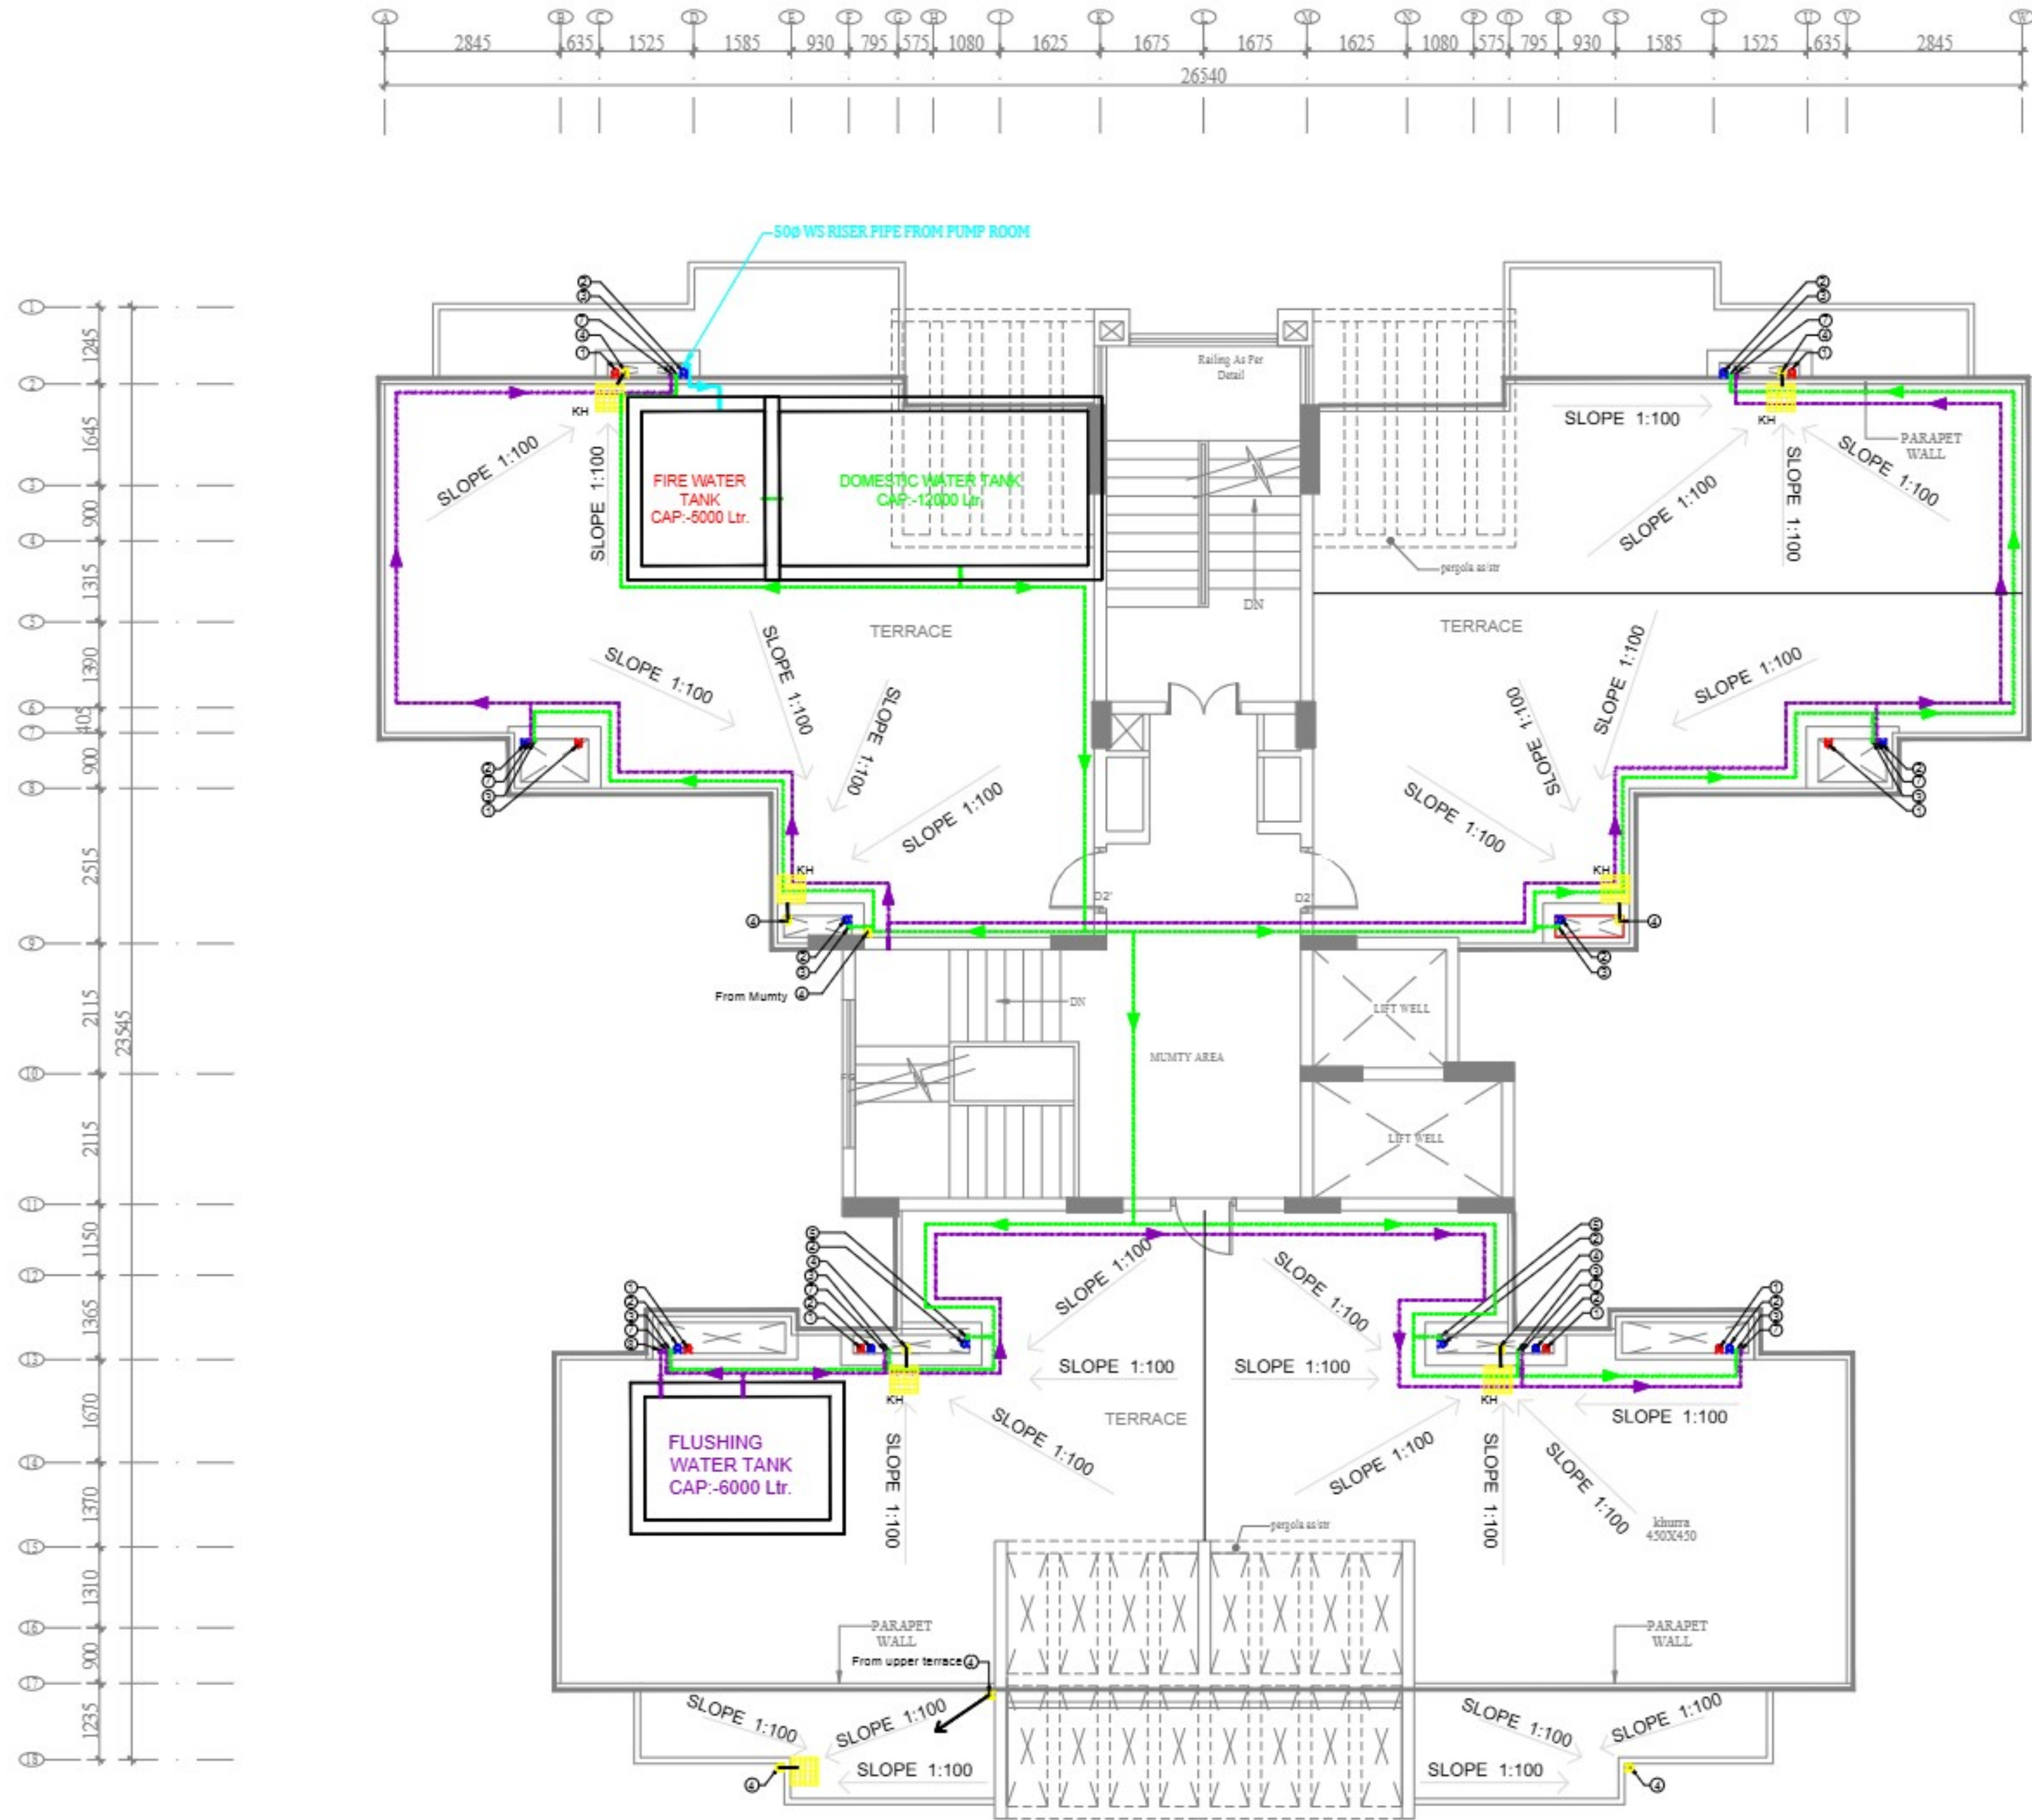

TERRACE FLOOR PLAN

- NOTES
1. ALL DIMENSIONS ARE IN MM AND SHOULD BE READ, NOT SCALED.
 2. THIS DRG. IS TO BE READ IN CONJUNCTION WITH RELEVANT ARCHITECTURAL AND SERVICES DRAWINGS.
 3. DOORS AND WINDOWS OPENINGS DENOTE FINISHED MASONRY OPENINGS ONLY.
 4. (FINISHED) MASONRY OPENING TO BE CHECKED AT SITE.
 5. THIS DRAWING IS EXCLUSIVE PROPERTY OF REPL AND SHOULD NOT BE REPRINTED, REPRODUCED IN ANY FORM WITHOUT THE WRITTEN PERMISSION OF THE ARCHITECT.
 6. CONTRACTOR SHALL VERIFY AND BE RESPONSIBLE FOR ALL DIMENSIONS ON SITE.
 7. ANY DISCREPANCY AT SITE SHOULD BE BROUGHT TO THE NOTICE OF THE ARCHITECT IMMEDIATELY.
 8. ANY REVISED DRAWINGS ISSUED ON SITE WILL SUPERSEDE ALL PREVIOUS ISSUED DRAWINGS.

LEGEND:- (sanitary)

S.NO.	SYMBOL	DESCRIPTION
1.		110 Ø UPVC SOIL PIPE
2.		110 Ø UPVC WASTE PIPE
3.		DN TAKE CPVC WATER SUPPLY PIPE
4.		110 Ø UPVC RAIN WATER PIPE FROM TERRACE
5.		75 Ø UPVC RAIN WATER PIPE FROM BALCONY
6.		50 Ø CPVC WATER SUPPLY PIPE RISER PIPE
7.		DN TAKE CPVC WATER SUPPLY PIPE
8.		50 Ø CPVC FLUSHING WATER RISER PIPE
9.		150 Ø UPVC WASTE PIPE (FOR BALCONY W.M.)
10.		CPVC WATER SUPPLY PIPE
11.		CPVC HOT SUPPLY PIPE
12.		CPVC FLUSHING WATER SUPPLY PIPE
13.		110 Ø UPVC SOIL PIPE FROM WC TO STACK
14.		110 Ø UPVC WASTE PIPE FROM FT TO STACK
15.		63 Ø UPVC WASTE FROM FG TO FT
16.		50 Ø UPVC WASTE FROM SINK TO FT
17.		50 Ø UPVC WASTE FROM W.B. TO FT
18.		150 Ø UPVC RAIN WATER PIPE FROM M.H. TO M.H.
19.		150 Ø UPVC SOIL PIPE FROM M.H. TO M.H.
20.		MAN HOLE 600X800mm (Bewer)
21.		MAN HOLE 600X800mm (Drain)
22.		FLOOR TRAP
23.		FLOOR DRAIN
24.		GEYSER
25.		GULLY TRAP (200X300mm)
26.		CATCH BASIN (450X450X450mm)
27.		KHURRA (450X450 mm)

Drawing Released For :

☐ APPROVAL ☐ SUBMISSION

☐ ADVANCE COPY ☐ GFC

ISSUES

Date	By	Description
------	----	-------------

SERVICE & CONSULTANT

Ascentia Professional Services
India Pvt. Ltd.

APS

23VC, 1510, 14th Floor, Block-C,
Saijva Nxt, Indraprastha,
Gurgaon 201304 12P
Email: ascentia@apsindia.com

ARCHITECTS:-

DESIGN LAB
9/11, ASUBAKARPUR, DHOOMANGANJ
PRAYAGRAJ-211011

CLIENT

NEW MODERN
BUILDWELL PVT. LTD.

PROJECT

NEW MODERN

DRAWING TITLE

PLUMBING
Terrace Floor Plan (Tower-12 A)
Block-3 Aven (Type-3)




DATE: 14-07-2025

CHECKED BY: 14-07-2025

SCALE: 1:50

DRAWING NO: NMOR/ALD/T12A/PL-03

REVISIONS:

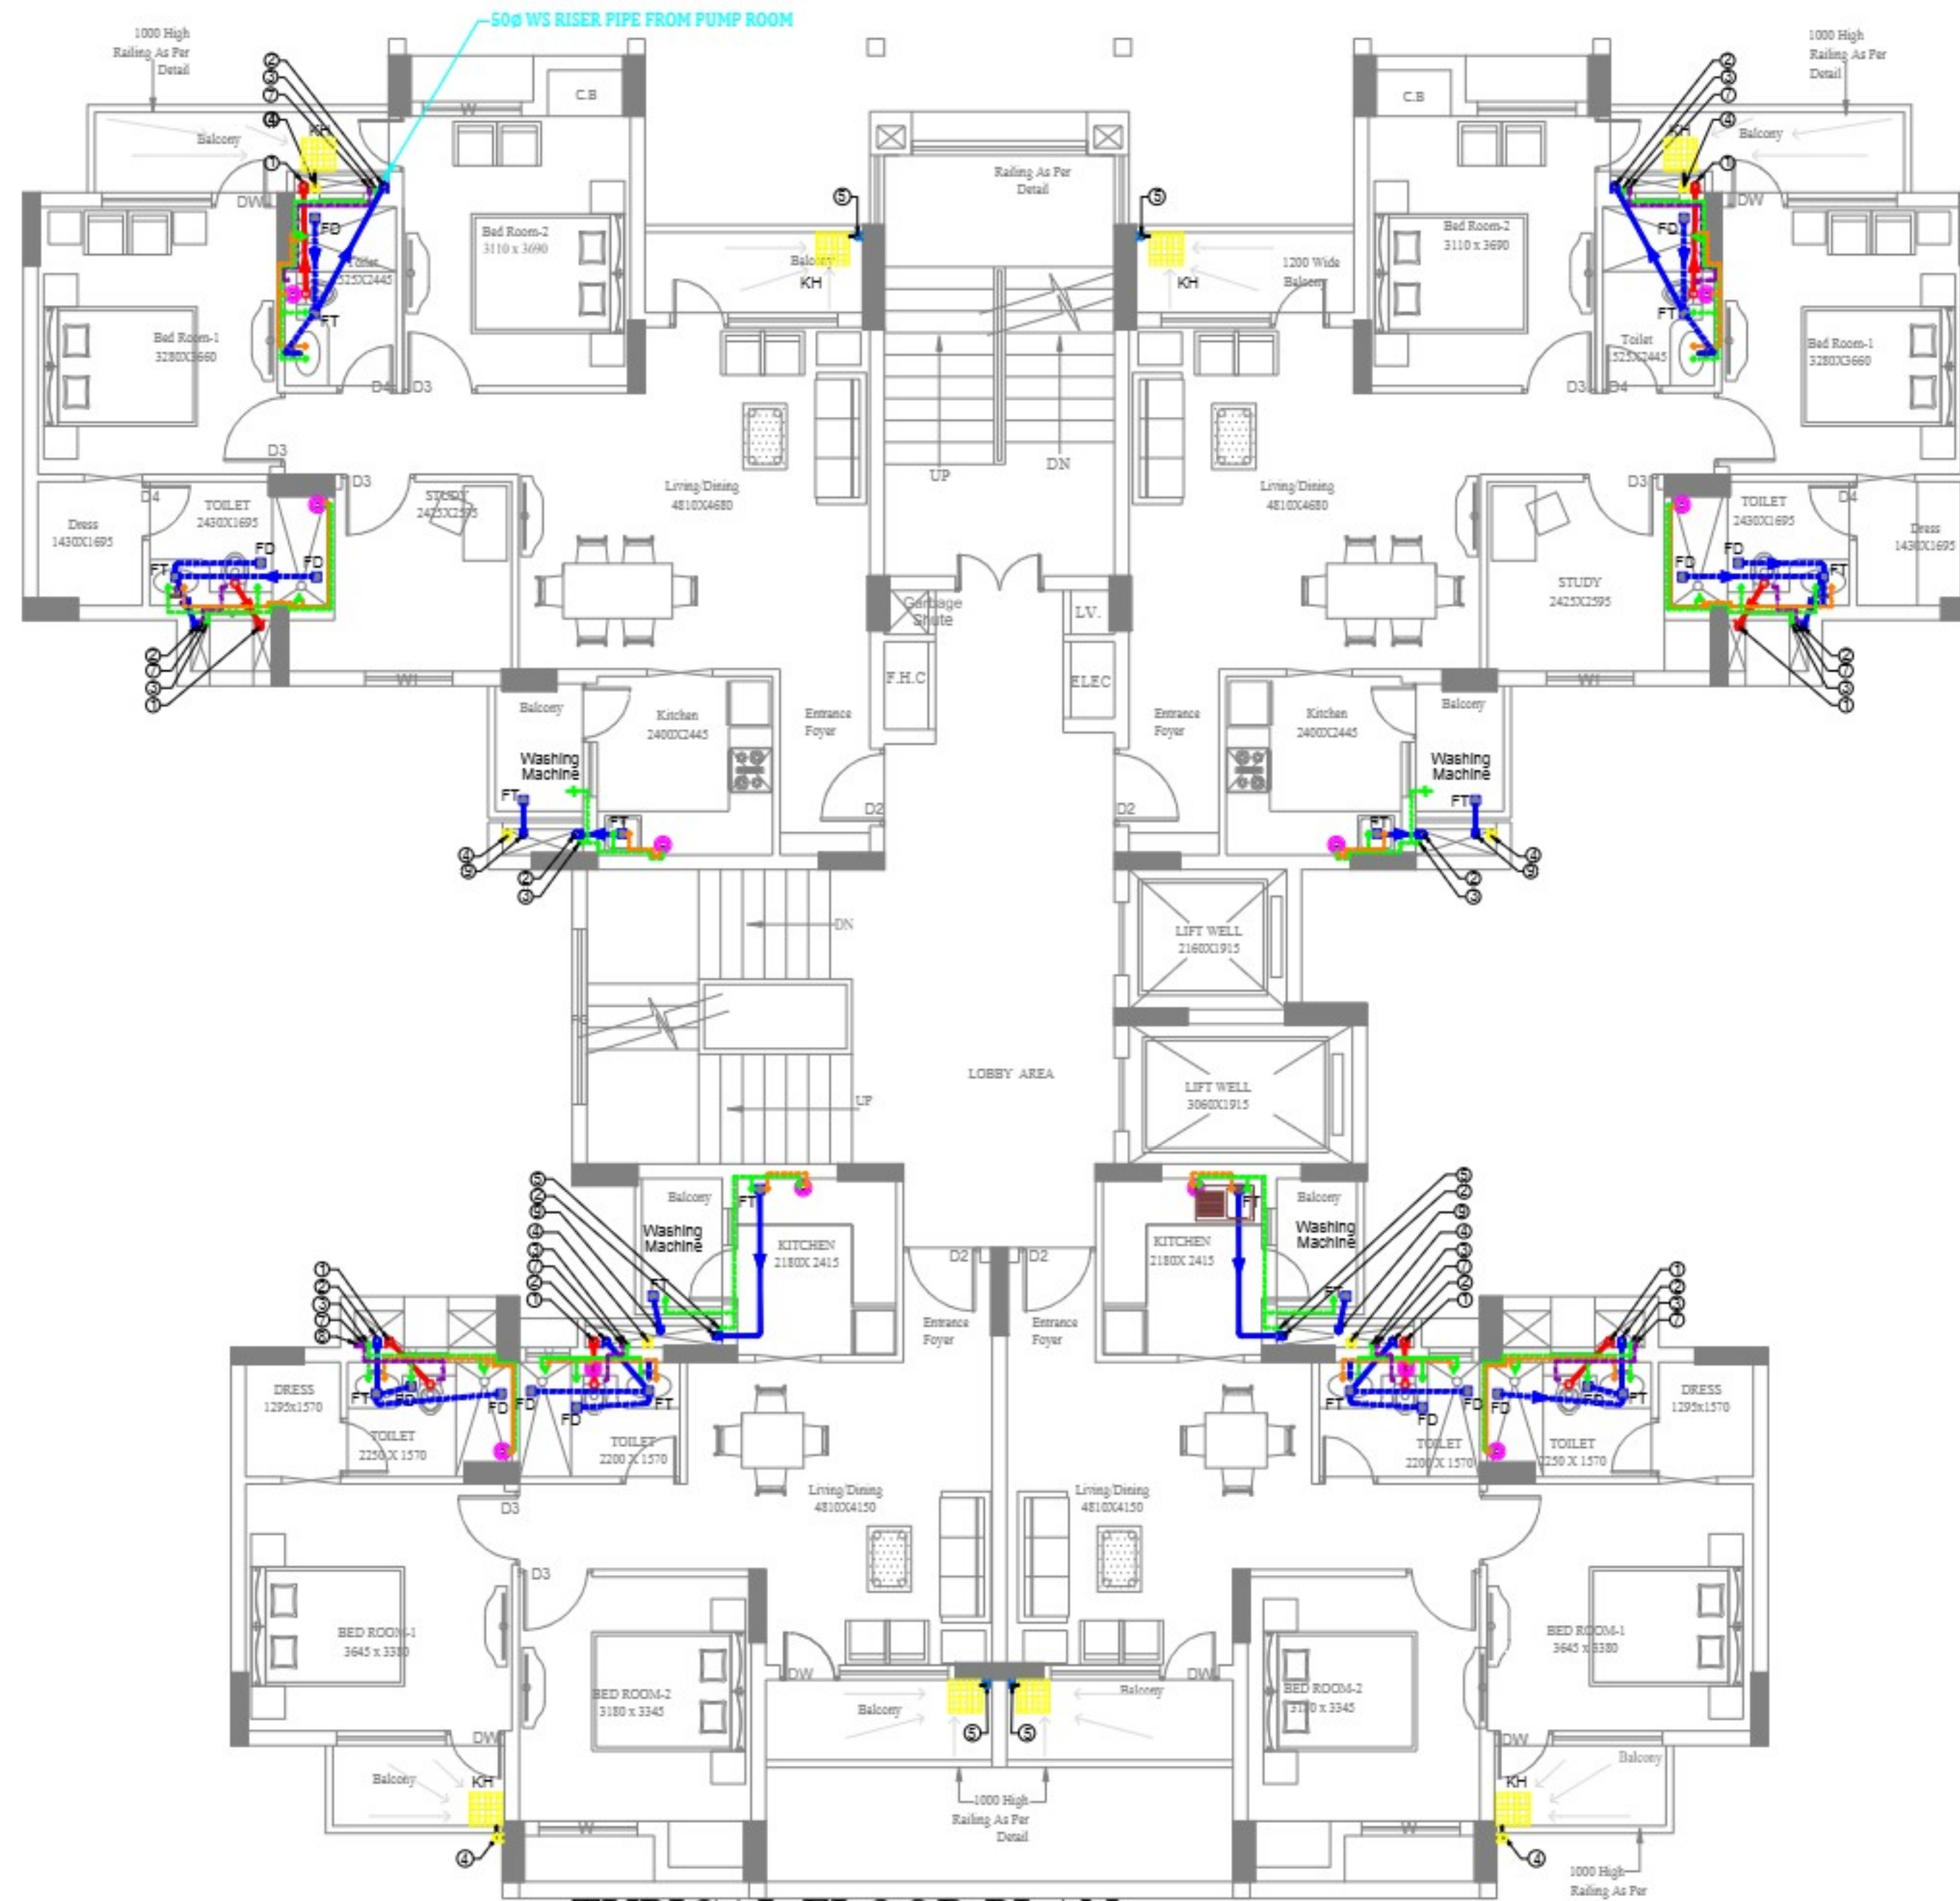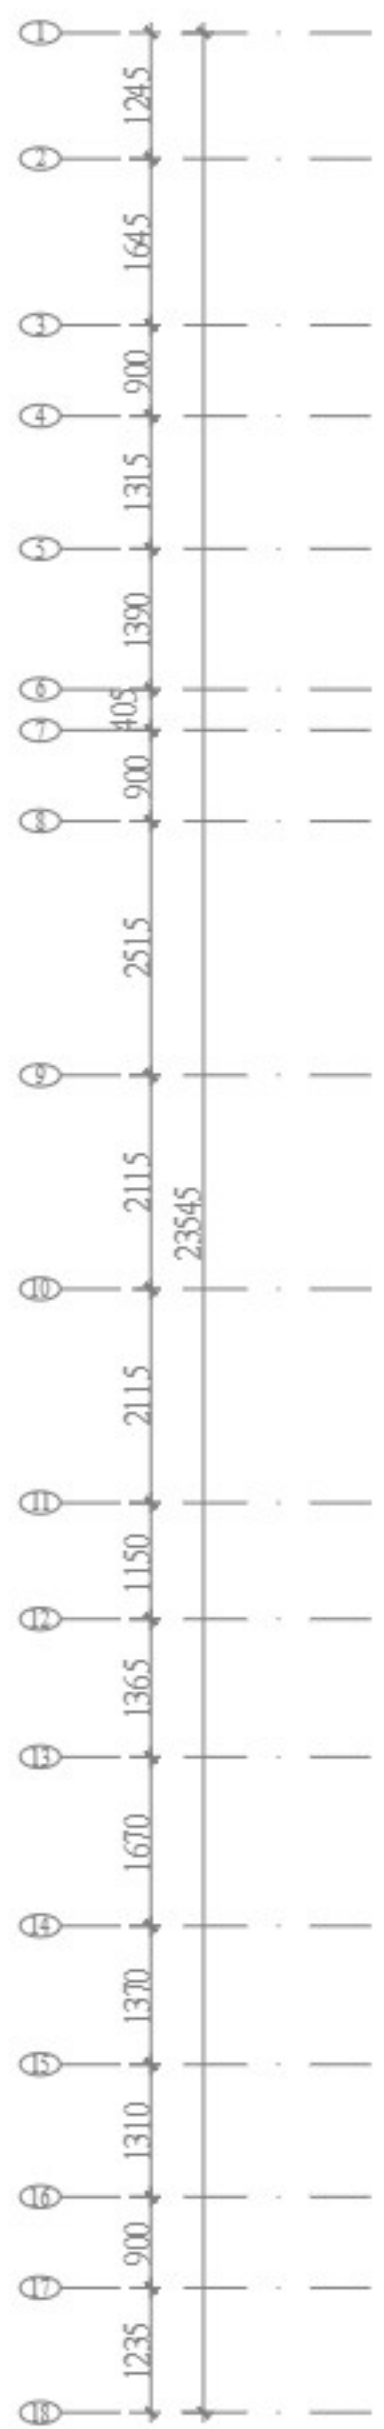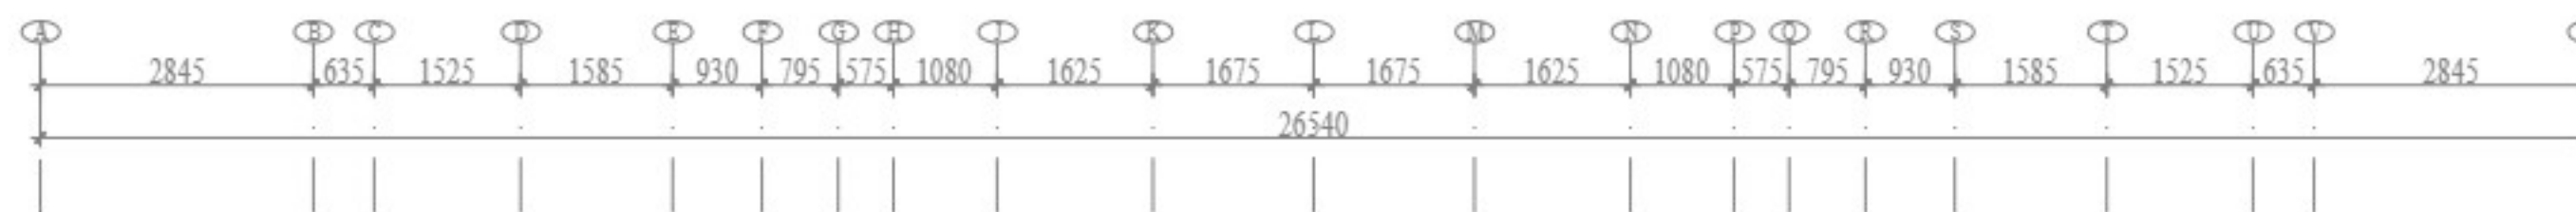

TYPICAL FLOOR PLAN

- NOTES
1. ALL DIMENSIONS ARE IN MM AND SHOULD BE READ, NOT SCALED.
 2. THIS DRG. IS TO BE READ IN CONJUNCTION WITH RELEVANT ARCHITECTURAL AND SERVICES DRAWINGS.
 3. DOORS AND WINDOWS OPENINGS DENOTE FINISHED MASONRY OPENINGS ONLY.
 4. (FINISHED) MASONRY OPENING TO BE CHECKED AT SITE.
 5. THIS DRAWING IS EXCLUSIVE PROPERTY OF REPL AND SHOULD NOT BE REPRINTED, REPRODUCED IN ANY FORM WITHOUT THE WRITTEN PERMISSION OF THE ARCHITECT.
 6. CONTRACTOR SHALL VERIFY AND BE RESPONSIBLE FOR ALL DIMENSIONS ON SITE.
 7. ANY DISCREPANCY AT SITE SHOULD BE BROUGHT TO THE NOTICE OF THE ARCHITECT IMMEDIATELY.
 8. ANY REVISED DRAWINGS ISSUED ON SITE WILL SUPERSEDE ALL PREVIOUS ISSUED DRAWINGS.

LEGEND:- (sanitary)

S.NO.	SYMBOL	DESCRIPTION
1.		115 Ø UPVC SOIL PIPE
2.		115 Ø UPVC WASTE PIPE
3.		DN TAKE CPVC WATER SUPPLY PIPE
4.		115 Ø UPVC RAIN WATER PIPE FROM TERRACE
5.		75 Ø UPVC RAIN WATER PIPE FROM BALCONY
6.		50 Ø CPVC WATER SUPPLY PIPE RISER PIPE
7.		DN TAKE CPVC FLUSHING WATER PIPE
8.		50 Ø CPVC FLUSHING WATER RISER PIPE
9.		75 Ø UPVC WASTE PIPE (FOR BALCONY W.M.)
10.		CPVC WATER SUPPLY PIPE
11.		CPVC HOT SUPPLY PIPE
12.		CPVC FLUSHING WATER SUPPLY PIPE
13.		115 Ø UPVC SOIL PIPE FROM WC TO STACK
14.		115 Ø UPVC WASTE PIPE FROM FT TO STACK
15.		63 Ø UPVC WASTE FROM FD TO FT
16.		50 Ø UPVC WASTE FROM SINK TO FT
17.		50 Ø UPVC WASTE FROM W.B. TO FT
18.		100 Ø UPVC RAIN WATER PIPE FROM M.H. TO M.H.
19.		100 Ø UPVC SOIL PIPE FROM M.H. TO M.H.
20.		MAN HOLE 600X600mm (Bewer)
21.		MAN HOLE 600X600mm (Drain)
22.		FT FLOOR TRAP
23.		FD FLOOR DRAIN
24.		GEYSER
25.		GULLY TRAP (300X300mm)
26.		CATCH BASIN (450X450X450mm)

Drawing Released For :

☐ APPROVAL	☐ SUBMISSION
☐ ADVANCE COPY	☐ GFC

ISSUES		
Date	By	Description

SERVICE & CONSULTANT

Ascendia Professional Services India Pvt. Ltd.
23VC, 15/10, 14th Block, Block-C,
Chennai 600 044, India.
Contacted 20/10/14 12P
Email: ascendia@coral.com

ARCHITECTS:-
DESIGN LAB
S/11, ABUBAKARPUR, DHOOMANGANJ
PRAYAGRAJ-211011

CLIENT
NEW MODERN
BUILDWELL PVT. LTD.

PROJECT
NEW MODERN

DRAWING TITLE
PLUMBING
Typical Floor Plan (Tower-12 A)
Block-3 Area (Type-3)

DATE:	CHECKED BY:	PROJ-INCHARGE:
12-07-2025		
SCALE:	DELT BY:	APPROVED BY:
1:50		
DRAWING NO :	REVISIONS :	
NMDR/ALD/T12A/PL-02		