

LEGEND	
	NEUTRAL EARTHING
	BODY EARTHING
	LIGHTNING ARRESTOR EARTHING


LEGEND FOR WATER SUPPLY	
	GARDEN HOSE
	BALL VALVE
	NON-RETURN VALVE
	DOMESTIC WATER SUPPLY LINE
	FLUSHING WATER SUPPLY LINE
	IRRIGATION LINE

LEGEND FOR FIRE SUPPLY	
	YARD HYDRANT WITH HOSE BOX
	1500 MS FIRE RING MAIN
	BALL VALVE / BUTTER FLY VALVE
	NON-RETURN VALVE



LEGEND FOR SEWAGE SUPPLY	
	MANHOLE FOR SEWER
	SEWAGE PIPE

LEGEND FOR DRAINAGE SUPPLY	
	DRAINAGE MANHOLE
	DRAINAGE PIPE

OTHERS
PROPERTY

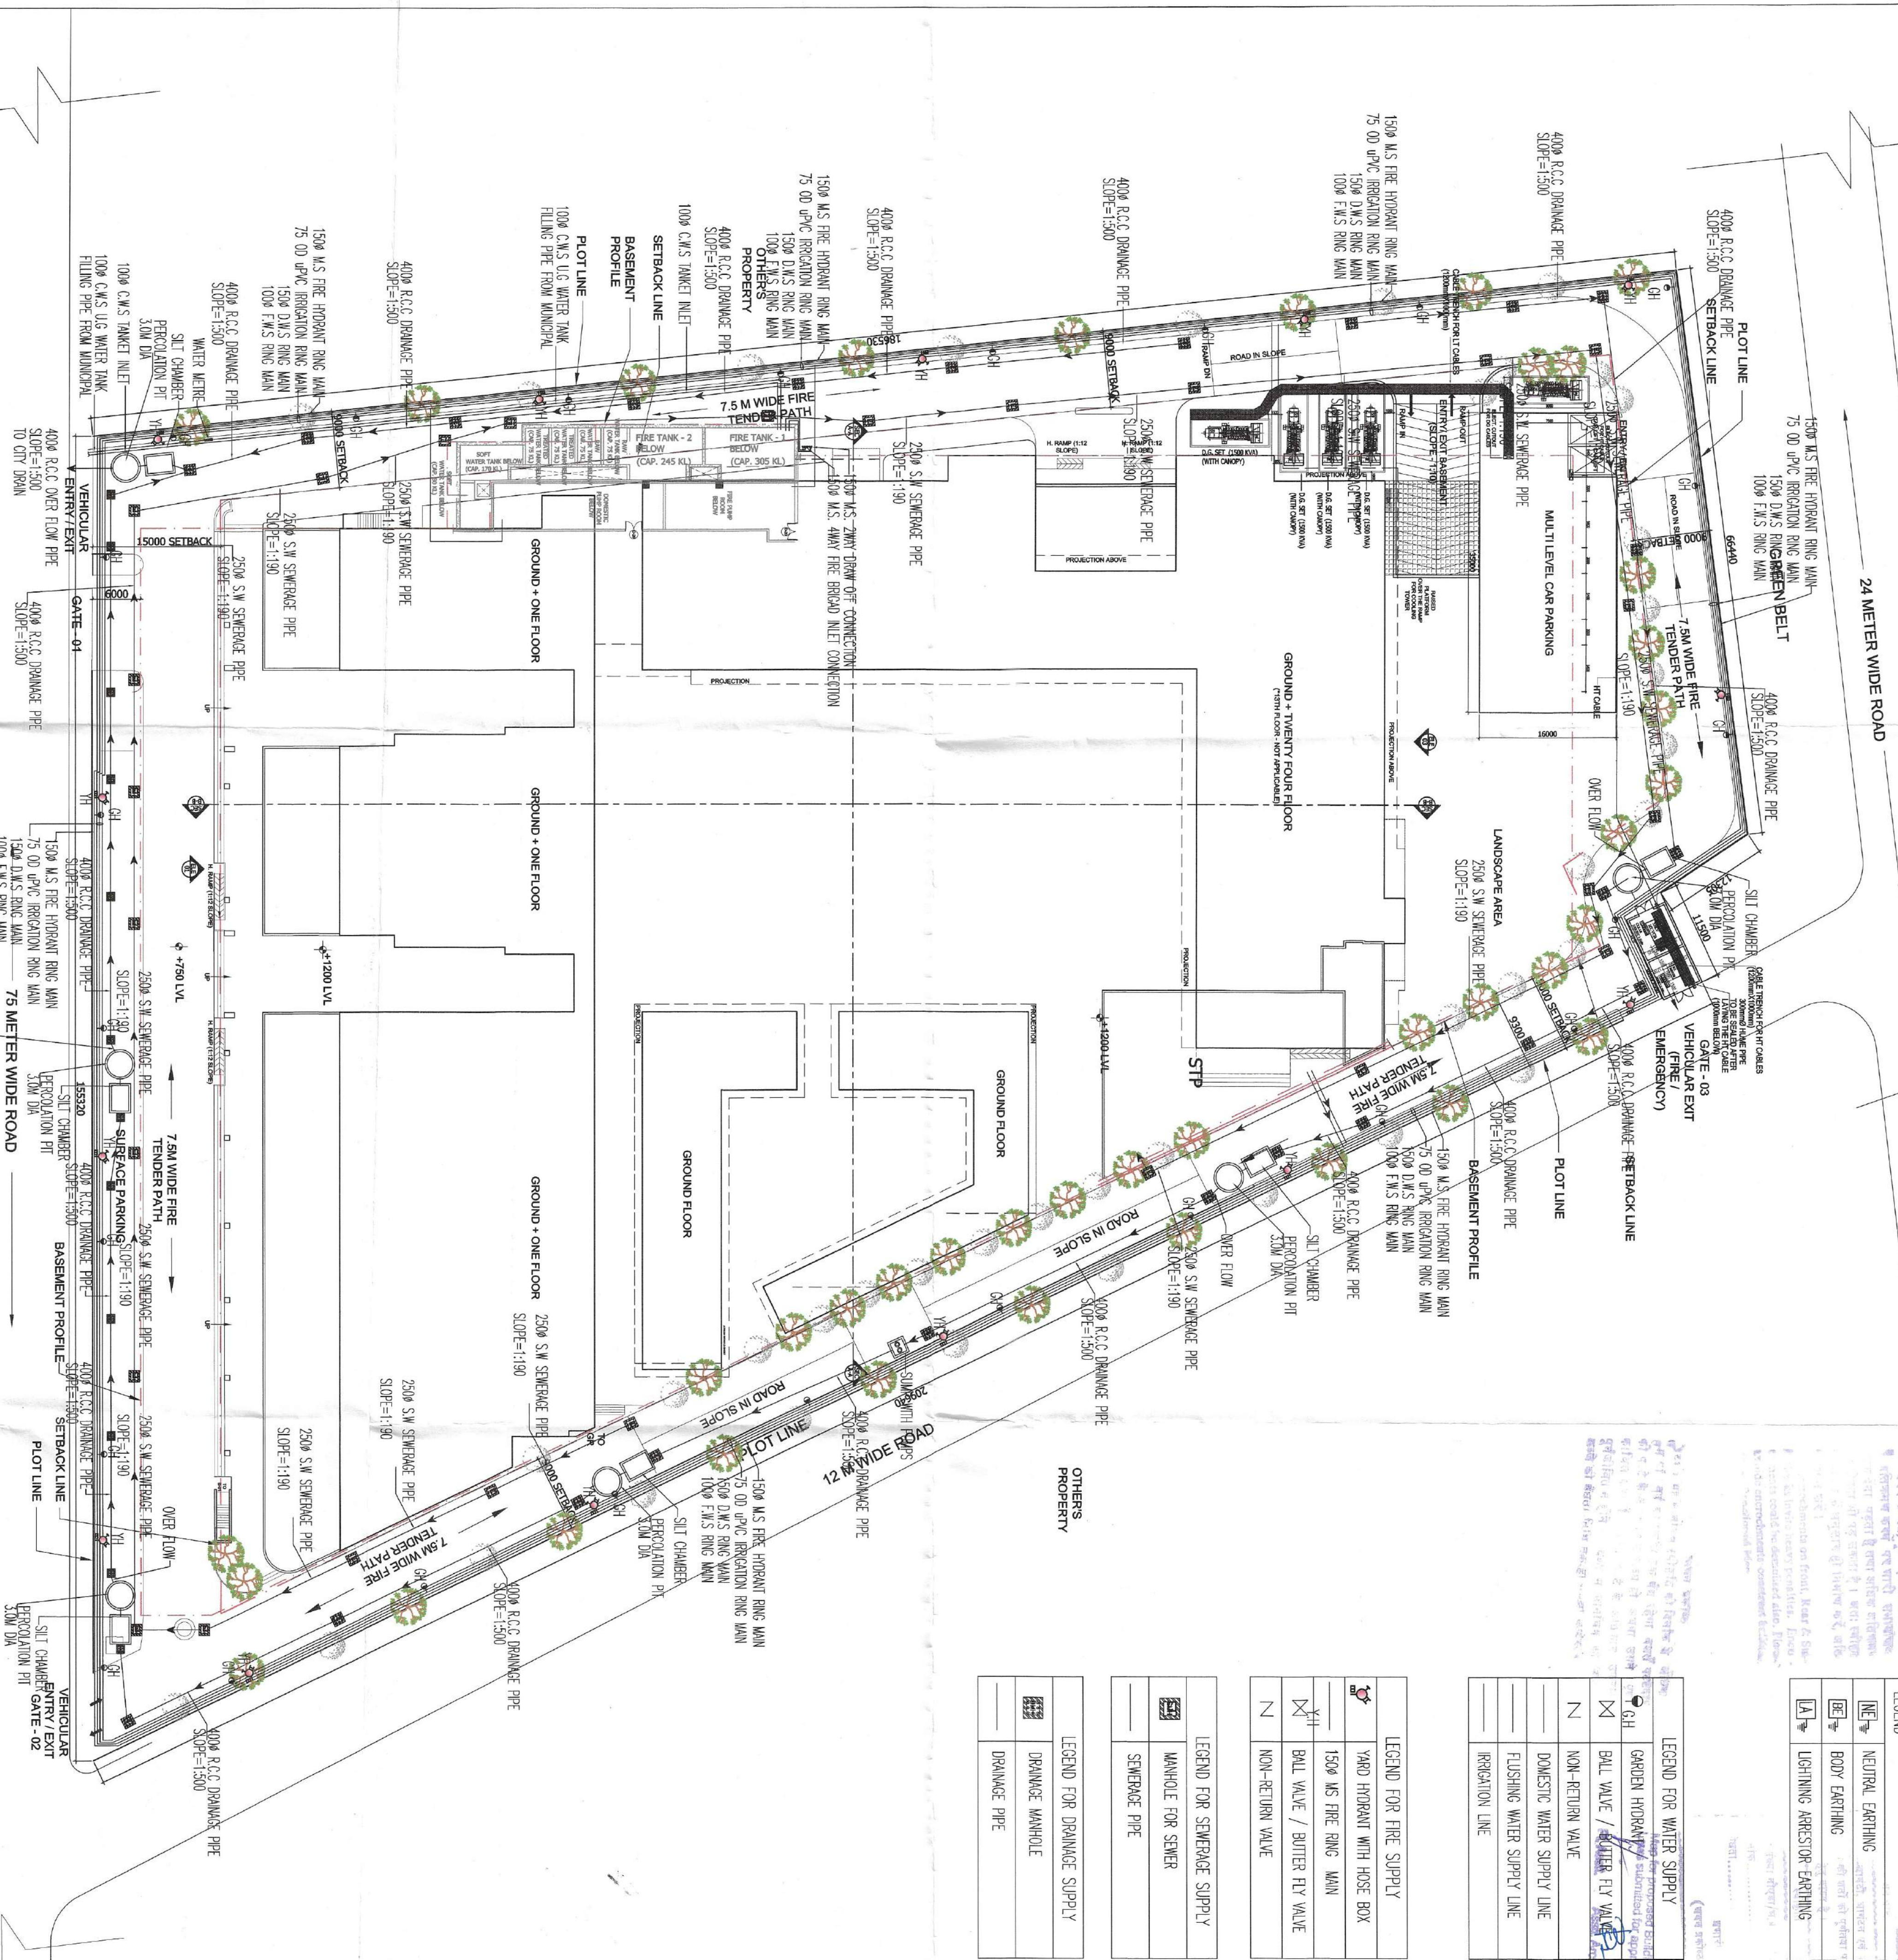

SITE PLAN

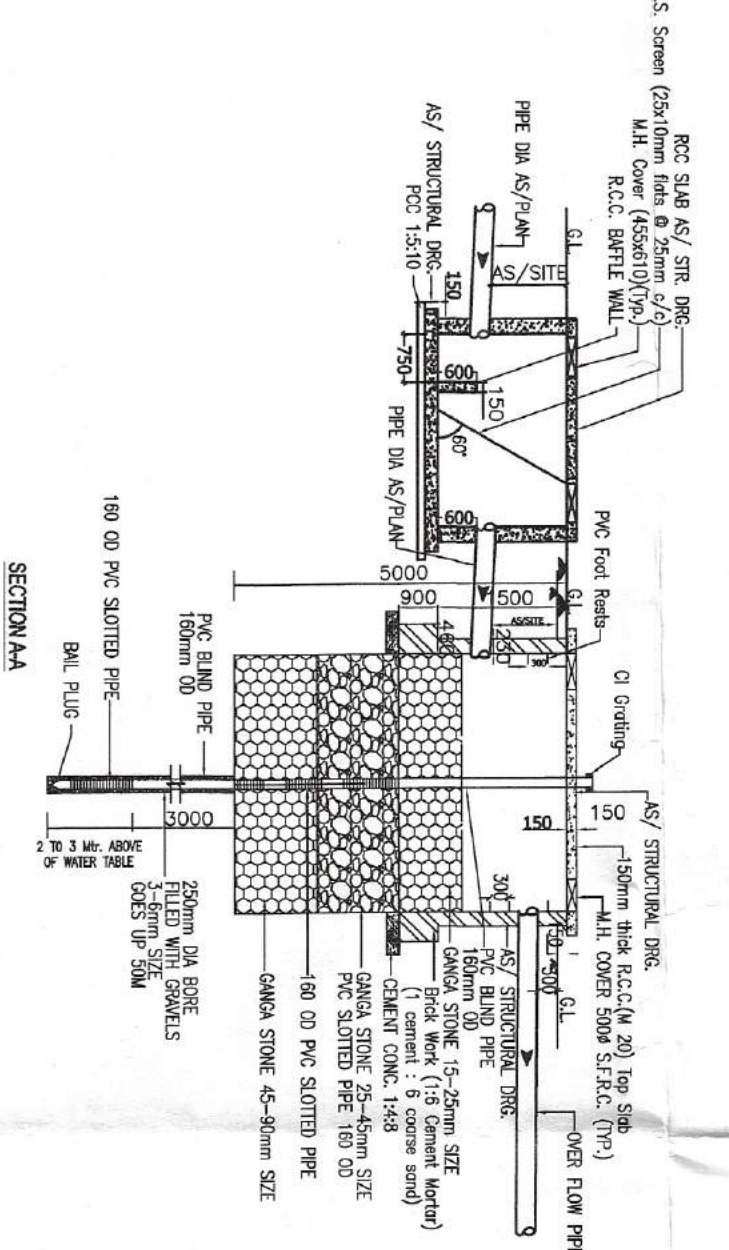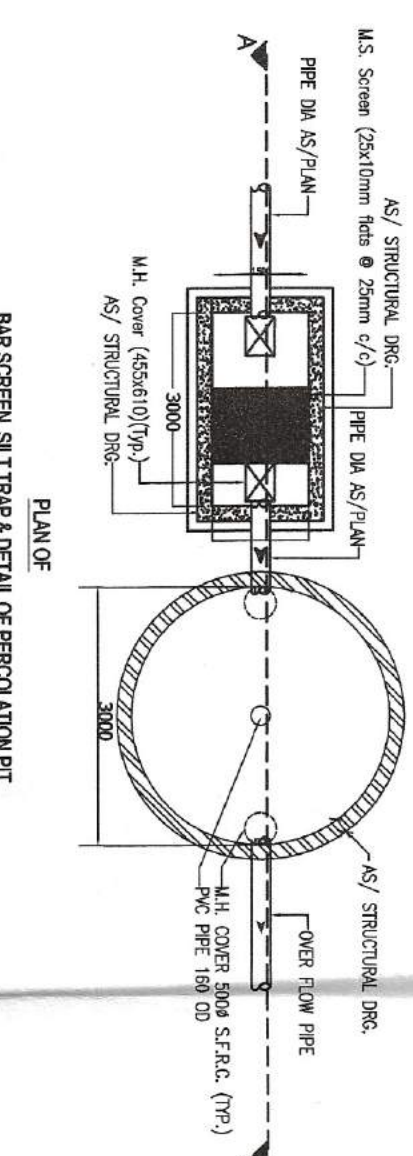

OWNERS:
SIFAL INFOTECH PVT. LTD
W-111/A FIRST FLOOR,
GREATER KAILASH PART-1,
NEW DELHI - 110048

PROJECT:
SUBMISSION DRAWING FOR PROPOSED
BUILDING THUM'S 73, ON PLOT NO.-04, AT
SECTOR -73, NOIDA DISTRICT,
GAUTAM BUDDH NAGAR,
UTTAR PRADESH.

ARCHITECTS:
ATWIN
BRU (INDIA) ARCHITECTS
F-89 GREEN PARK, NEW DELHI -16.
Ph. +91-11-26853815, 26853807, Fax: +91-11-26850788
E-mail : bharch@rediffmail.com, info@atwin.in
Website: www.atwin.in

SITE PLAN
CO-ORDINATION LAYOUT

DEALT BY: SCALE: 1:400

For SIFAL INFOTECH PVT. LTD.
Signature
AR. ATEESH AGARWAL
B.Arch, DIP. PROJ. MGMT (LONDON)
M. C. A. - 2003 / 31212
APPLICANT'S SIGNATURE ARCHITECT'S SIGNATURE

SD-01B