


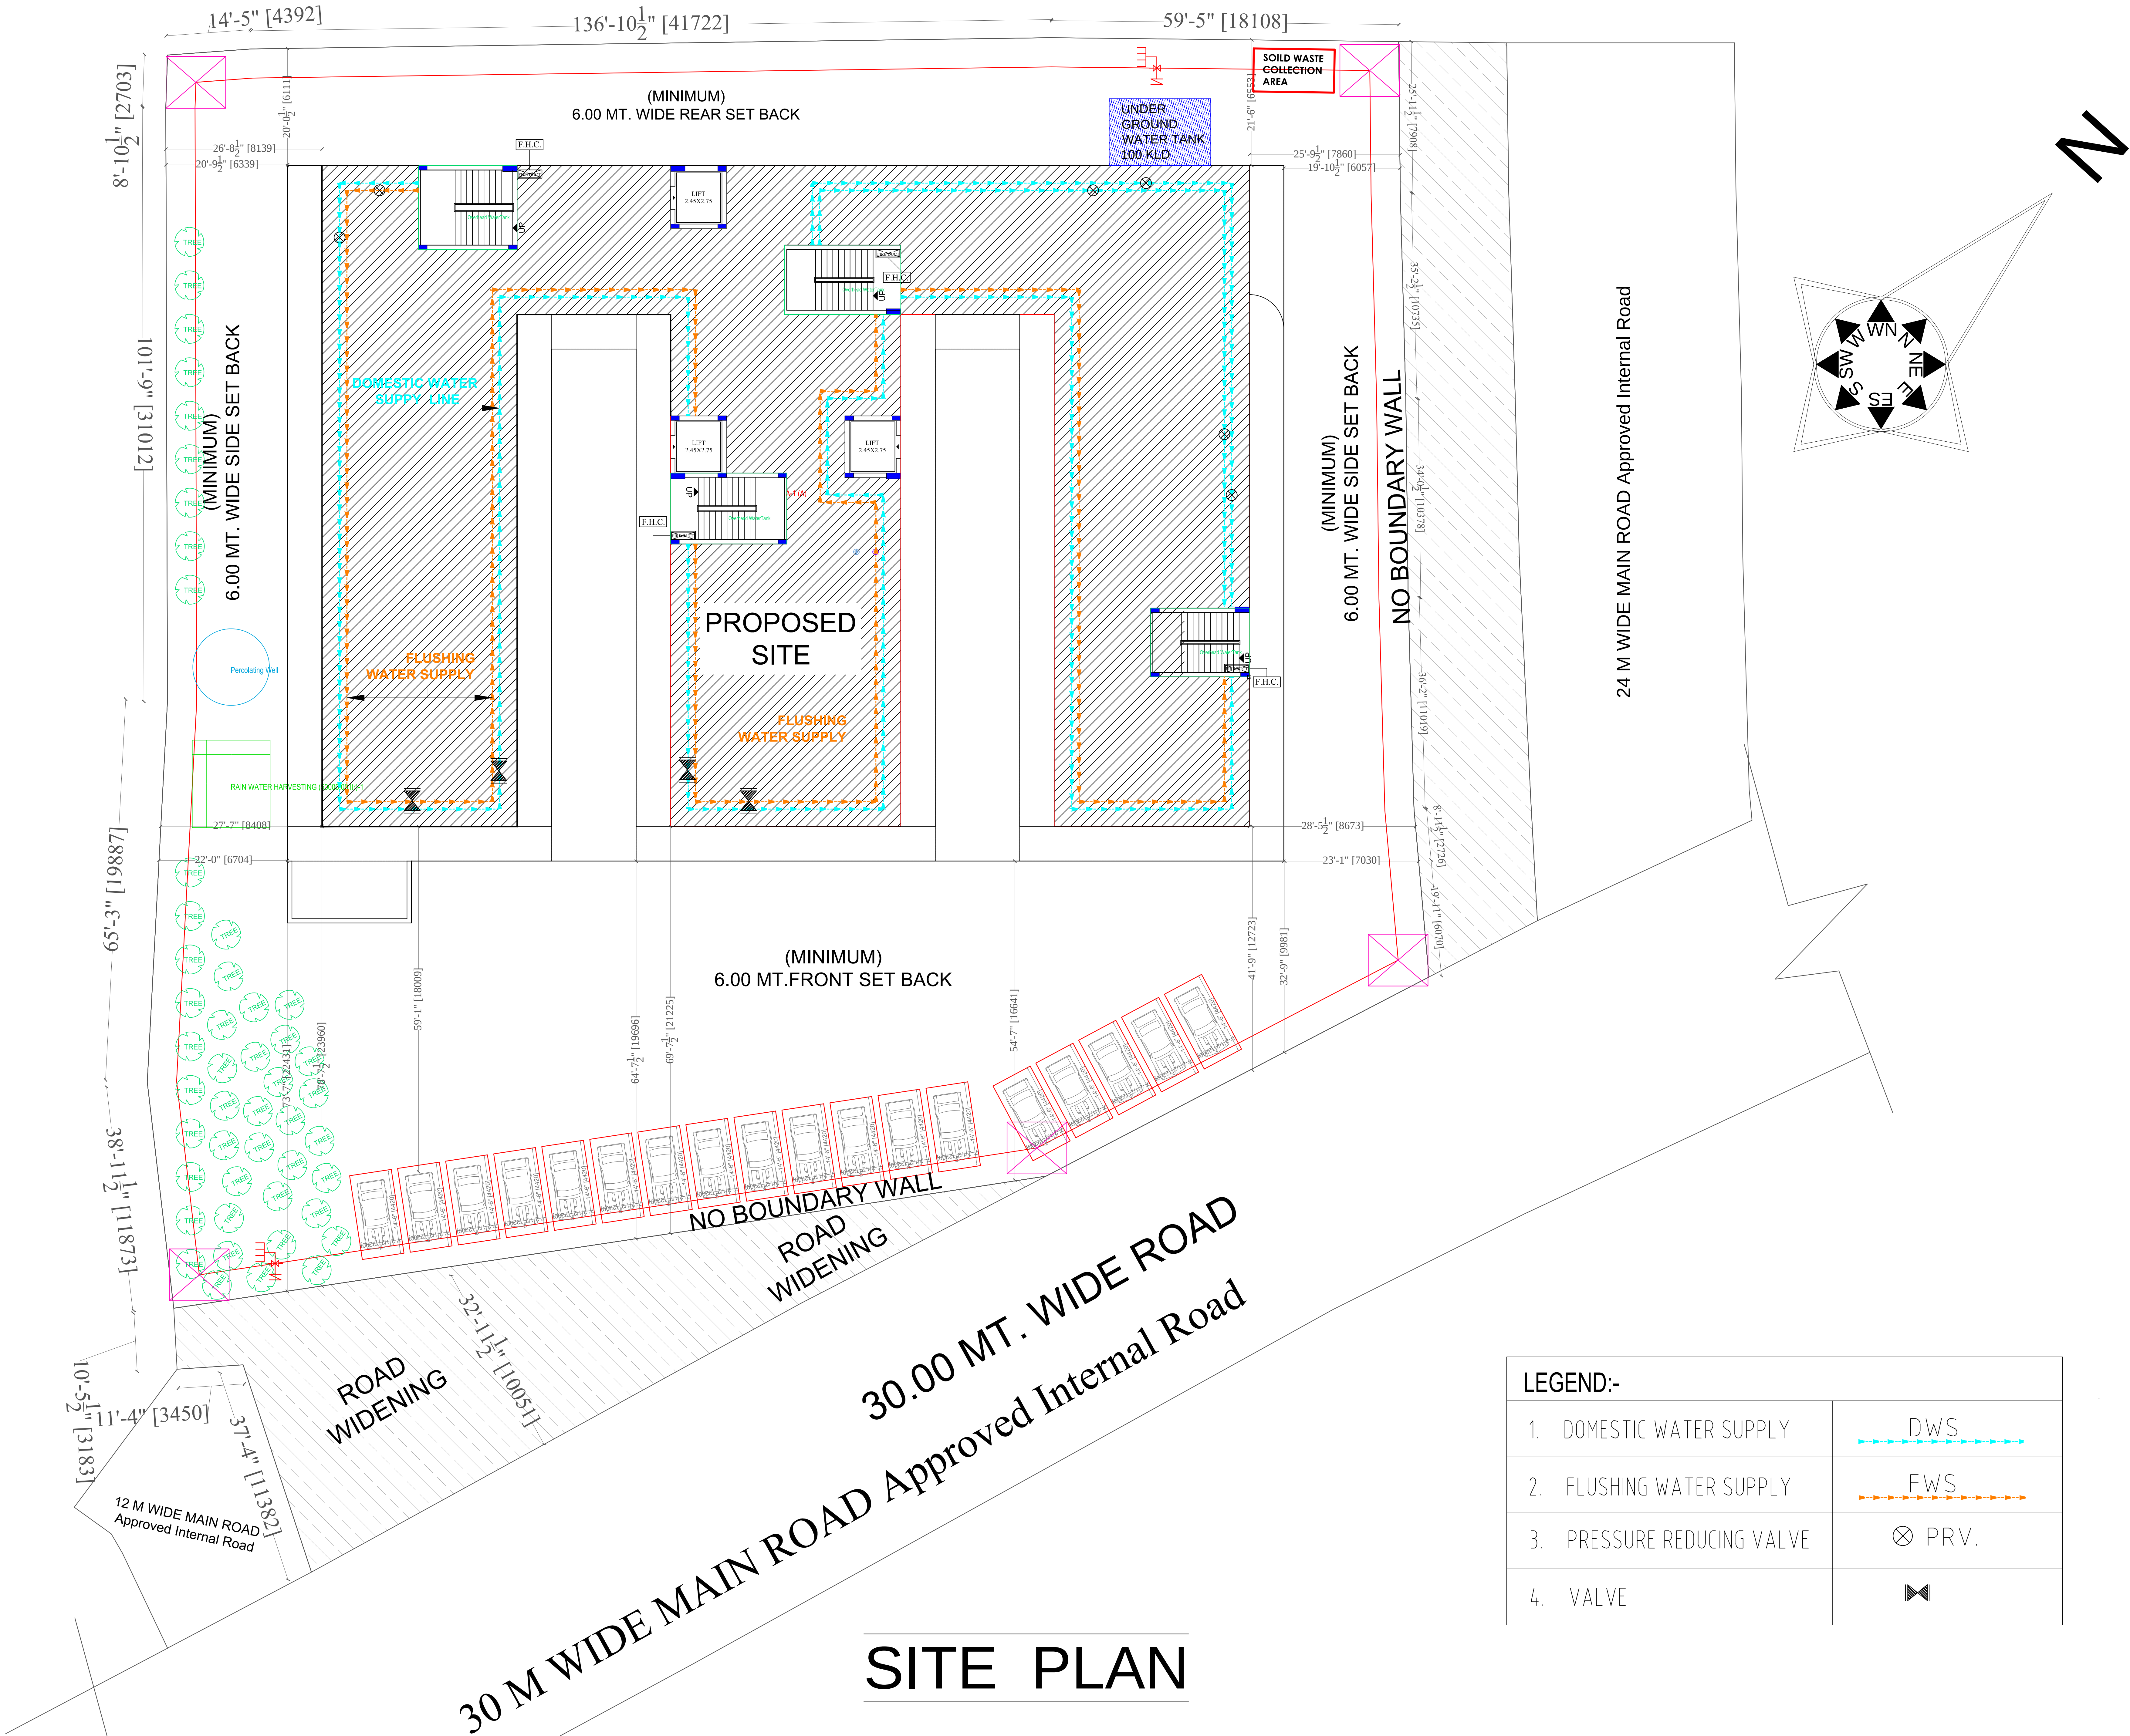

SITE PLAN

WATER SUPPLY PLAN

APPROVAL OF G.D.A.:

PROJECT TITLE:

Density

sheet number 02

DWN BY:

CKD BY:

OWNER SIGN.

ACORE ARCHITECTURAL SERVICES PVT. LTD
ARCHITECT:ASHISH SRIVASTAVA
(B. ARCH)
BRANCH OFFICE : 935/D MATRI ANCHAL NEAR
GORAKHNATH RAILWAY CROSSING GORAKHPUR
TEL: OFF:3294813,RESI:2255290, MOBILE:9415321836.