


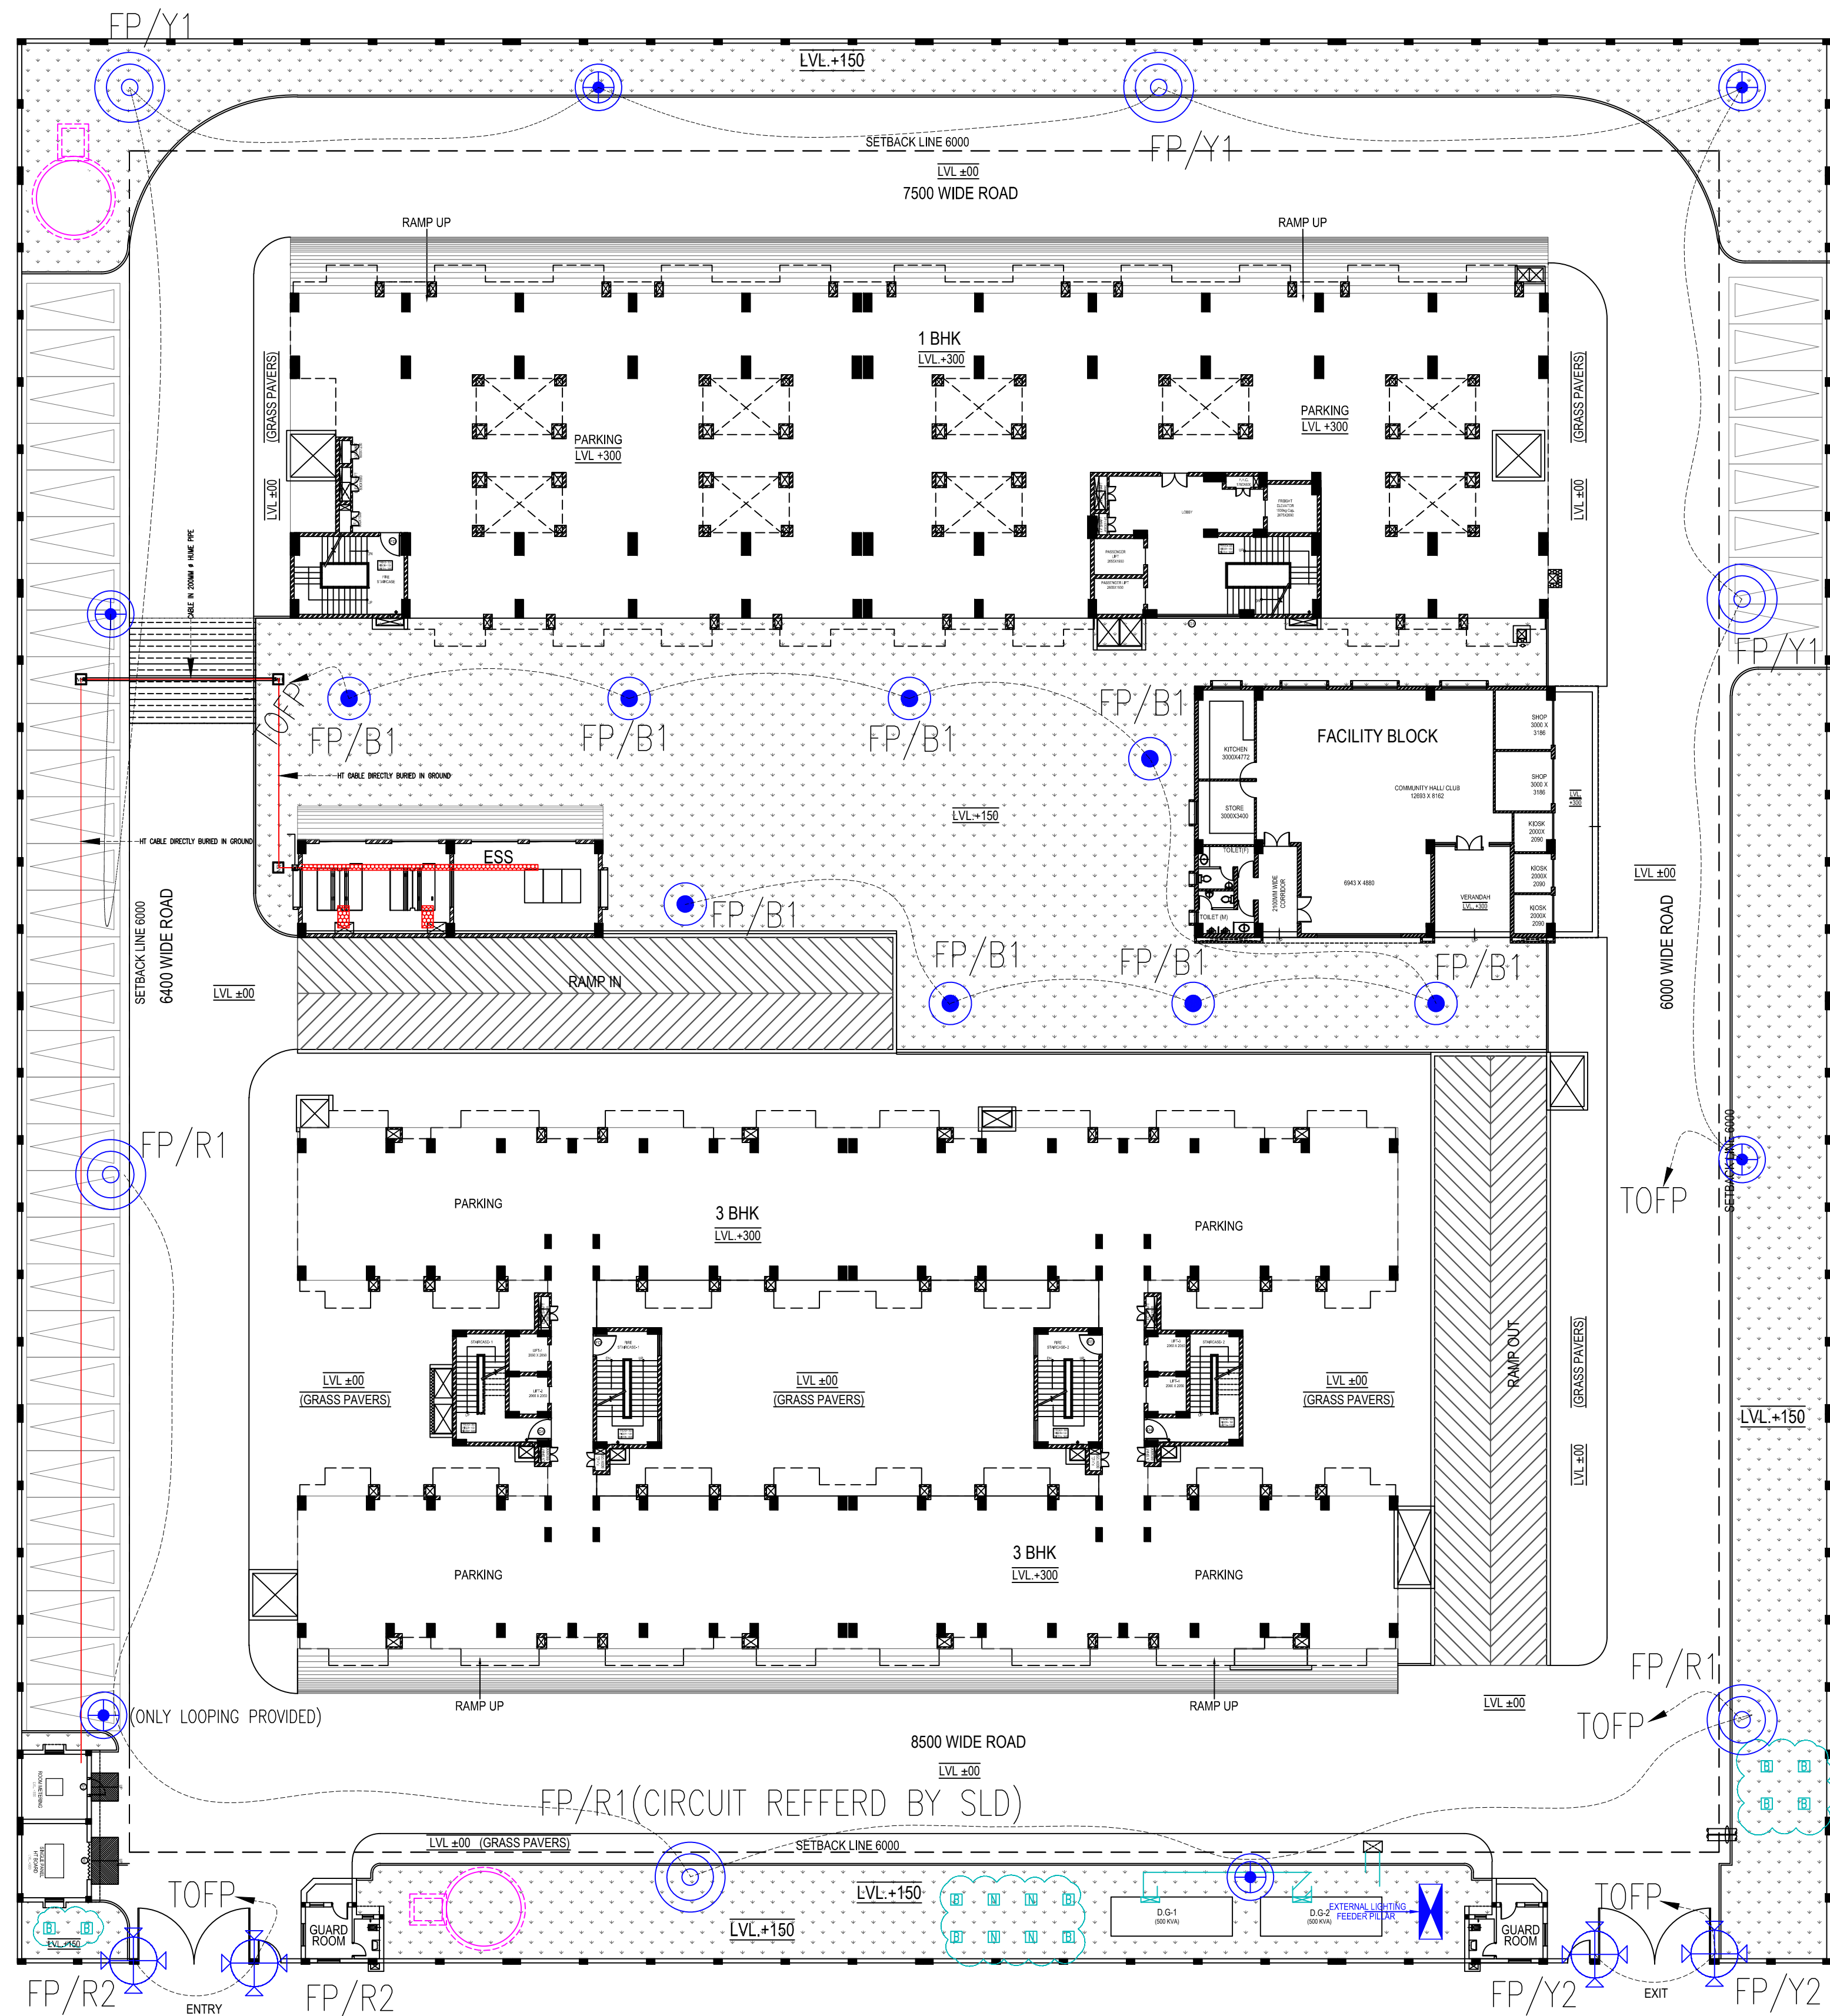

ELECTRICAL LEGEND		
1.		8Mtr BRIKA POLE WITH 78W LED LIGHT WITH SOLLAR BECKUP
2.		8Mtr BRIKA POLE WITH 78W LED LIGHT
3.		POST TOP LANTERN (BAJAJ BJMPTI 70SV LPF)
4.		4Mtr POLE WITH POST TOP LIGHT
5.		FEEDER PILLAR

NOTE-
1) ALL ITEMS SHALL BE APPROVED BY ARCHITECT.
2) LUX CALCULATION SHEET SHALL BE PROVIDED BY OEM FOR APPROVAL.
3) EXTERNAL LIGHTING FEEDER PILLAR SHALL BE ADVANCE PANELS & SWITCHGEAR / ABB / SIEMENS/ L&T MAKE .
PANEL SHALL BE MANUFACTURE AT THEIR RESPECTIVE PLANTS, AUTHORIZED INTEGRATORS SHALL NOT ALLOWED.
4) SHOP DRAWING WITH PROPER DIMENTION SHALL BE PROVIDED BY ELECTRICAL CONTRACTOR FOR APPROVAL.
5) PRIOR INSPECTION OF ELECTRICAL ITEMS SHALL BE DONE AT THEIR MANUFACTURING PLANT BY ELECTRICAL CONSULTANT.

SUBMISSION DRAWING

PROJECT:
**1BHK & 3BHK APARTMENTS ,
PLOT NO. L & M SECTOR - 12
AT GREATER NOIDA**

CONSTRUCTION AGENCY :
GREATER NOIDA INDUSTRIAL DEVELOPMENT
AUTHORITY,
169 CHITVAN ESTATE SECTOR
GAMMA - II GREATER NOIDA, GAUTAM BUDH
NAGAR, UTTAR PRADESH 201308

DRG. TITLE:
EXTERNAL LIGHTING LAYOUT
SITE PLAN

DRAWN BY:
SANJAY

CHECKED BY:
PRASHANT SHARMA

DATE:
07-04-2017

SCALE :
NTS

DRG NO. :
EL-SAGN-101C(EXT.)

REVISIONS :

S.N.	REVISION	DATE	DESCRIPTION
2)	R2	07.04.17	LIGHTING & HUME PIPE REVISED.
1)	R1	20.07.16	CIRCUITING REVISED

DATE:
JULY'16

SCALE :
NTS

NORTH :

DRG NO. :
EL-101C

CONSULTING ARCHITECTS:
ARCH-EN DESIGN
Architect **ASHOK KUMMAR**
DELHI OFF.: B-2/7, HAUZ KHAS, NEW DELHI-16.
011-45188222, Fax:- 011- 45188288
LUCKNOW OFF.: 4/S,VISHAL KHAND,GOMTI NAGAR, LUCKNOW
0522-4088222, Fax :- 0522- 4088288

A.C.E.O.		C.E.O	
SURESH KUMAR SR. DRAFT MAN	W. SUKHBIR SR.EXE.(PLNG.)	NIMISHA SHARMA D.G.M. (PLNG.)	G.M.(PLNG./ARCH.)

**GREATER NOIDA INDUSTRIAL
DEVELOPMENT AUTHORITY**