



PROJECT
PROPOSED GROUP HOUSING-02 IN
OMAXE HITECH CITY , LUCKNOW U.P.

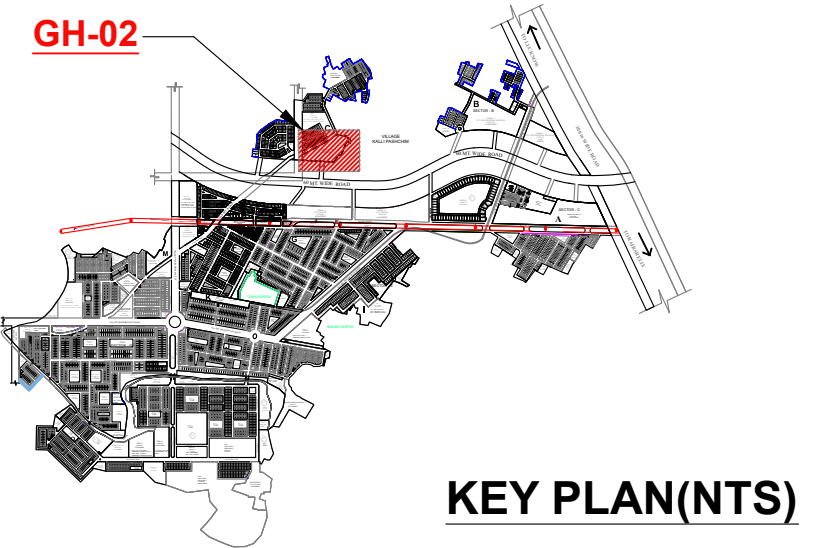

KEY PLAN(NTS)

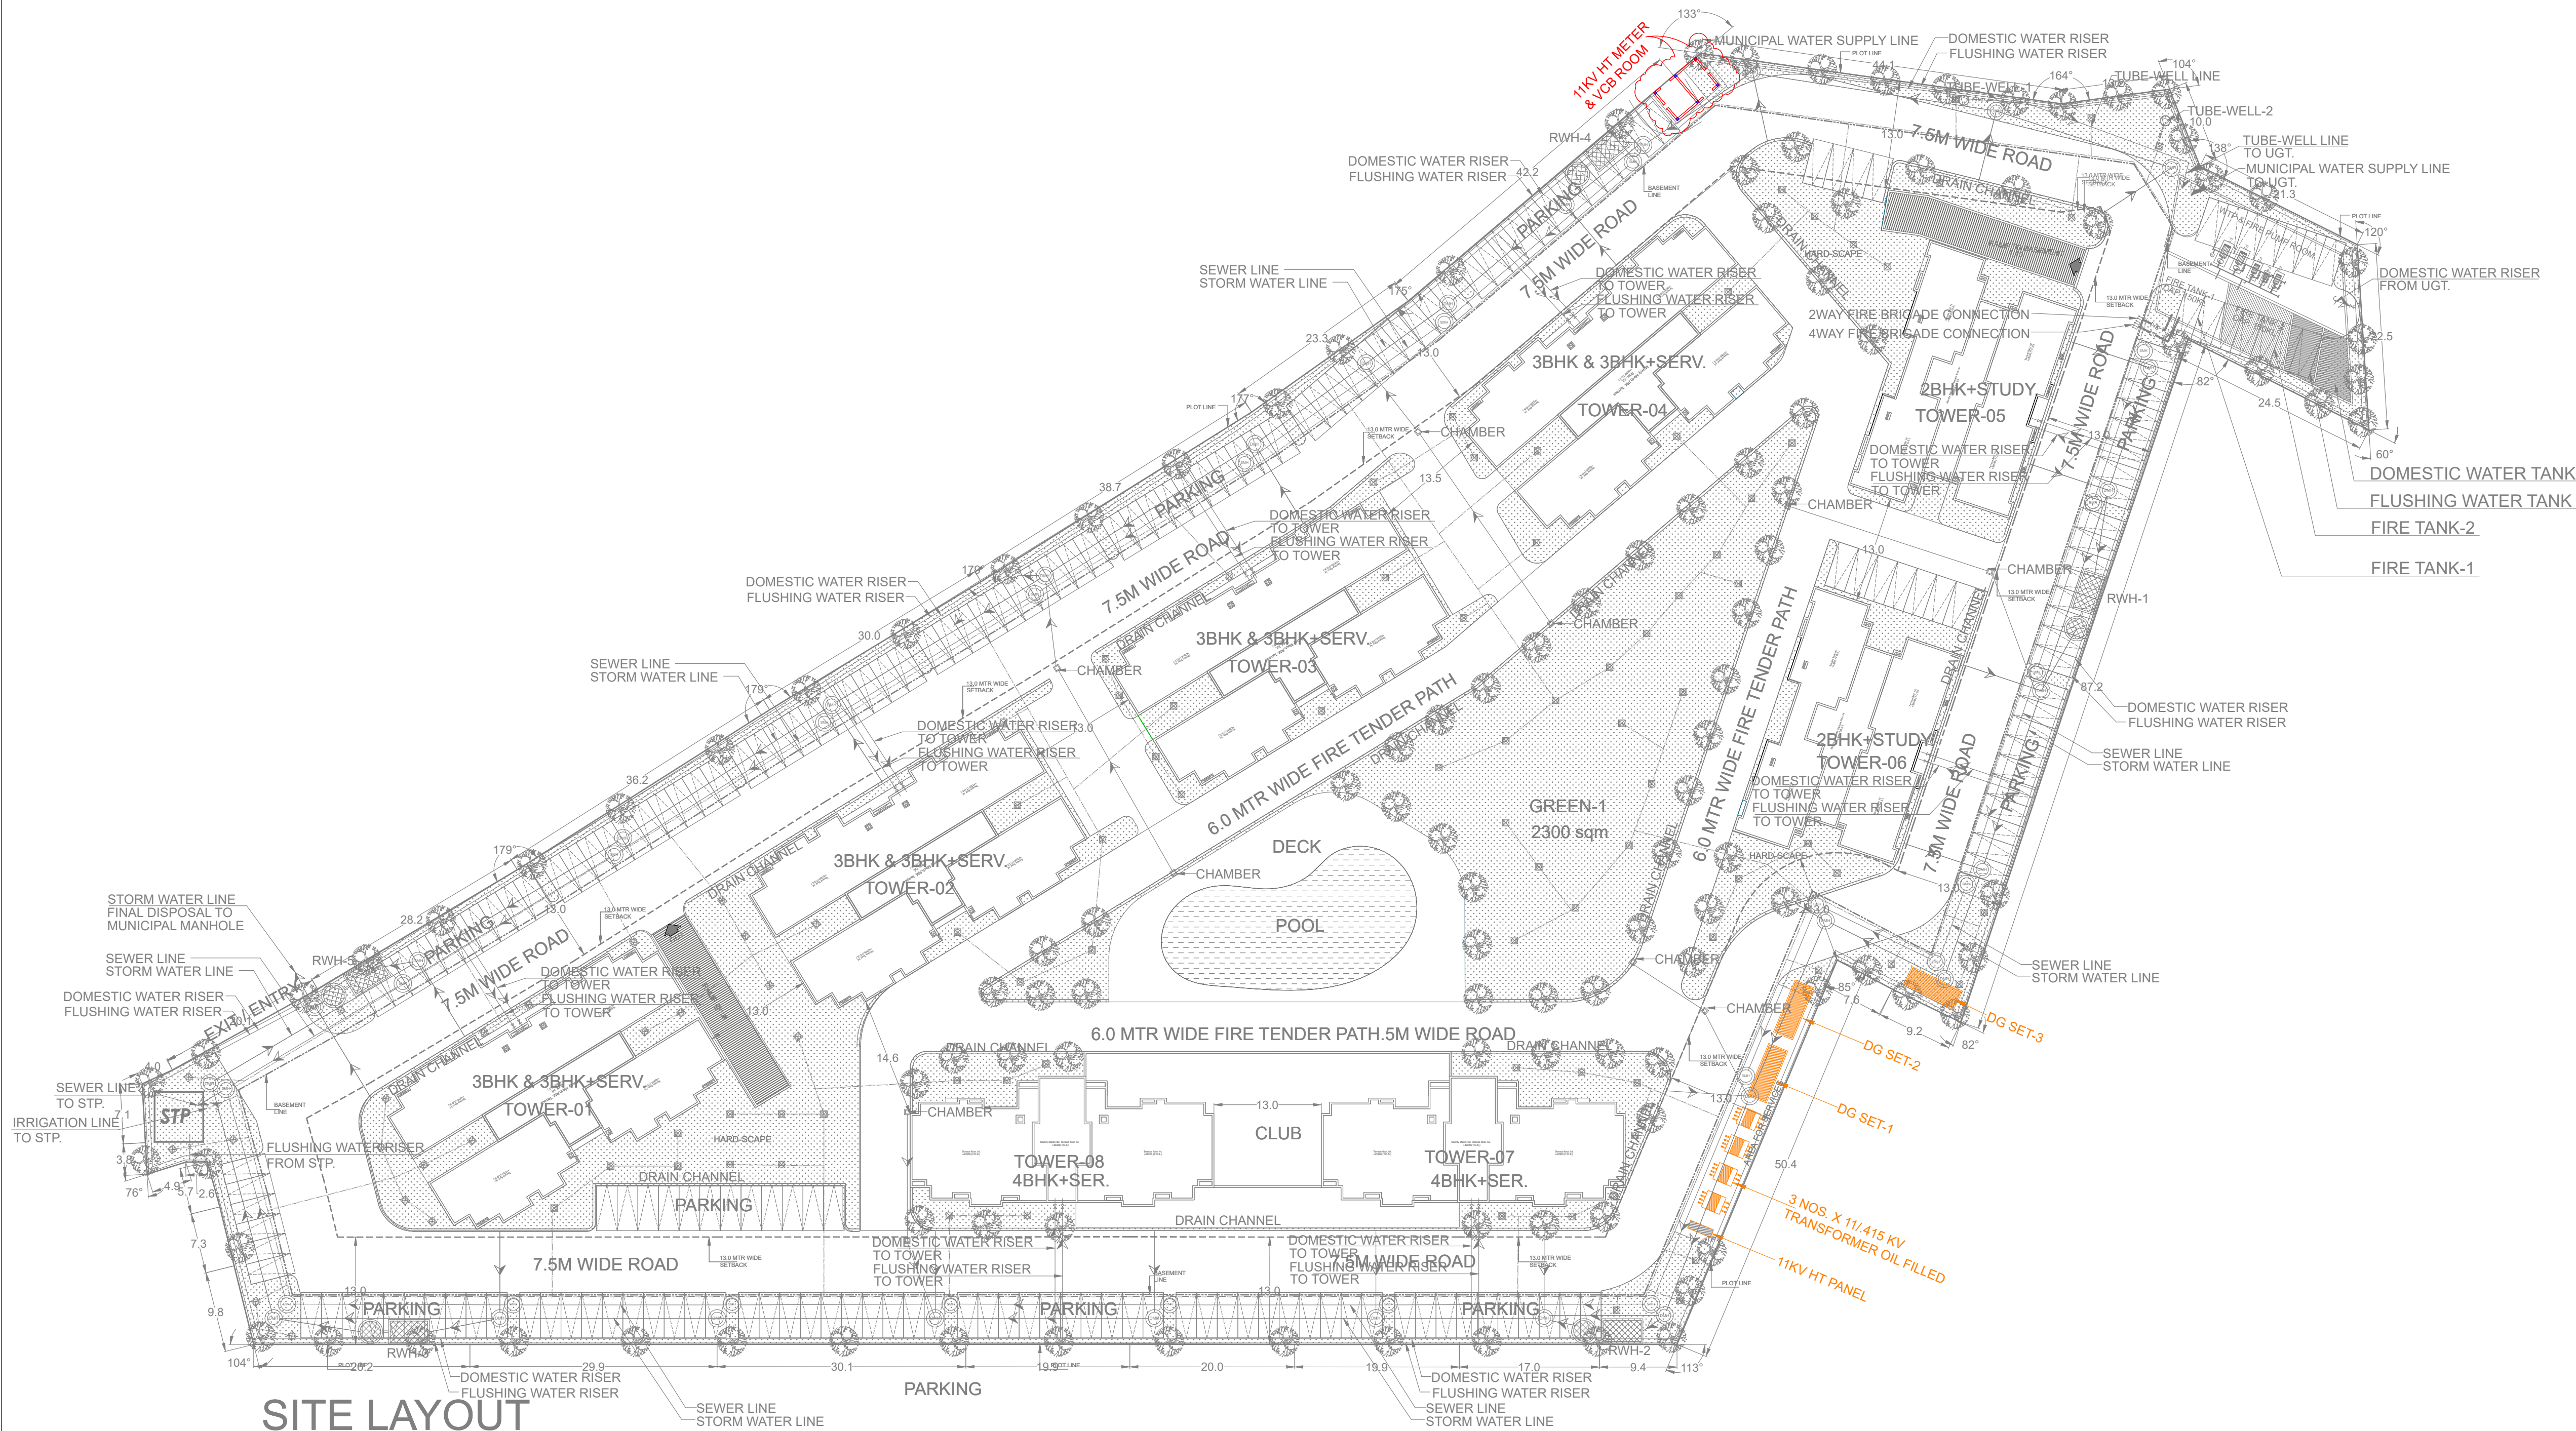

DRAWING TITLE

GROUP HOUSING-02
ELECTRICAL SITE PLAN

SCALE

DATE

ARCHITECT

N.T.S.

JAN-2024

CLIENT/ OWNERS

DRAWING NUMBER-

LKO/HI-TECH/GH-02/SUB-01

TOTAL PLOT AREA -22977.18 Sqm.