




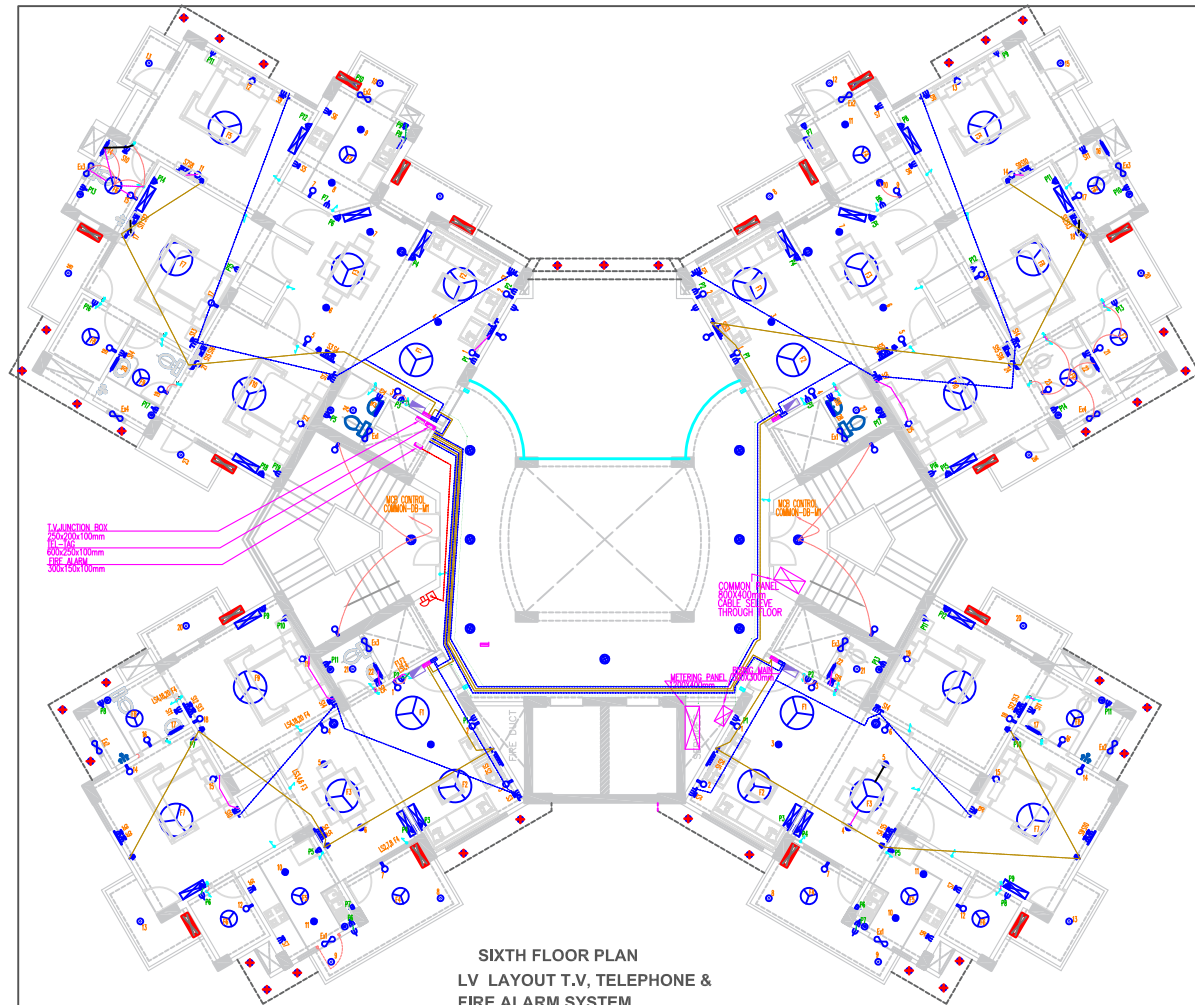


SIXTH FLOOR PLAN
LV LAYOUT T.V, TELEPHONE &
FIRE ALARM SYSTEM

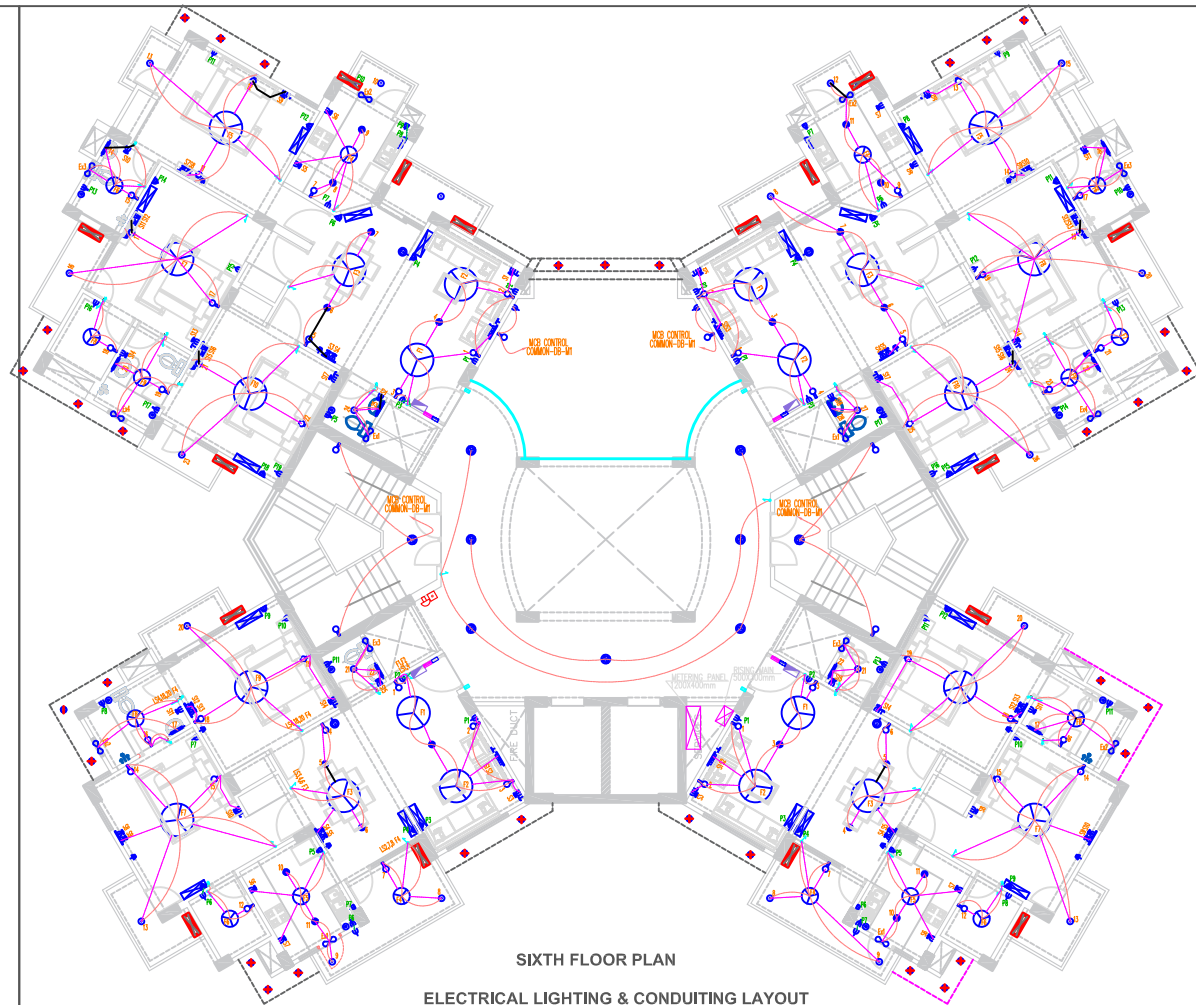

SIXTH FLOOR PLAN
ELECTRICAL LIGHTING & CONDUITING LAYOUT

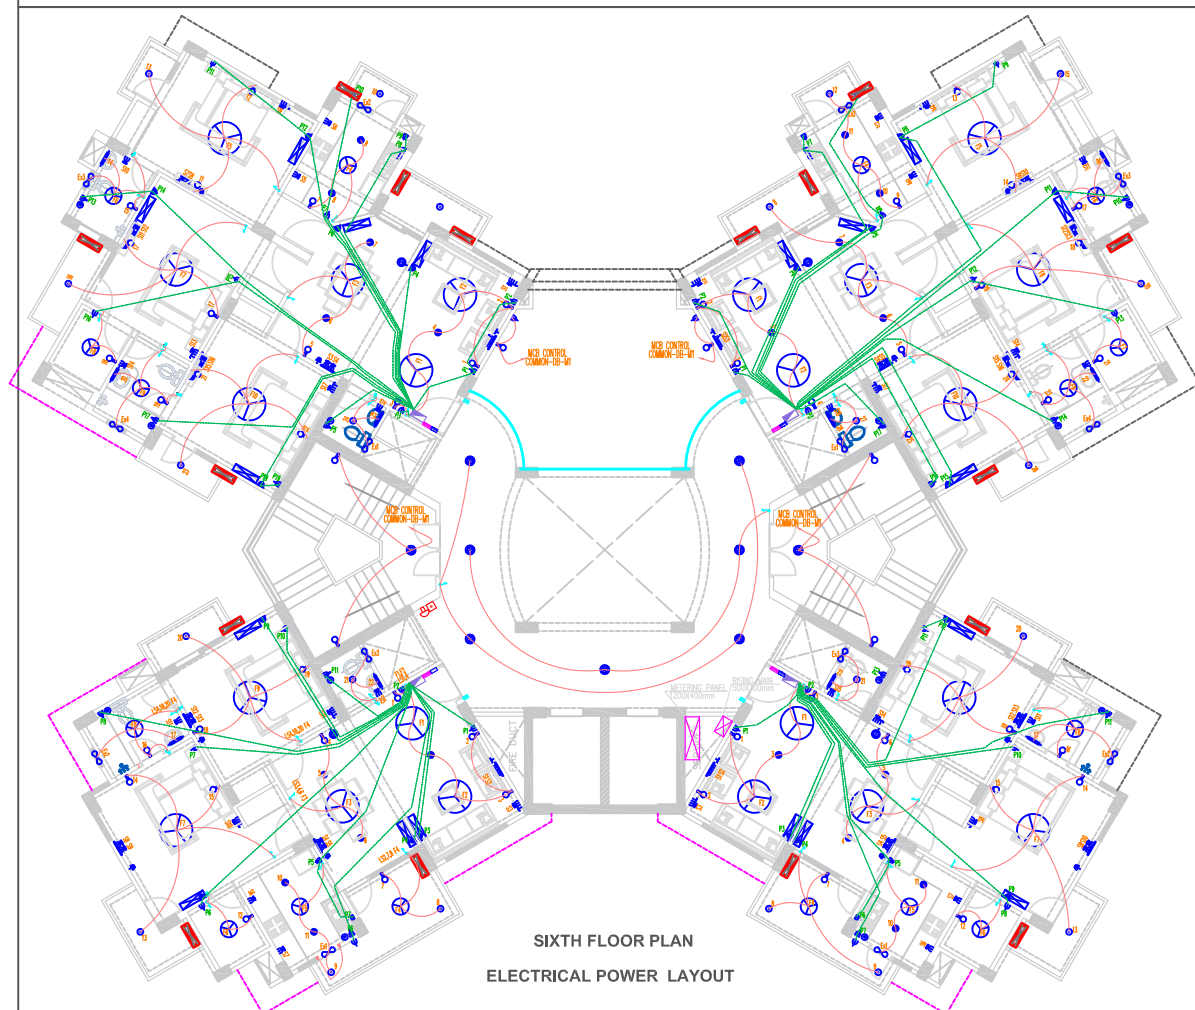

SIXTH FLOOR PLAN
ELECTRICAL POWER LAYOUT

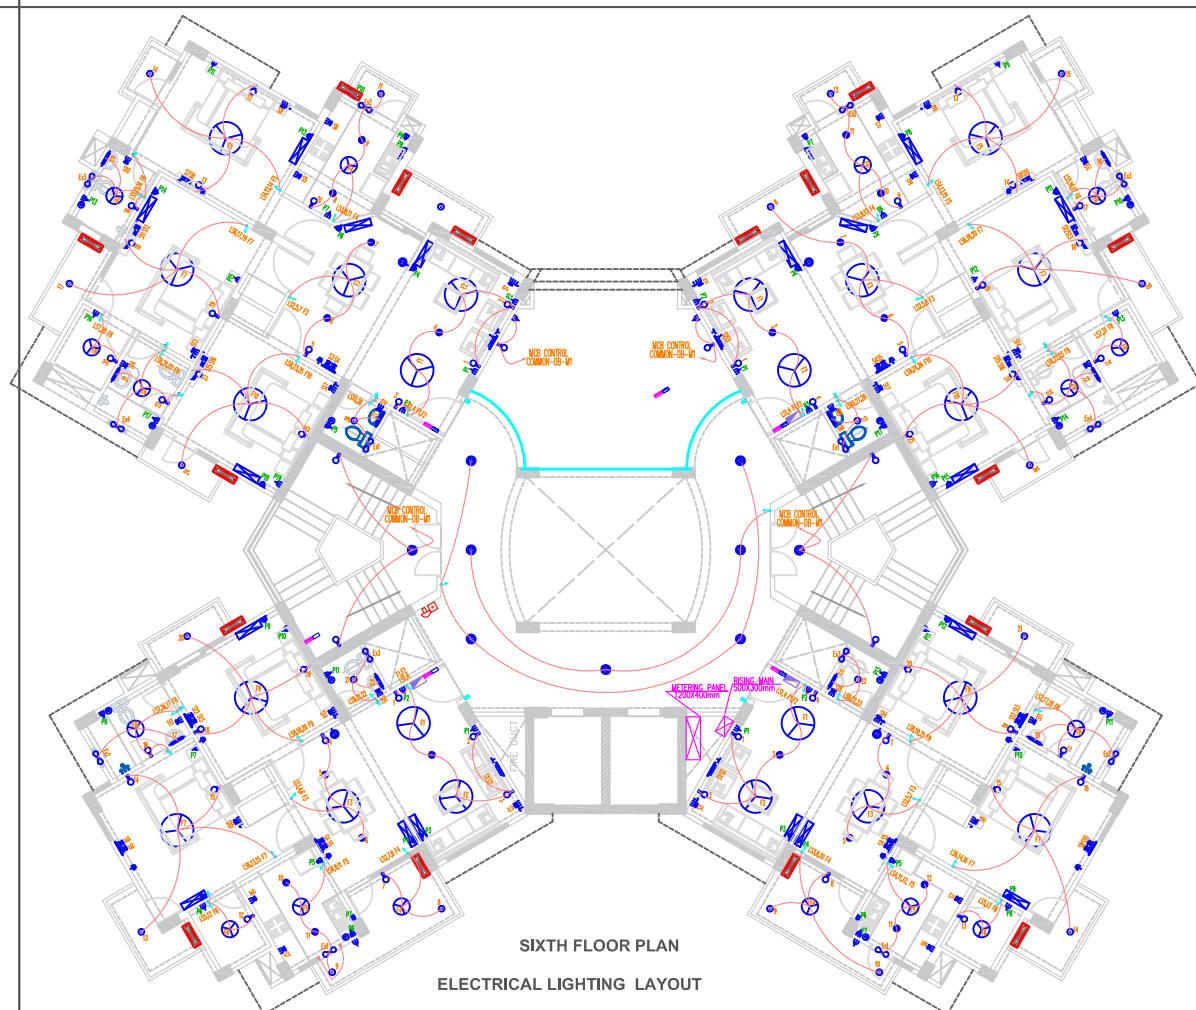

SIXTH FLOOR PLAN
ELECTRICAL LIGHTING LAYOUT

NOTES:-
1. ALL DIMENSIONS ARE IN M.M. AND ONLY
WRITTEN
2. DIMENSIONS SHALL BE FOLLOWED.
3. DRAWING SHALL BE CHECKED BEFORE
EXECUTION.
4. INCONSISTENCY IF ANY SHALL BE
BROUGHT TO THE
NOTICE OF THE FIRM IMMEDIATELY.

■ FOR APPROVAL
■ FOR ESTIMATION/TENDER
■ FOR CONSTRUCTION

No. Revision Date

TITLE:
ELECTRICAL LAYOUT

PROJECT:
T5-SAUBHAGYAM
(GROUND +10 FLOOR)

Developer:
ELDECO HOUSING &
INDUSTRIES (P) LTD.

espaces
Ar.Sanjay Kumar Gupta
108,F. Floor,Corporate Chamber-1,
Vibhuti Khand,Gomti Nagar,
Lucknow-226010
Ph.No.4065958,9415114589
email-espaces_arch@rediffmail.com

Drawn by:
Checked by:
Date: 26/02/2019
Scale: not to scale
Sheet no.: T5/SAUBHAGYAM /ELE/05

SYMBOL	DESCRIPTION	MOU. HEIGHT
	6A ONE WAY SWITCH BOARD	1050mm AFFL
	6A TWO WAY SWITCH BOARD	1050mm AFFL
	1x2BW -FL SURFACE TYPE LIGHT FIXTURE	CEILING
	1x18W PL WALL BRACKET FIXTURE	2100mm AFFL
	1x18W PL CEILING LIGHT FIXTURE	CEILING
	1x18W PL SURFACE LIGHT FIXTURE	CEILING
	1x18W PL MIRROR TYPE WALL MOUNTED FIXTURE	ABOVE MIRROR
	2x11W PL SURFACE TYPE LIGHTING FIXTURE	CEILING
	250mm DIA. EXHAUST FAN	AS PER WIN. DETAIL
	BELL PUSH BUTTON	1050mm AFFL
	CALL BELL	2100mm AFFL
	1x9W BULK HEAD LIGHT FIXTURE OF PHILIPS CAT. NO. FXG-101	ABOVE MID DOOR/ ABOVE LIFT
	6A SWITCH SOCKET OUTLET	300mm AFFL/150mm ABOVE CONTOUR
	16A SWITCH SOCKET OUTLET	300mm AFFL/150mm ABOVE CONTOUR
	16A SWITCH SOCKET OUTLET	1800mm AFFL
	1x18W Reverse light(concealed)	Embedded-upwards Facade lighting

SYMBOL	DESCRIPTION	MOU. HEIGHT
	20A SWITCH SOCKET OUTLET FOR A.C.	300mm AFFL/150mm ABOVE CONTOUR
	1.No-T.V. OUTLET	300mm AFFL/150mm ABOVE CONTOUR
	TELEPHONE OUTLET	300mm AFFL/150mm ABOVE CONTOUR
	HOOTER	+2100mm AFFL.
	MANUAL CALL POINT	1050mm AFFL.
	CEILING FAN 900mm DIA.	CEILING
	CEILING FAN 1200mm DIA.	CEILING
	CEILING FAN 1400mm DIA.	CEILING
	DISTRIBUTION BOARD	1500mm AFFL.
	32mm & 40mm DIA. SUB-MAIN CONDUIT	IN SLAB/ WALL
	LIGHTING CONDUIT-(25mm-II) & (20mm-I)	IN SLAB/ WALL
	POWER CONDUIT (25mm-II) & (20mm-I)	IN SLAB/ WALL
	TELEPHONE CONDUIT-(20mm-I)	IN SLAB/ WALL
	25mm DIA. TV CONDUIT	IN SLAB/ WALL
	20mm DIA. FIRE ALARM CONDUIT	IN SLAB/ WALL
	TV JUNCTION BOX	1500mm AFFL.
	TELEPHONE JUNCTION BOX	1500mm AFFL.