


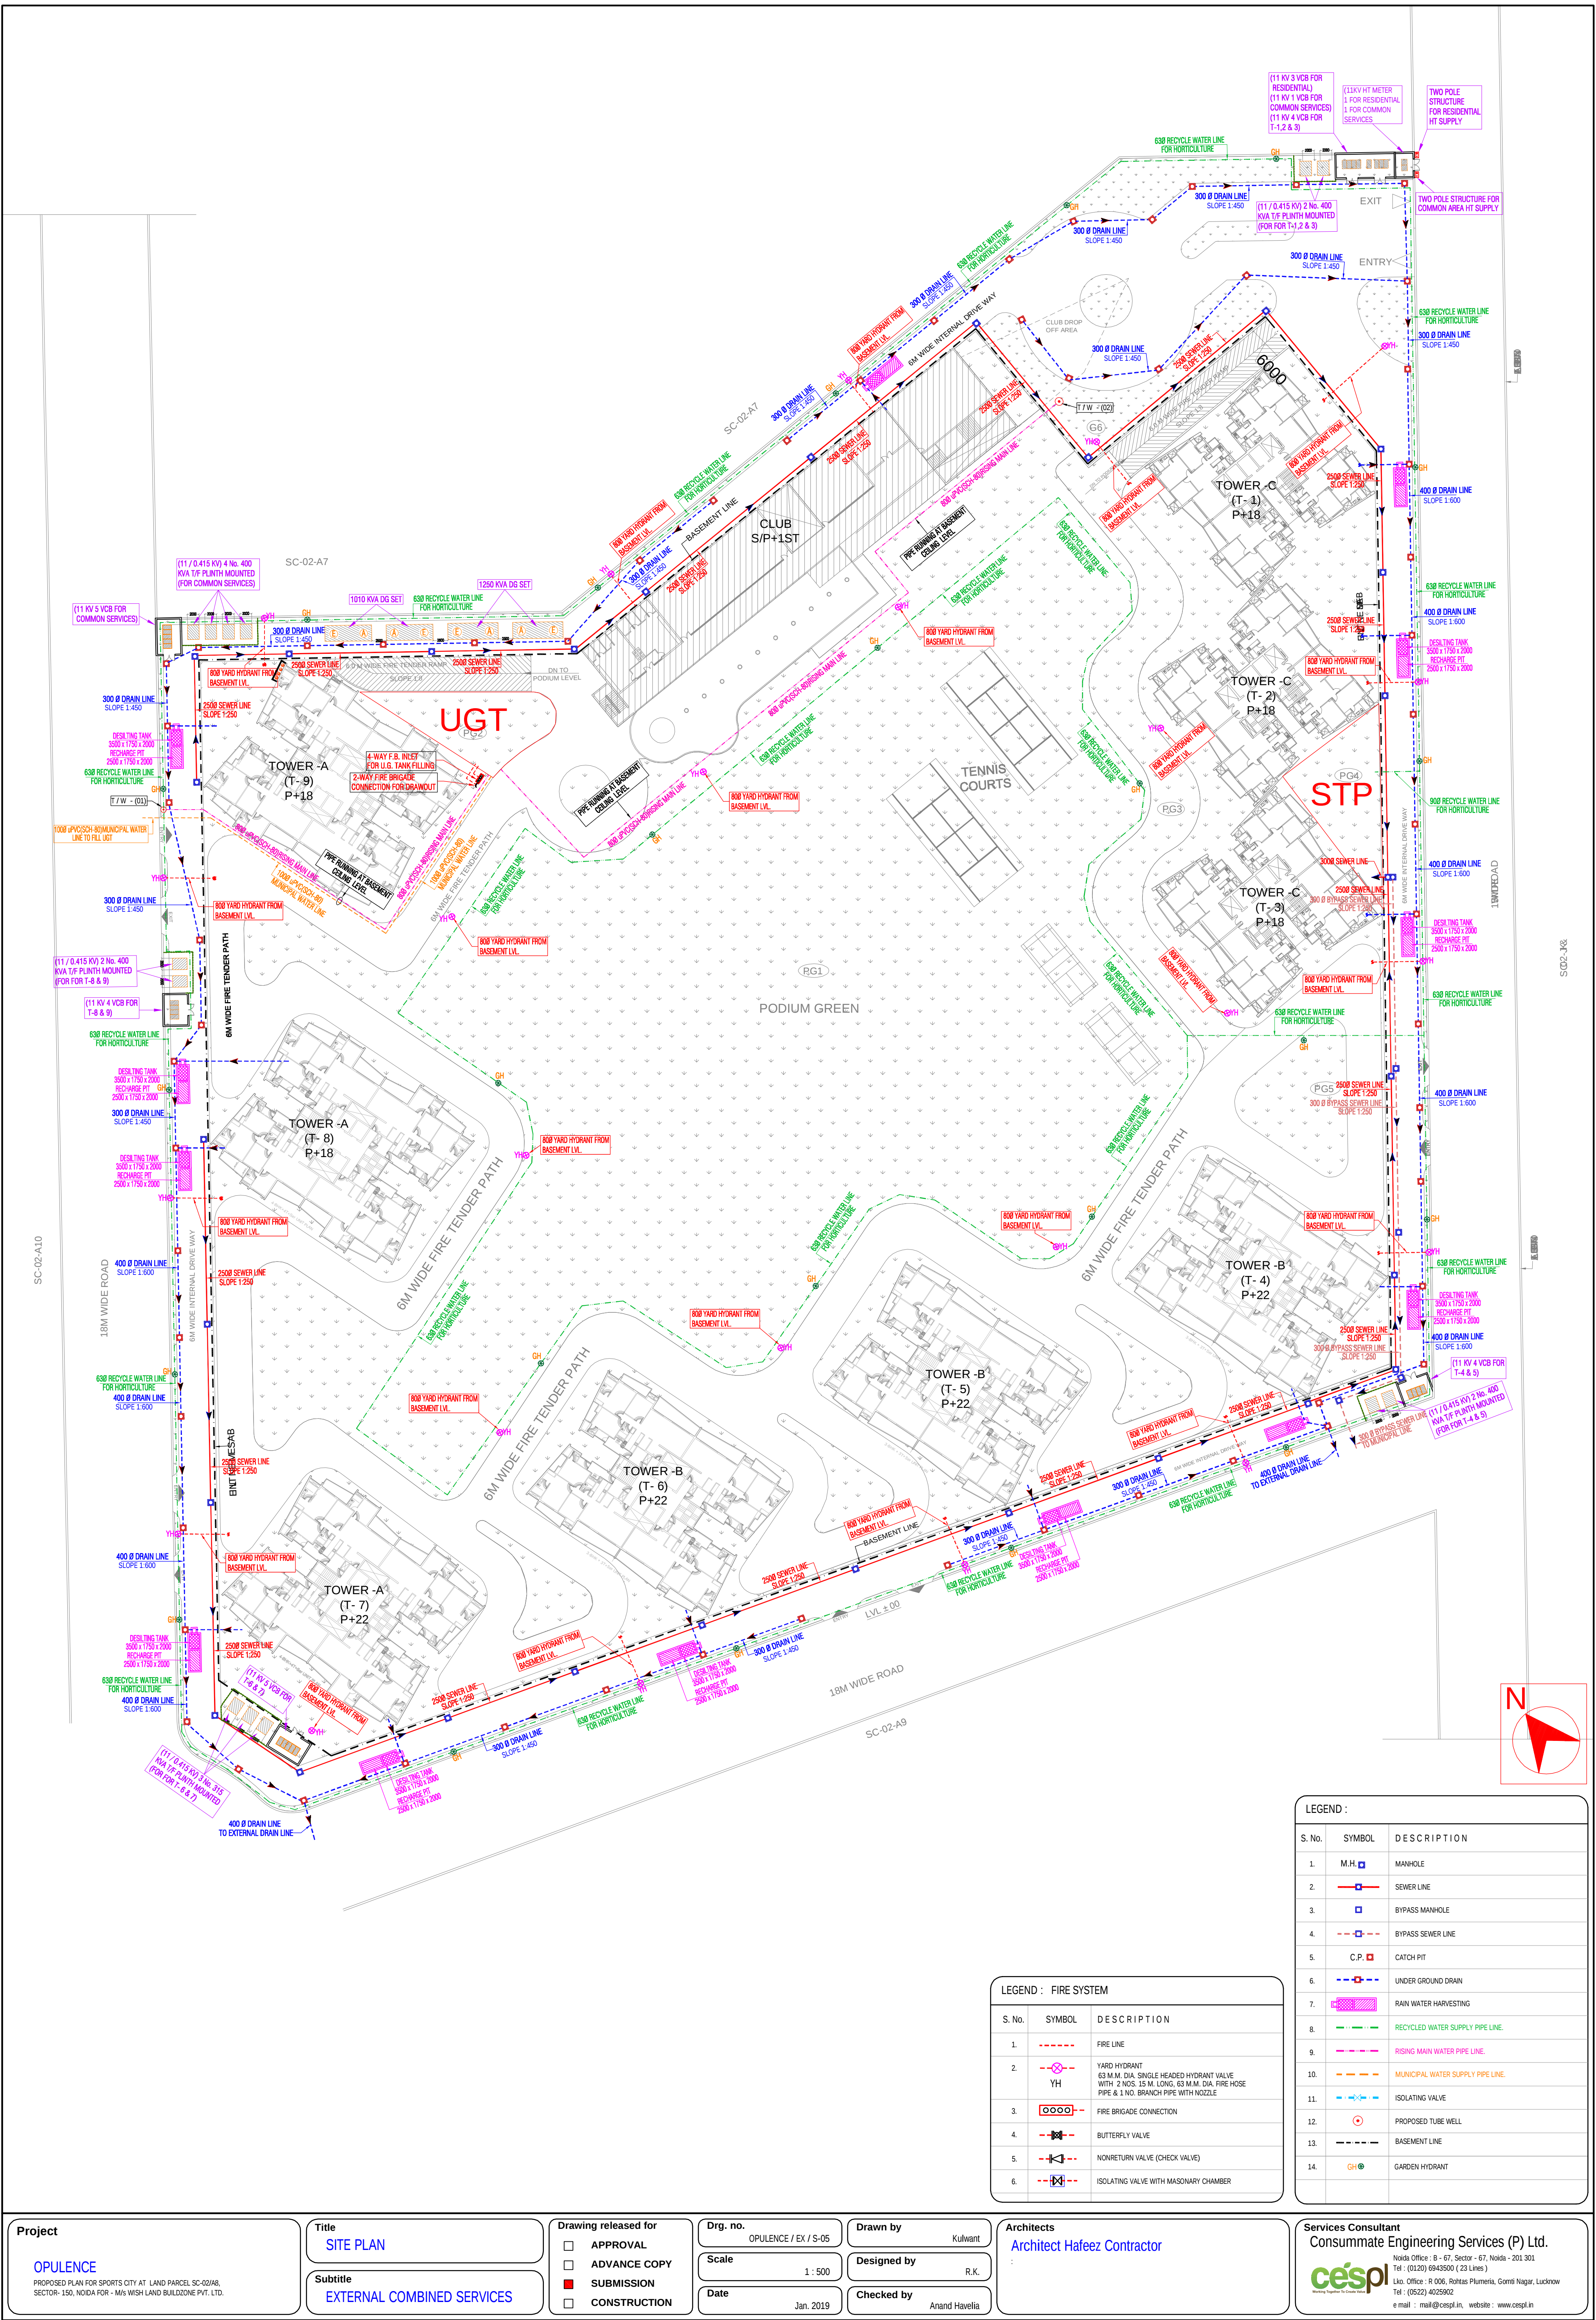

LEGEND : FIRE SYSTEM		
S. No.	SYMBOL	DESCRIPTION
1.	---	FIRE LINE
2.	YH	YARD HYDRANT 63 M.M. DIA. SINGLE HEADED HYDRANT VALVE WITH 2 NOS. 15 M. LONG, 63 M.M. DIA. FIRE HOSE PIPE & 1 NO. BRANCH PIPE WITH NOZZLE
3.	---	FIRE BRIGADE CONNECTION
4.	---	BUTTERFLY VALVE
5.	---	NONRETURN VALVE (CHECK VALVE)
6.	---	ISOLATING VALVE WITH MASONRY CHAMBER

LEGEND :		
S. No.	SYMBOL	DESCRIPTION
1.	M.H.	MANHOLE
2.	---	SEWER LINE
3.	---	BYPASS MANHOLE
4.	---	BYPASS SEWER LINE
5.	C.P.	CATCH PIT
6.	---	UNDER GROUND DRAIN
7.	---	RAIN WATER HARVESTING
8.	---	RECYCLED WATER SUPPLY PIPE LINE
9.	---	RIISING MAIN WATER PIPE LINE
10.	---	MUNICIPAL WATER SUPPLY PIPE LINE
11.	---	ISOLATING VALVE
12.	---	PROPOSED TUBE WELL
13.	---	BASEMENT LINE
14.	GH	GARDEN HYDRANT

Project

OPULENCE

PROPOSED PLAN FOR SPORTS CITY AT LAND PARCEL SC-02/A8, SECTOR-150, NOIDA FOR - M/s WISH LAND BUILDZONE PVT. LTD.

Title

SITE PLAN

Subtitle

EXTERNAL COMBINED SERVICES

Drawing released for

☐ APPROVAL
☐ ADVANCE COPY
☒ SUBMISSION
☐ CONSTRUCTION

Drg. no.

OPULENCE / EX / S-05

Scale

1 : 500

Date

Jan. 2019

Drawn by

Kulwant

Designed by

R.K.

Checked by

Anand Havella

Architects

Architect Hafeez Contractor

Services Consultant

Consummate Engineering Services (P) Ltd.

cespi

Noida Office : B - 67, Sector - 67, Noida - 201 301
Tel : (0120) 6943500 (23 Lines)
Lko. Office : R 006, Rohas Plumeria, Gomti Nagar, Lucknow
Tel : (0522) 4025902
e mail : mail@cespi.in, website : www.cespi.in