


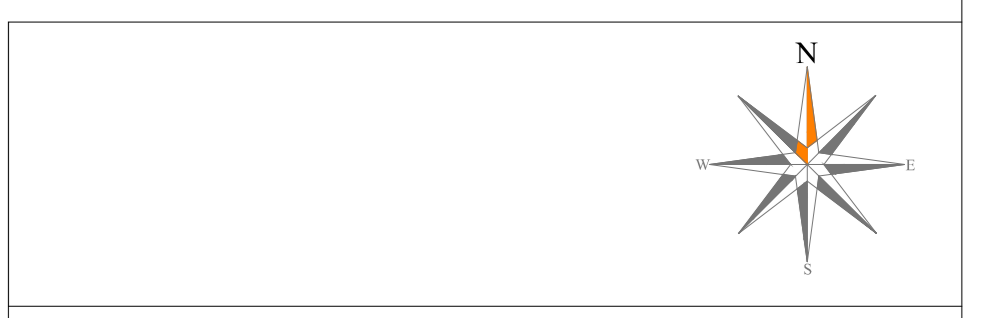

LEGEND	
	MUNICIPAL WATER SUPPLY LINE
	DOMESTIC WATER SUPPLY LINE
	FLUSHING WATER SUPPLY LINE
	GARDEN HYDRANT



**SUBMISSION DRAWINGS**

PROJECT:  
Proposed Group housing colony scheme over an area measuring 3.09 acres at Gomati Nagar Lucknow U.P. by Inception Buildtech Private Limited.

DRAWING TITLE:  
**WATER SUPPLY LAYOUT**

SITE PLAN

OWNER'S SIGN      ARCHITECT'S SIGN

PLUMBING & FIRE CONSULTANT:-

**CPA** C P Vidya and Associates  
312A, WINDLE PARK, SOUTH GATE, SECTOR-49 NEAR PARK HOSPITAL (GURGAON)  
Gurgaon-122018 (INDIA)  
Email:- cpavidyaassociates@gmail.com

**ACPL** ISO 9001:2015  
Architecture Management Planning

ACPL Design Ltd E-24, South Extension - II, New Delhi 110048, India  
www.acpl.com      C:\acpl\acpl@acpl.com

SCALE 1:275	DEALT BY	DATE AUG. 2023
DESIGN BY	CHECKED BY	DRG. No. PLUSTWS-04