


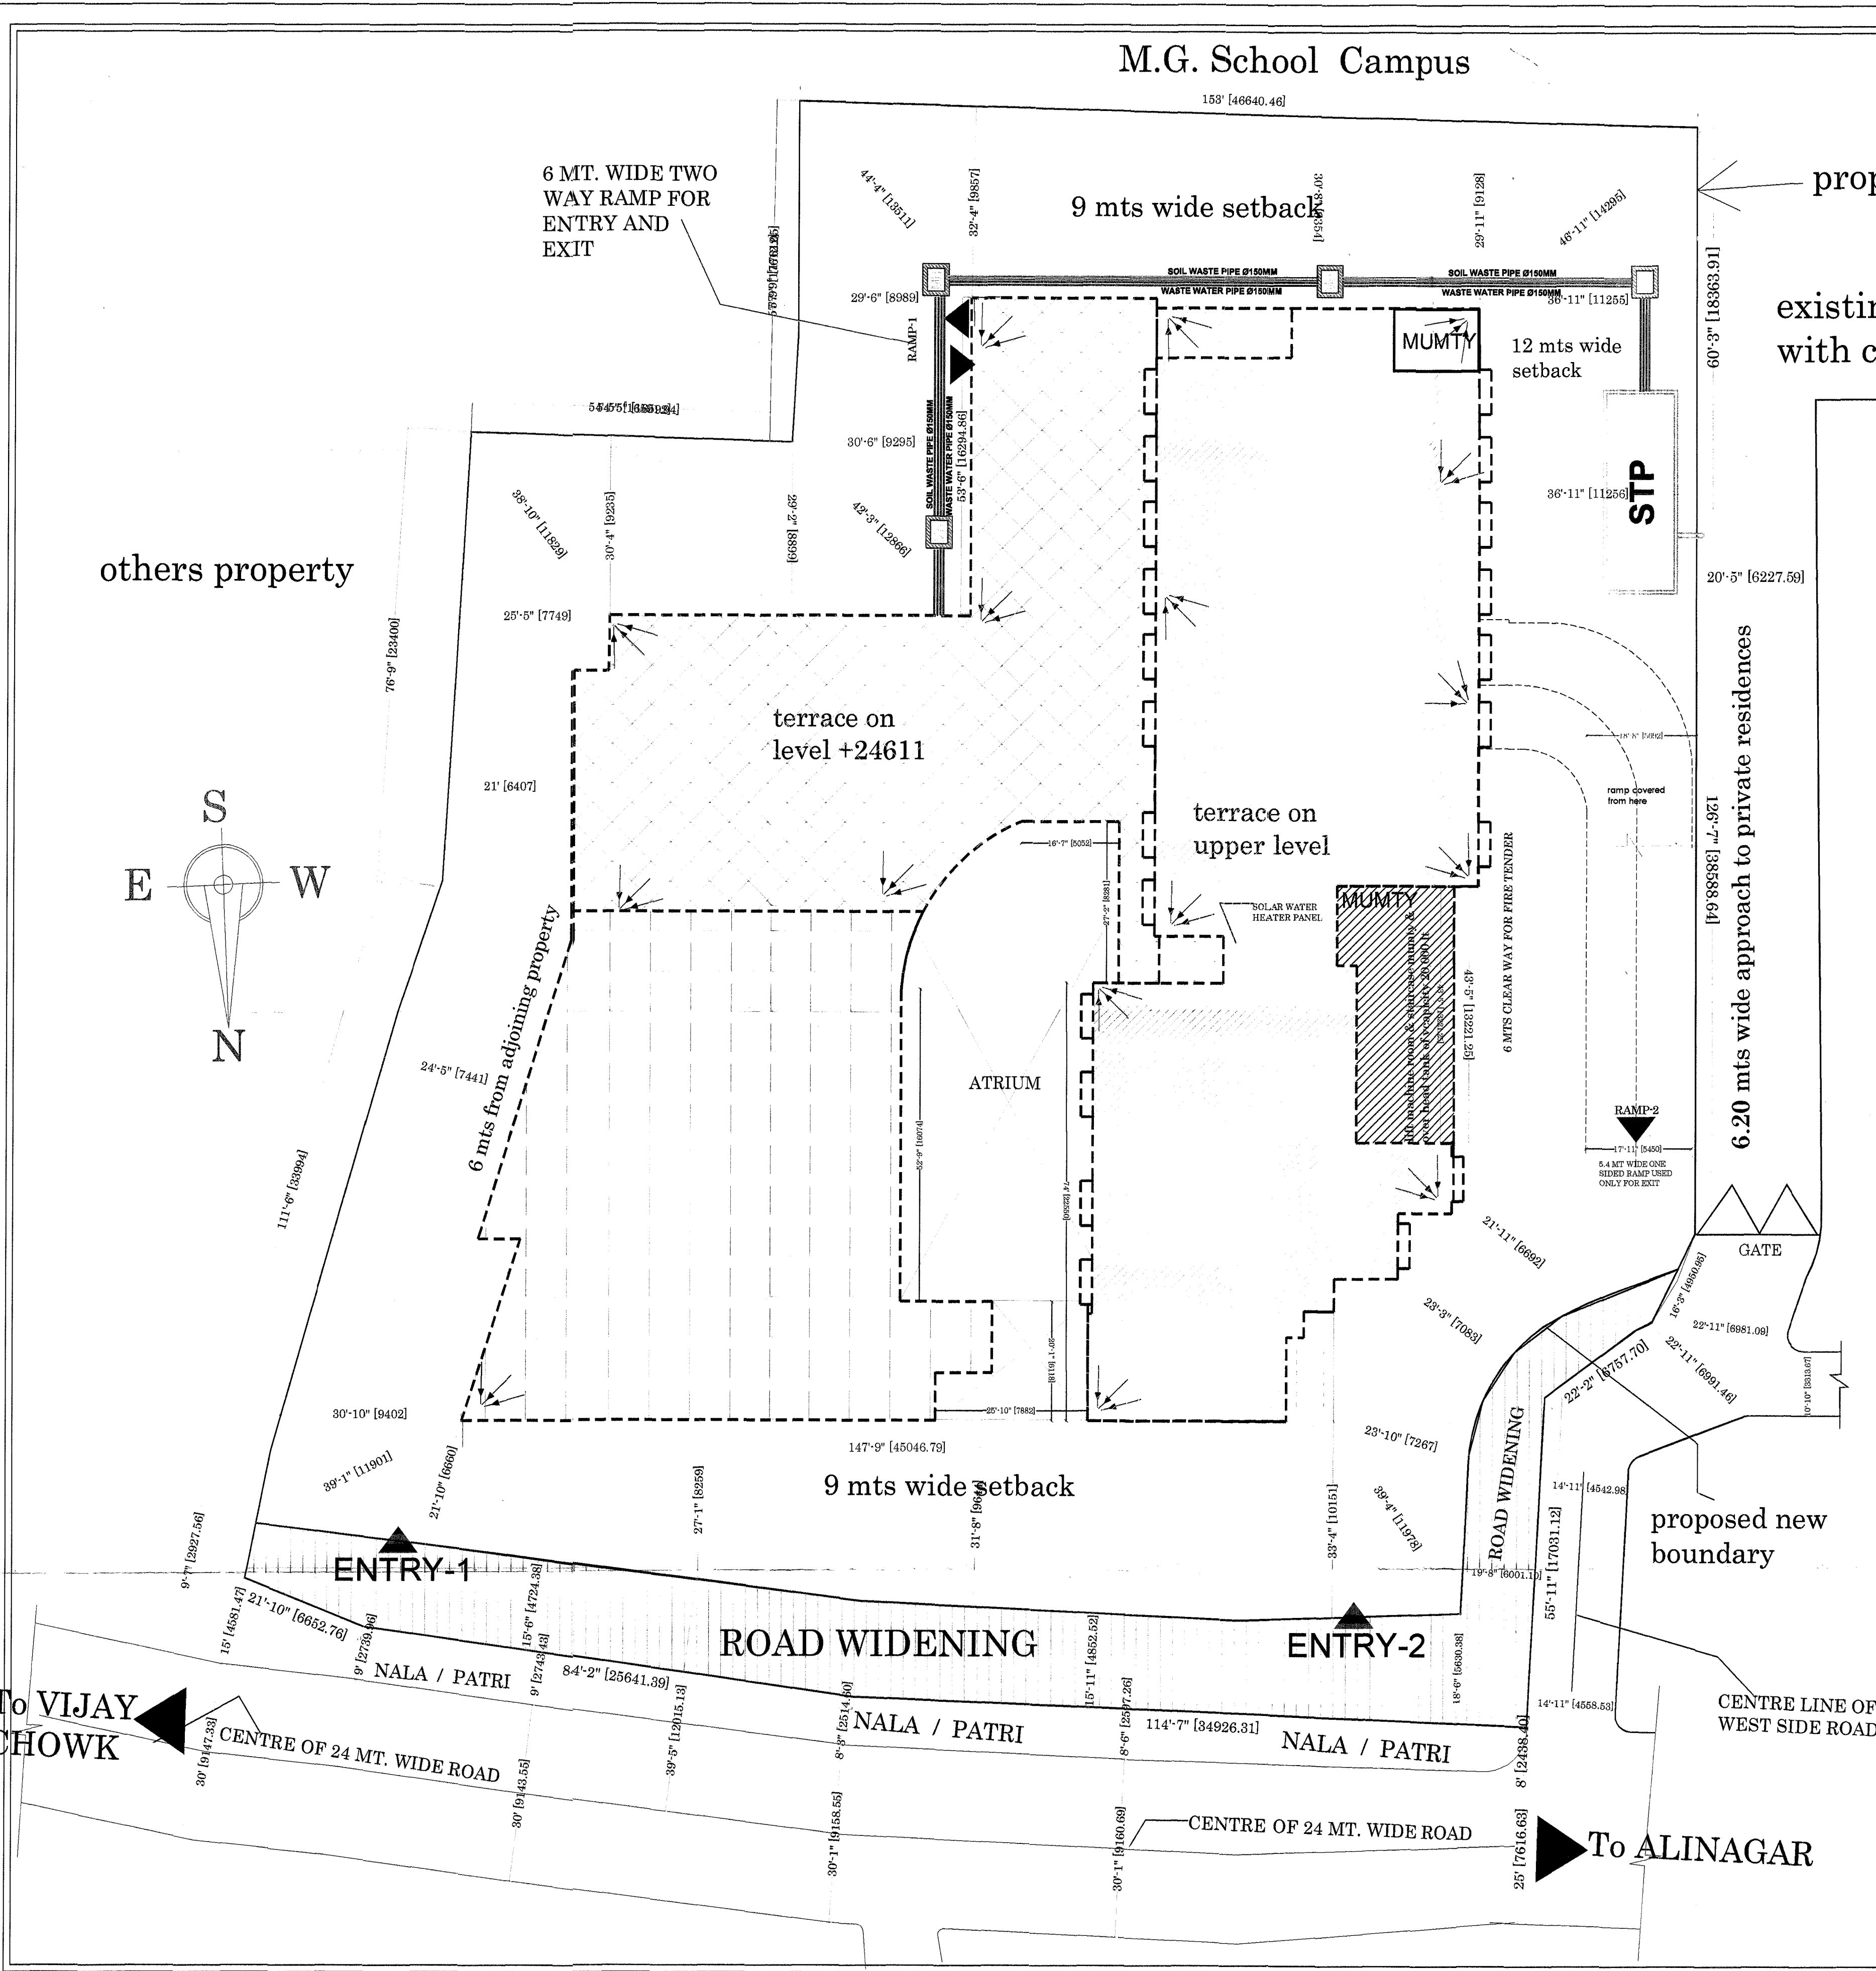

LEGEND :

	MANHOLE
	SEWAGE TREATMENT PLANT
	WASTE WATER PIPE
	SOIL WASTE PIPE
	DRAIN PIPE

Remarks

THIS DRAWING IS THE PROPERTY OF A-CORE ARCHITECTURAL SERVICES PVT. LTD. AND ISSUED FOR THE SPECIFIC PROJECT MENTIONED THEREIN. THIS IS NOT TO BE COPIED OR USED FOR OTHER PROJECTS UNLESS EXPRESSLY PERMITTED BY THE ARCHITECT.

PROJECT

PROPOSED MULTIPLEX AND HOTEL AT EXISTING MENKA AND INDERLOK CINEMA CAMPUS, NEAR VIJAY CHAUK, GORAKHPUR

DEVELOPER/OWNER

SMT SAVITRI DAS
W/O LATE SHRI PREM MOHAN DAS AND
SHREE HARI MOHAN DAS, AND
SHREE VED MOHAN DAS, AND
SHRI SOMENDRA MOHAN DAS
S/O LATE SHRI PREM MOHAN DAS AND
SHRI SHOBHIT MOHAN DAS
S/O LATE SHRI PREM MOHAN DAS

Drawing Title

SITE PLAN

sheet number 01 B
REVISED

Drg. No.

Scale

Date 19-11-2014

Drawn By

Issued To

North

↓

ACORE ARCHITECTURAL SERVICES PVT. LTD.

ARCHITECT:ASHISH SRIVASTAVA

BRANCH OFFICE : 935/D MATRI ANCHAL NEAR GORAKHNATH RAILWAY CROSSING GORAKHPUR

TEL: OFF:3294813,RES:2255290, MOBILE:9415321836.

DOMESTIC DISCHARGE PLAN